



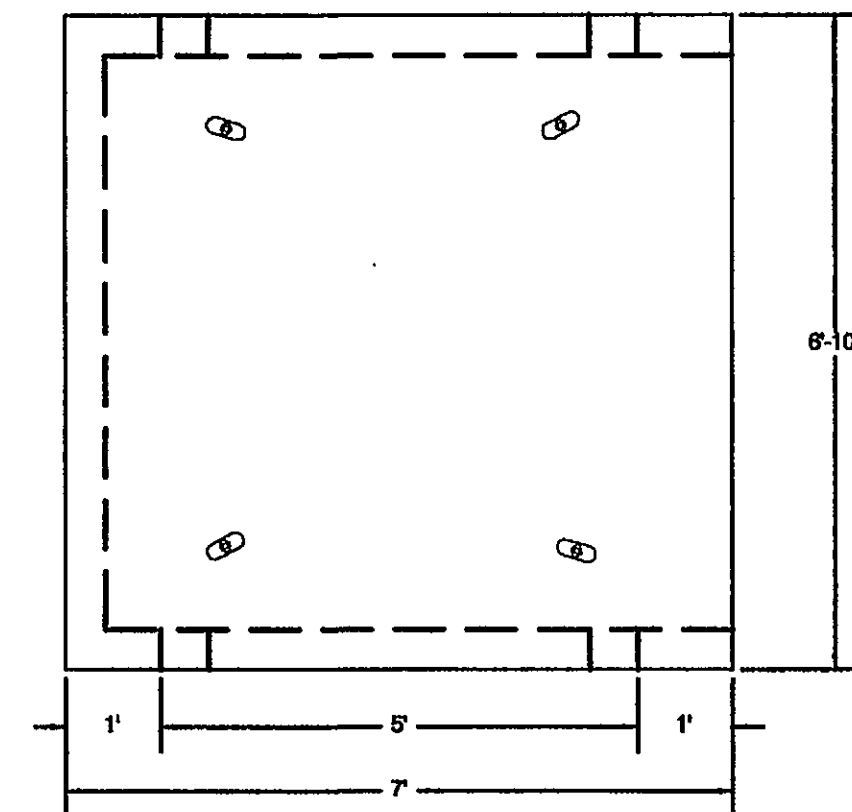


PLAN VIEW

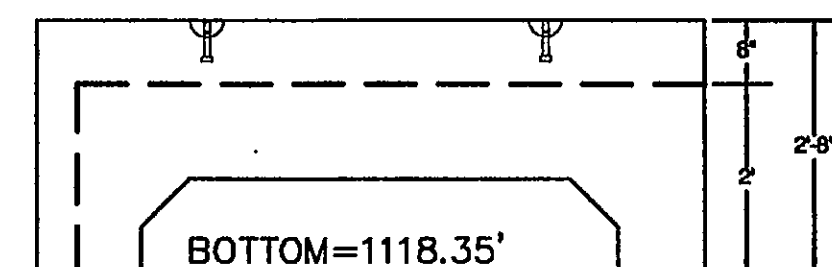

ELEVATION VIEW

TYPE II UNITS		
UNIT HEIGHT (in.)	CUBIC STORAGE (C.F.)	WEIGHT (lbs.)
24	82	6810

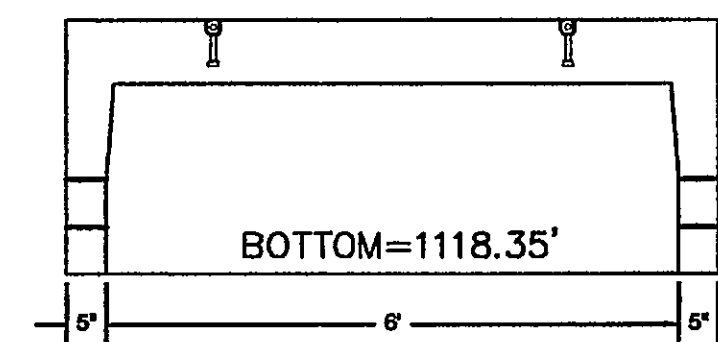

SIDE VIEW

STORMTRAP
PRECAST CONCRETE STORMWATER TRAPS

P.O. BOX 782
MORRIS, IL 60450
1-87-STORMTRAP

ENGINEER INFORMATION:

ACS DESIGN
2203 PETERS CREEK RD
ROANOKE, VA 24017
Phone: 540-562-2345
Fax: 540-562-2344

PROJECT INFORMATION:

ROANOKE PROJECT
ROANOKE, VA
AS-1647-VA-06

CURRENT ISSUE DATE:

02/23/06

APPROVED BY:

ISSUED FOR:

PRELIMINARY

REV.: DATE: DESC. BY:

02/23/06 ISSUED FOR PRELIMINARY AS

SCALE:


NTS

SHEET TITLE:


STANDARD
2'-0" SINGLETRAP
TYPE II

SHEET NUMBER:

05

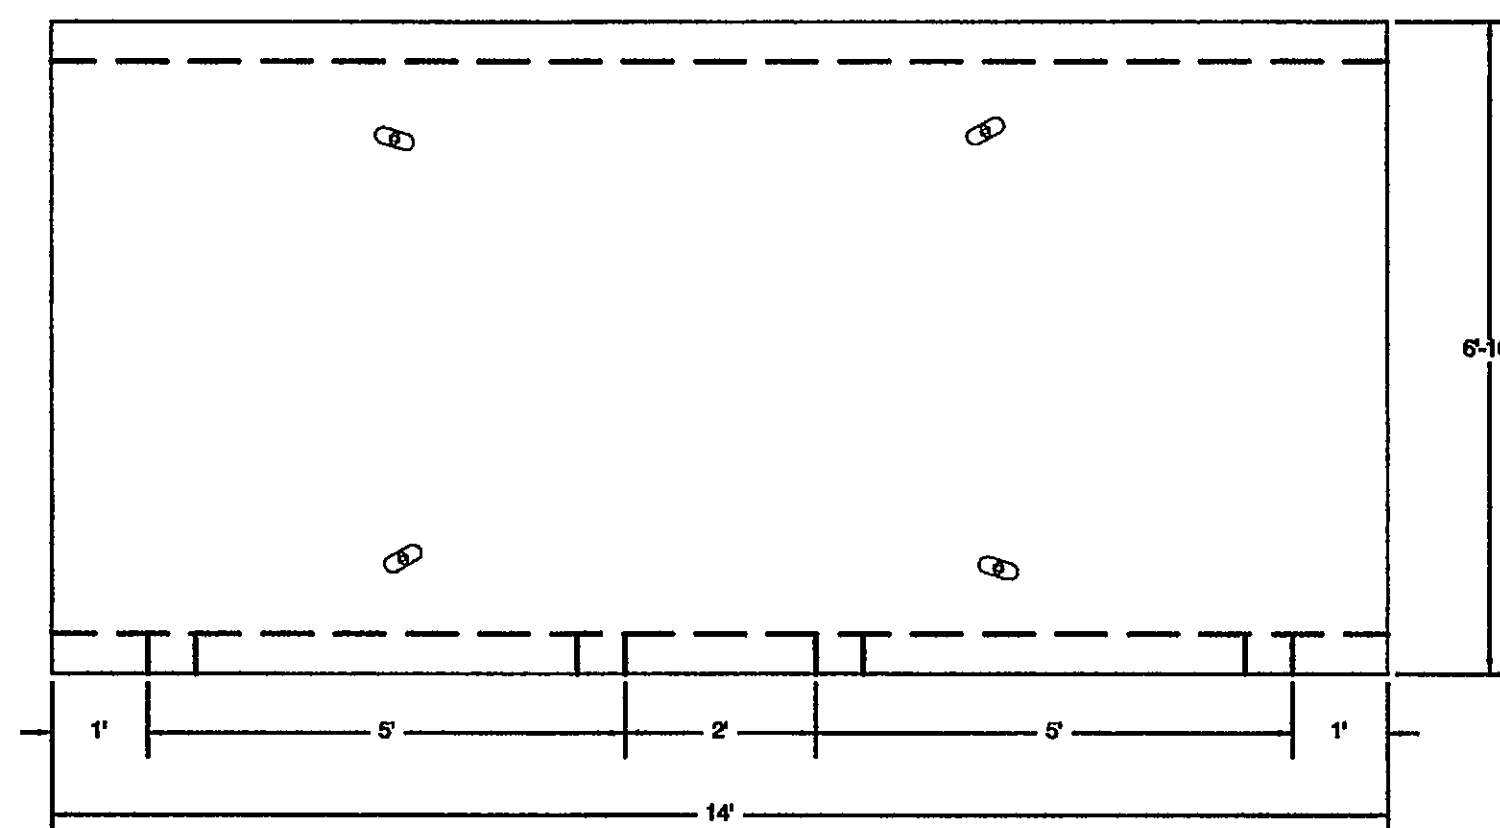


PLAN VIEW

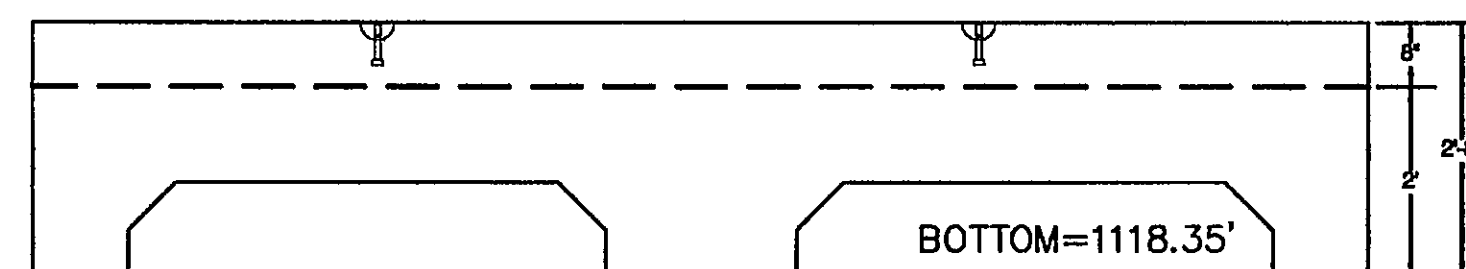

ELEVATION VIEW

TYPE III UNITS		
UNIT HEIGHT (in.)	CUBIC STORAGE (C.F.)	WEIGHT (lbs.)
24	170.5	12650

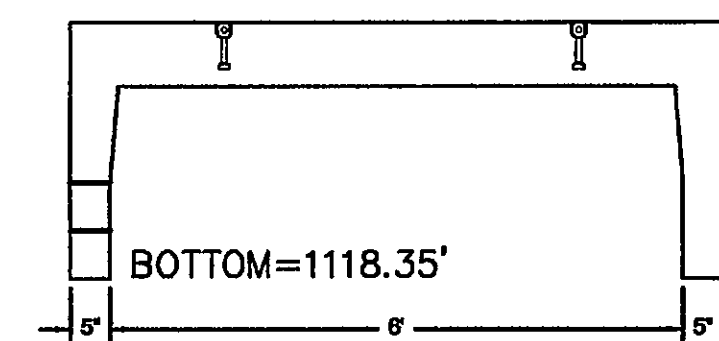

SIDE VIEW

STORMTRAP
PRECAST CONCRETE STORMWATER TRAPS

P.O. BOX 782
MORRIS, IL 60450
1-87-STORMTRAP

ENGINEER INFORMATION:

ACS DESIGN
2203 PETERS CREEK RD
ROANOKE, VA 24017
Phone: 540-562-2345
Fax: 540-562-2344

PROJECT INFORMATION:

ROANOKE PROJECT
ROANOKE, VA
AS-1647-VA-06

CURRENT ISSUE DATE:

02/23/06

APPROVED BY:

ISSUED FOR:

PRELIMINARY

REV.: DATE: DESC. BY:

02/23/06 ISSUED FOR PRELIMINARY AS

SCALE:


NTS

SHEET TITLE:

STANDARD
2'-0" SINGLETRAP
TYPE III

SHEET NUMBER:

06

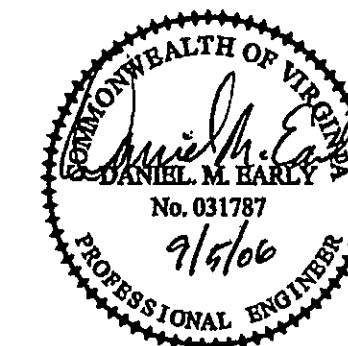

ACS DESIGN

Engineering-Planning-Surveying
Construction Management

2203 Peters Creek Road, NW
Roanoke, Virginia 24017
Phone: 540 562 2345
Fax: 540 562 2344
Email: info@acsdesignllc.com
www.acsdesignllc.com

VISTAR EYE CENTER
SITE PLAN
ROANOKE COUNTY, VIRGINIA

DRAWN BY: SFE

DESIGNED BY: SFE

CHECKED BY: SFE

DATE: 03/28/2006

SCALE: NONE

REVISIONS

DATE	REVISION	COMMENT

SHEET No.

C1.12

UNDERGROUND STORM WATER
BASIN NOTES AND DETAILS

JOB No. 06005