
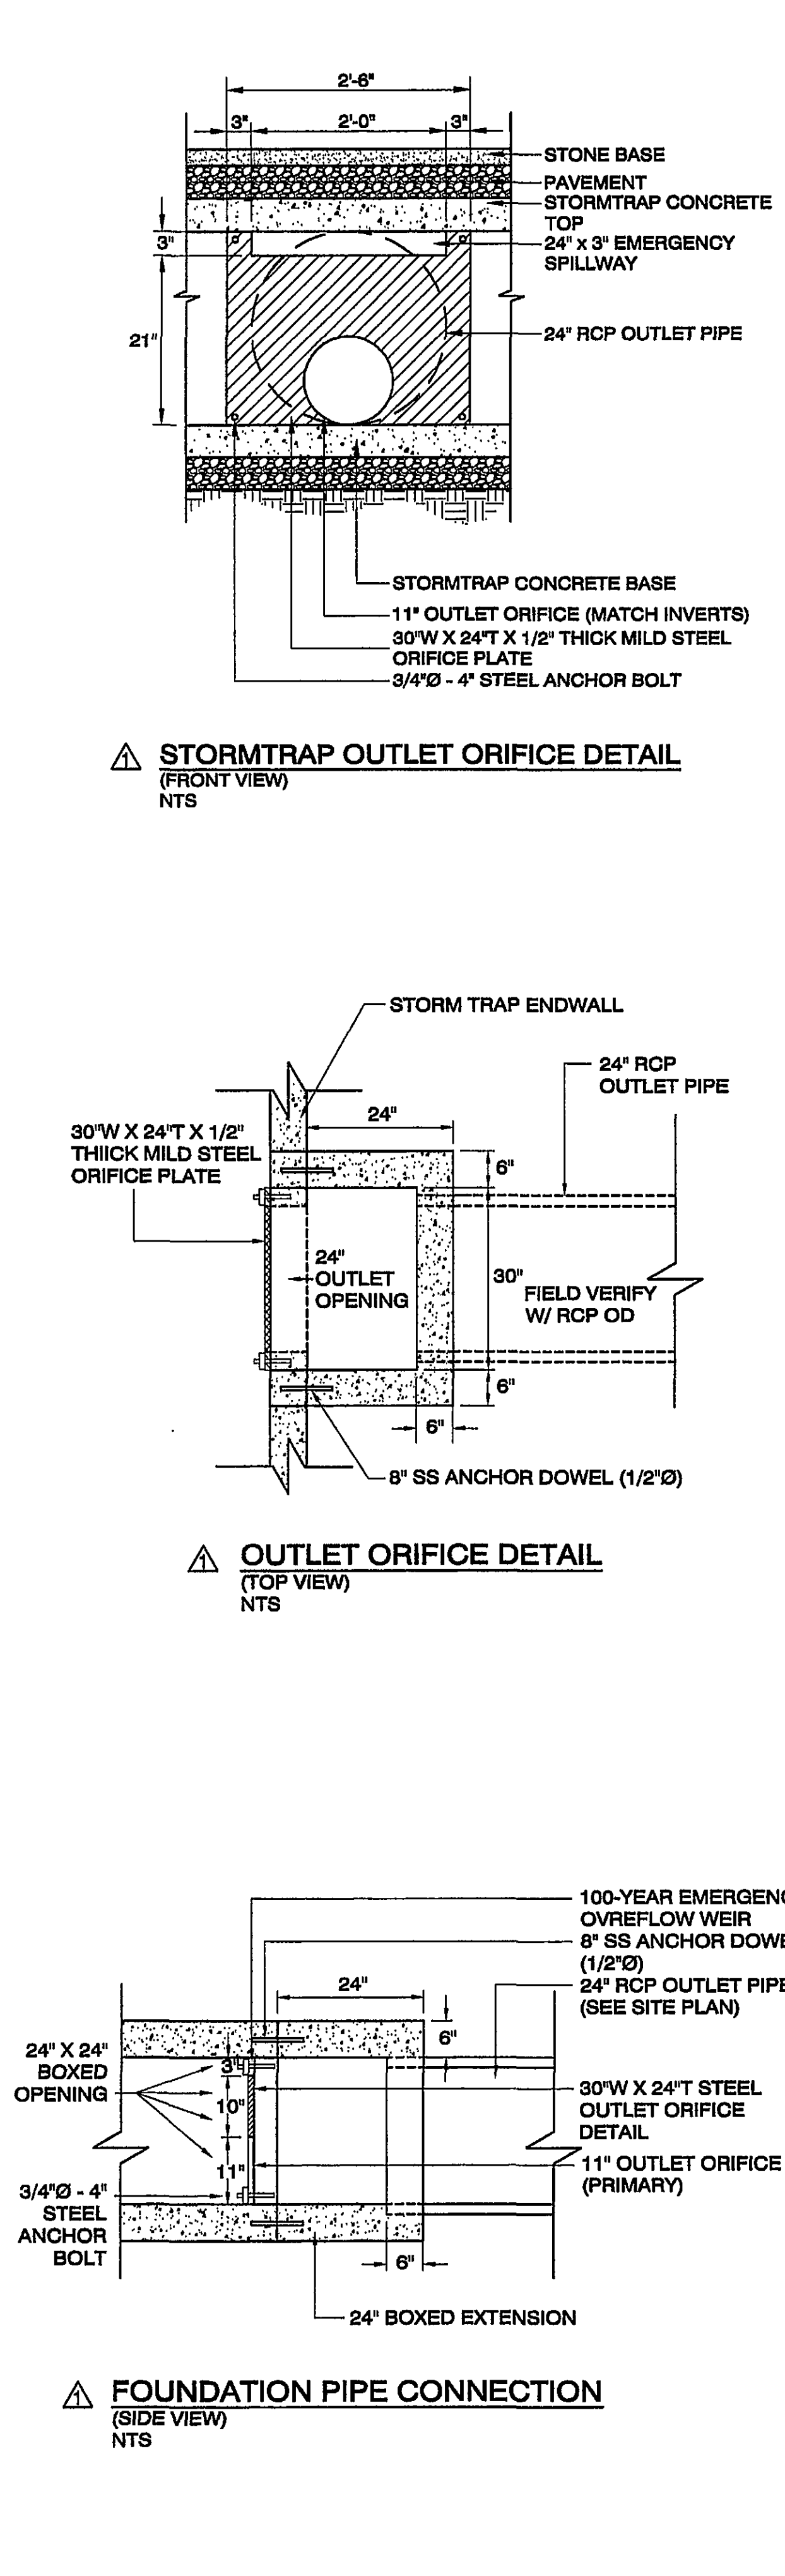


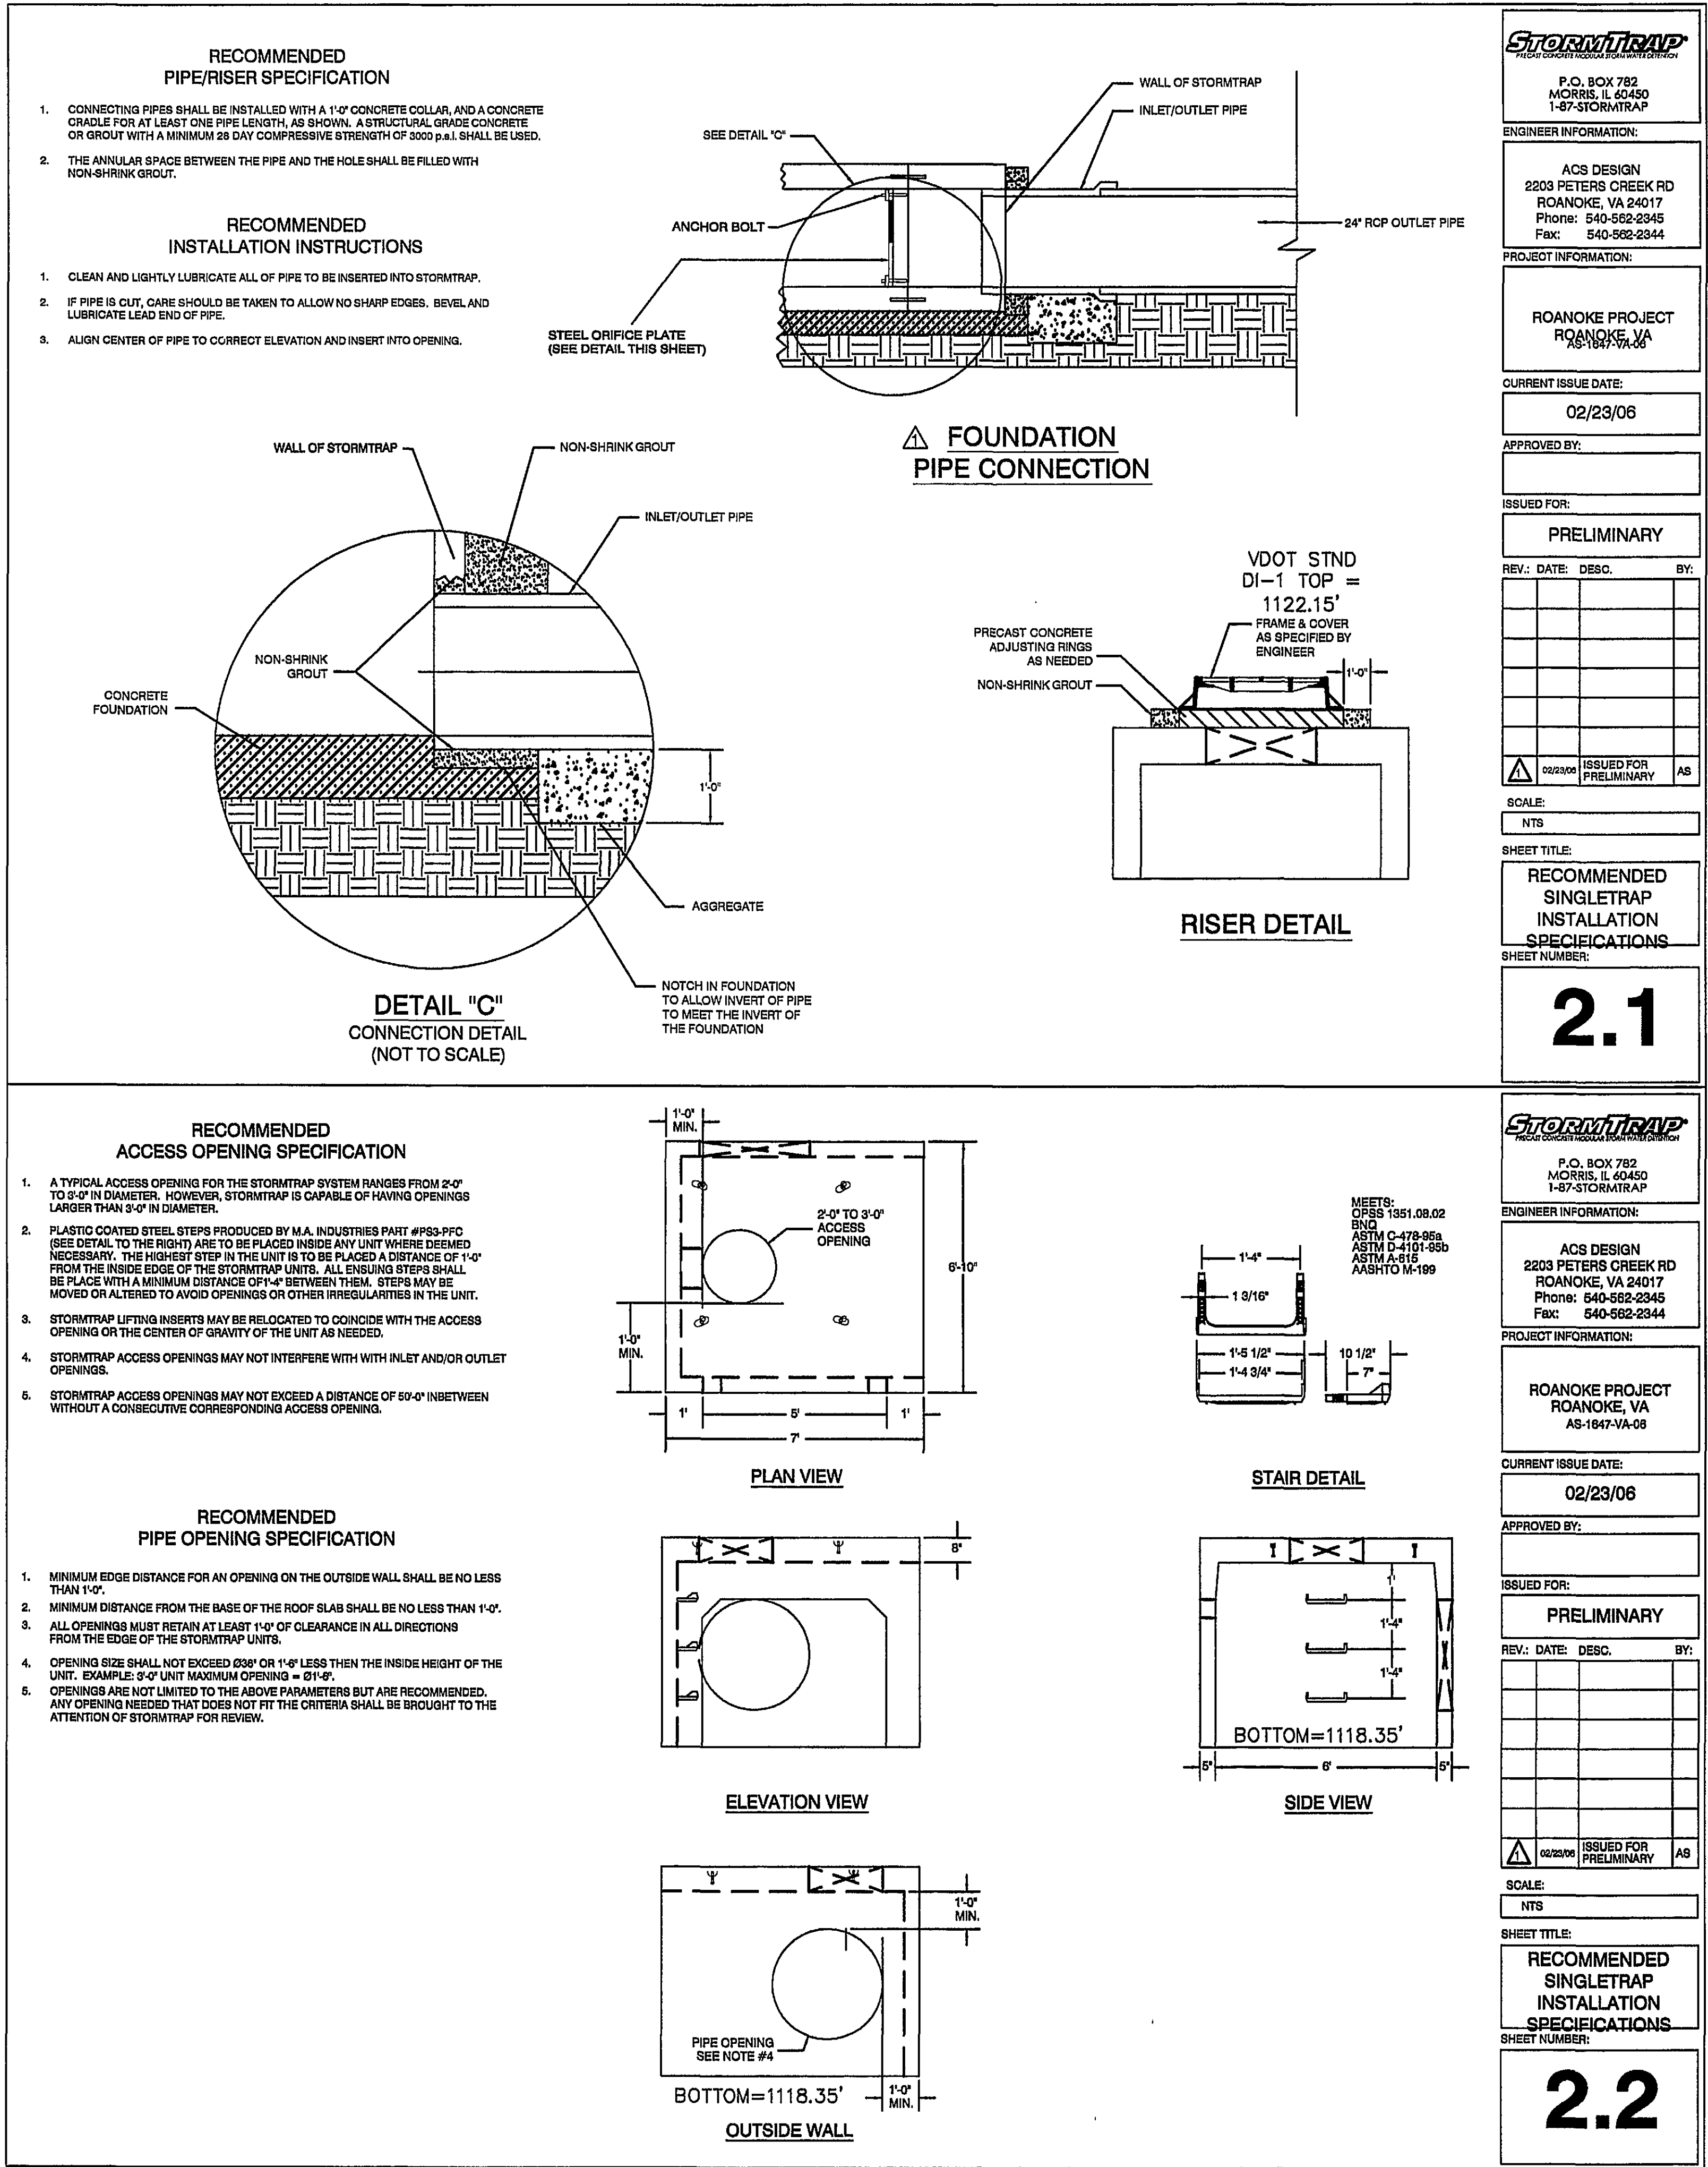

PROFESSIONAL ENGINEER
DANIEL M. EARLY
No. 031787
9/21/06

ACS DESIGN
Engineering • Planning • Surveying
Construction Management

2203 Peters Creek Road, NW
Roanoke, Virginia 24017
Phone: 540 562 2345
Fax: 540 562 2344
Email: info@acsdesignllc.com
www.acsdesignllc.com

VISTAR EYE CENTER
SITE PLAN
ROANOKE COUNTY, VIRGINIA

DRAWN BY: SFE
DESIGNED BY: SFE
CHECKED BY: SFE
DATE: 03/28/2006
SCALE: NONE

REVISIONS

REVISION	DATE	COMMENT
1	07/05	PER ROANOKE COUNTY

SHEET No. **C1.14**
UNDERGROUND STORM WATER
BASIN NOTES AND DETAILS
JOB No. 06005