

Commission No.: 1823	Checked By: WTA	Project Coordinator: WTA
Drawn By: JPR	Date: 9/28/01	

Mattm & Craig
CONSULTING ENGINEERS • SURVEYORS
701 FIRST STREET
ROANOKE, VIRGINIA 24012
(540) 345-9342
FAX (540) 345-7691

WAL-MART STORE #3243-00
GRADING & UTILITY PLAN
CRUMPACKER DRIVE (RTE. 781)
ORGANOKE COUNTY, VIRGINIA


Vertical Scale:
1"=10'

Horizontal Scale:
1"=30'

Issue Date:
9/28/01


Sheet No.:

C-42

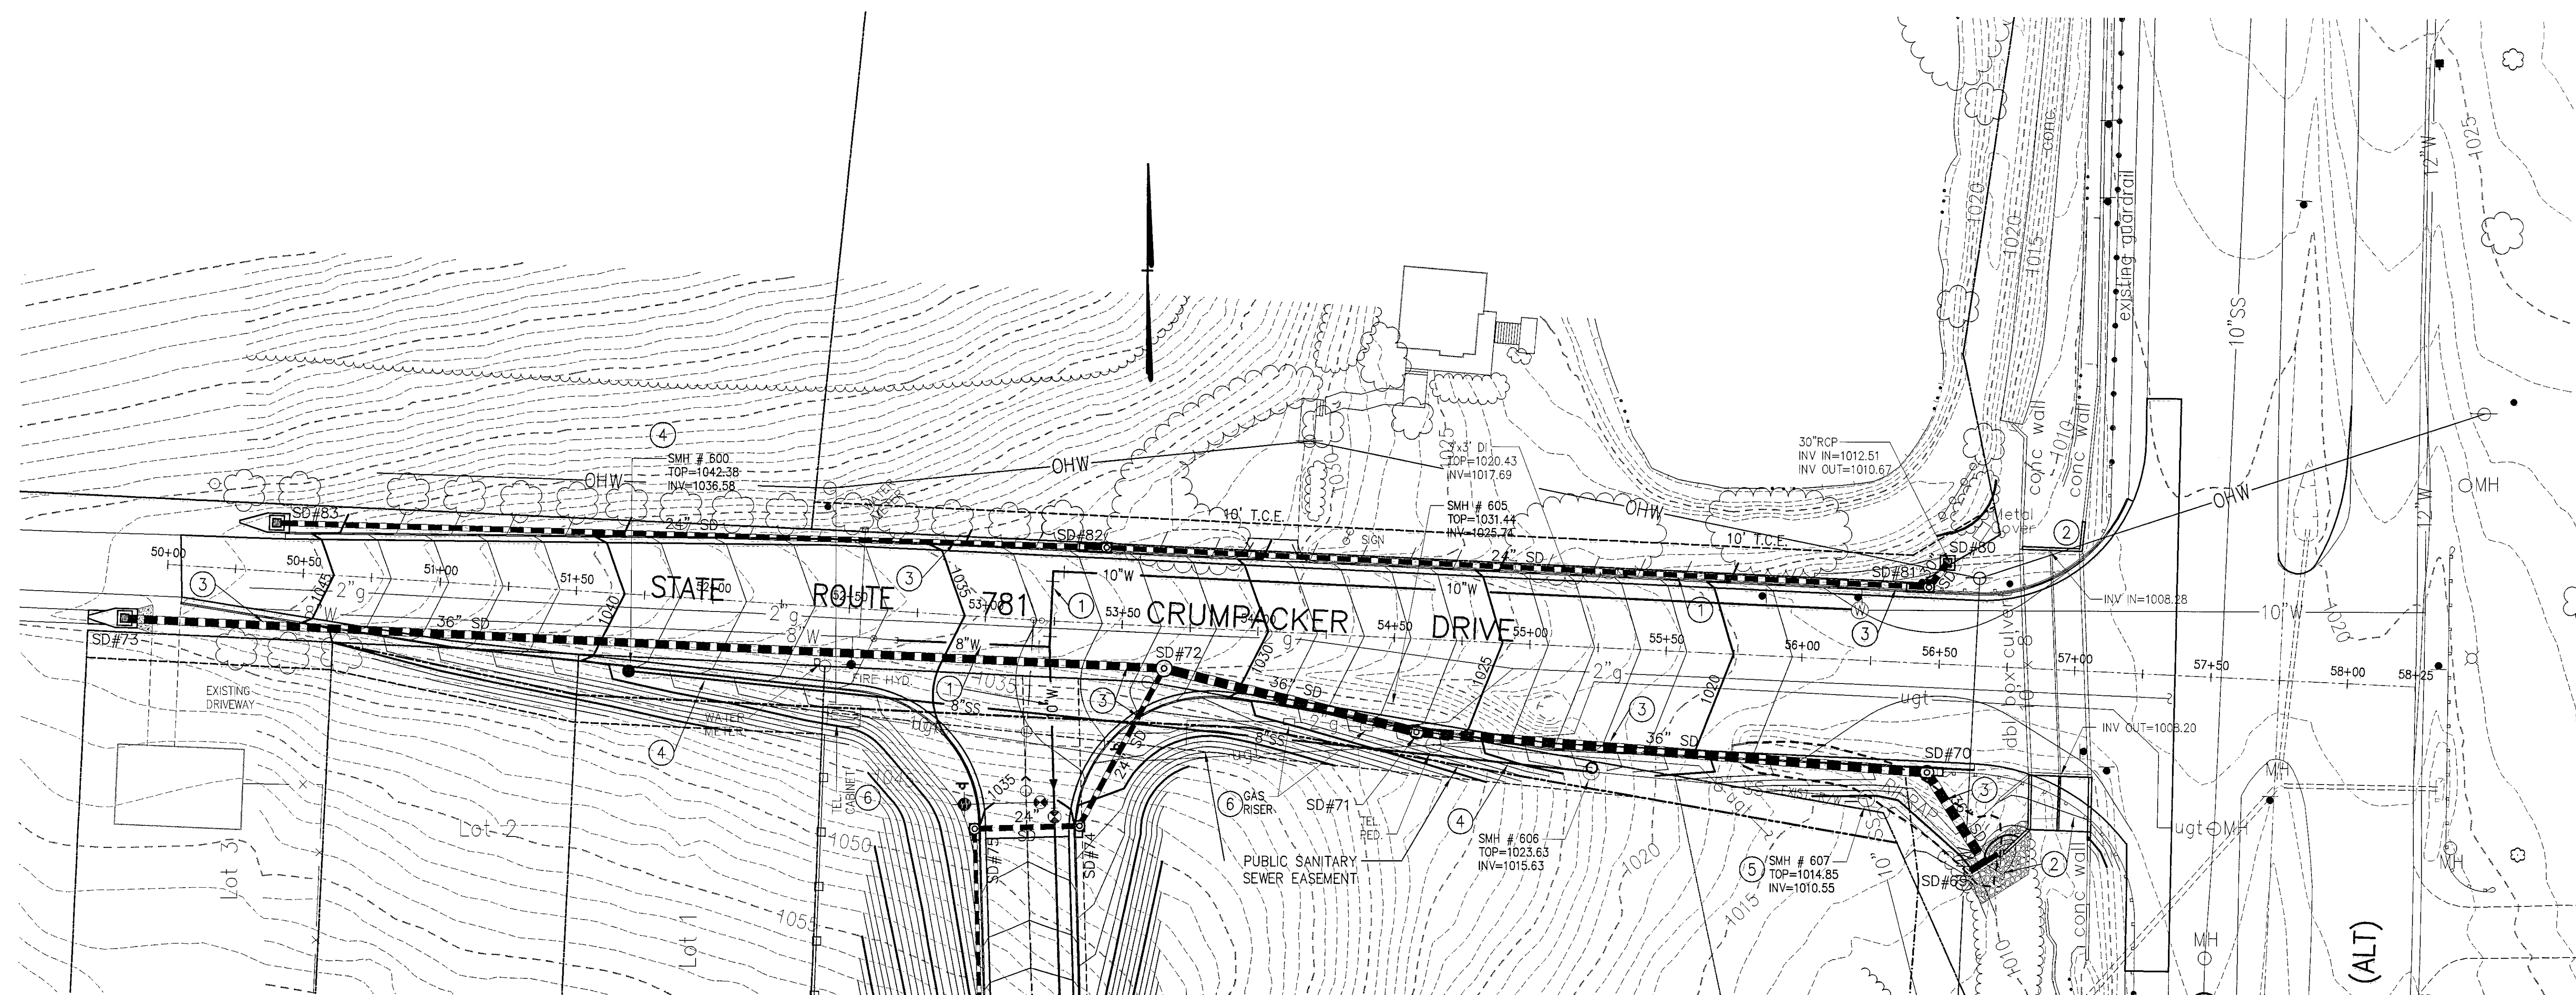

GRADING & UTILITY PLAN - CRUMPACKER DRIVE (RTE. 781)

- KEYNOTES:**
- ① 10" WATERLINE. PROVIDE 3' MIN. COVER. CONNECT TO EXISTING 8" WATERLINE IN CRUMPACKER DRIVE (±30' W. OF REAR ACCESS DRIVE) AND CONNECT TO 8" WATERLINE SERVING WAL-MART SITE.
 - ② REFER TO SHEET C-49 FOR ADDITIONAL INFORMATION PERTAINING TO BOX CULVERT EXTENSION, GUARDRAIL AND OUTLET PROTECTION REQUIRED.
 - ③ NEW STORM DRAIN. REFER TO OFF-SITE STORM DRAIN PROFILES ON SHEET C-46.
 - ④ NEW 8" SANITARY SEWER AND NEW MANHOLE. SEE SHEET C-43 FOR PROFILE.
 - ⑤ ADJUST SMH #607 AND SET RIM 1' ABOVE FINISH GRADE.
 - ⑥ RELOCATE TELEPHONE CABINET, UNDERGROUND TELEPHONE & GAS LINE. COORDINATE WORK WITH APPROPRIATE UTILITY COMPANIES.

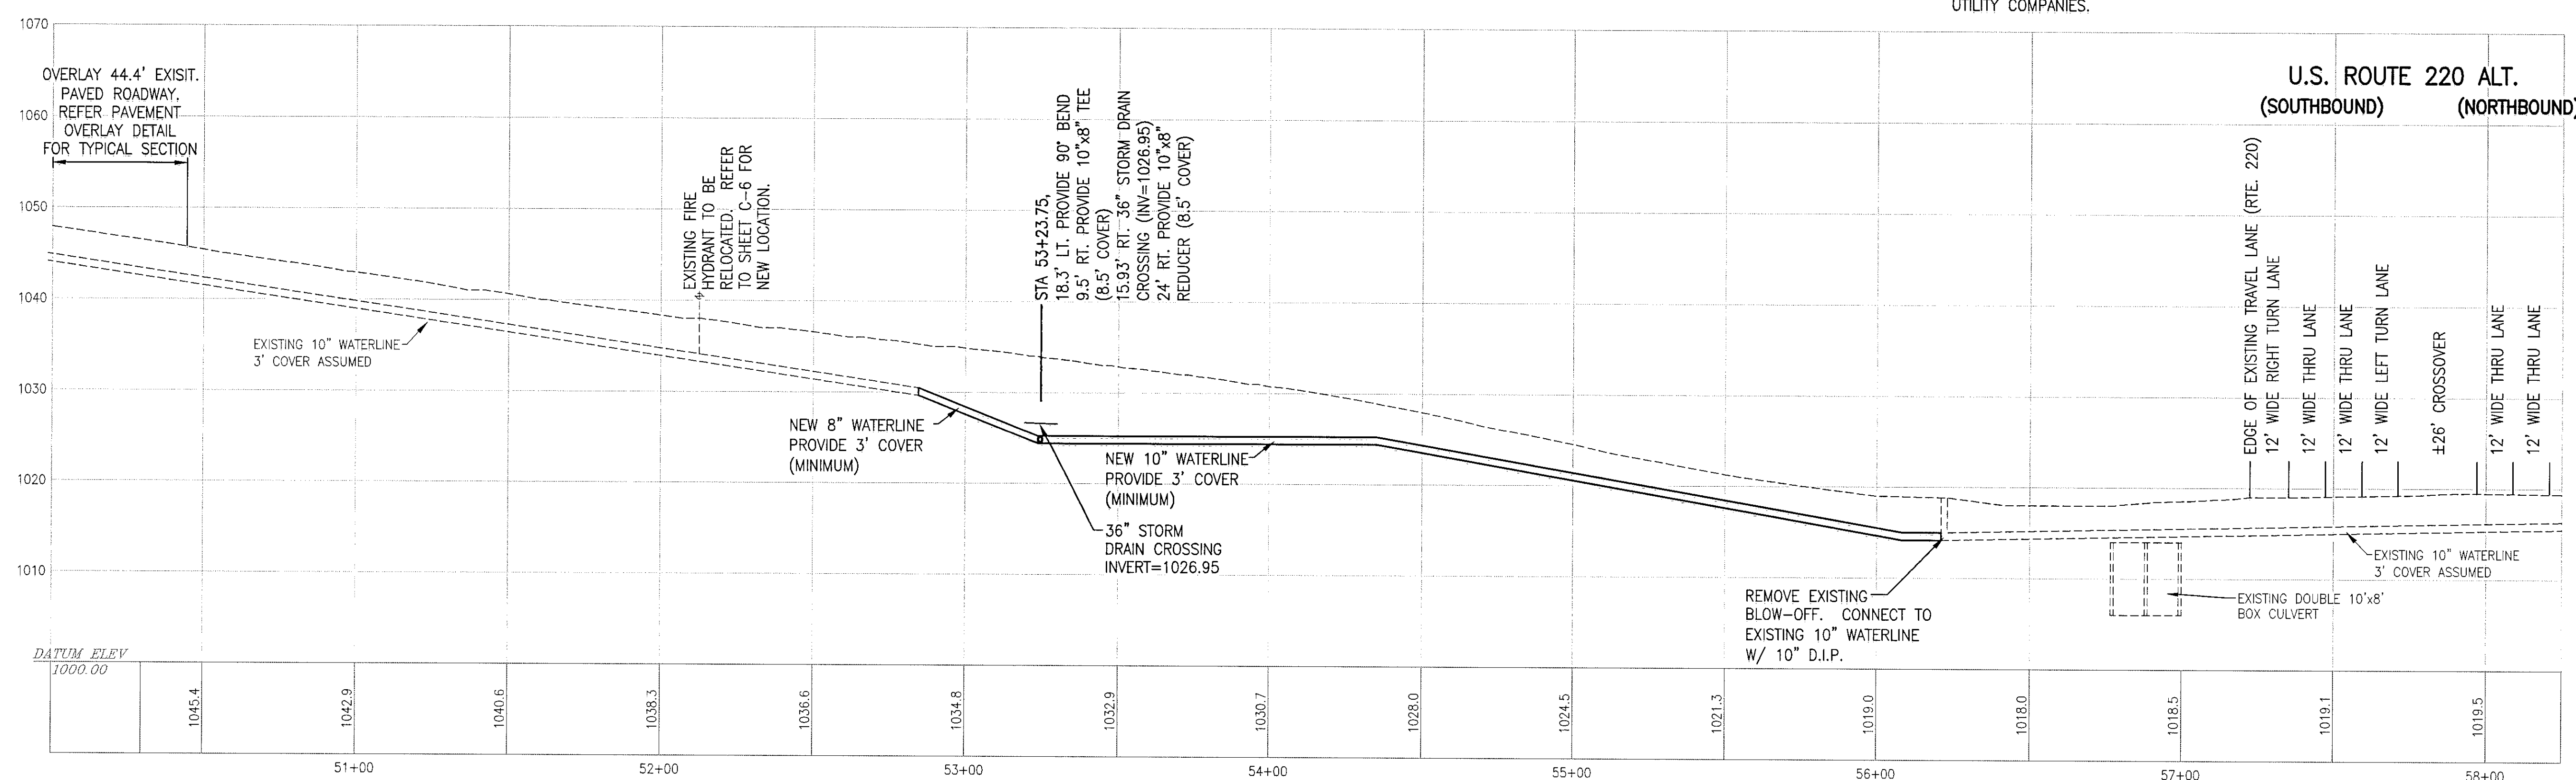

ROADWAY & WATERLINE PROFILE - CRUMPACKER DRIVE (RTE. 781)

ALL CONSTRUCTION SHALL BE PERFORMED IN ACCORDANCE WITH ROANOKE COUNTY STANDARDS AND SPECIFICATIONS.

LOCATION OF EXISTING UTILITIES SHOWN HEREON HAVE BEEN OBTAINED FROM FIELD SURVEY, AERIAL SURVEY, AND RECORDS. CONTRACTOR SHALL VERIFY LOCATION OF ALL UNDERGROUND UTILITIES AND NOTIFY ENGINEER IF CONFLICTS ARISE.

REFER TO SHEET C-41 FOR ADDITIONAL NOTES.

CONTRACTOR SHALL CONTACT
MISS UTILITY @ 1-800-552-7001
FOR LOCATION OF ALL UTILITIES,
AT LEAST 72 HOURS PRIOR TO
BEGINNING CONSTRUCTION

