



STATE	PROJECT NUMBER	SHEET NUMBER	TOTAL SHEETS
VA	08-203		

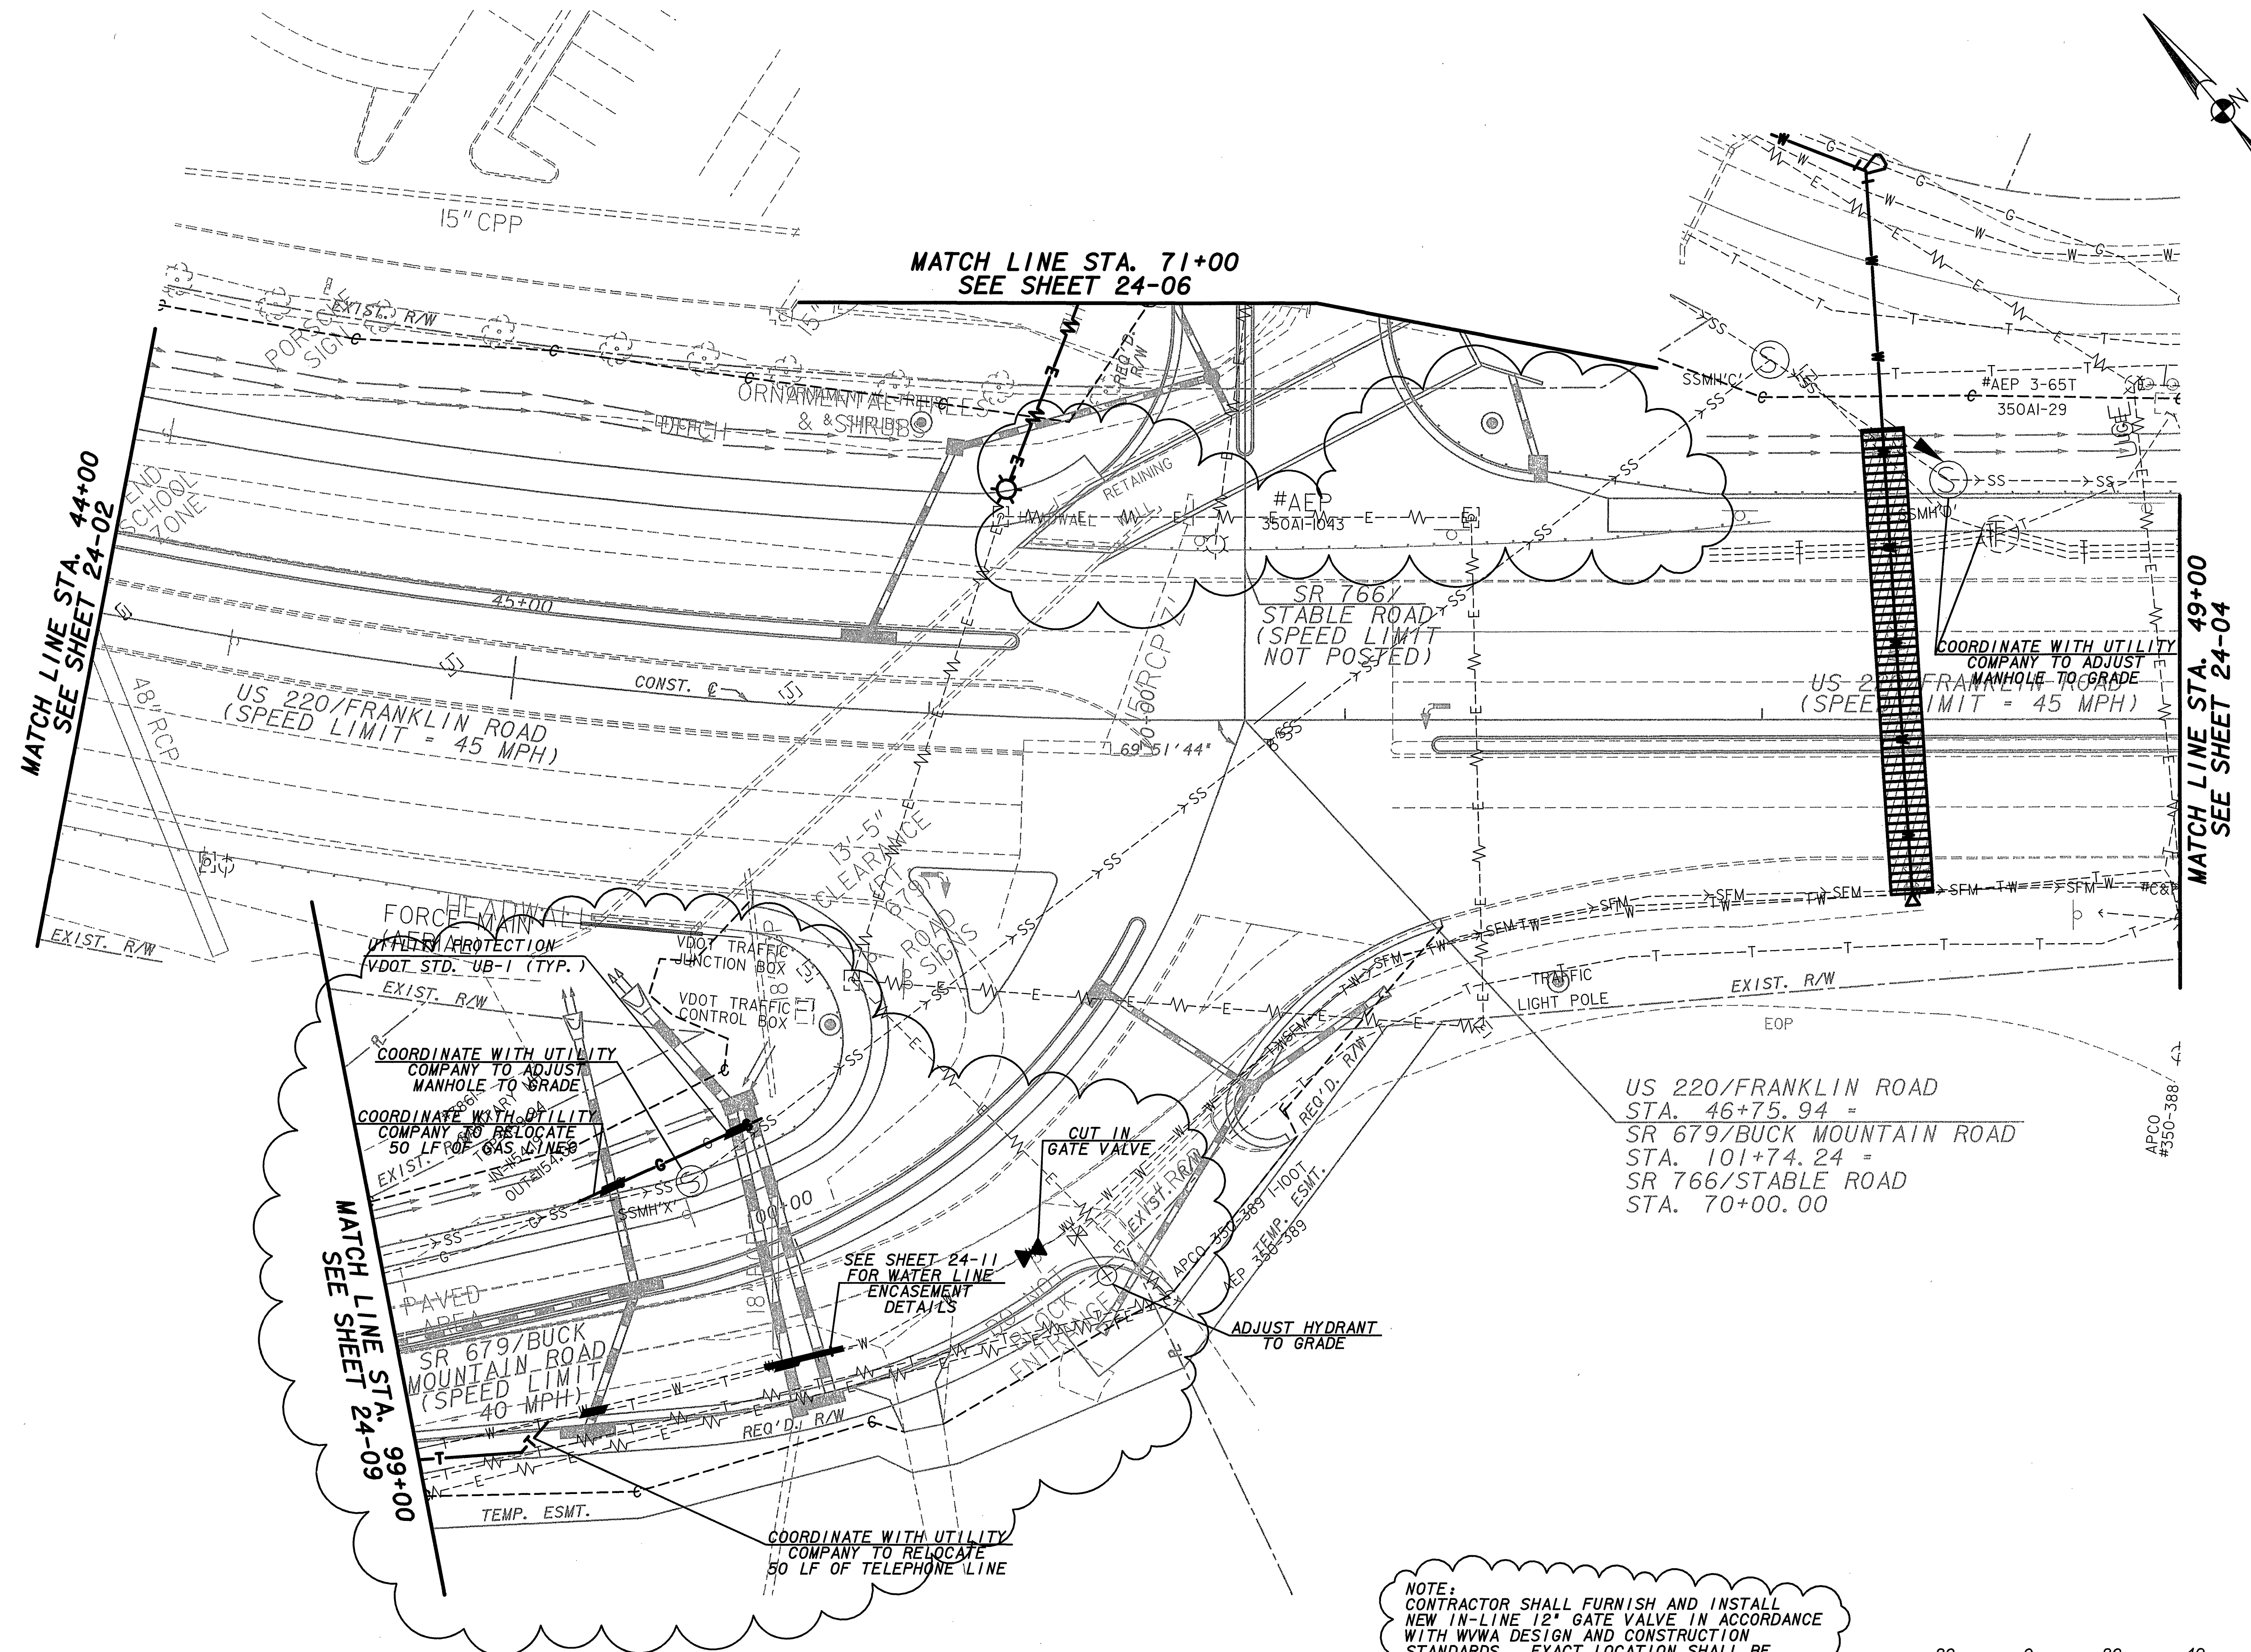

NOTE:
CONTRACTOR SHALL FURNISH AND INSTALL
NEW IN-LINE 12" GATE VALVE IN ACCORDANCE
WITH WWA DESIGN AND CONSTRUCTION
STANDARDS. EXACT LOCATION SHALL BE
DETERMINED IN FIELD WITH WWA
CONSTRUCTION INSPECTOR.

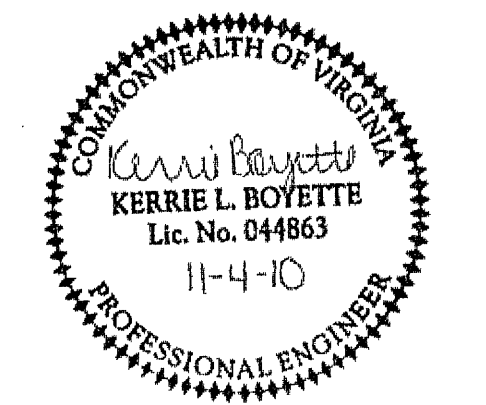

REVISIONS									
DATE	BY	DESCRIPTION	DATE	BY	DESCRIPTION	DESIGNED BY	NAME	DATE	DRAWN BY
10-14-09	KB	ADDENDUM #5				CM	CM	09/21/09	CM
11-04-10	KB	RFI #149				KB	KB	09/21/09	KB
					SUPERVISED BY KERRIE BOYETTE, P.E.				

Wolverton & Associates
Consulting Engineers & Land Surveyors
6745 Bypass Road, Suite 101, Duluth, Georgia 30097
Phone: (770) 441-6669 Fax: (770) 441-6672

**PROPOSED COMMERCIAL DEVELOPMENT
ROANOKE, ROANOKE COUNTY, VIRGINIA
UTILITY PLAN**

**DRAWING NUMBER
24-03**