

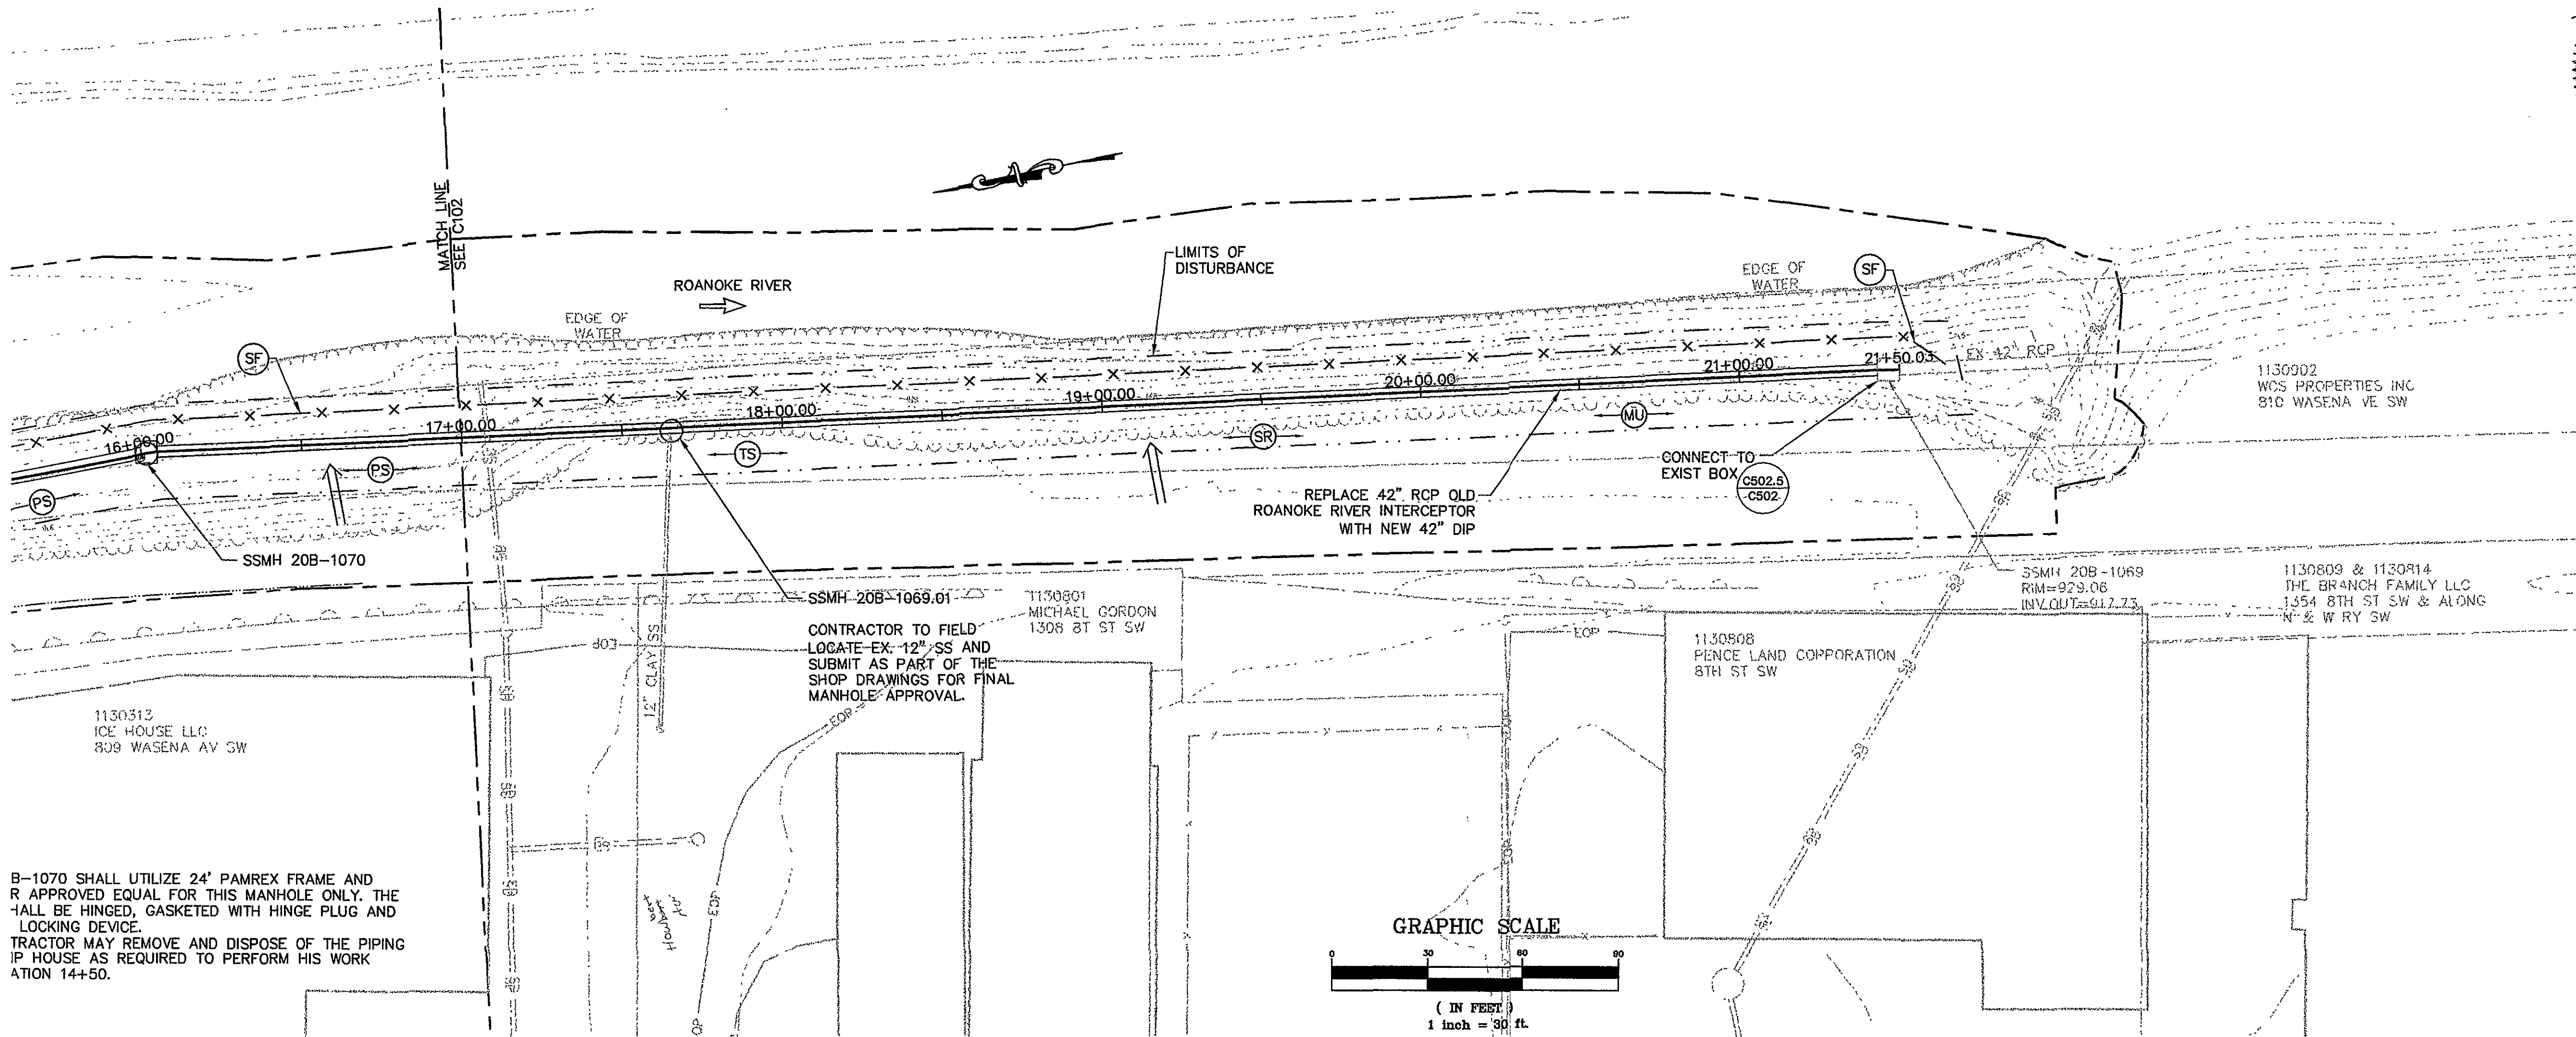
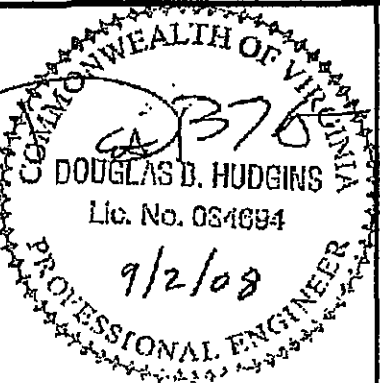



15:09:11\\WVA\1307-08 Wasena Park Crossing\Production\C103.dwg, C103, 9/19/2008 3:58:37 PM, not

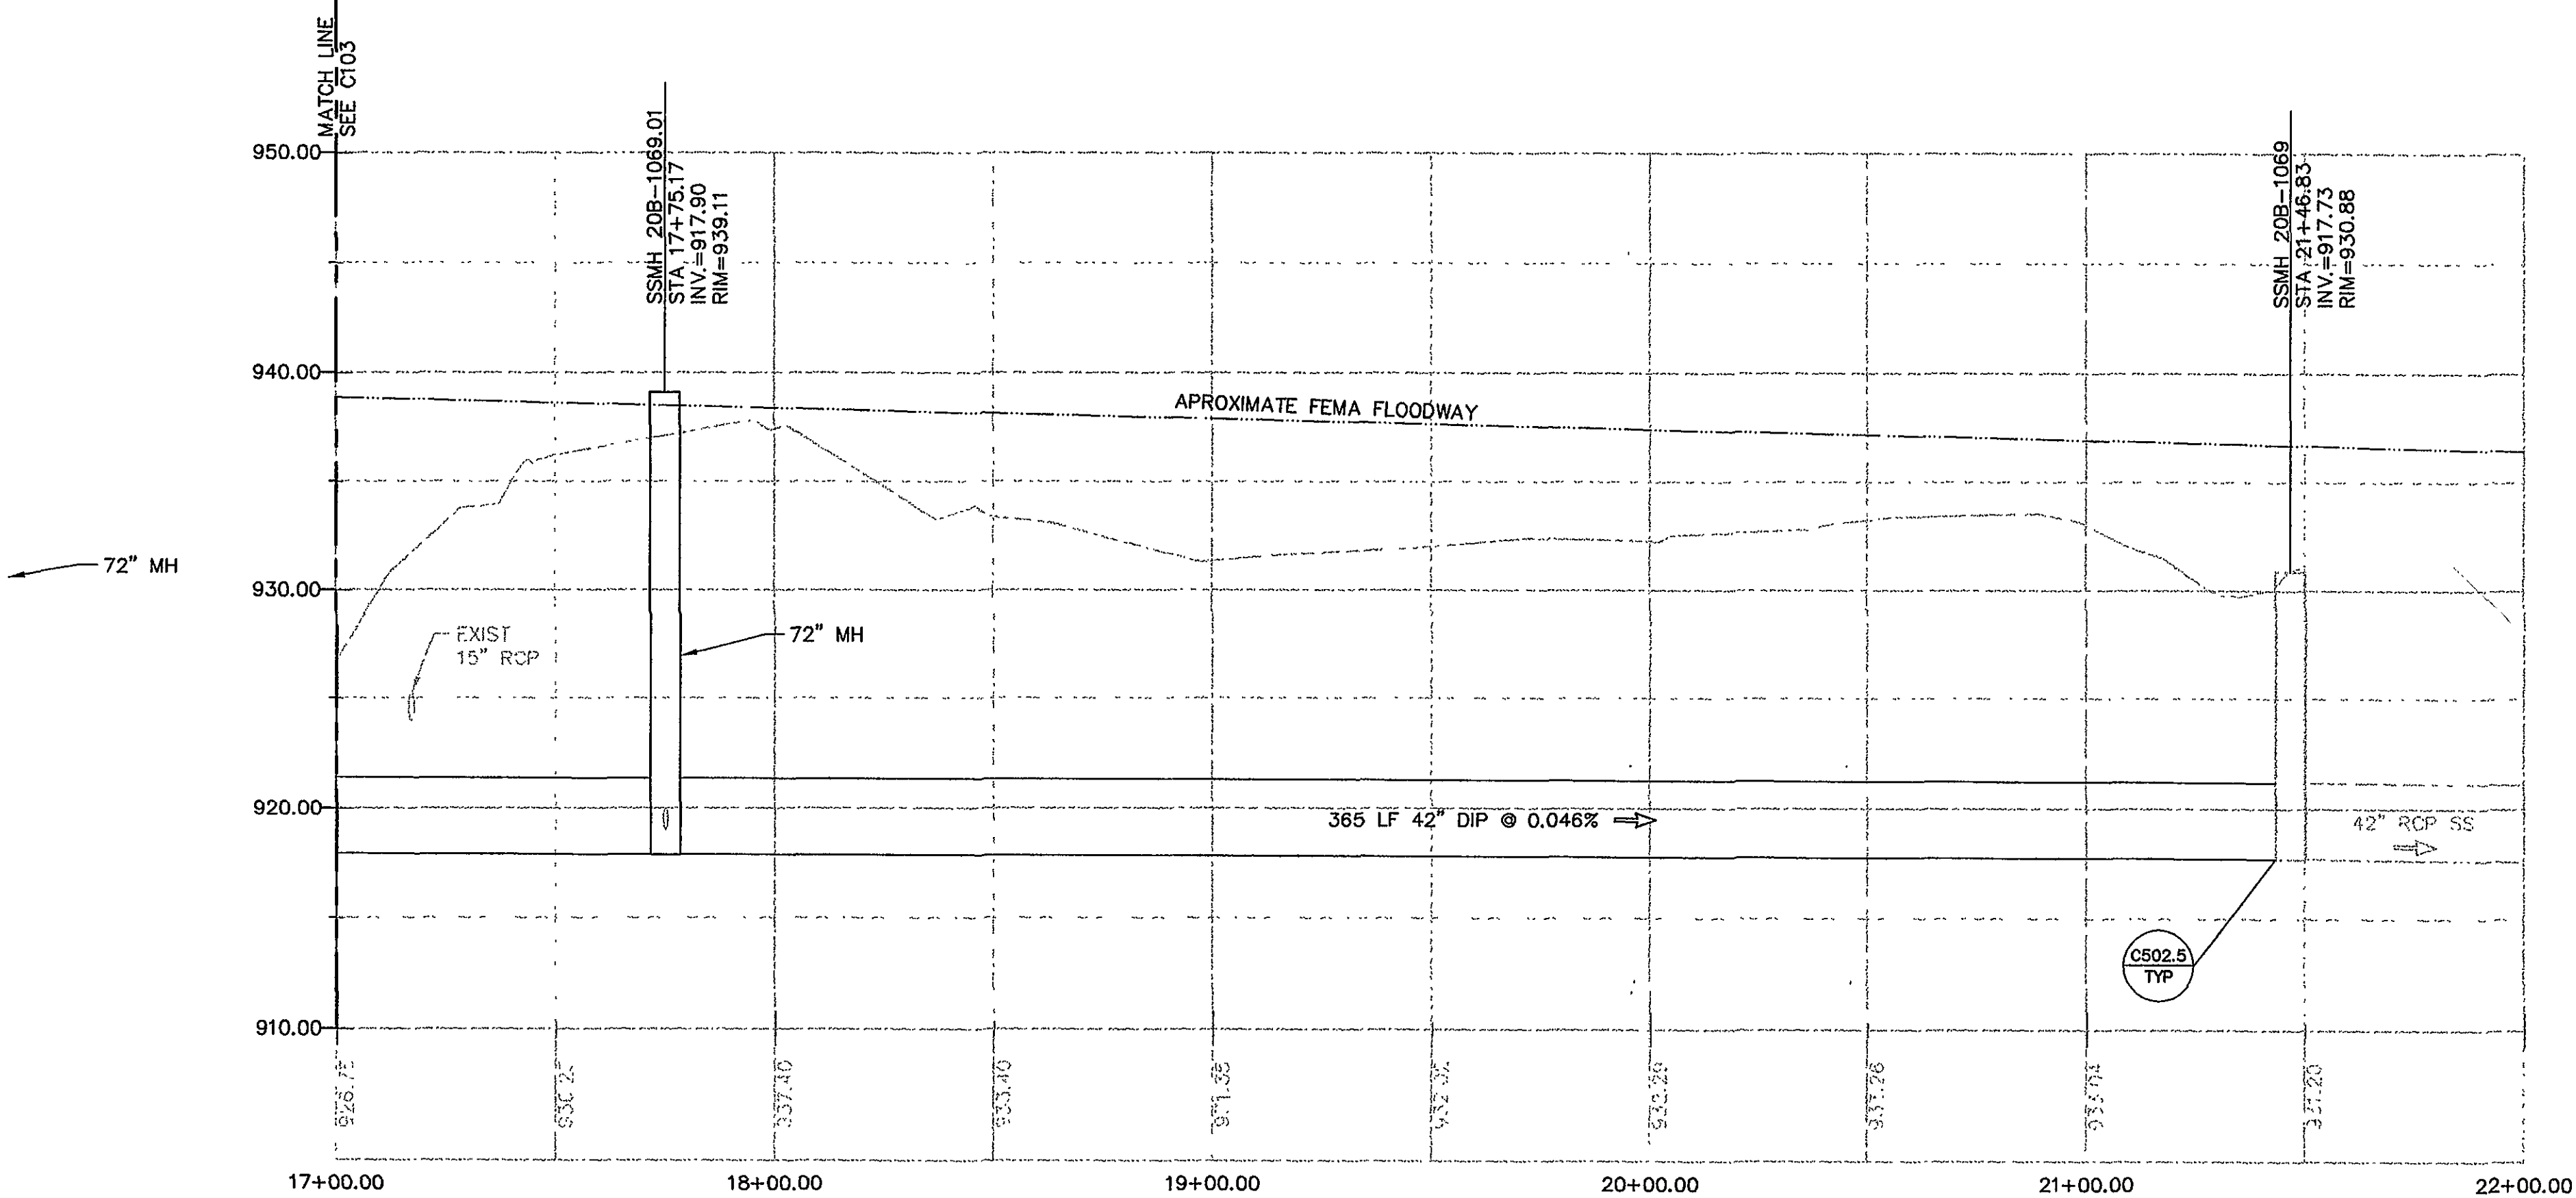

B-1070 SHALL UTILIZE 24" PAMREX FRAME AND R APPROVED EQUAL FOR THIS MANHOLE ONLY. THE SHALL BE HINGED, GASKETED WITH HINGE PLUG AND LOCKING DEVICE. TRACTOR MAY REMOVE AND DISPOSE OF THE PIPING IF HOUSE AS REQUIRED TO PERFORM HIS WORK ATION 14+50.

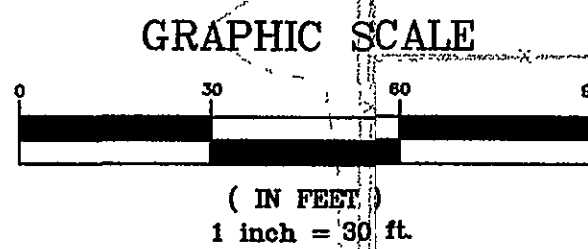

OLVER INCORPORATED
Consulting Engineers & Applied Scientists

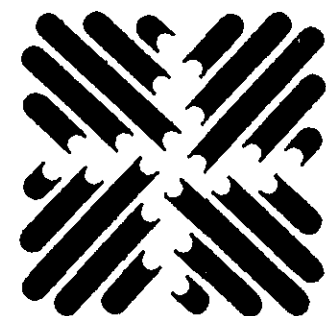

1116 SOUTH MAIN STREET
BLACKSBURG, VIRGINIA 24060
(540) 552-5548

WESTERN VIRGINIA WATER AUTHORITY
INTERCEPTOR IMPROVEMENTS AT WASENA PARK

PROPOSED SITE PLAN
SEWER LINE REPLACEMENT

Rev.	Description	Date	By
C	ADDENDUM 1	9/19/08	DBH
B	BID ISSUE/DEQ REVIEW	8/27/08	DBH
A	CLIENT REVIEW	8/20/08	DBH

Designed: ETA
Drawn: MJM
Checked: DBH
Date: AUG 08
Scale: AS SHOWN
Job No. 12306.08

Archived File Name:

C103

VERIFY SCALE

Bar Scale measures 1" on original drawing

0" 1"