

WASHINGTON HEIGHTS WATERLINE REPLACEMENT PHASE 1 WESTERN VIRGINIA WATER AUTHORITY ROANOKE, VIRGINIA APR. 30, 2021 COMM. NO. 4095


SHEET LIST

- 1 TITLE SHEET
- 2 GENERAL NOTES & LEGEND
- 3 INDEX SHEET & SURVEY DATA
- 4 PLAN AND PROFILE - COMER ST NW WATERLINE
- 5 PLAN AND PROFILE - VIRGINIA AVE NW WATERLINE
- 6 PLAN AND PROFILE - VIRGINIA AVE NW WATERLINE
- 7 PLAN AND PROFILE - VERMONT AVE NW WATERLINE
- 8 PLAN AND PROFILE - VERMONT AVE NW WATERLINE
- 9 PLAN AND PROFILE - VERMONT AVE NW WATERLINE
- 10 PLAN AND PROFILE - FEILDING AVE NW WATERLINE
- 11 PLAN AND PROFILE - MAINE AVE NW WATERLINE
- 12 PLAN AND PROFILE - MAINE AVE NW WATERLINE
- 13 PROFILE - MONROE ST NW
- 14 PROFILE - VAN BUREN ST NW & COMER ST NW
- 15 DETAILS
- 16 DETAILS
- 17 WWA CUSTOMER LIST
- 18 MOT PLAN
- 19 FIRE HYDRANT SERVICE RANGE EXHIBIT


PREPARED FOR



APPROVED FOR CONSTRUCTION

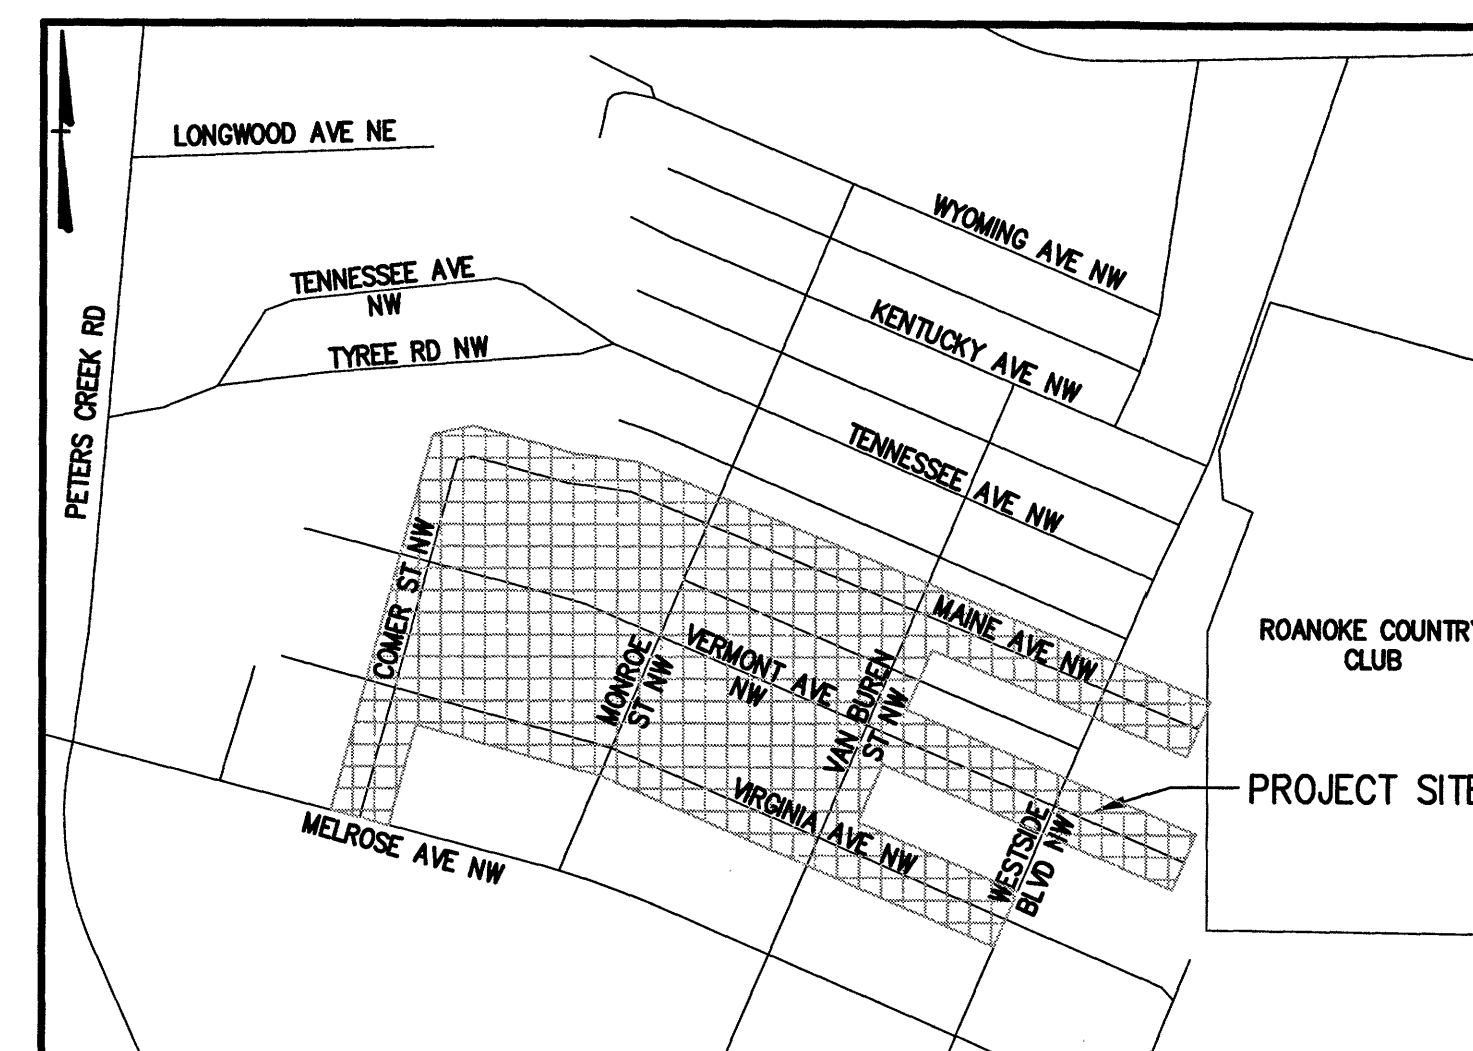

LOCATION MAP
NOT TO SCALE

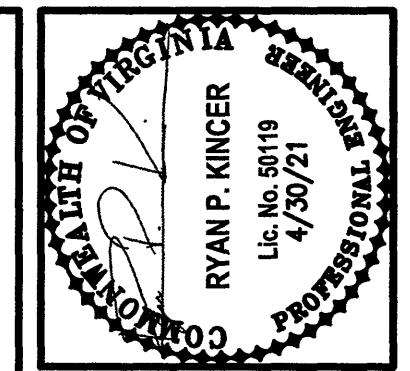

Revisions	Date

Issue Date: APR. 30, 2021	Drawn By: RPK/MLC Designed By: RPK	Checked By: BCC Date: 4/30/21
------------------------------	---------------------------------------	----------------------------------

Mattern & Craig
ENGINEERS-SURVEYORS
701 FIRST STREET, S.W.
ROANOKE, VIRGINIA 24016
(540) 945-5272
FAX (540) 945-7681

WASHINGTON HEIGHTS WATERLINE REPLACEMENT PHASE 1
TITLE SHEET
ROANOKE, VIRGINIA

Vertical Scale:

Horizontal Scale:

Commission Number:
4095

Sheet No.:

1

CHARLES CROSH
As-BUILT
7-1-22