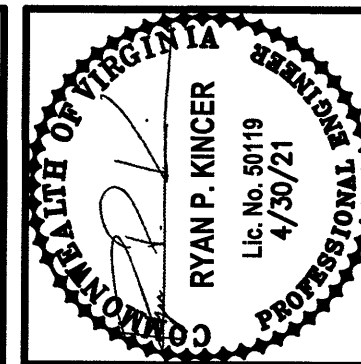
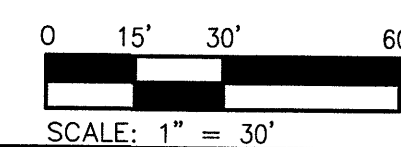
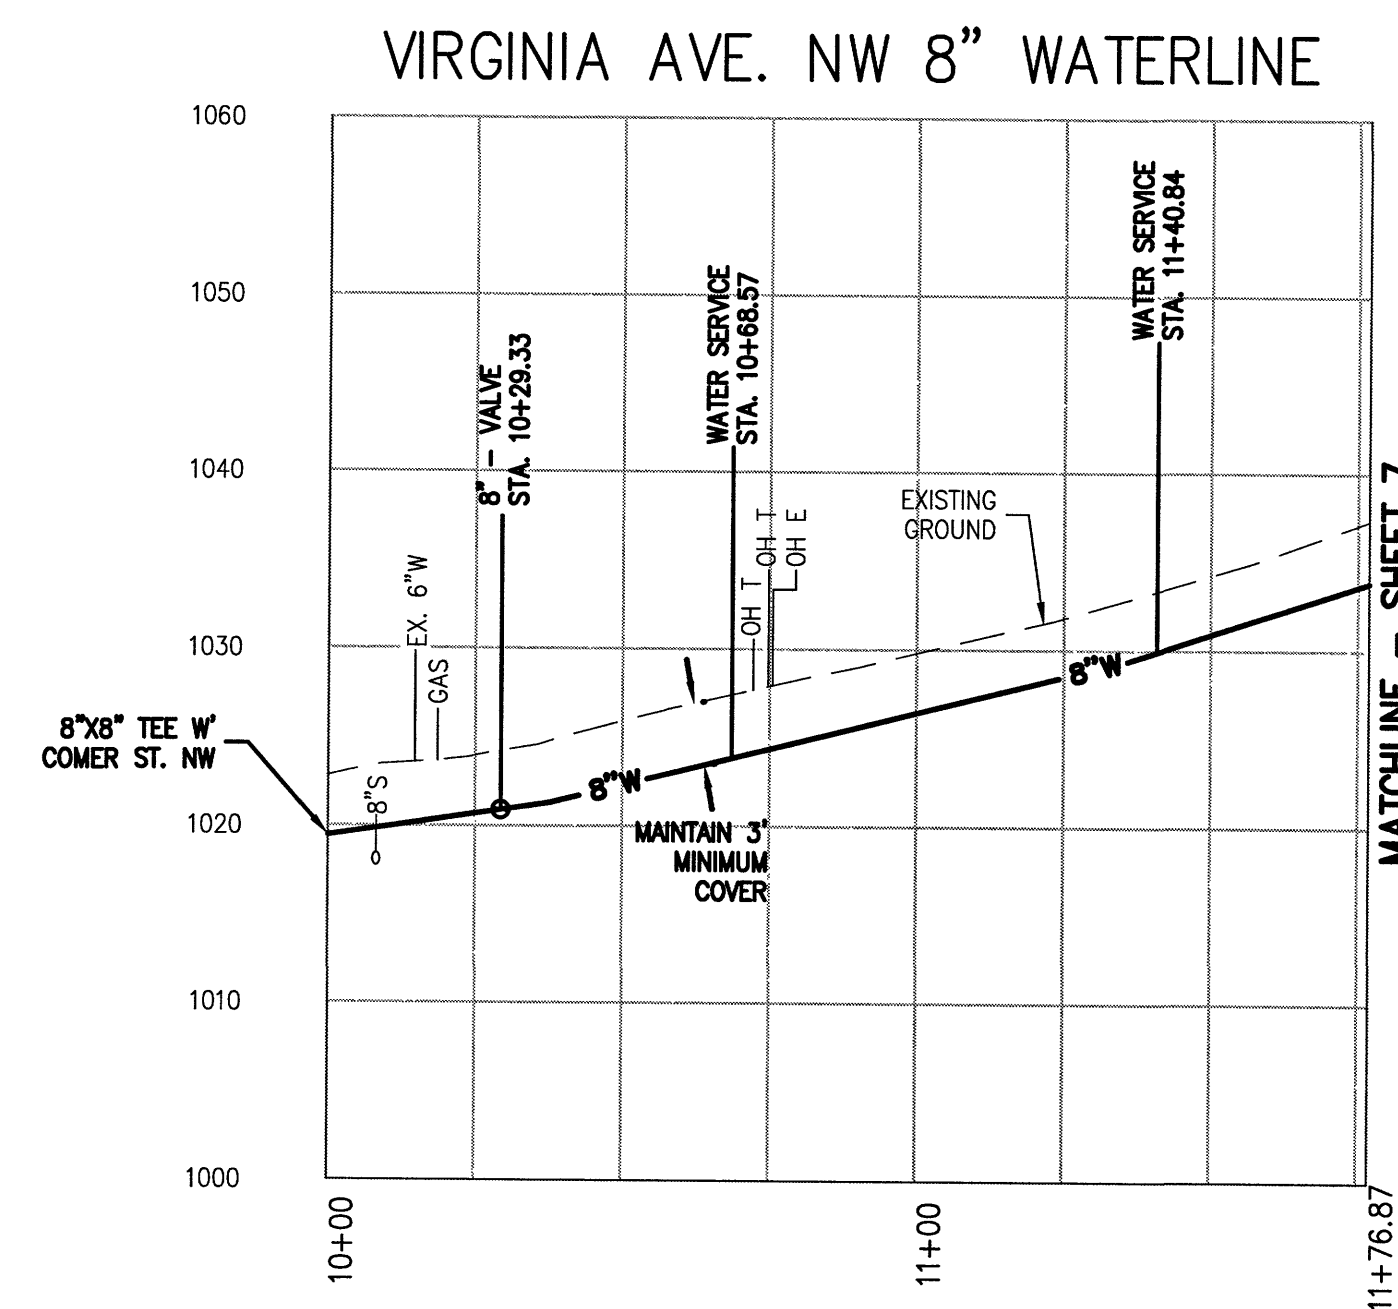
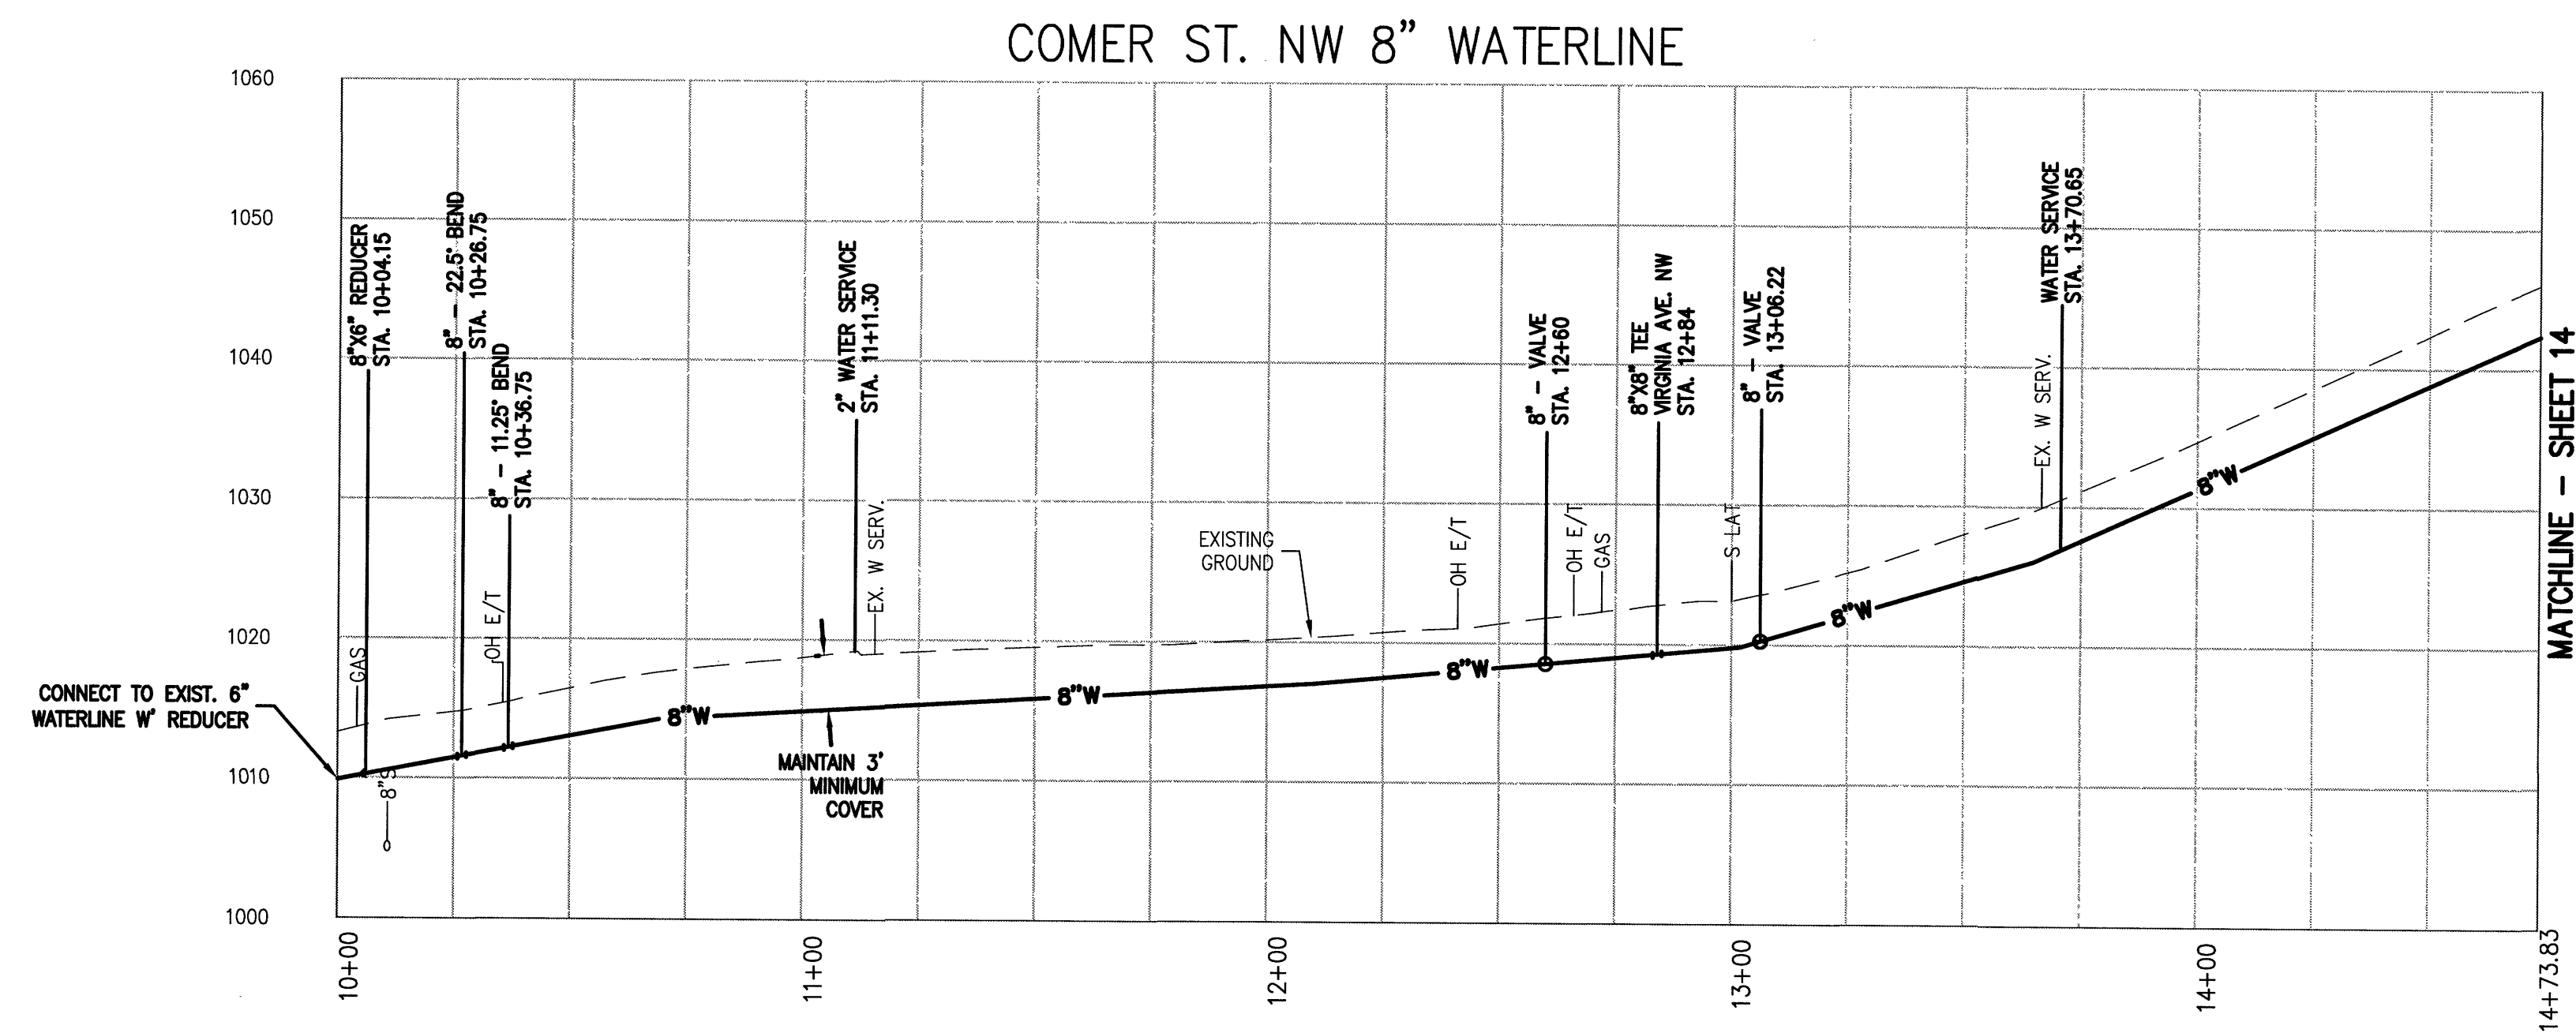
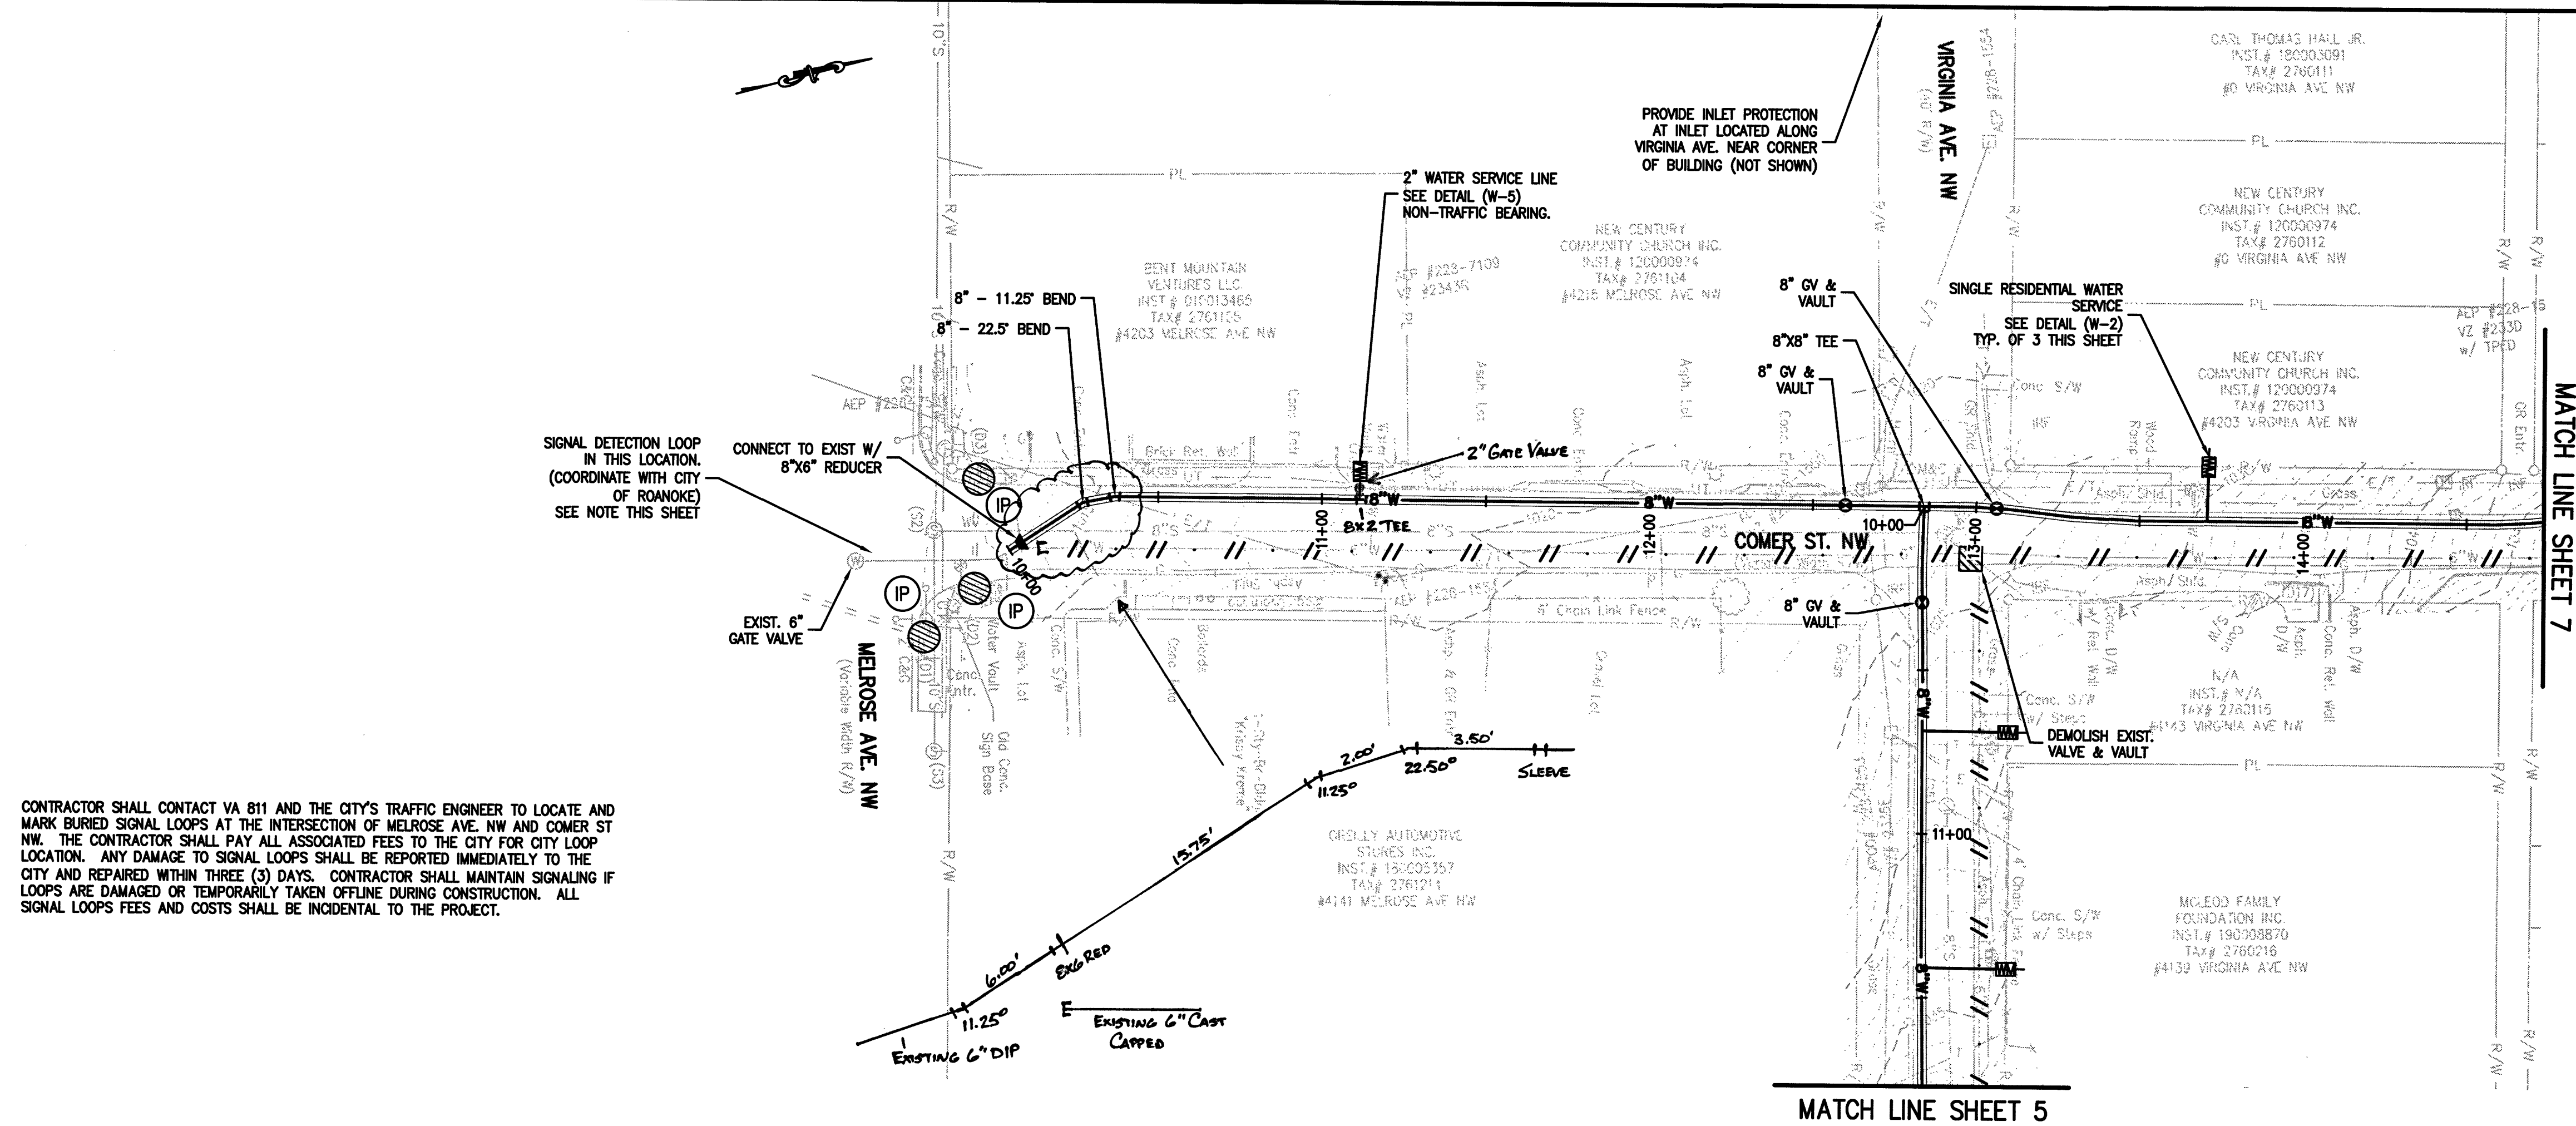


[illegible]

Issue Date: APR. 30, 2021	Drawn By: RPK/MLC	Checked By: BCC
	Designed By: RPK	Date: 4/30/21

Mattern & Craig
ENGINEERS•SURVEYORS

701 FIRST STREET, S.W.
ROANOKE, VIRGINIA 24016
(540) 345-9342
FAX (540) 345-7891

WASHINGTON HEIGHTS WATERLINE REPLACEMENT PHASE 1
PLAN AND PROFILE -
COMER ST NW WATERLINE
ROANOKE, VIRGINIA

Vertical Scale:
1"=10'

Horizontal Scale:
1"=30'

Commission Number:
4095

Sheet No.: