


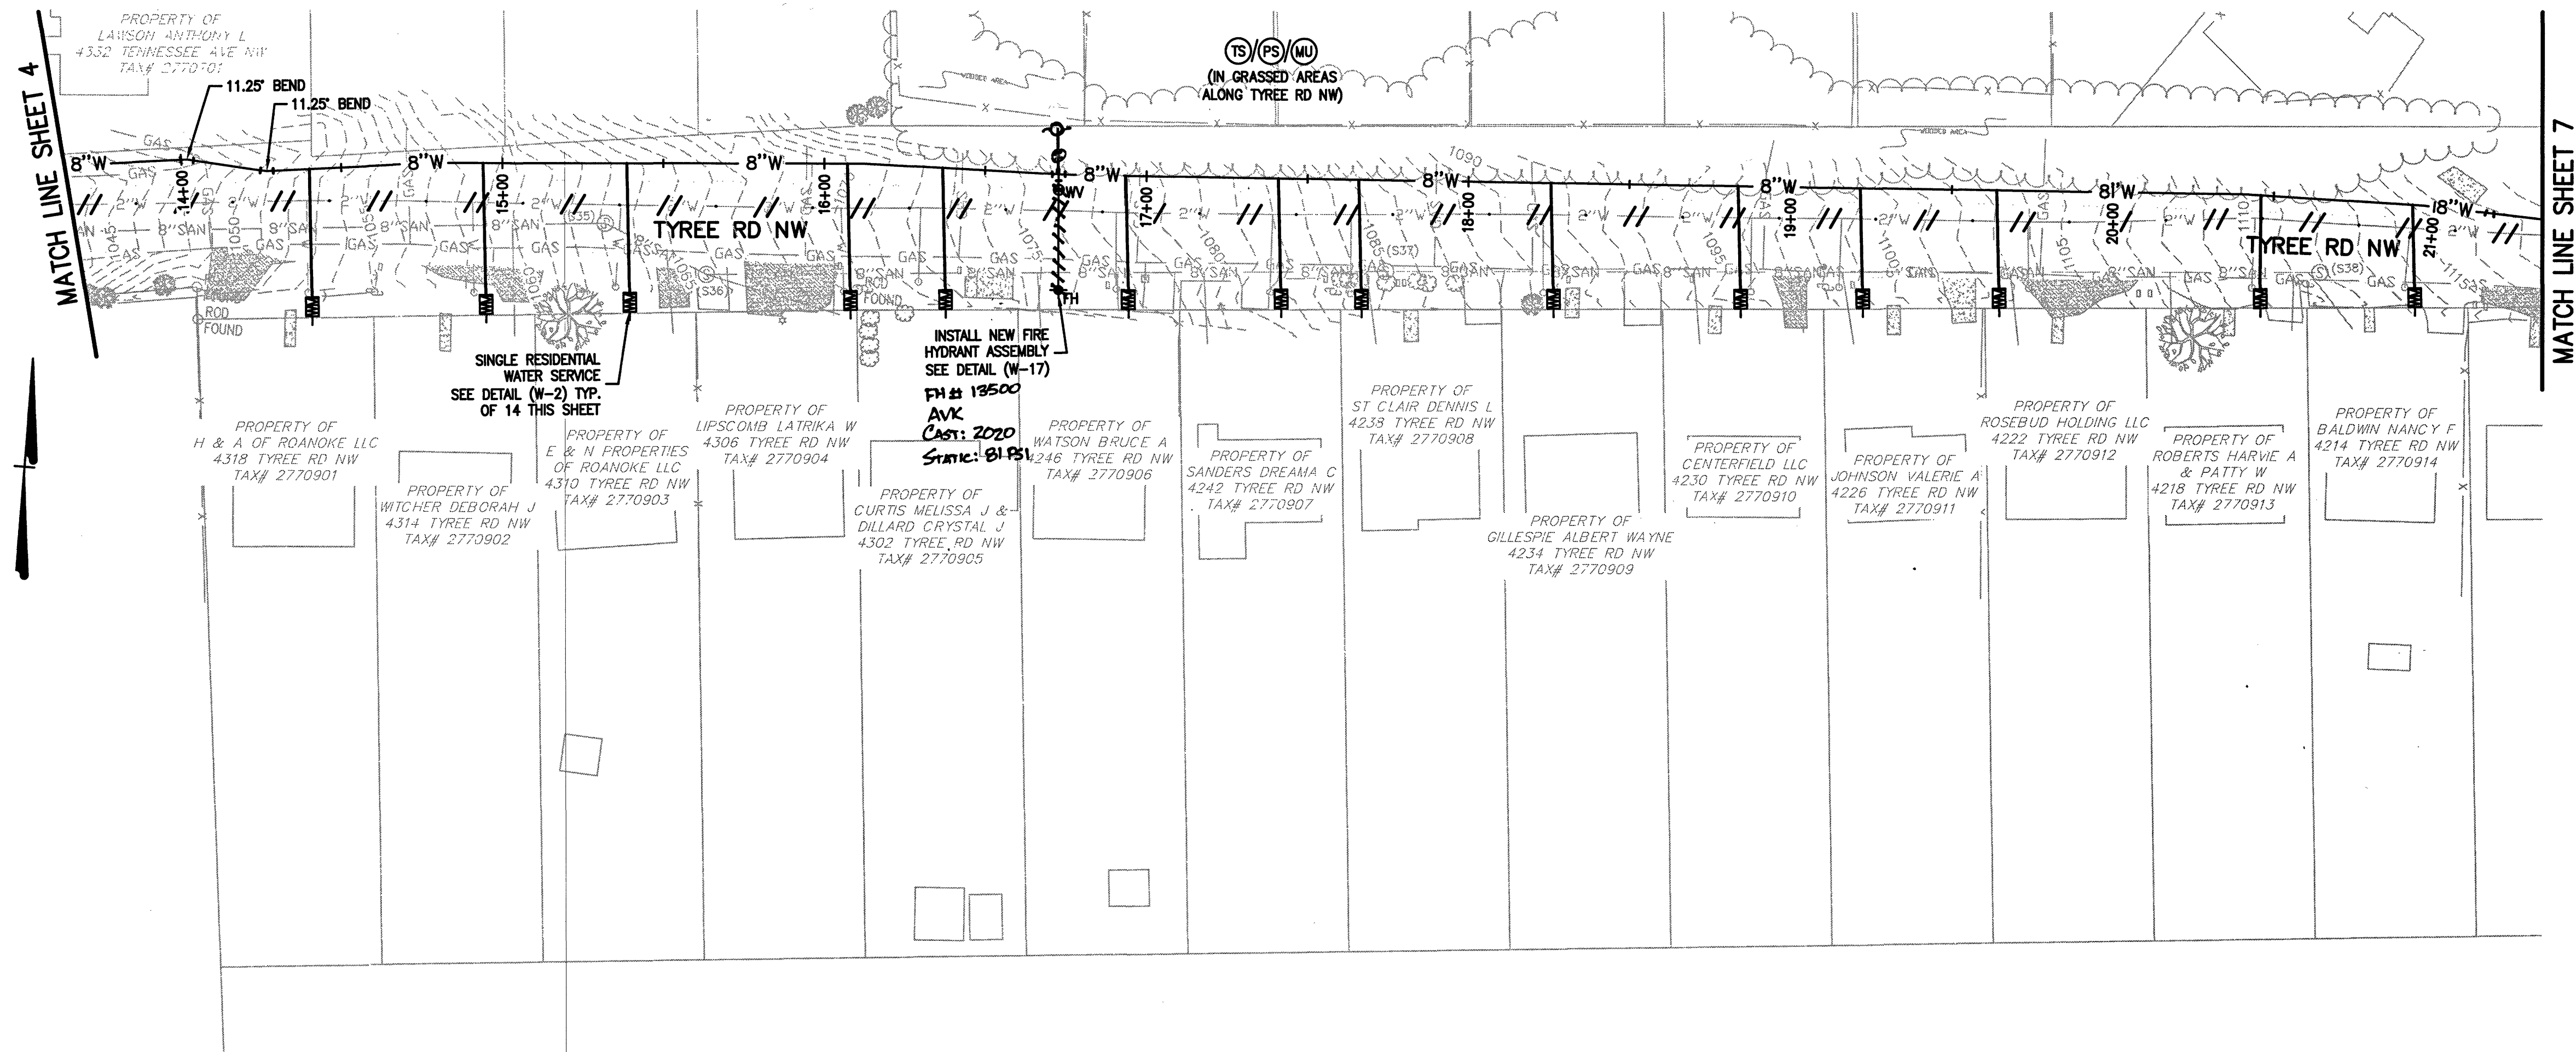

8 INCH WATERLINE - TYREE RD.



Revisions	Date

Issue Date:	MAR. 9, 2021
Drawn By:	RPK/MLC
Designed By:	RPK
Checked By:	BCC
Date:	3/9/21

Matern & Craig
ENGINEERS-SURVEYORS
701 FIRST STREET, S.W.
ROANOKE, VIRGINIA 24016
(540) 945-9942
FAX (540) 945-1651

WASHINGTON HEIGHTS WATERLINE REPLACEMENT PHASE 2

PLAN AND PROFILE -
TYREE RD NW WATERLINE

ROANOKE, VIRGINIA

Vertical Scale:
1"=10'

Horizontal Scale:
1"=30'

Commission Number:
4095

Sheet No.:
5