





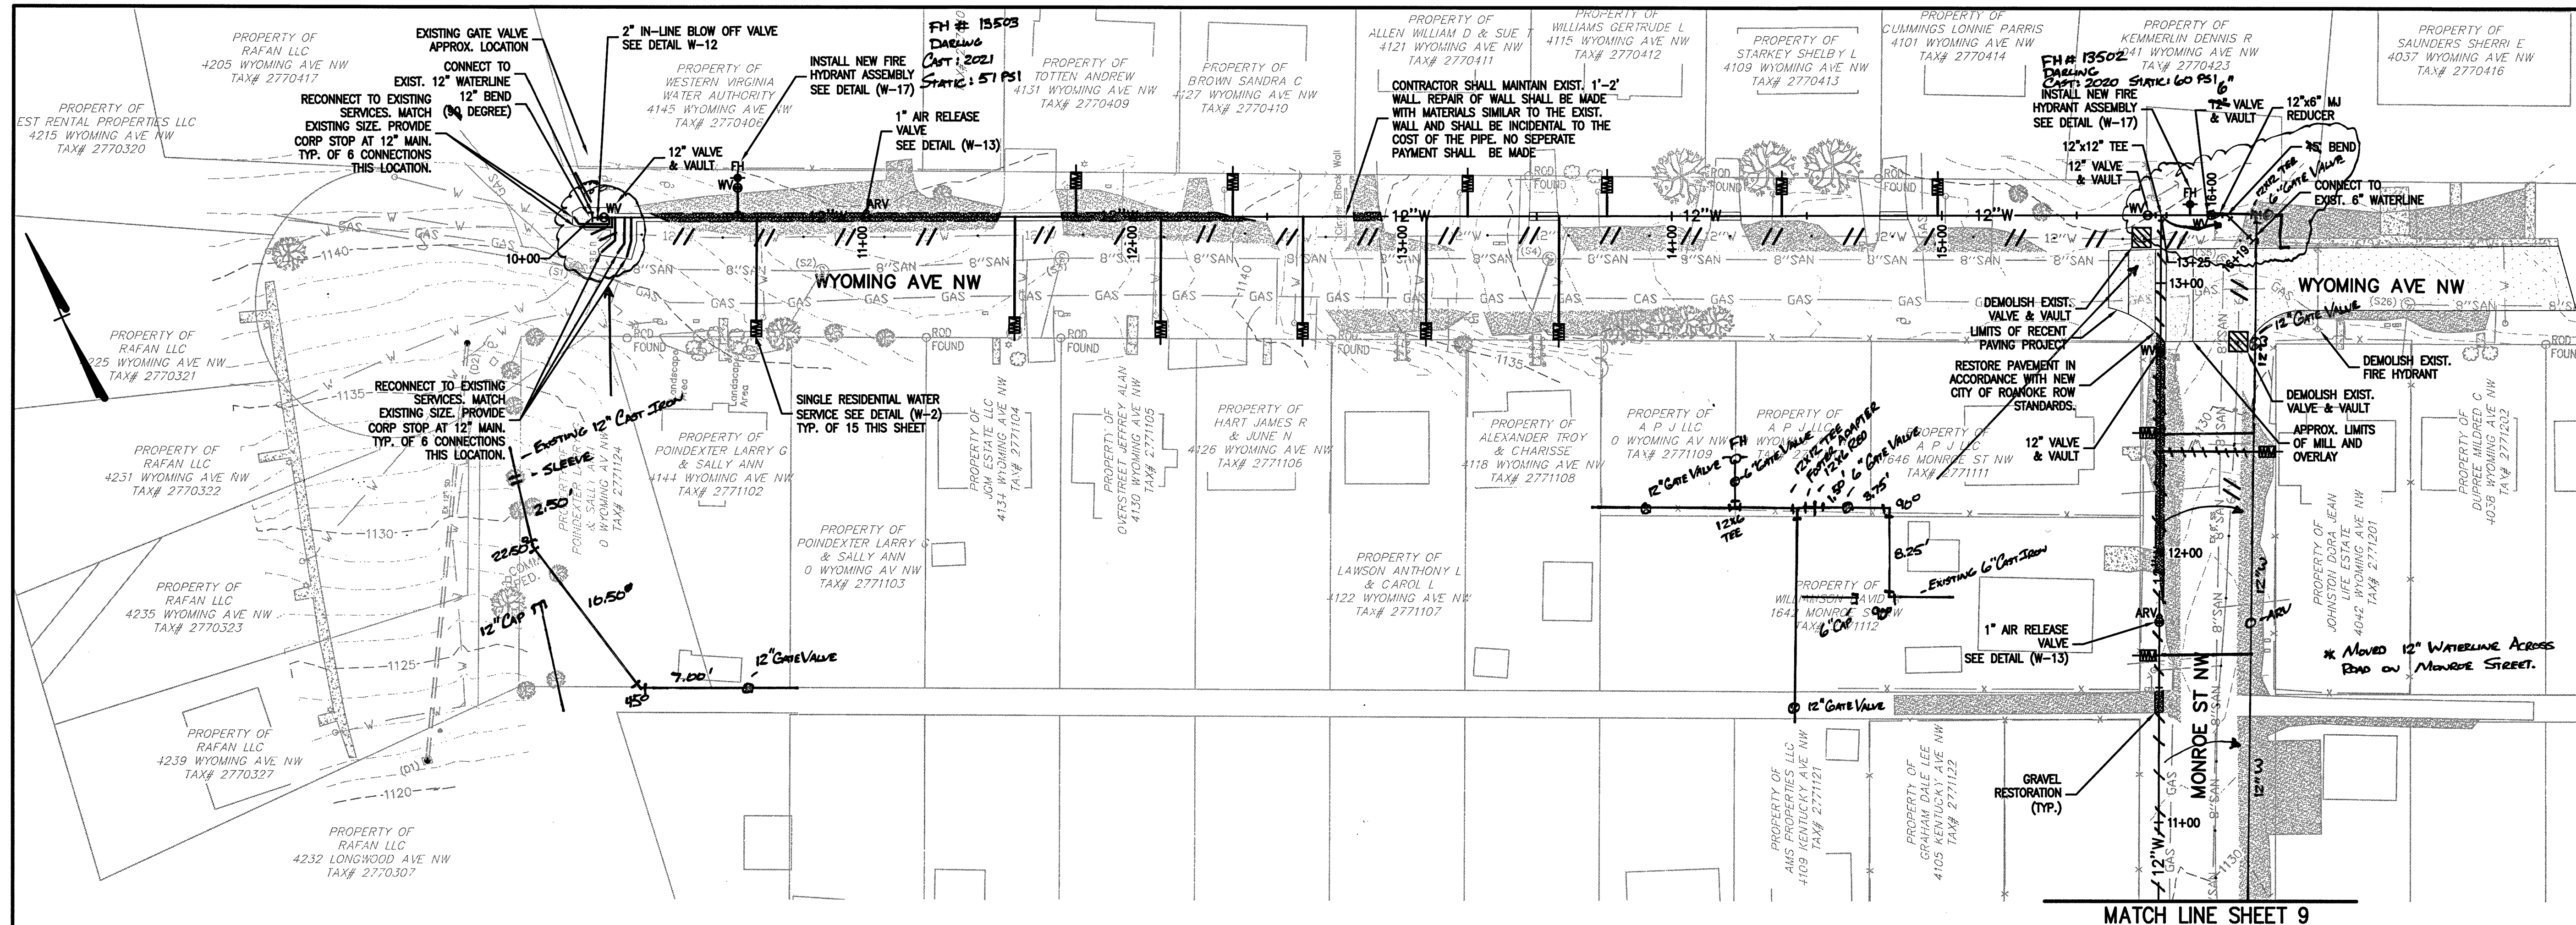


MATCH LINE SHEET 9

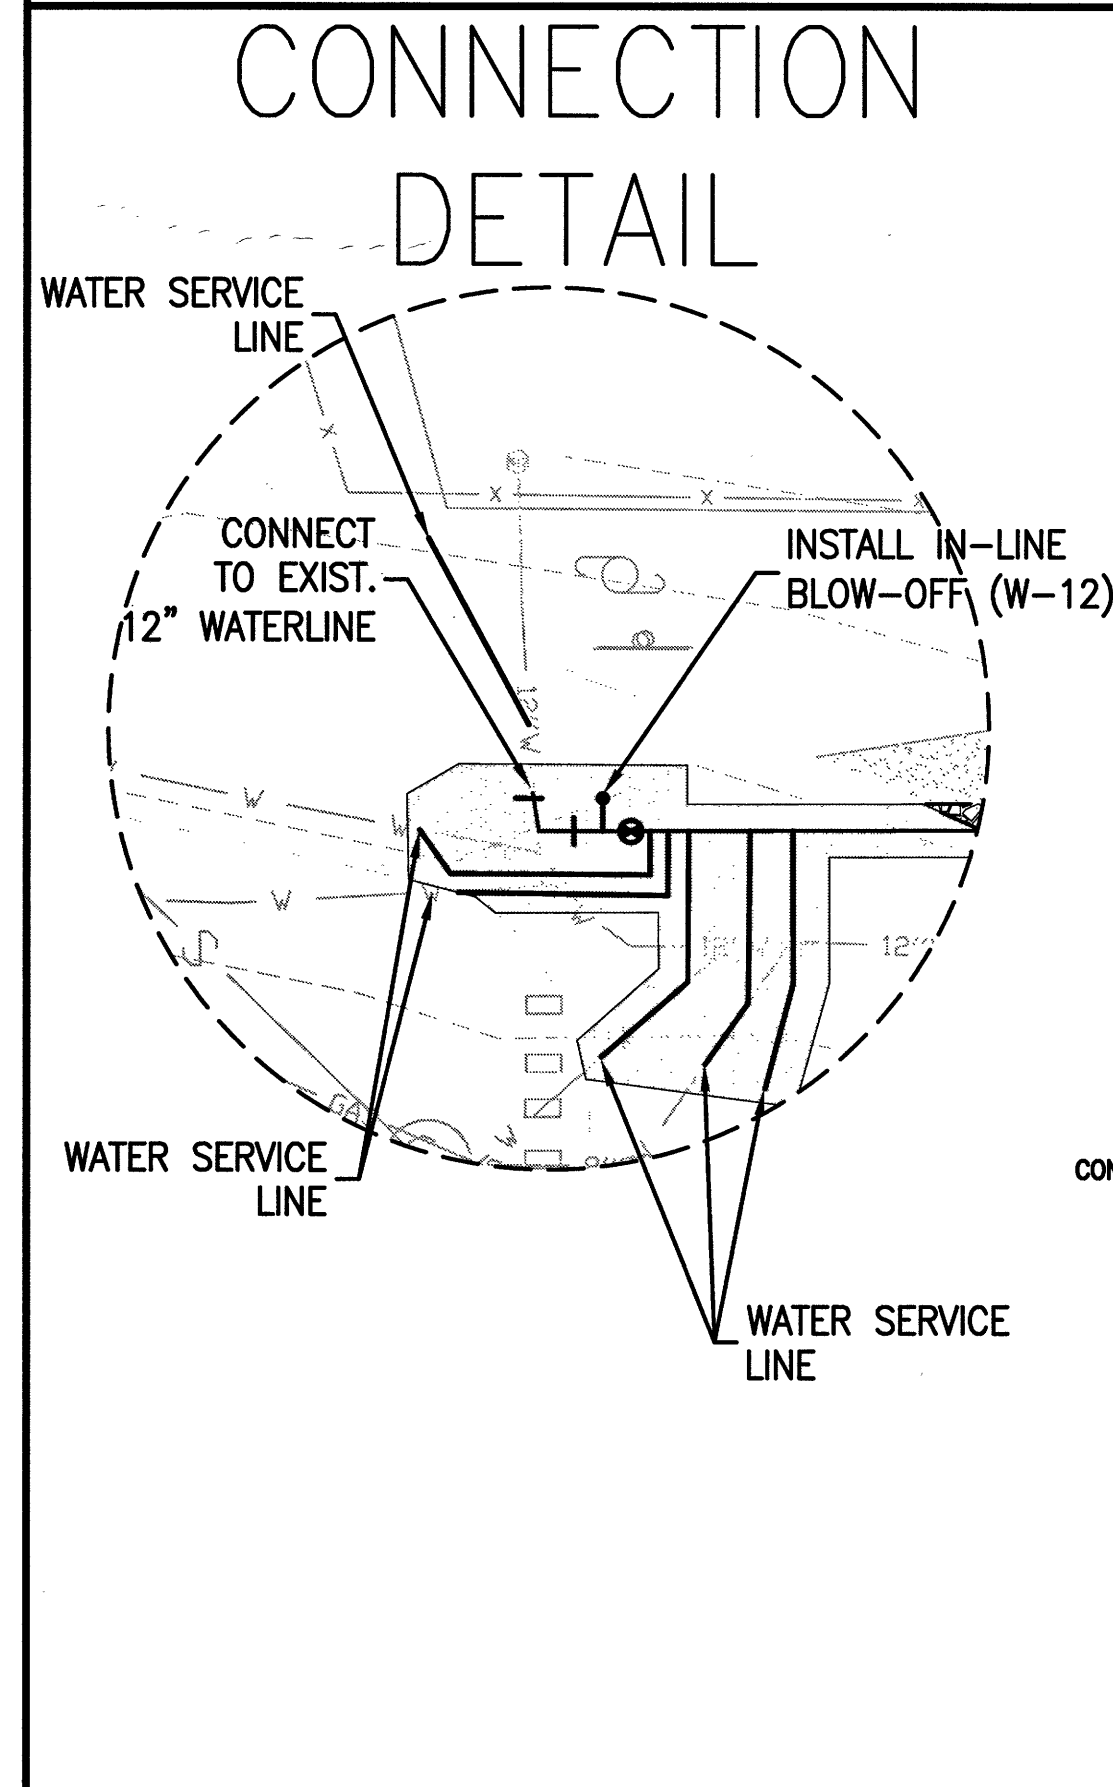

12 INCH WATERLINE - WYOMING AVE.

SEE SHEET 14 FOR MONROE ST. PROFILES

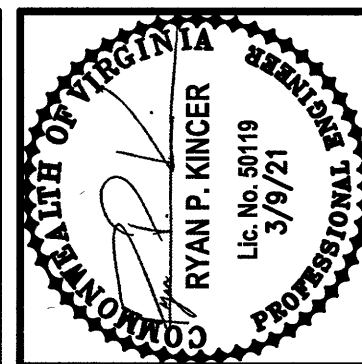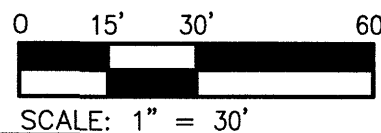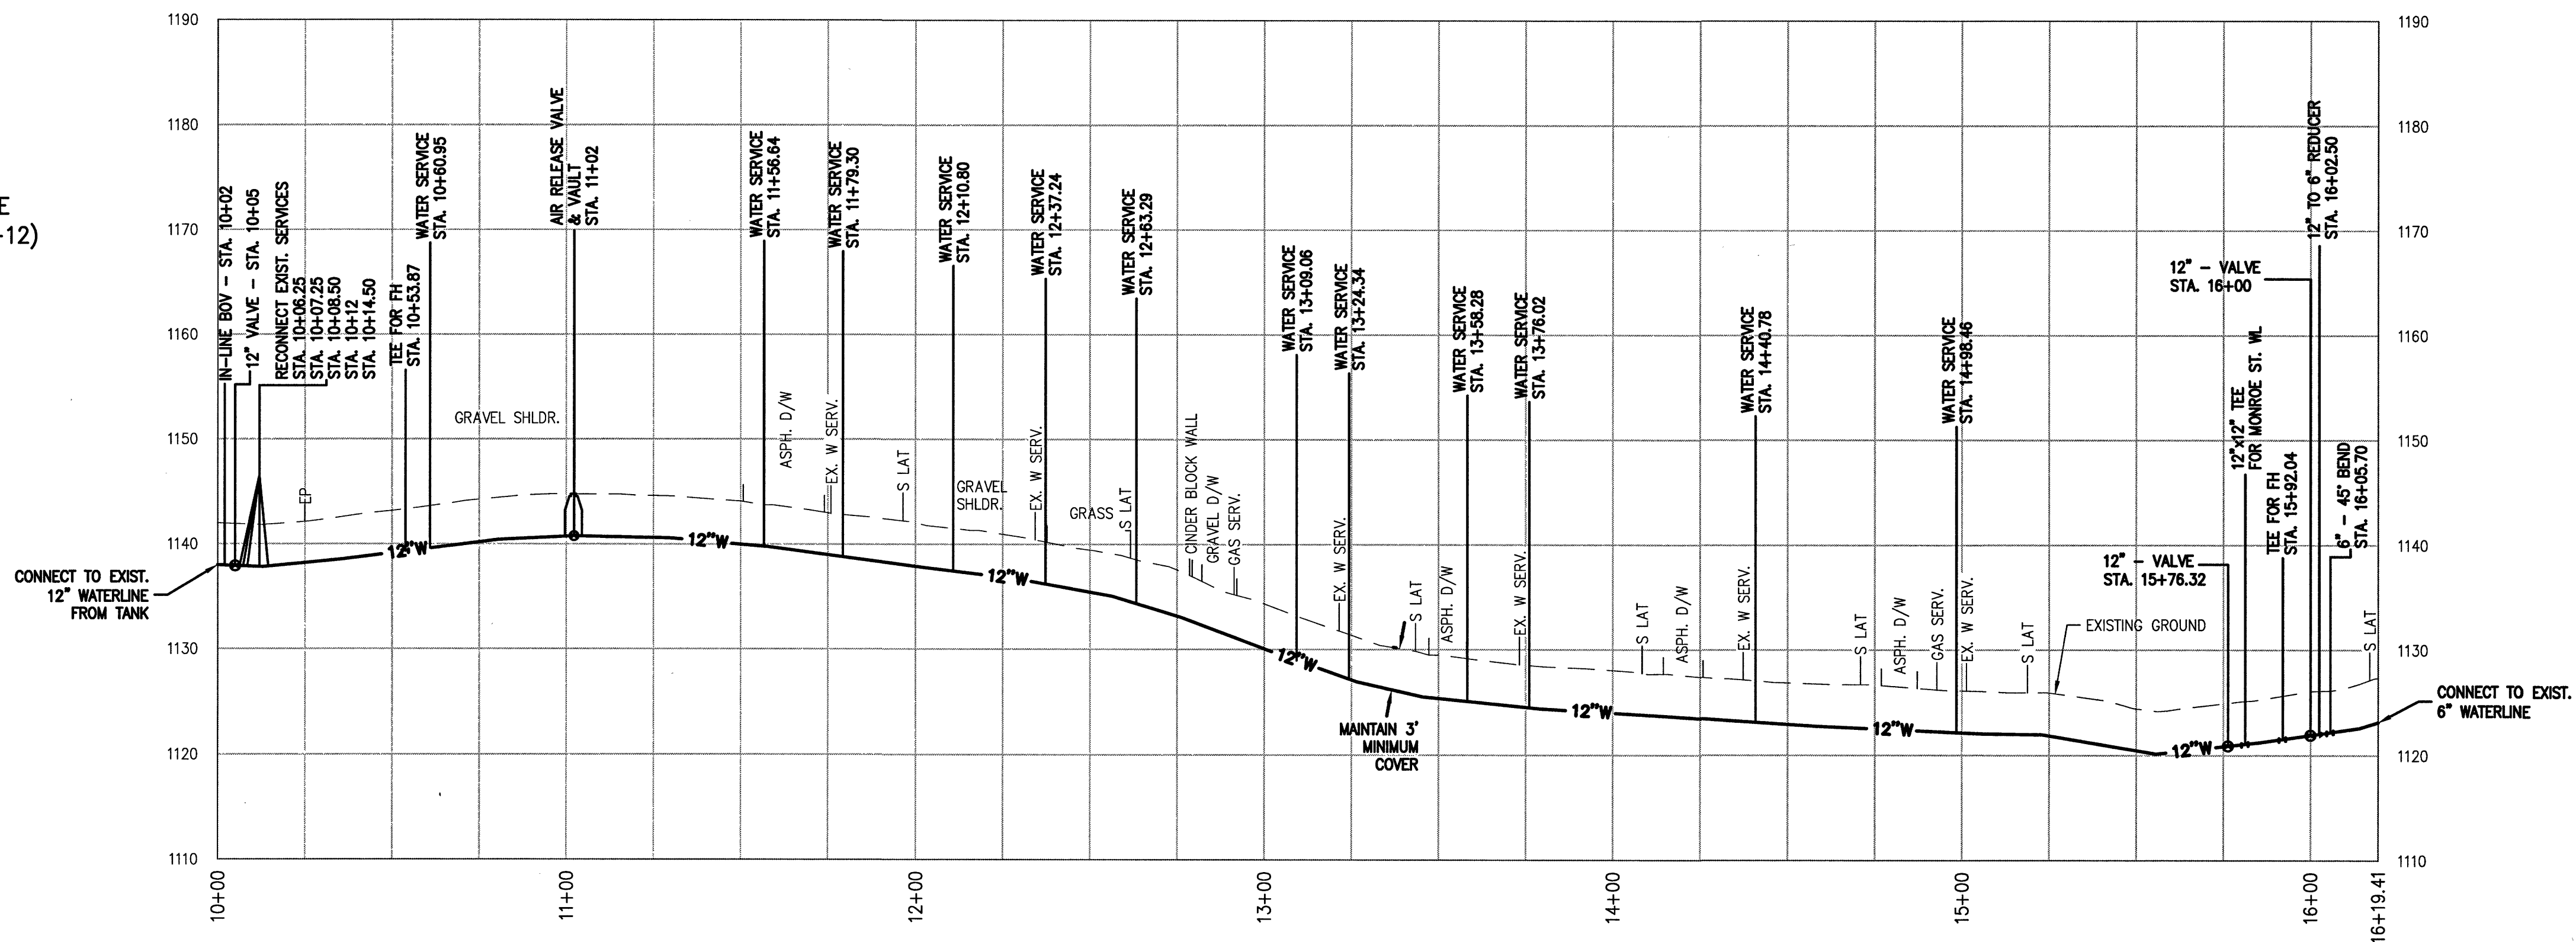

Date	
Revisions	

Issue Date:	MAR. 9, 2021
Drawn By:	RPK/MLO
Designed By:	RPK
Checked By:	BOC
Date:	3/9/21

Mattern & Craig
ENGINEERS/SURVEYORS
701 FIRST STREET, S.W.
ROANOKE, VIRGINIA 24016
(540) 346-9342
FAX (540) 346-7891

WASHINGTON HEIGHTS WATERLINE REPLACEMENT PHASE 2
PLAN AND PROFILE -
WYOMING AVE NW WATERLINE
ROANOKE, VIRGINIA

Vertical Scale:
1"=10'

Horizontal Scale:
1"=30'

Commission Number:
4095

Sheet No.:
11