


I:\4095 - Washington Heights Waterline Replacement\Drawings\4095 Design PH2.dwg, 3/9/2021 8:28:30 PM, MLC

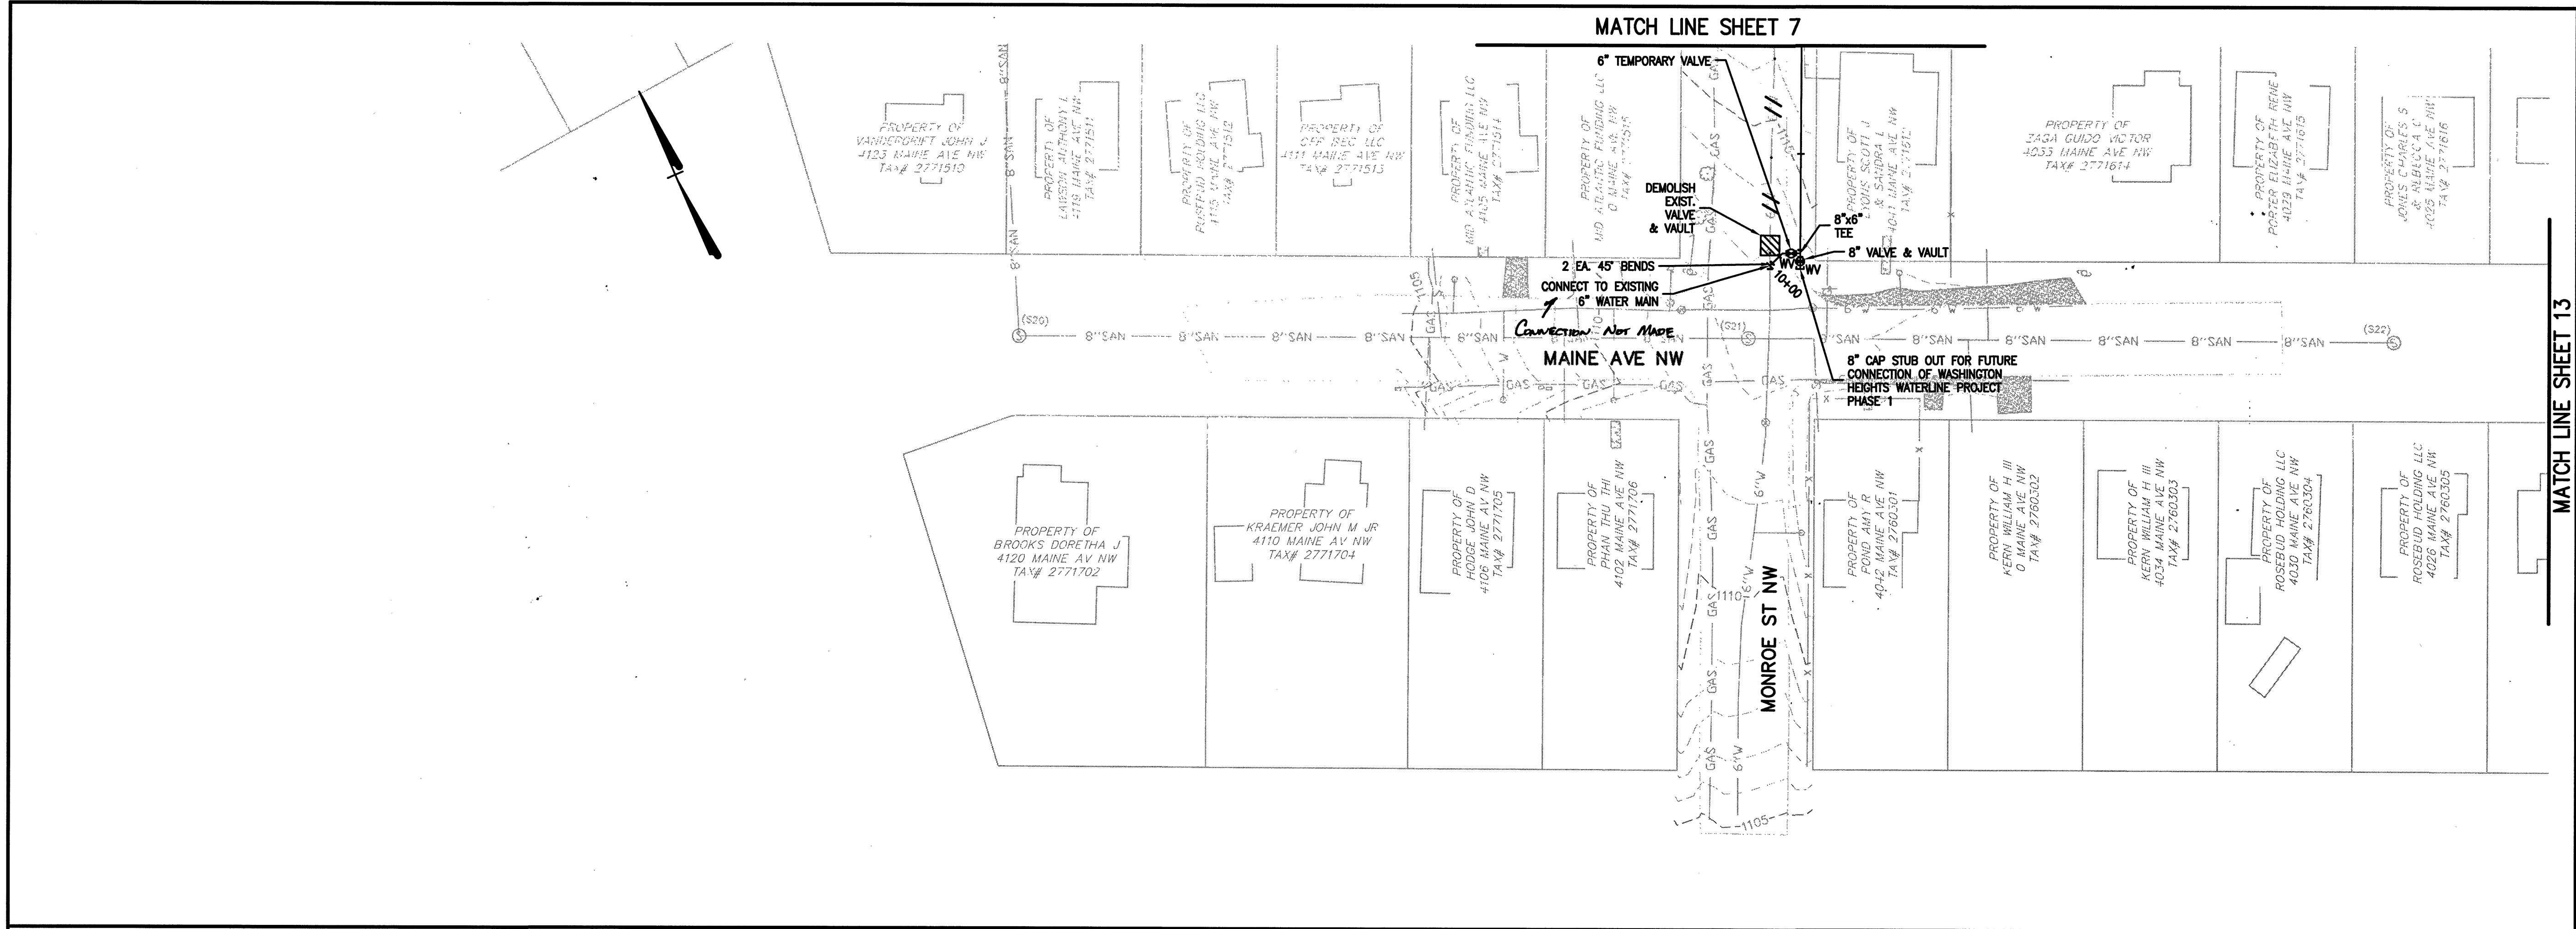

MATCH LINE SHEET 13





| Revisions | Date |
|-----------|------|
|           |      |
|           |      |
|              |              |
|--------------|--------------|
| Issue Date:  | MAR. 9, 2021 |
| Drawn By:    | RPK/MJC      |
| Designed By: | RPK          |
| Checked By:  | BCC          |
| Date:        | 3/9/21       |

**Matern & Craig**  
ENGINEERS-SURVEYORS  
701 FIRST STREET, S.W.  
ROANOKE, VIRGINIA 24016  
(540) 945-5642  
FAX (540) 545-1681

6 INCH & 8 INCH WATERLINE – MONROE ST.

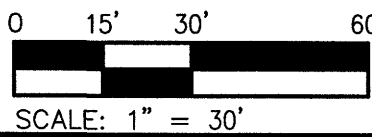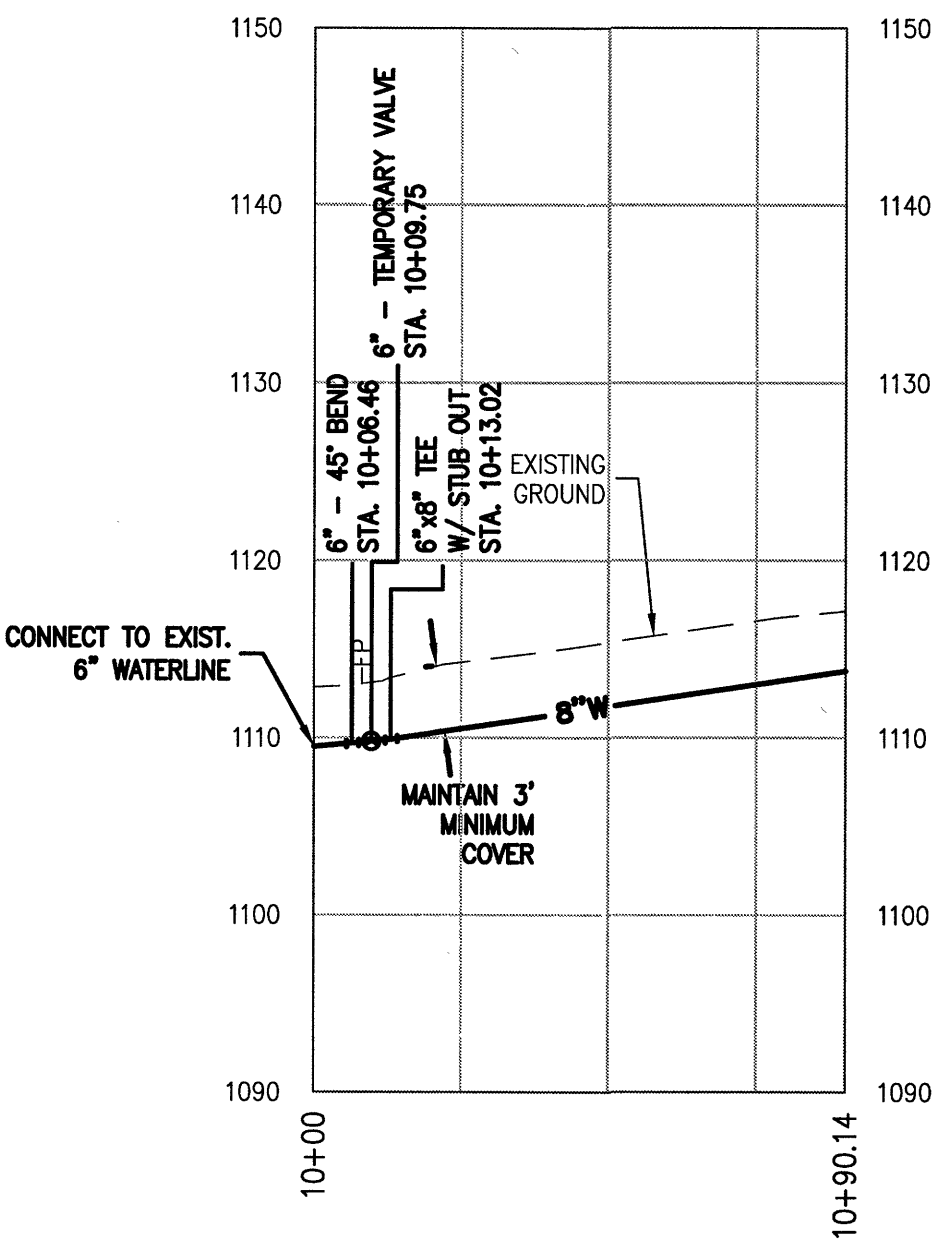

WASHINGTON HEIGHTS WATERLINE REPLACEMENT PHASE 2

PLAN AND PROFILE –

MONROE ST NW WATERLINE

ROANOKE, VIRGINIA

Vertical Scale:  
1"=10'

Horizontal Scale:  
1"=30'

Commission Number:  
4095

Sheet No.:  
12