



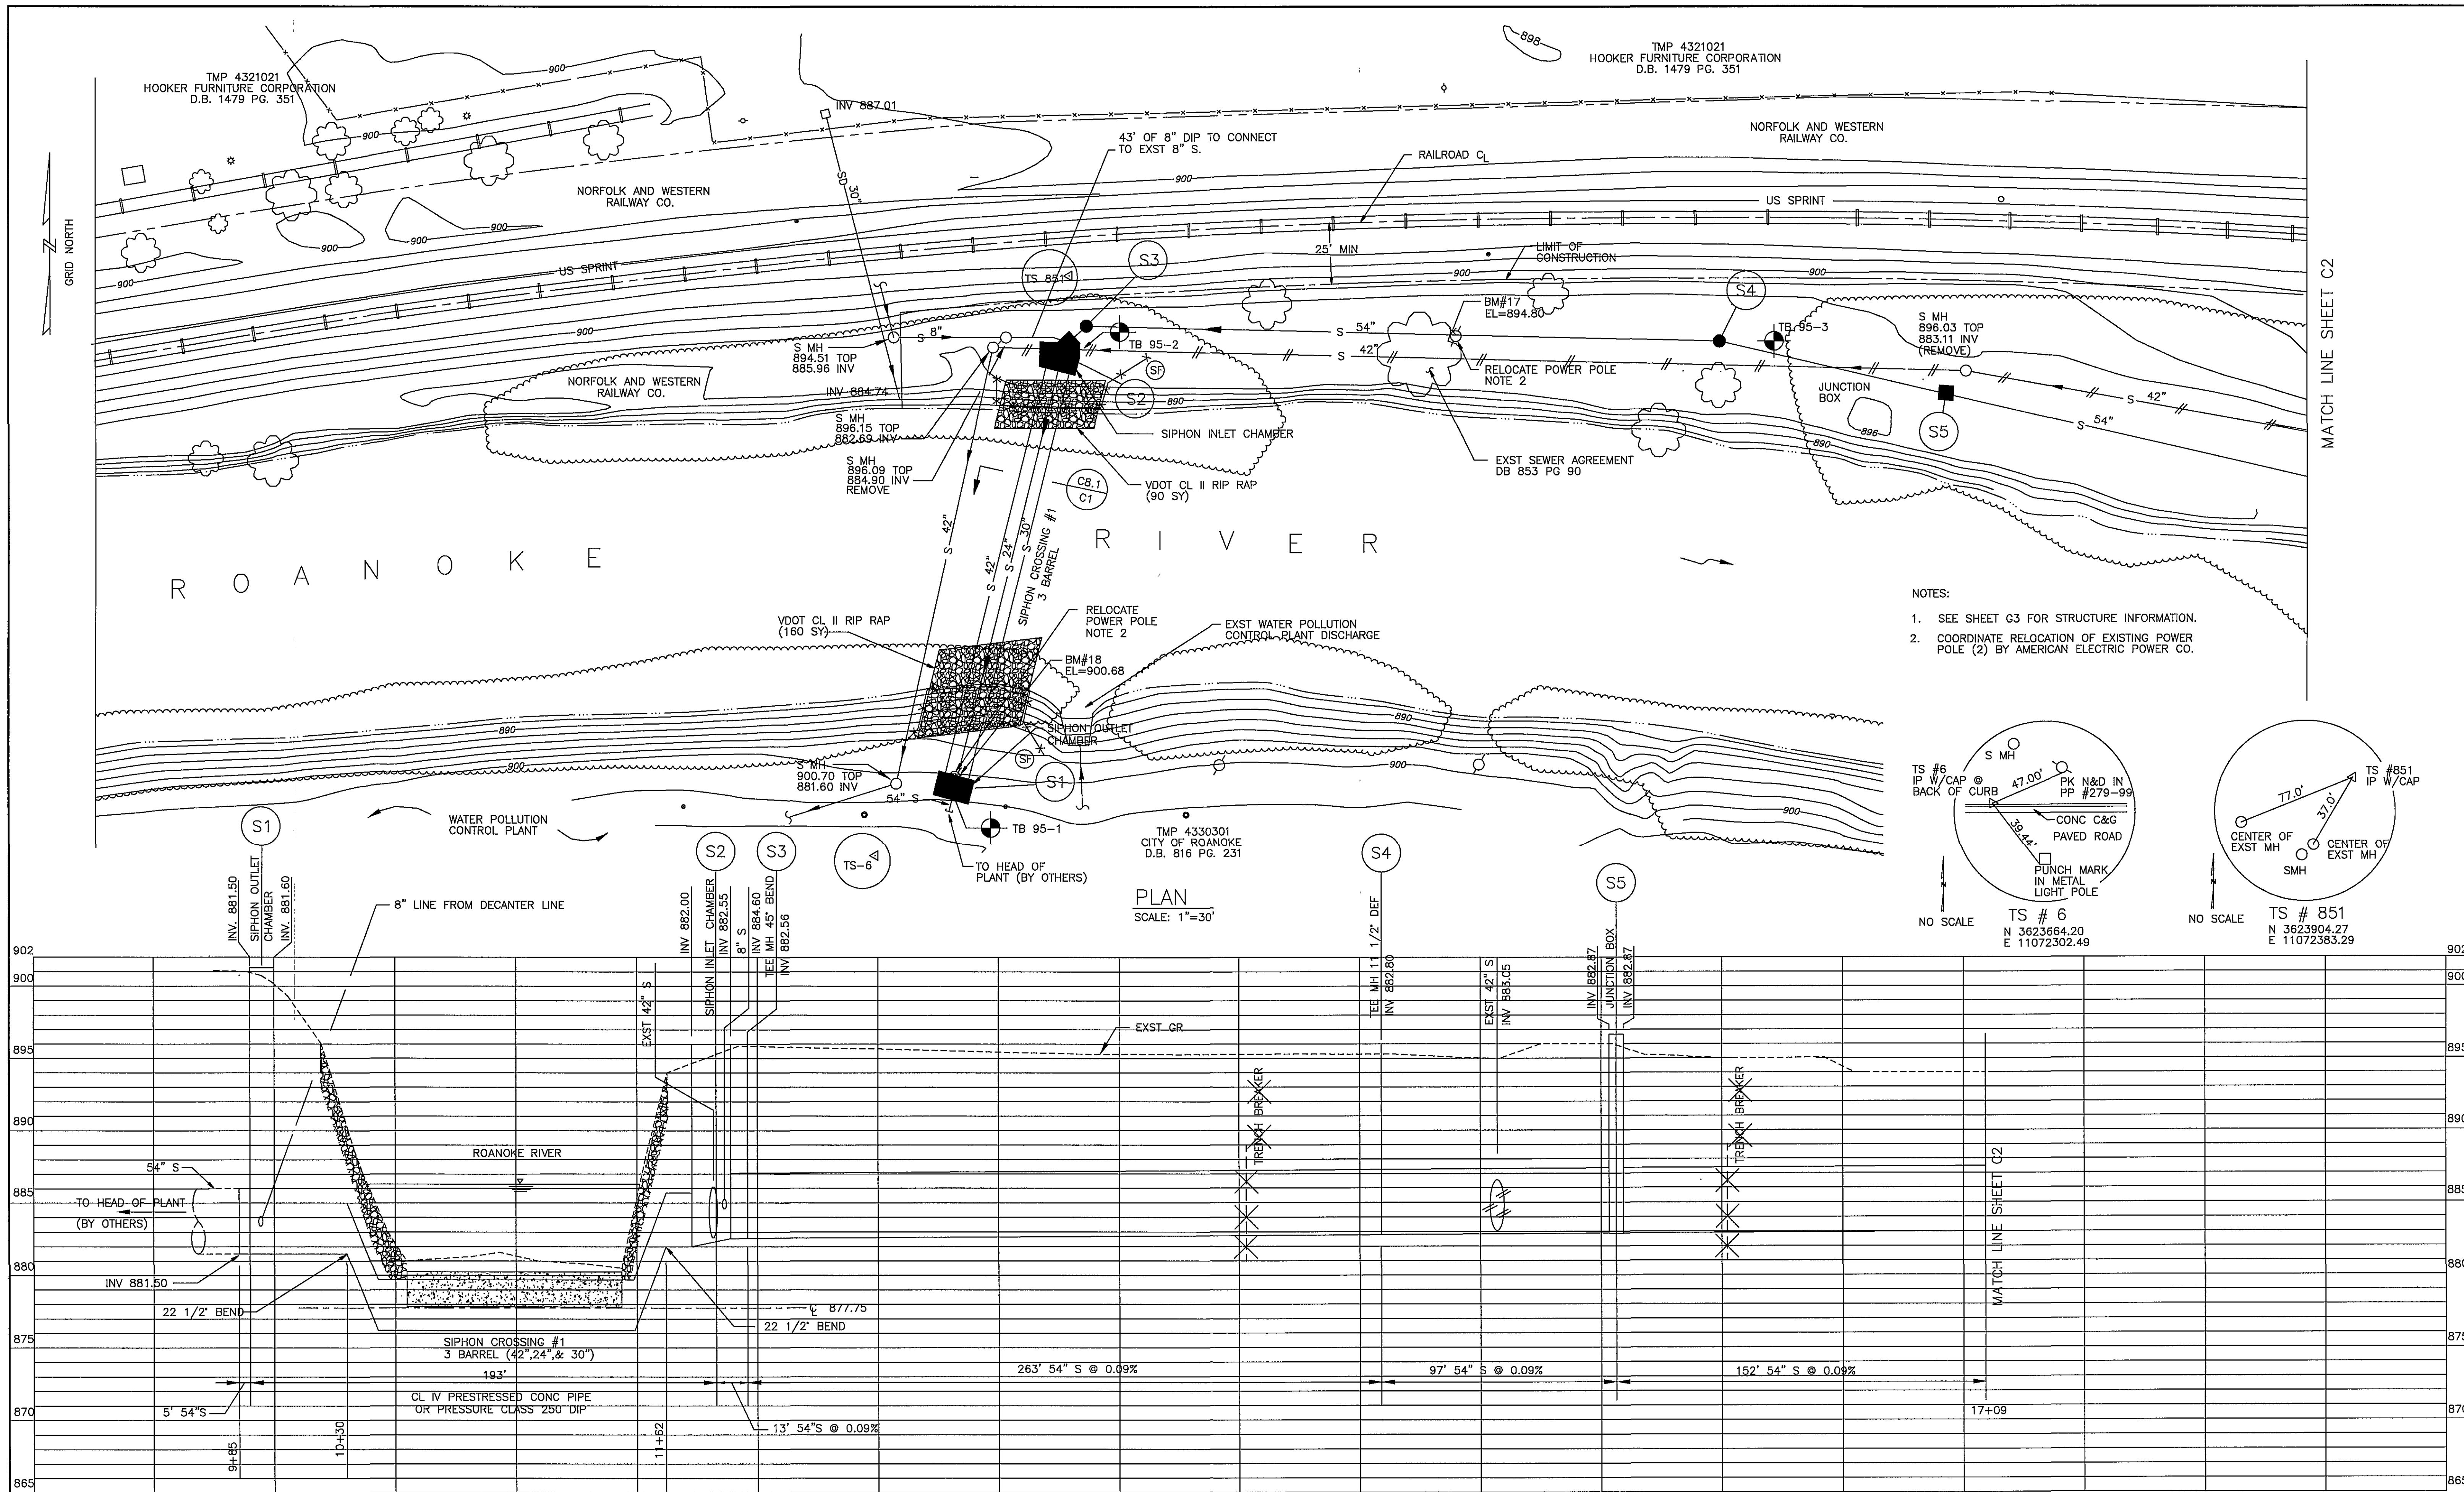

HAYES, SEAY, MATTERN & MATTERN, INC.
ARCHITECTS/ENGINEERS/PLANNERS
ROANOKE, VIRGINIA

DESIGNED: DMH	DATE	BY	REVISIONS
DRAWN: MHL	10/15/98	MNH	DESCRIPTION
CHECKED:			RECORD DRAWINGS SEE SHEET G1 FOR NOTE
APPROVED:			

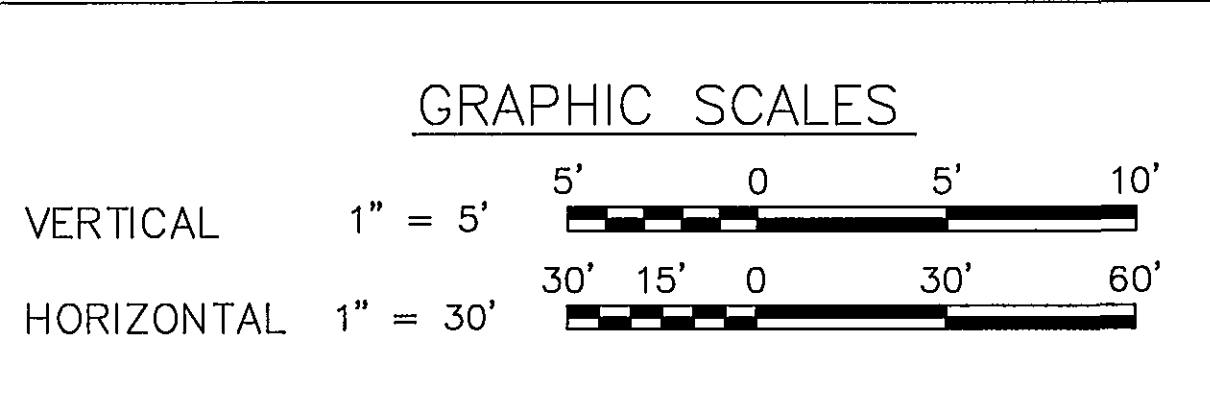

TINKER CREEK INTERCEPTOR SEWER
CITY OF ROANOKE, VIRGINIA

PLAN AND PROFILE
STA 9+85 TO STA 17+09

COMM. NO.: 7211 SCALE: AS NOTED DATE: MAY 17, 1996

PROJECT NO.: 6317
CONTRACT A
SHEET NO.
C1
RECORD DRAWINGS