
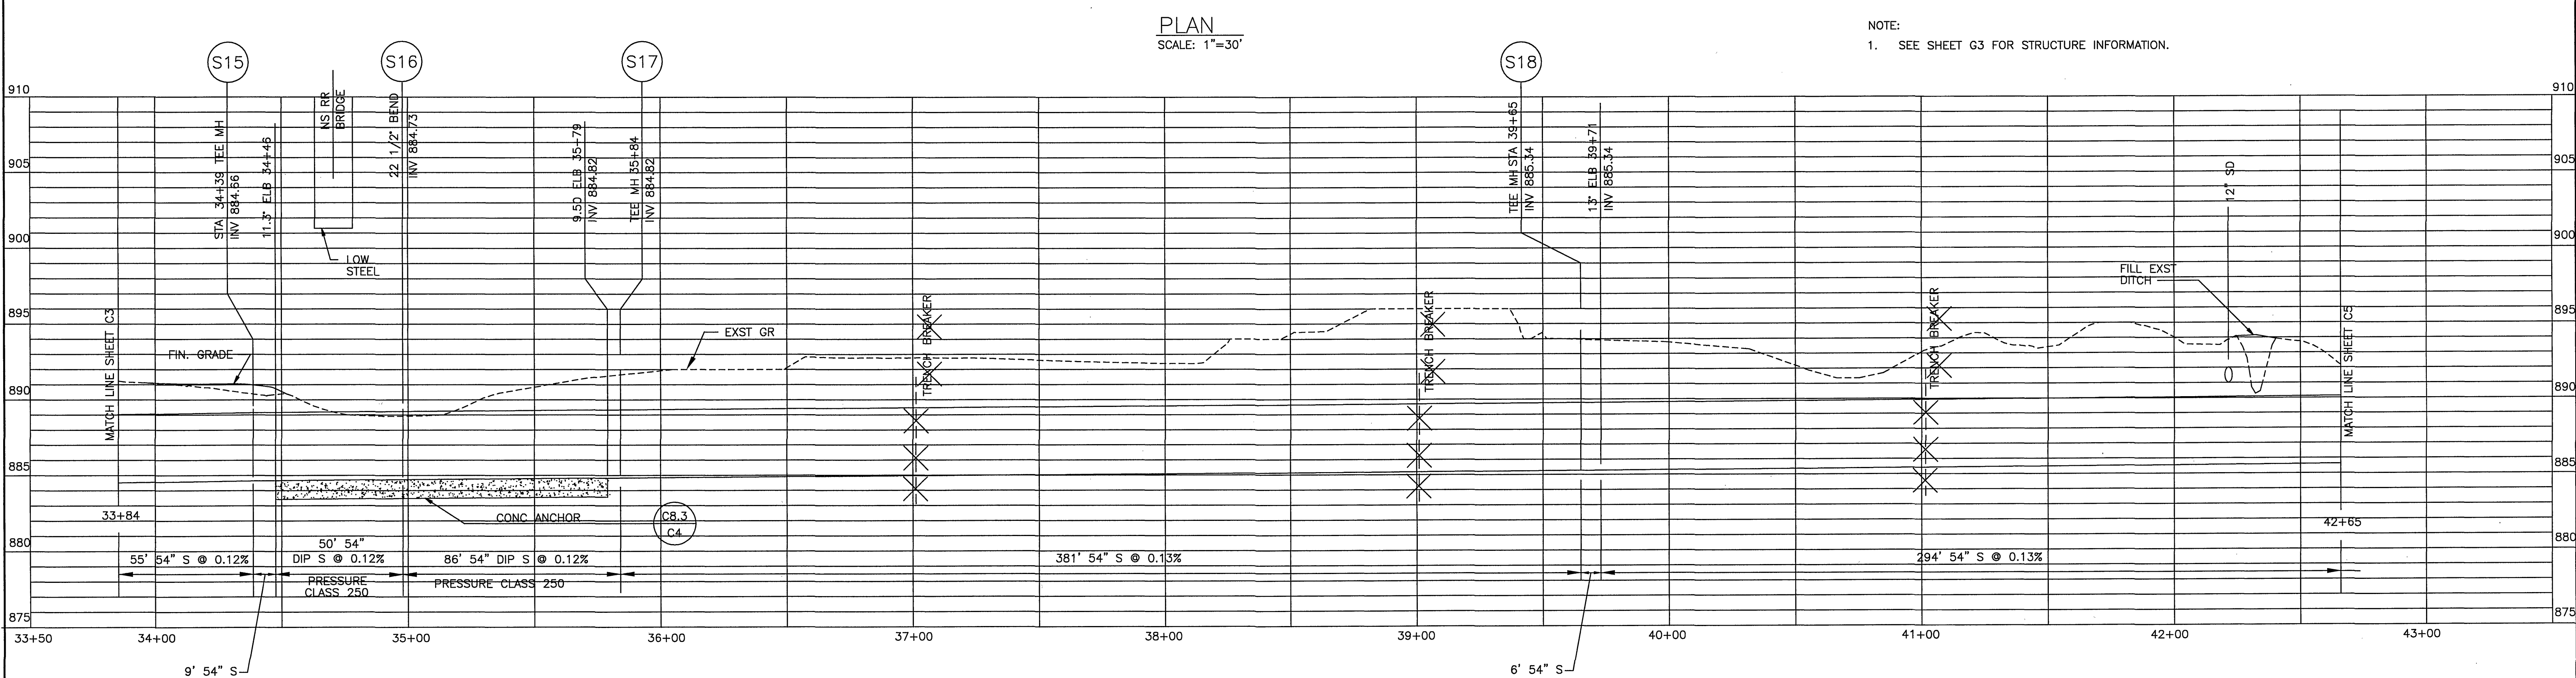


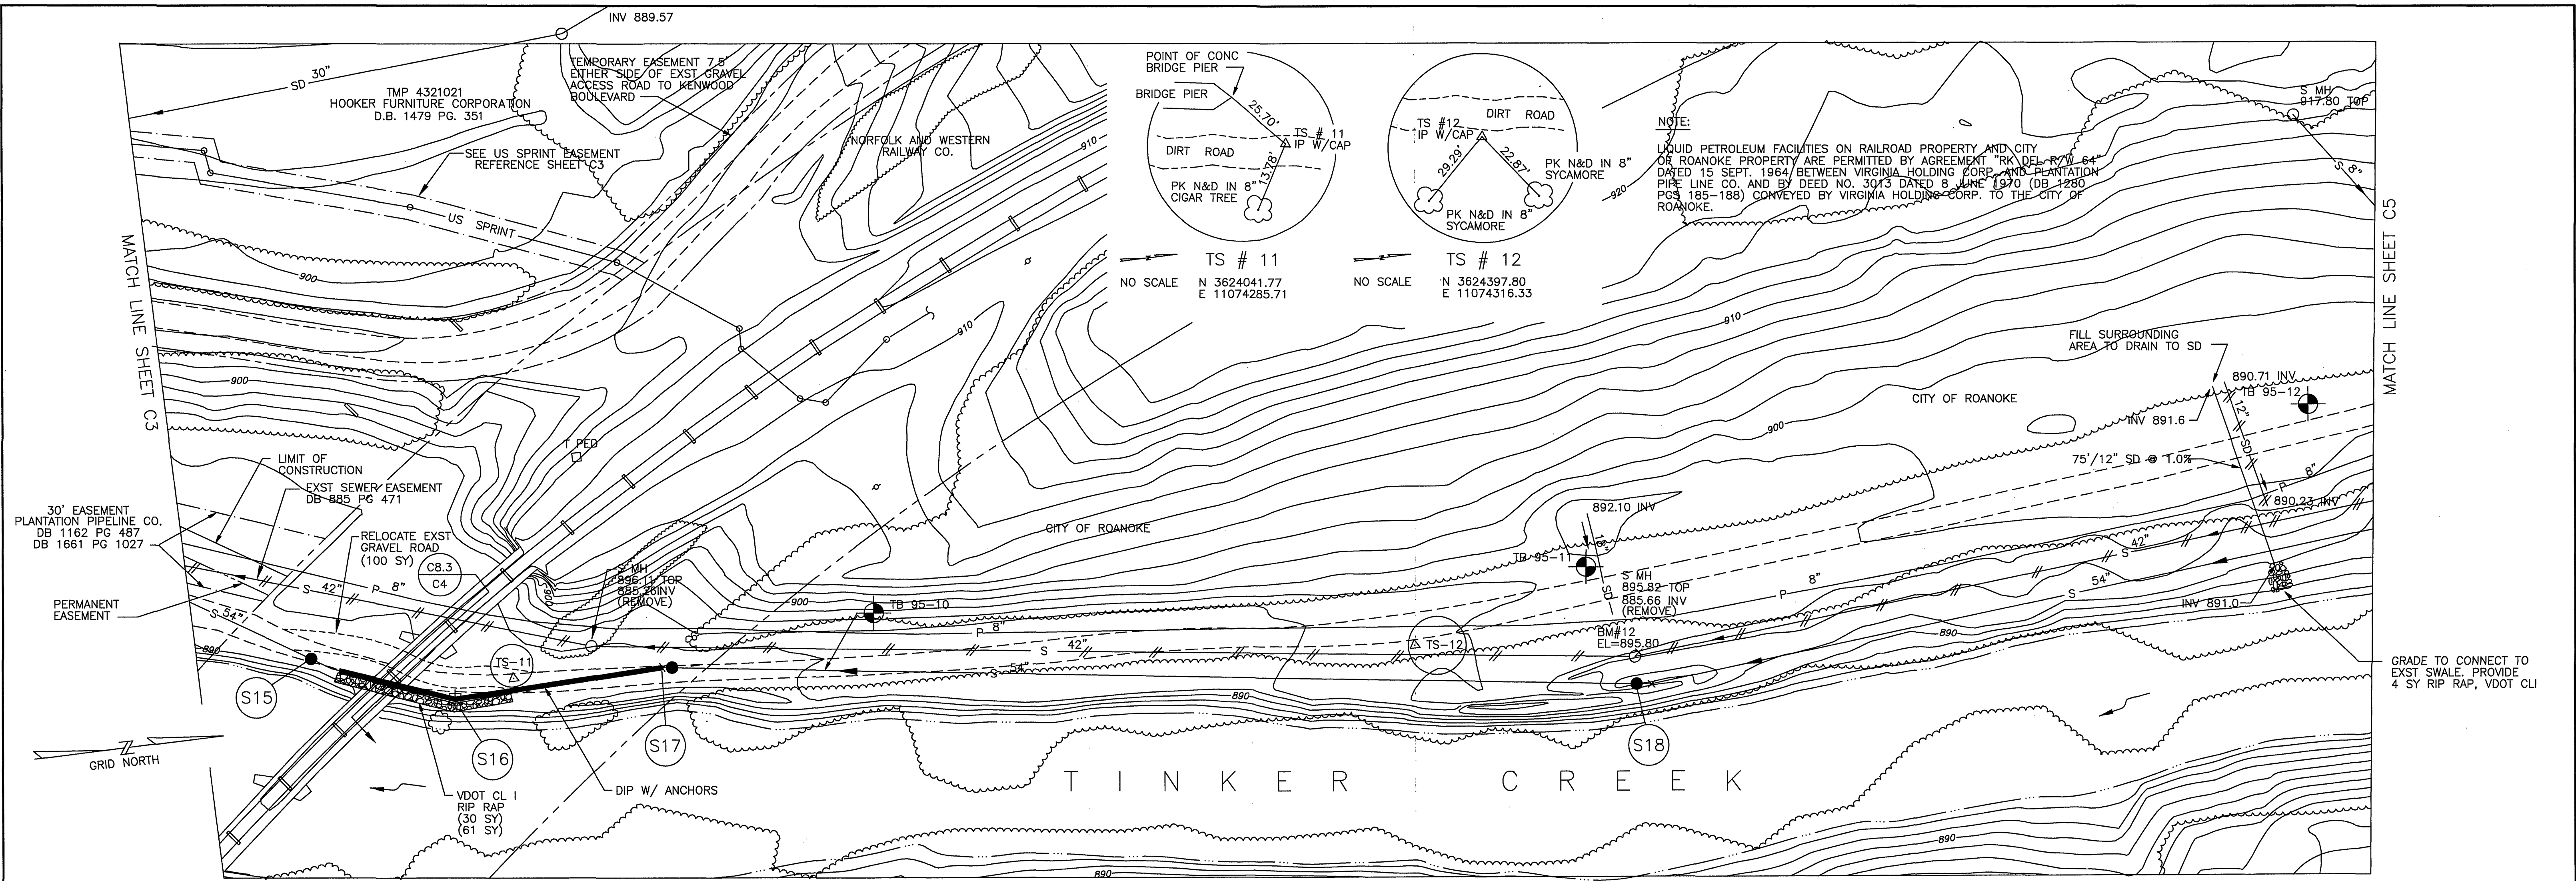

HAYES, SEAY, MATTERN & MATTERN, INC. ARCHITECTS/ENGINEERS/PLANNERS ROANOKE, VIRGINIA	DESIGNED: DMH	DATE	BY	REVISIONS
	DRAWN: MHL	2/3/97	DMH	ALIGNMENT REVISED BETWEEN S18 AND S20
	CHECKED:	10/15/98	MNH	RECORD DRAWINGS SEE SHEET G1 FOR NOTE
	APPROVED:			
GRAPHIC SCALES VERTICAL 1" = 5' HORIZONTAL 1" = 30'				
TINKER CREEK INTERCEPTOR SEWER CITY OF ROANOKE, VIRGINIA PLAN AND PROFILE STA 33+84 TO STA 42+65				
COMM. NO.: 7211 SCALE: AS NOTED DATE: MAY 17, 1996				
PROJECT NO.: 6317 CONTRACT A SHEET NO. C4 RECORD DRAWINGS				