


NOTE:


LIQUID PETROLEUM FACILITIES ON RAILROAD PROPERTY AND CITY OF ROANOKE PROPERTY ARE PERMITTED BY AGREEMENTS "RK DEL R/W 66" AND "VA RK DEL R/W 65" DATED 15 SEPT. 1964 BETWEEN VIRGINIA HOLDING CORP. AND PLANTATION PIPE LINE CO. AND BY DEED NO. 3013 DATED 8 JUNE 1970 (DB 1280 PGS 185-188) CONVEYED BY VIRGINIA HOLDING CORP. TO THE CITY OF ROANOKE.

NOTE:


1. SEE SHEET G3 FOR STRUCTURE INFORMATION.

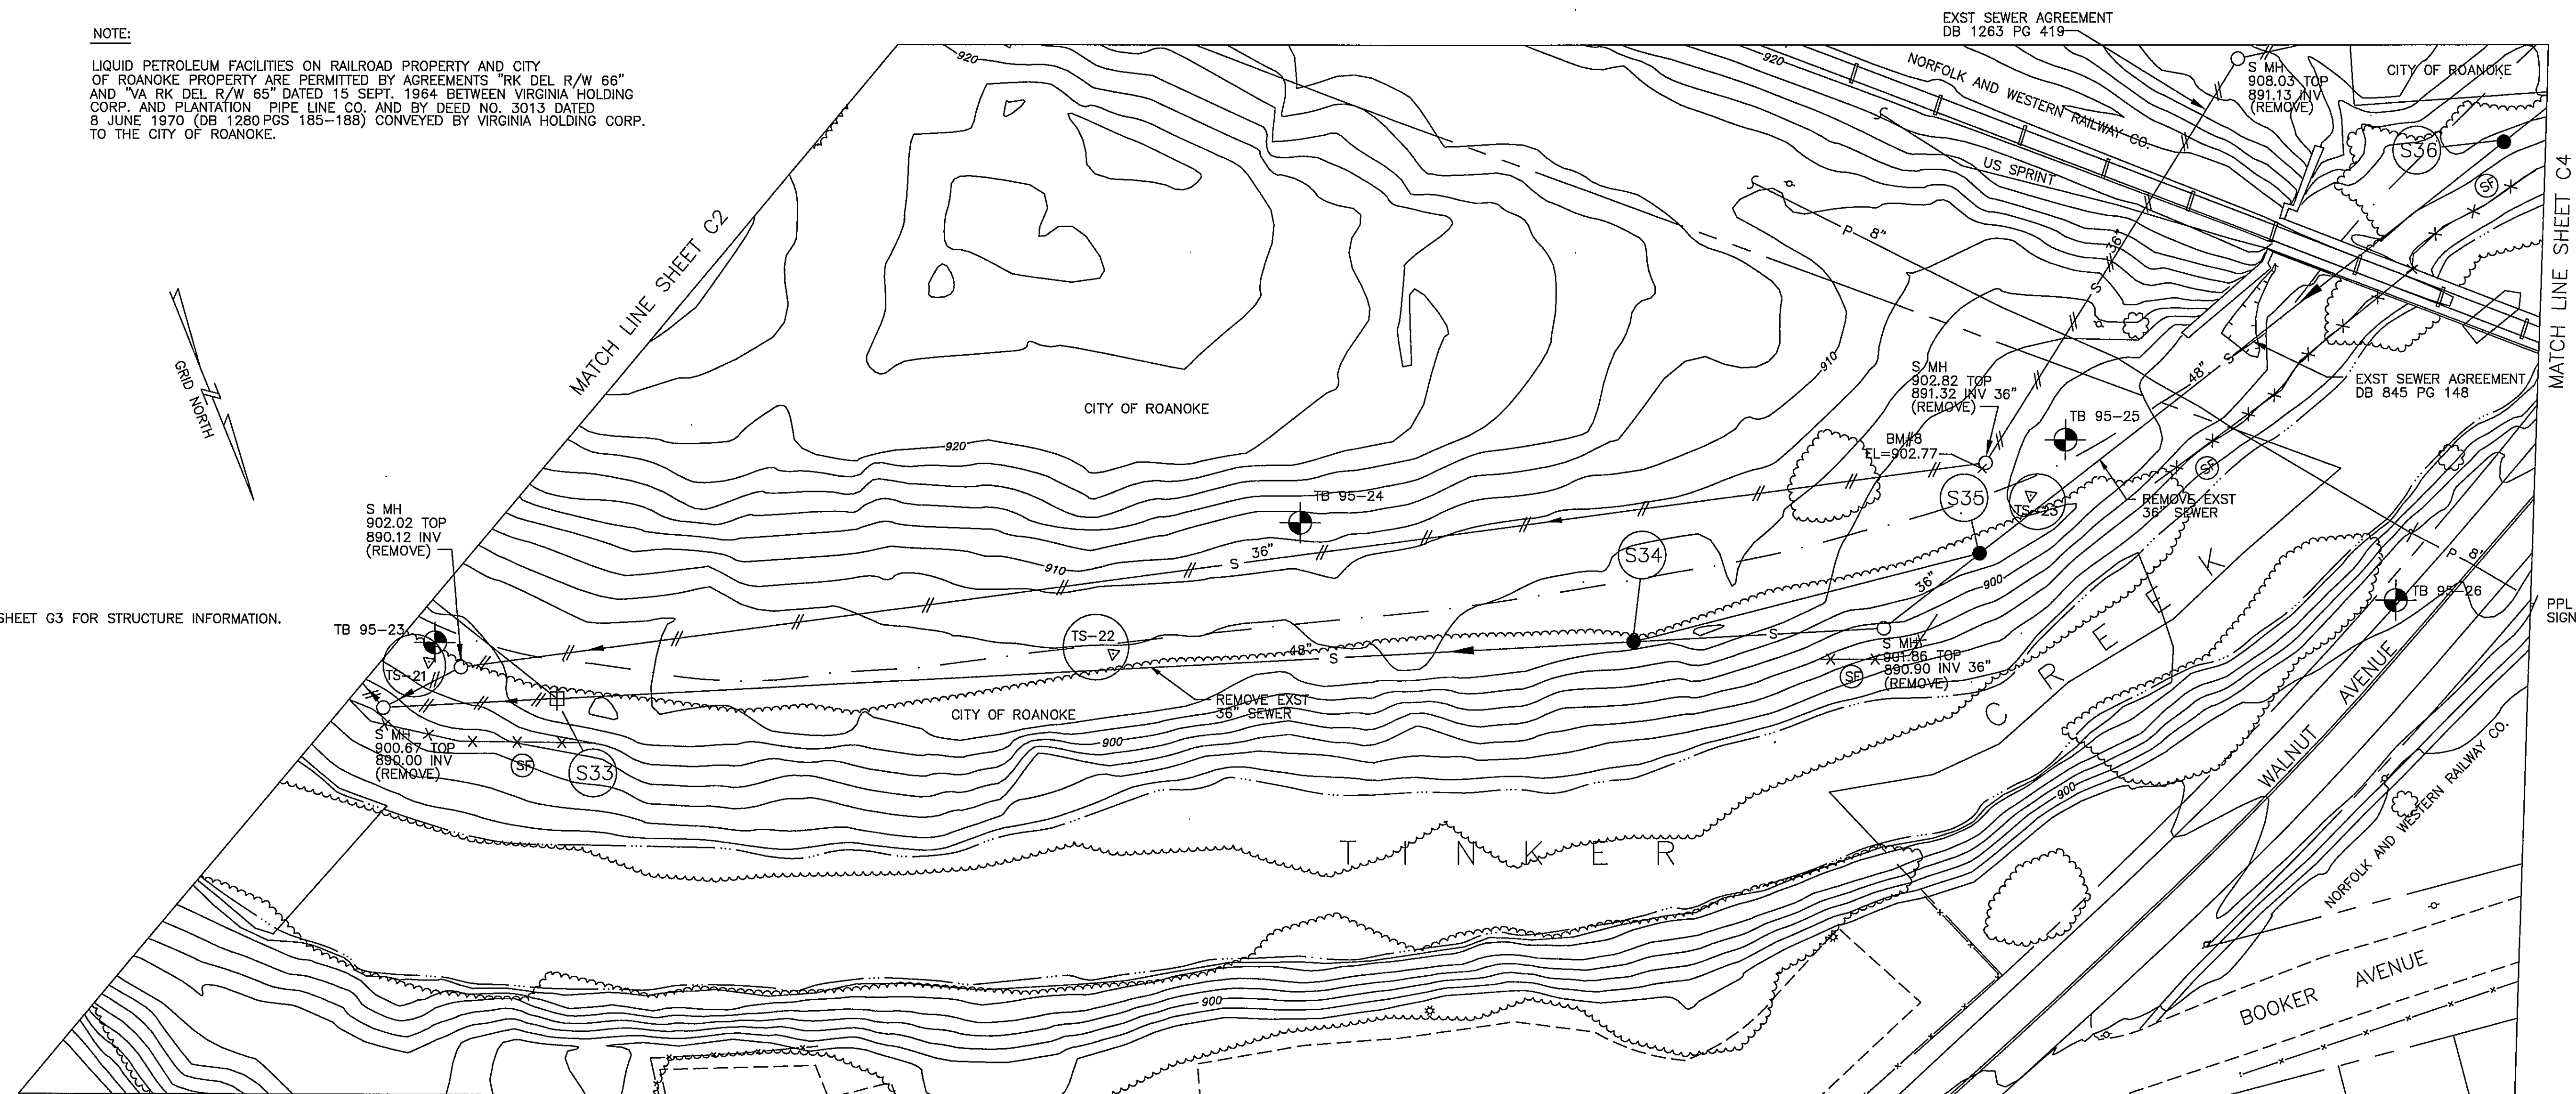


PLAN
SCALE: 1" = 30'

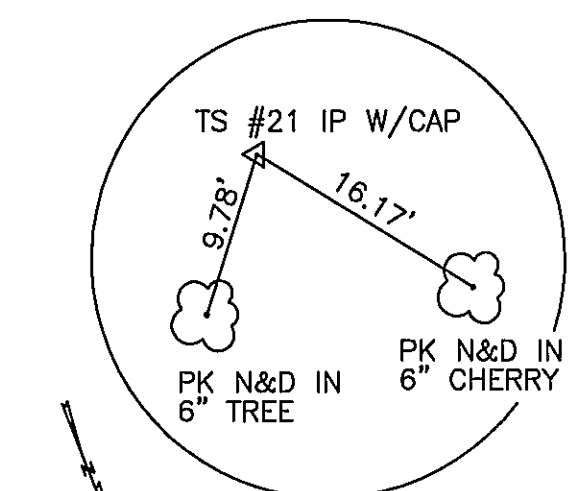


NO SCALE
TS # 21
N 3627737.39
E 11072857.39

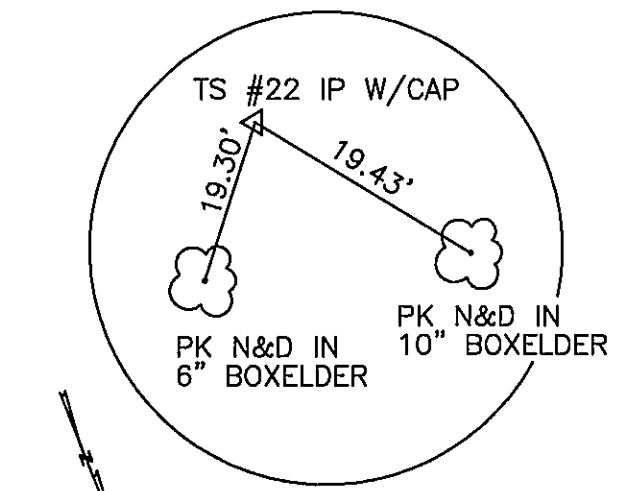

NO SCALE
TS # 22
N 3627820.35
E 11072642.96

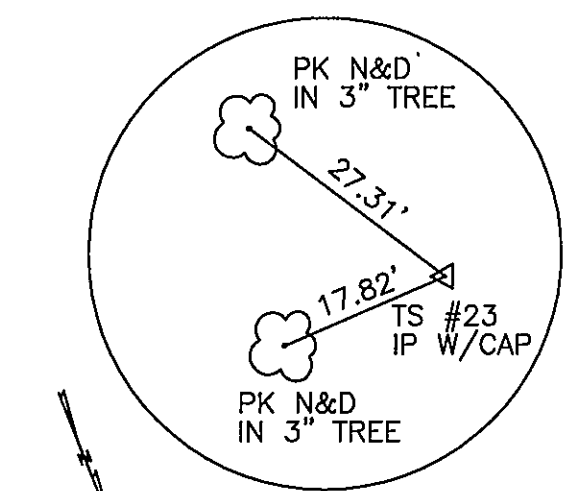

NO SCALE
TS # 23
N 3627886.04
E 11072336.88

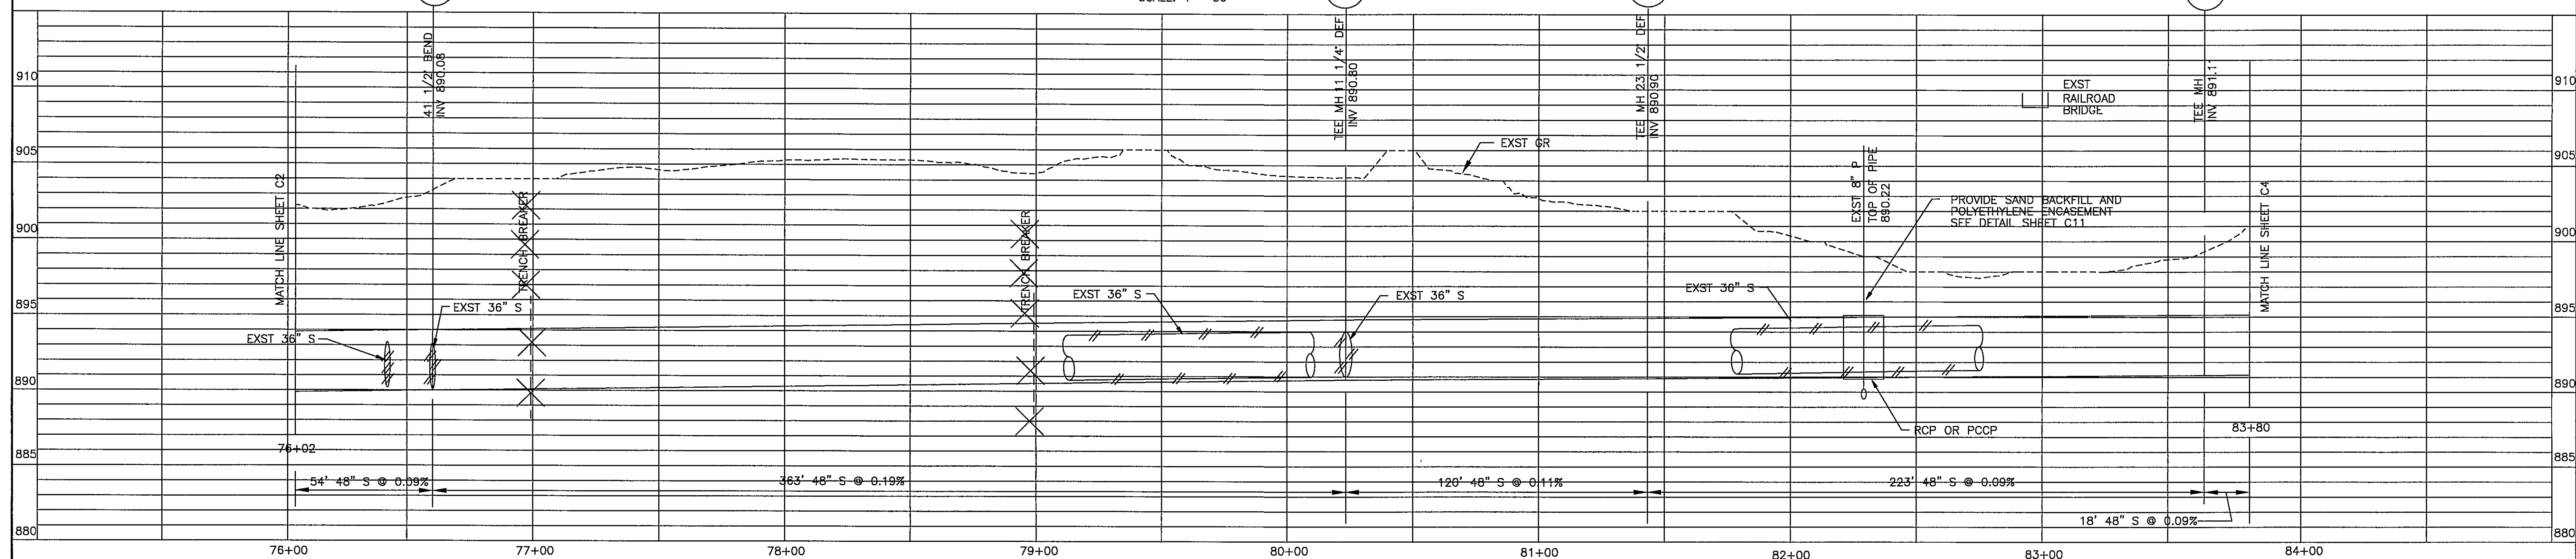

HAYES, SEAY, MATTERN & MATTERN, INC.
ARCHITECTS/ENGINEERS/PLANNERS
ROANOKE, VIRGINIA

DESIGNED: DMH
DRAWN: MHL
CHECKED:
APPROVED:

REVISIONS
DATE BY DESCRIPTION
10/15/98 MNH RECORD DRAWINGS SEE SHEET G1 FOR NOTE

GRAPHIC SCALES

VERTICAL

1" = 5'

HORIZONTAL

1" = 30'

TINKER CREEK INTERCEPTOR SEWER
CITY OF ROANOKE, VIRGINIA

PLAN AND PROFILE
STA 76+02 TO STA 83+80

COMM. NO.: 7211

SCALE: AS NOTED

DATE: MAY 17, 1996

PROJECT NO.: 6317

CONTRACT B

SHEET NO.

C3

RECORD DRAWINGS