
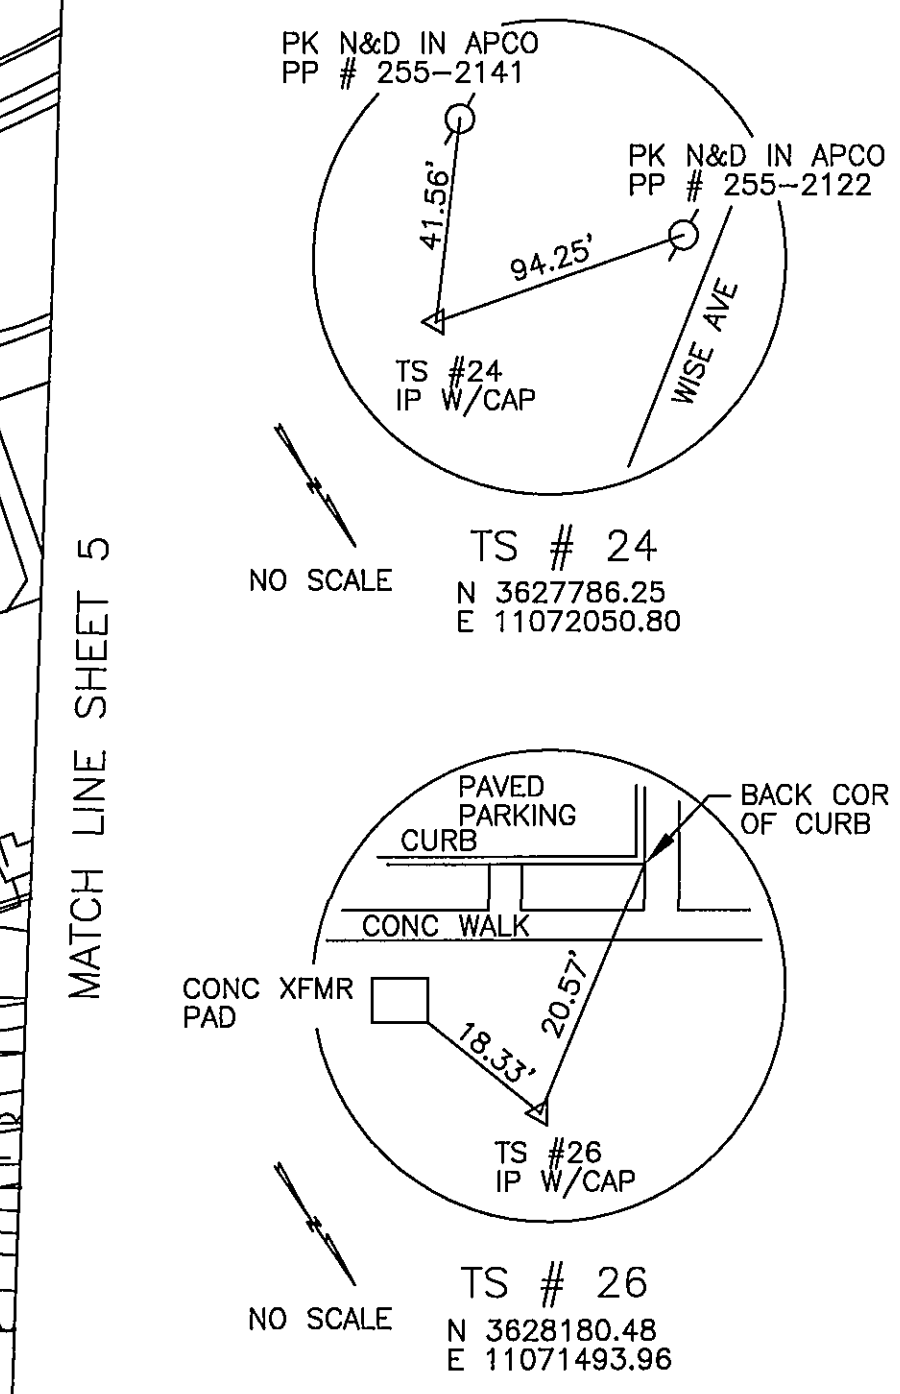
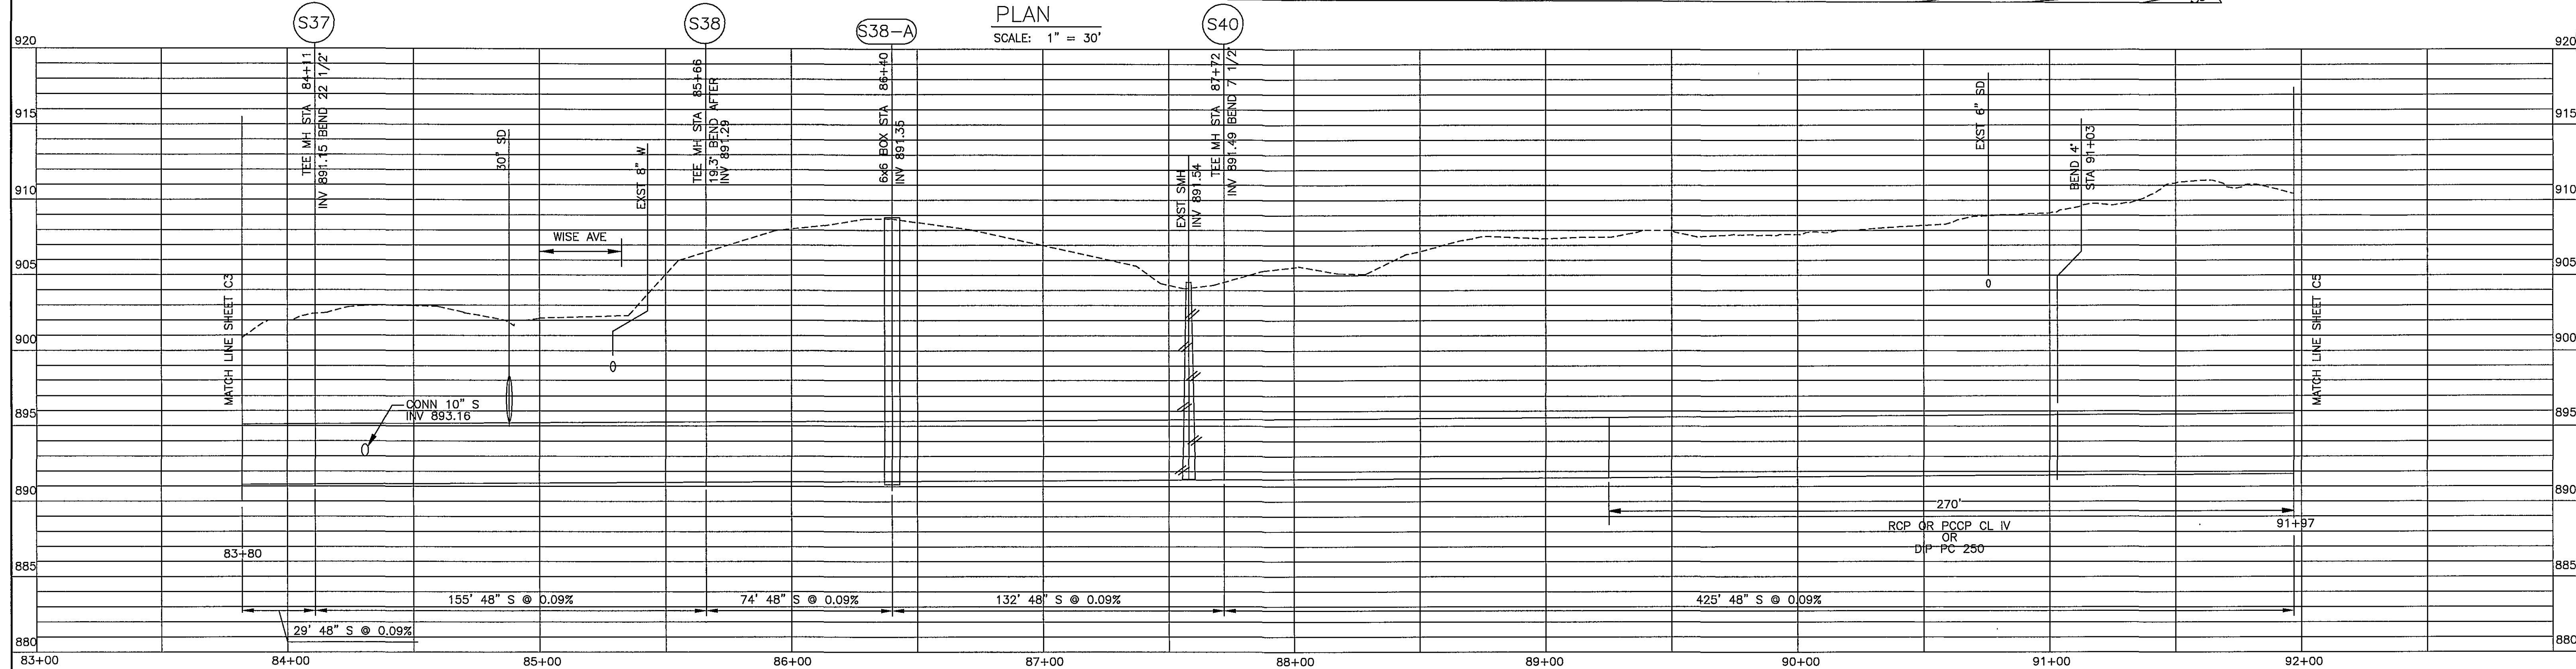


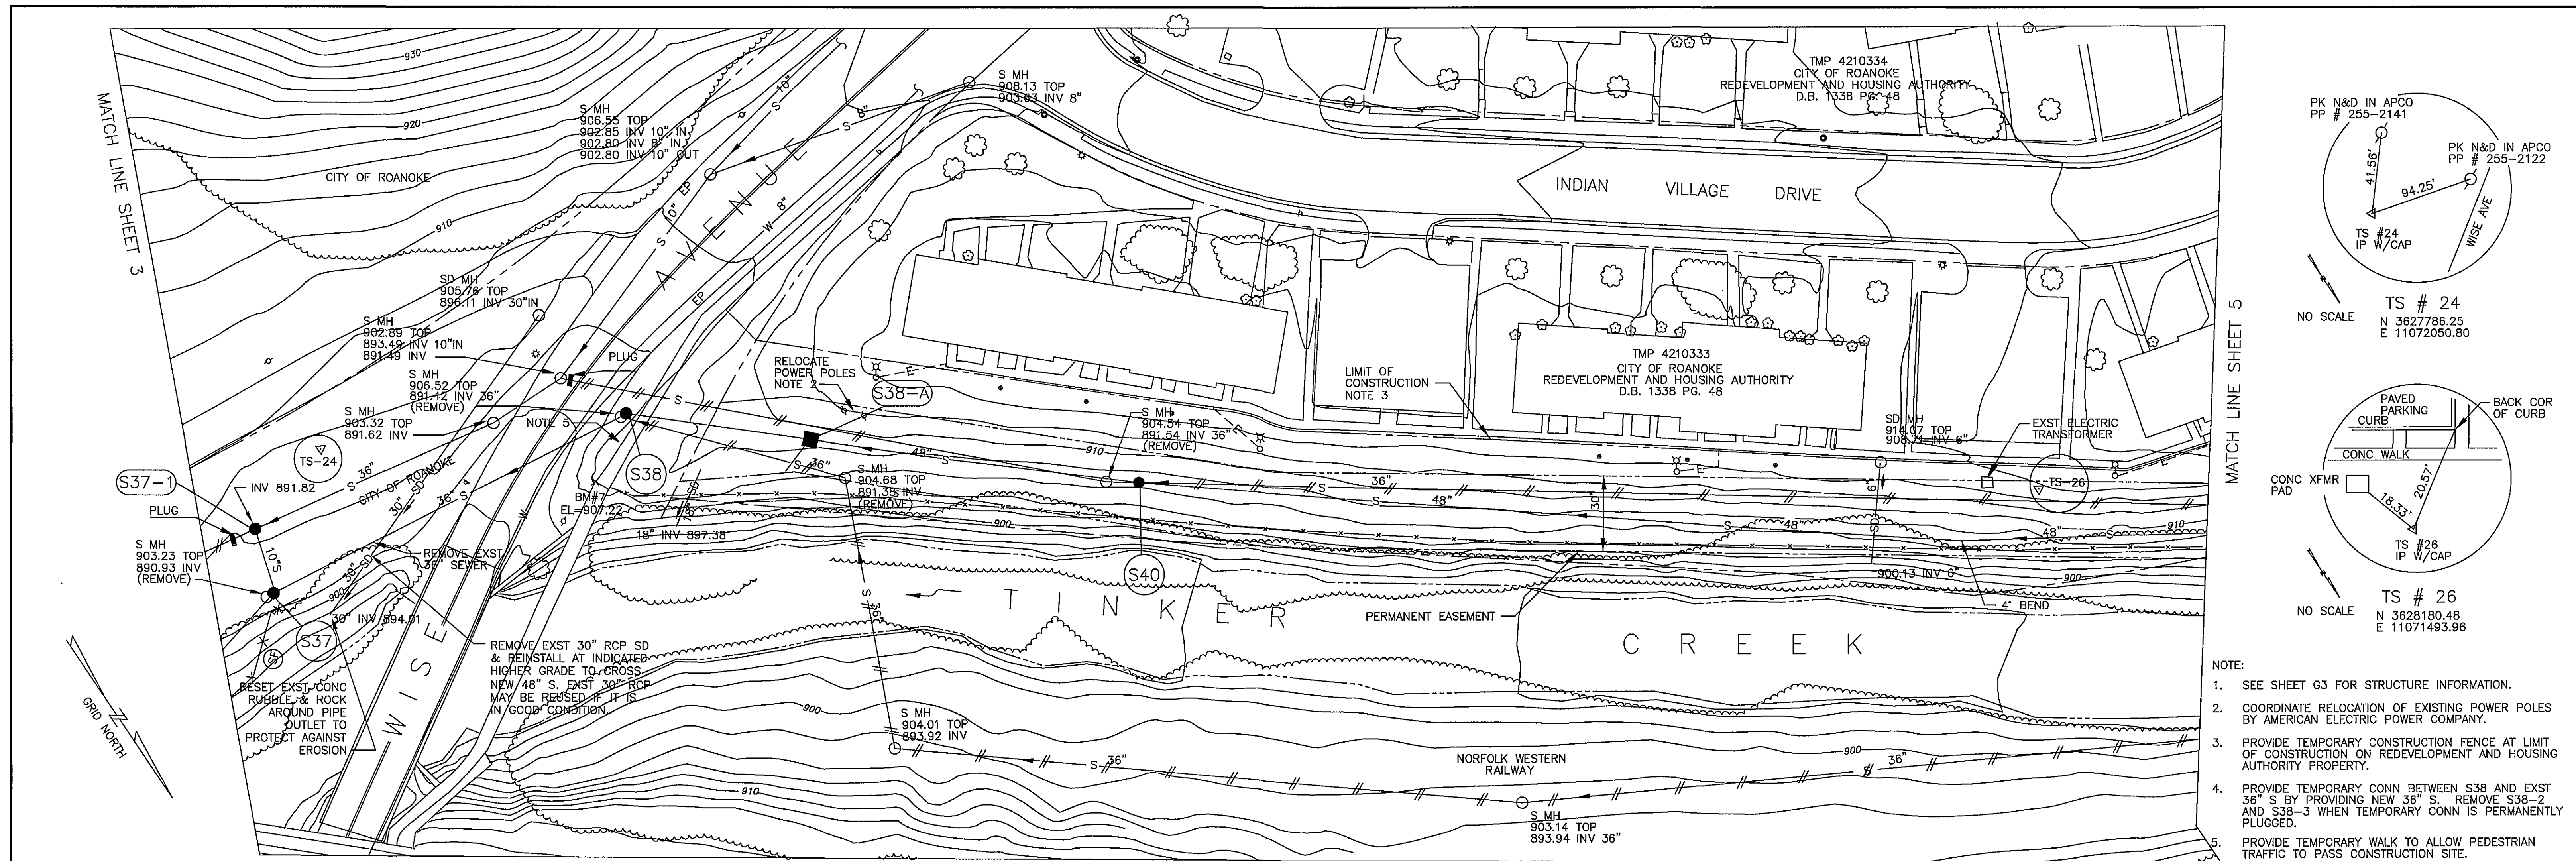

- NOTE:
- SEE SHEET G3 FOR STRUCTURE INFORMATION.
 - COORDINATE RELOCATION OF EXISTING POWER POLES BY AMERICAN ELECTRIC POWER COMPANY.
 - PROVIDE TEMPORARY CONSTRUCTION FENCE AT LIMIT OF CONSTRUCTION ON REDEVELOPMENT AND HOUSING AUTHORITY PROPERTY.
 - PROVIDE TEMPORARY CONN BETWEEN S38 AND EXST 36" S BY PROVIDING NEW 36" S. REMOVE S38-2 AND S38-3 WHEN TEMPORARY CONN IS PERMANENTLY PLUGGED.
 - PROVIDE TEMPORARY WALK TO ALLOW PEDESTRIAN TRAFFIC TO PASS CONSTRUCTION SITE.

HAYES, SEAY, MATTERN & MATTERN, INC. ARCHITECTS/ENGINEERS/PLANNERS ROANOKE, VIRGINIA	DESIGNED: DMH	DATE	BY	REVISIONS		GRAPHIC SCALES VERTICAL 1" = 5'  HORIZONTAL 1" = 30' 	TINKER CREEK INTERCEPTOR SEWER CITY OF ROANOKE, VIRGINIA			PROJECT NO.: 6317
	DRAWN: MHL	10/15/98	MNH	RECORD DRAWINGS SEE SHEET G1 FOR NOTE			PLAN AND PROFILE STA 83+80 TO STA 91+97			CONTRACT B
	CHECKED:									SHEET NO.
	APPROVED:									C4
										RECORD DRAWINGS