

 


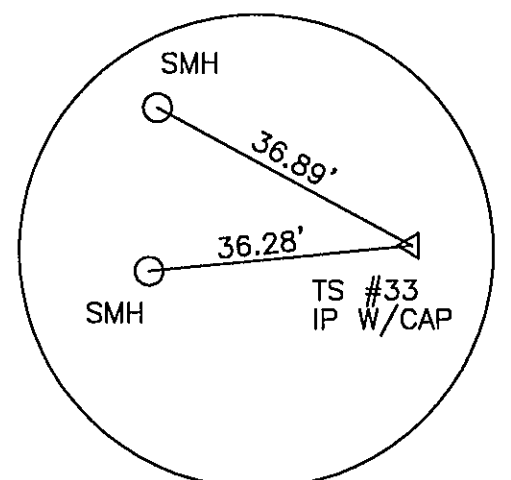


NO SCALE TS # 33
N 3629264.82
E 11070627.10

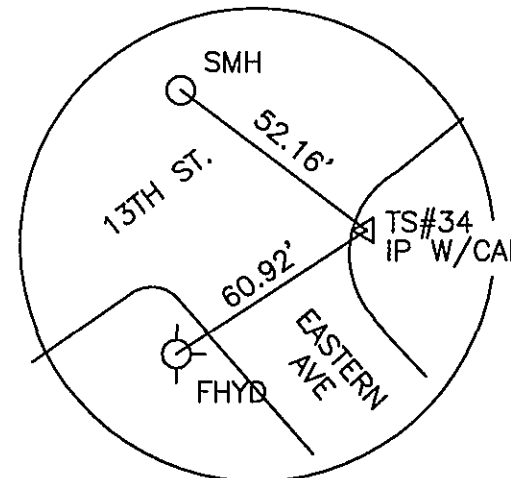

NO SCALE TS # 34
N 3629589.36
E 11070516.89




MATCH LINE SHEET C6

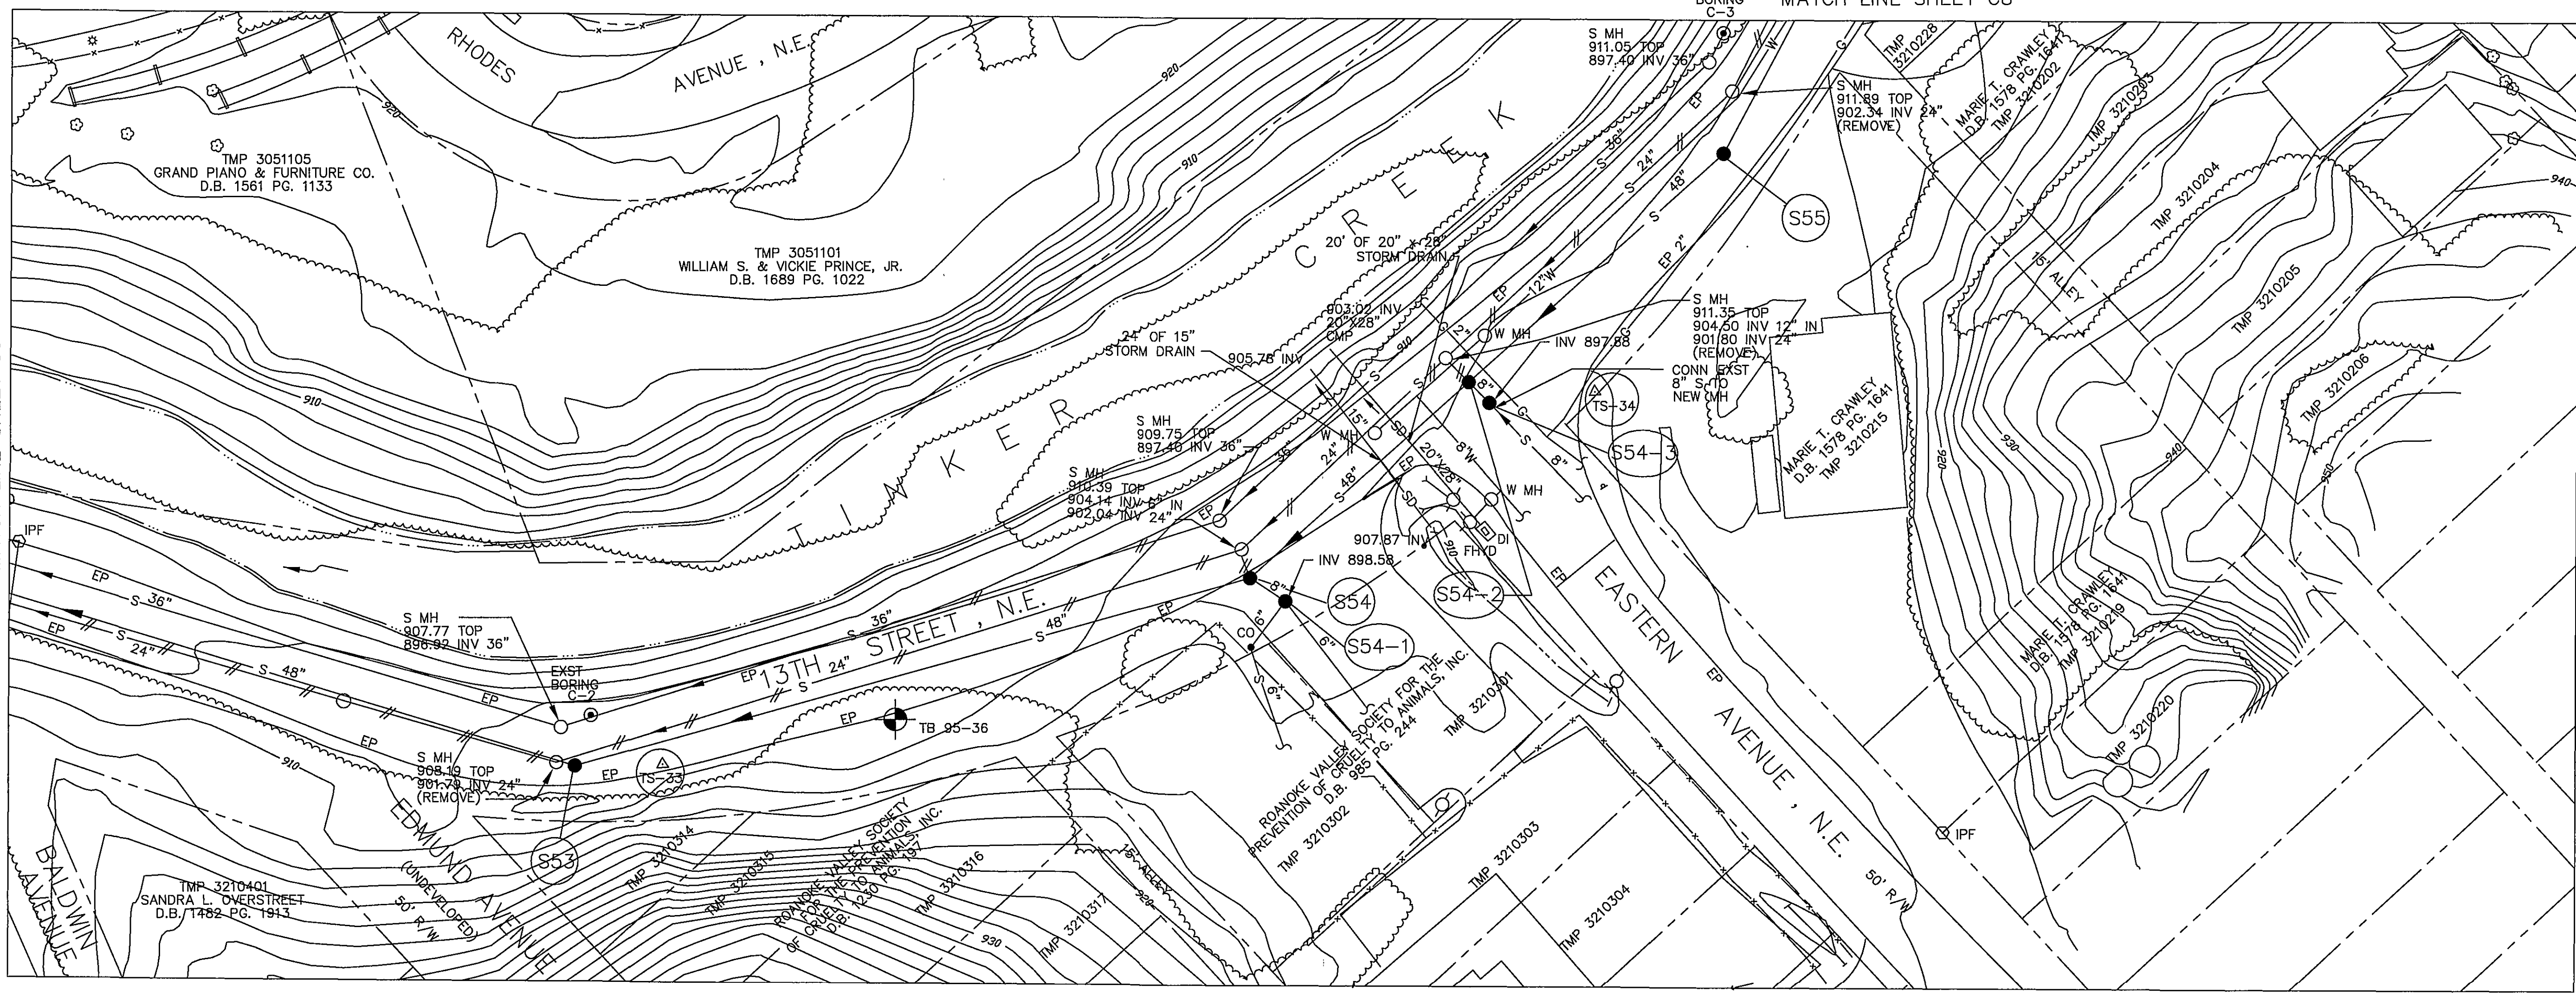


NOTE:
1. SEE SHEET G3 FOR STRUCTURE INFORMATION.

PLAN
SCALE: 1"=30'

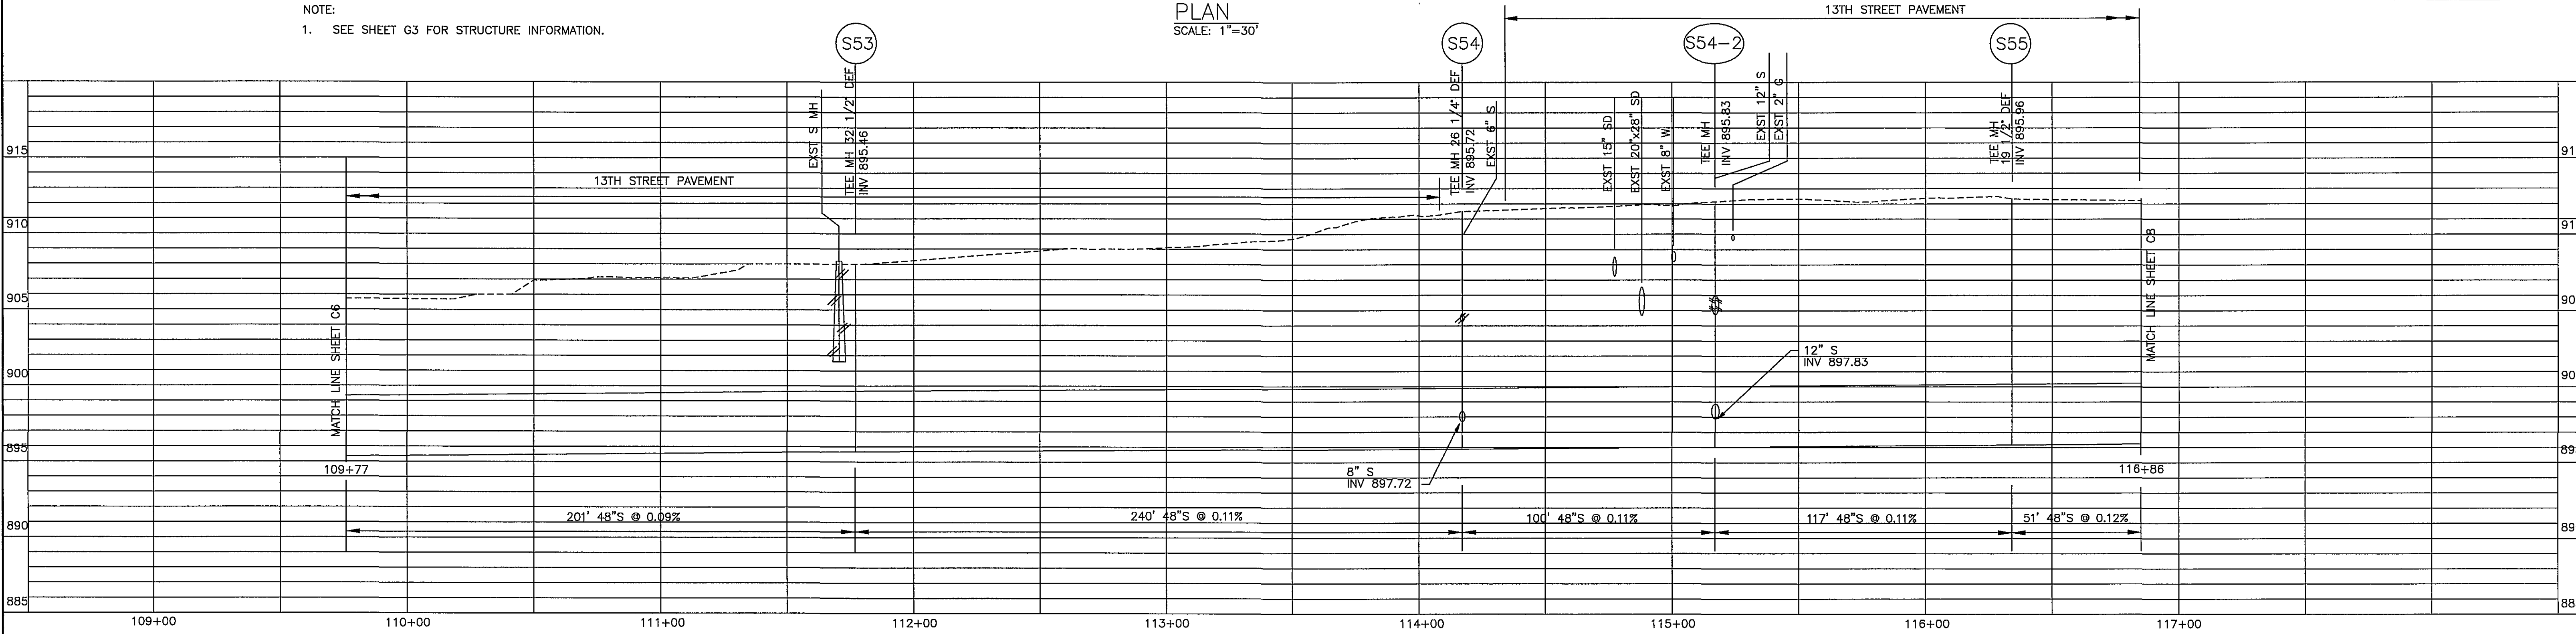

HAYES, SEAY, MATTERN & MATTERN, INC.
ARCHITECTS/ENGINEERS/PLANNERS
ROANOKE, VIRGINIA

DESIGNED: DMH	DATE	BY	REVISIONS	
			DESCRIPTION	
DRAWN: MHL	10/15/98	MNH	RECORD DRAWINGS SEE SHEET G1 FOR NOTE	
CHECKED:				
APPROVED:				

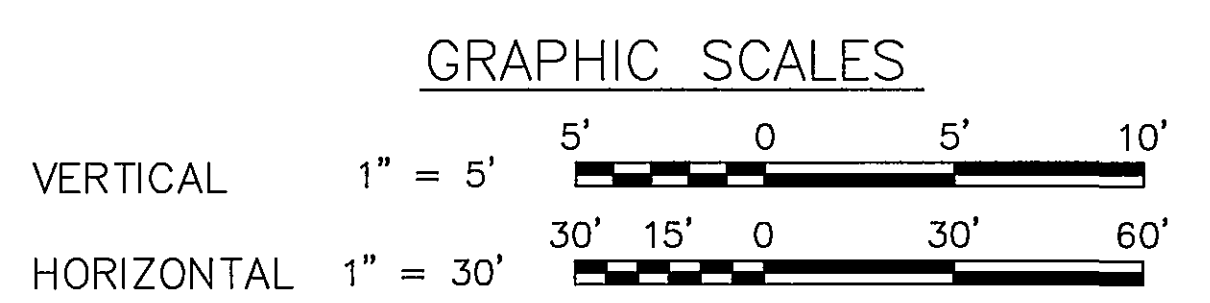

TINKER CREEK INTERCEPTOR SEWER CITY OF ROANOKE, VIRGINIA			PROJECT NO.: 6317
PLAN AND PROFILE STA 109+77 TO STA 116+86			CONTRACT B SHEET NO.
COMM. NO.: 7211	SCALE: AS NOTED	DATE: MAY 17, 1996	RECORD DRAWINGS