


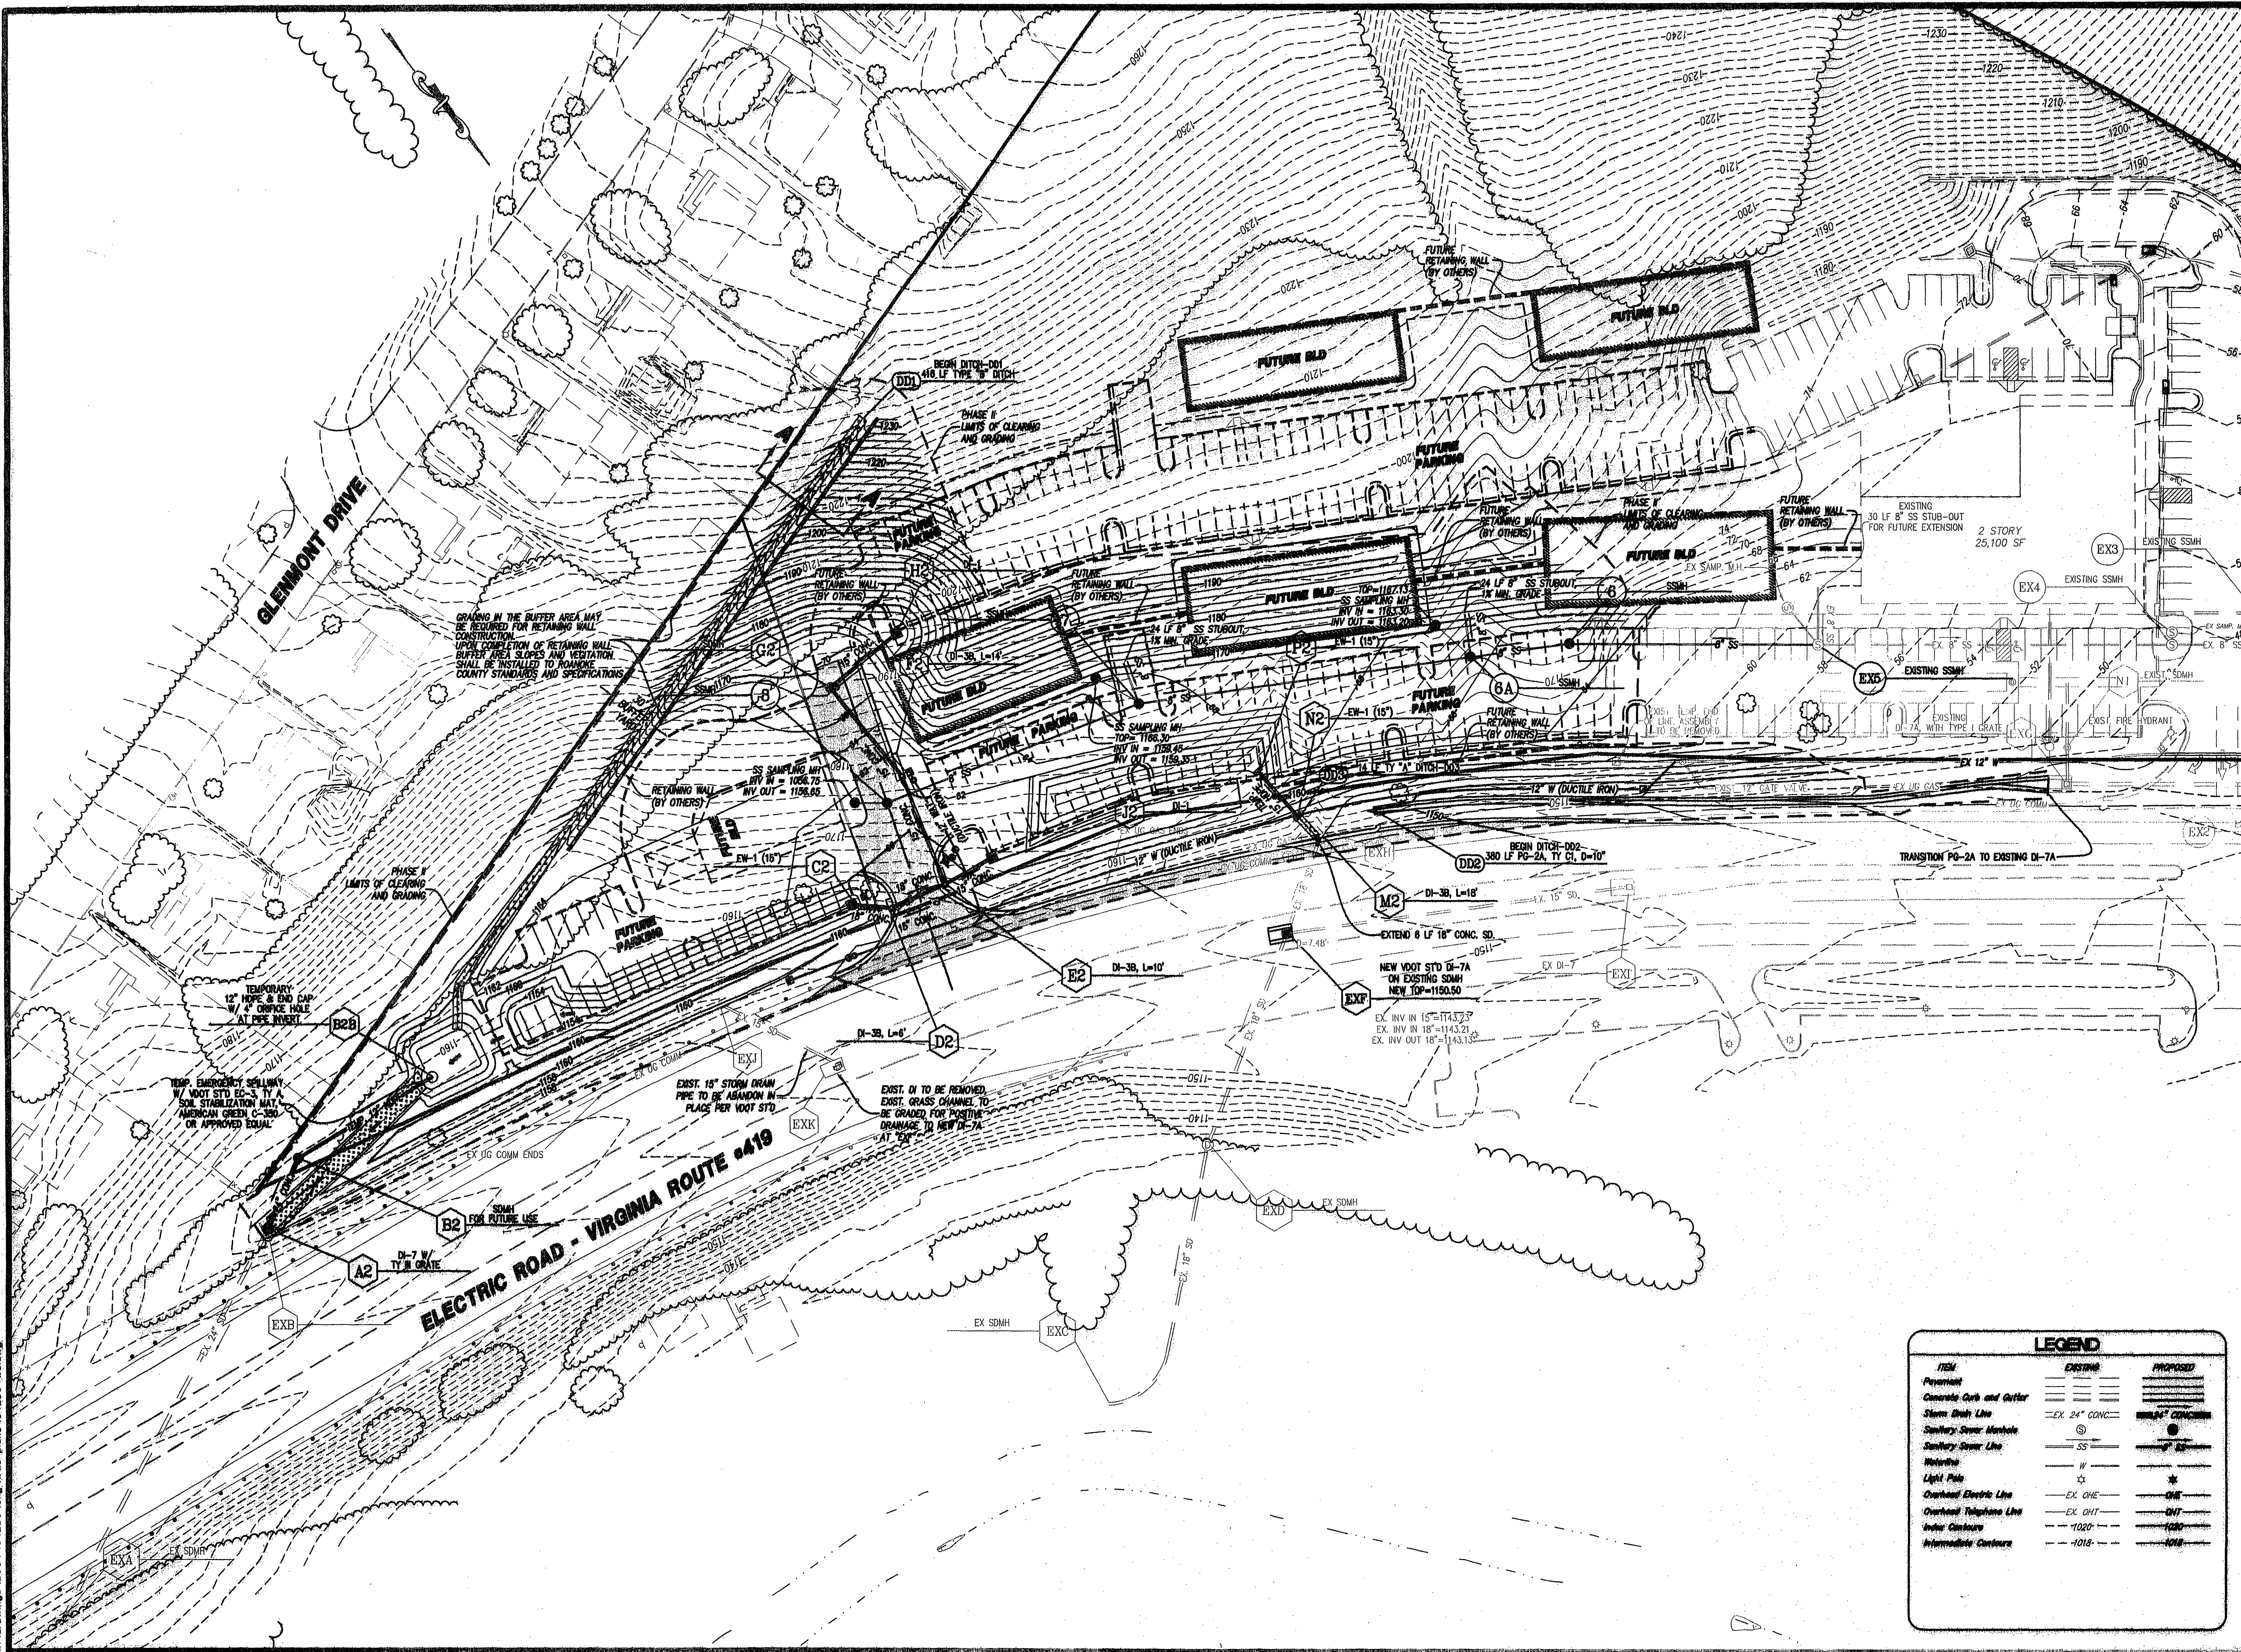

| LEGEND                   |          |          |
|--------------------------|----------|----------|
| ITEM                     | EXISTING | PROPOSED |
| Payment                  | ---      | ---      |
| Concrete curb and gutter | ---      | ---      |
| Storm Drain Line         | ---      | ---      |
| Sanitary Sewer Manhole   | ---      | ---      |
| Sanitary Sewer Line      | ---      | ---      |
| Waterline                | ---      | ---      |
| Light Pole               | ---      | ---      |
| Overhead Electric Line   | ---      | ---      |
| Overhead Telephone Line  | ---      | ---      |
| Index Contours           | ---      | ---      |
| Intermediate Contours    | ---      | ---      |

04230 ws-gt01 (6).dwt

**LUMSDEN ASSOCIATES P.C.**  
ENGINEERS-SURVEYORS-PLANNERS  
ROANOKE, VIRGINIA

4664 BRAMBLETON AVENUE  
P.O. BOX 20669  
ROANOKE, VIRGINIA 24018

PHONE: (540) 774-4411  
FAX: (540) 772-9445  
E-MAIL: MAIL@LUMSDENPC.COM

WEST VILLAGE  
PHASE II  
PREPARED FOR  
WEST VILLAGE, L.L.C.  
CAYE SPRING MAGISTERIAL DISTRICT  
ROANOKE COUNTY, VIRGINIA

**GRADING PLAN**

REVISIONS

| NO. | DATE | DESCRIPTION |
|-----|------|-------------|
|     |      |             |
|     |      |             |
|     |      |             |
|     |      |             |

DATE: February 27, 2006

SCALE: 1" = 40'

COMMISSION NO: 2004-230

SHEET 6 OF 12