

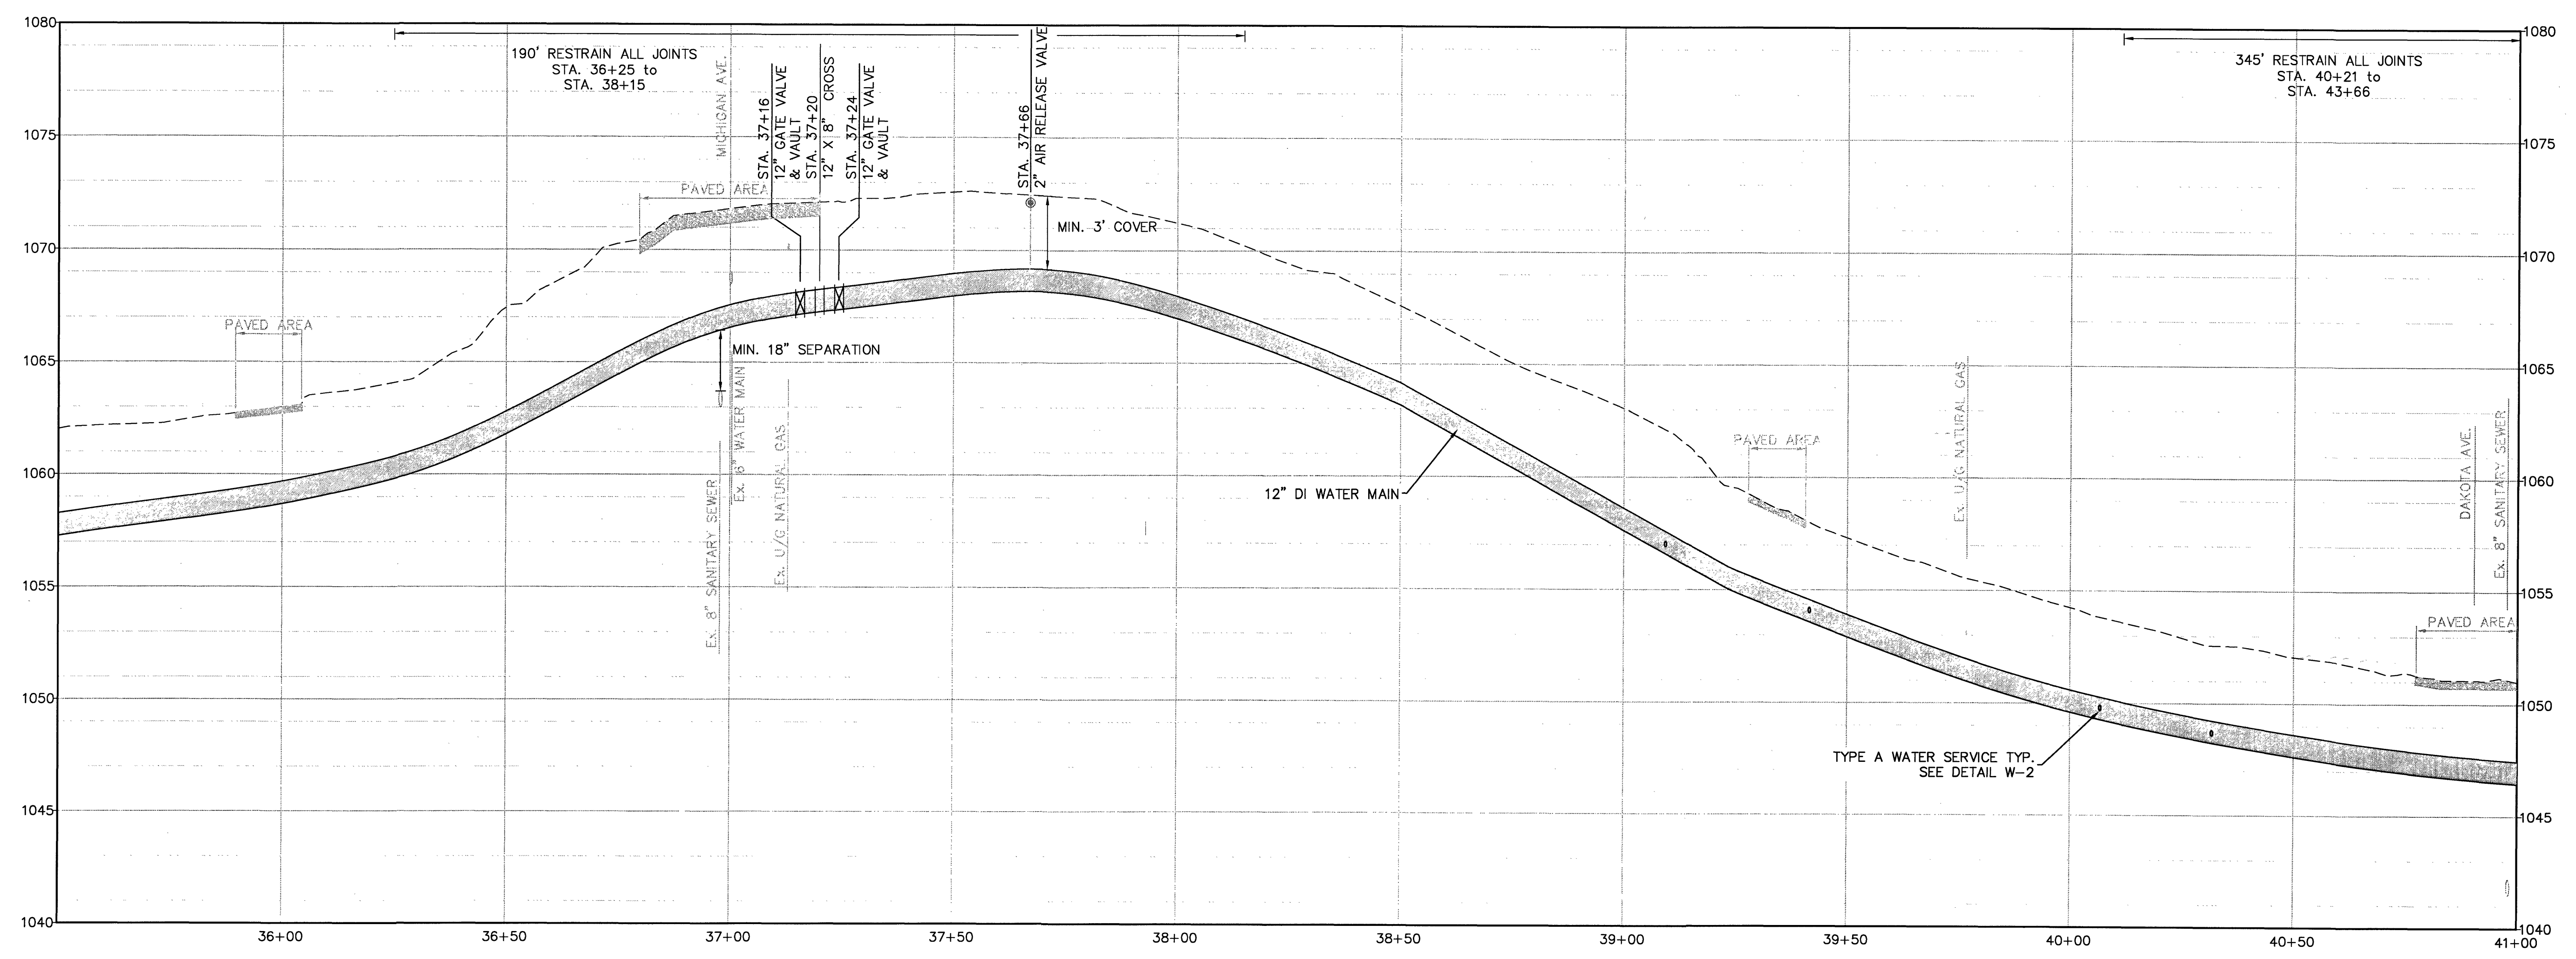


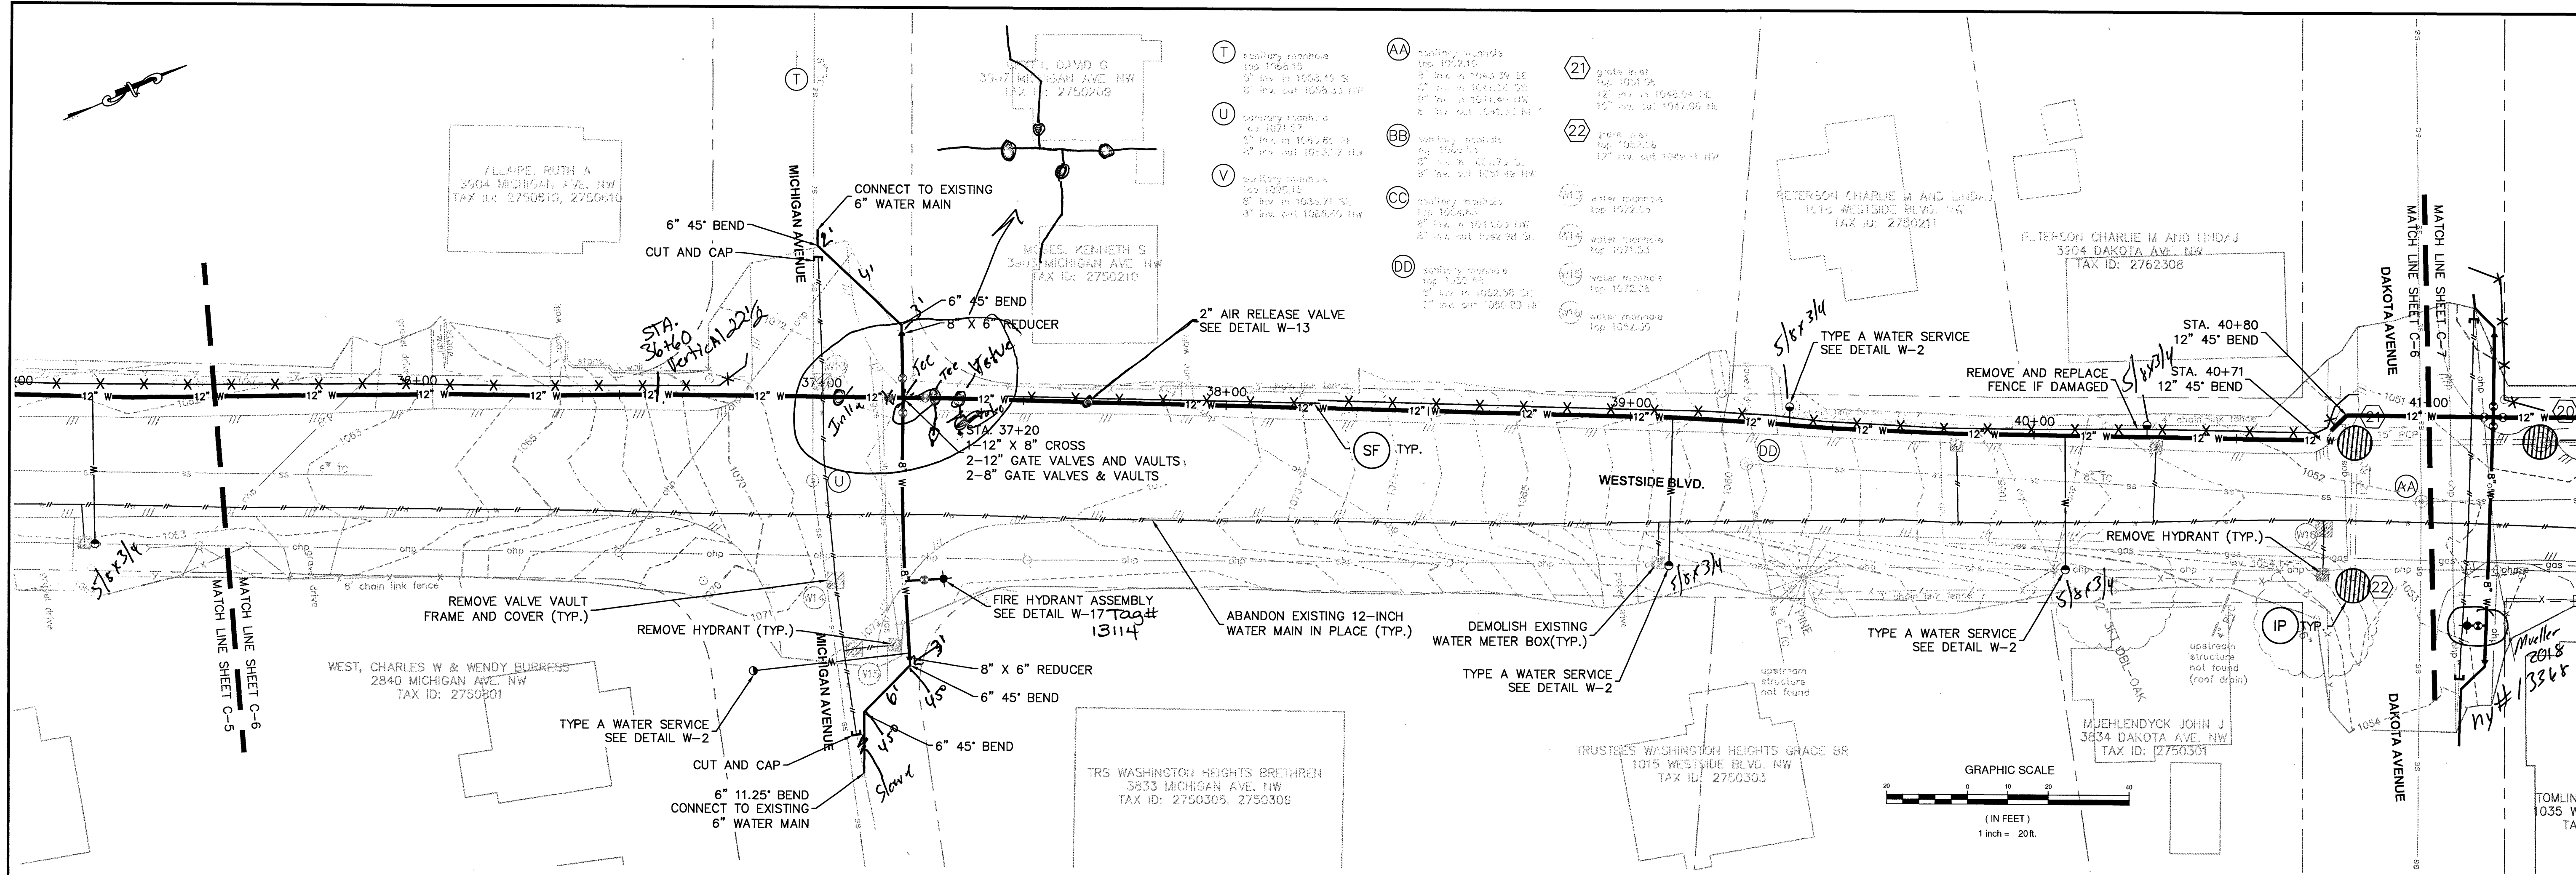

WATER MAIN PROFILE
SCALE: H:1"=20' V:1"=4'

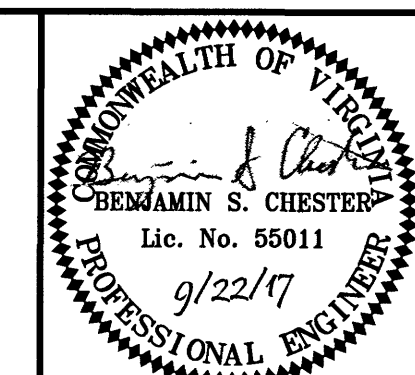

Draper Aden Associates
Engineering • Surveying • Environmental Services
2206 South Main Street
Blacksburg, VA 24060
540-552-0444 Fax: 540-552-0291
www.daa.com

• Richmond, VA
• Raleigh, NC
• Charlottesville, VA
• Fayetteville, NC
• Hampton Roads, VA
• Northern Virginia

**WATER MAIN PLAN AND PROFILE
WESTSIDE BLVD. WATER MAIN
REPLACEMENT**
ROANOKE, VIRGINIA

REVISIONS	
DESIGNED BY:	BSC
DRAWN BY:	BSC
CHECKED BY:	JSL
SCALE:	1" = 20'
DATE:	9/15/17
PROJECT NUMBER:	B11132B-11
C-6	