

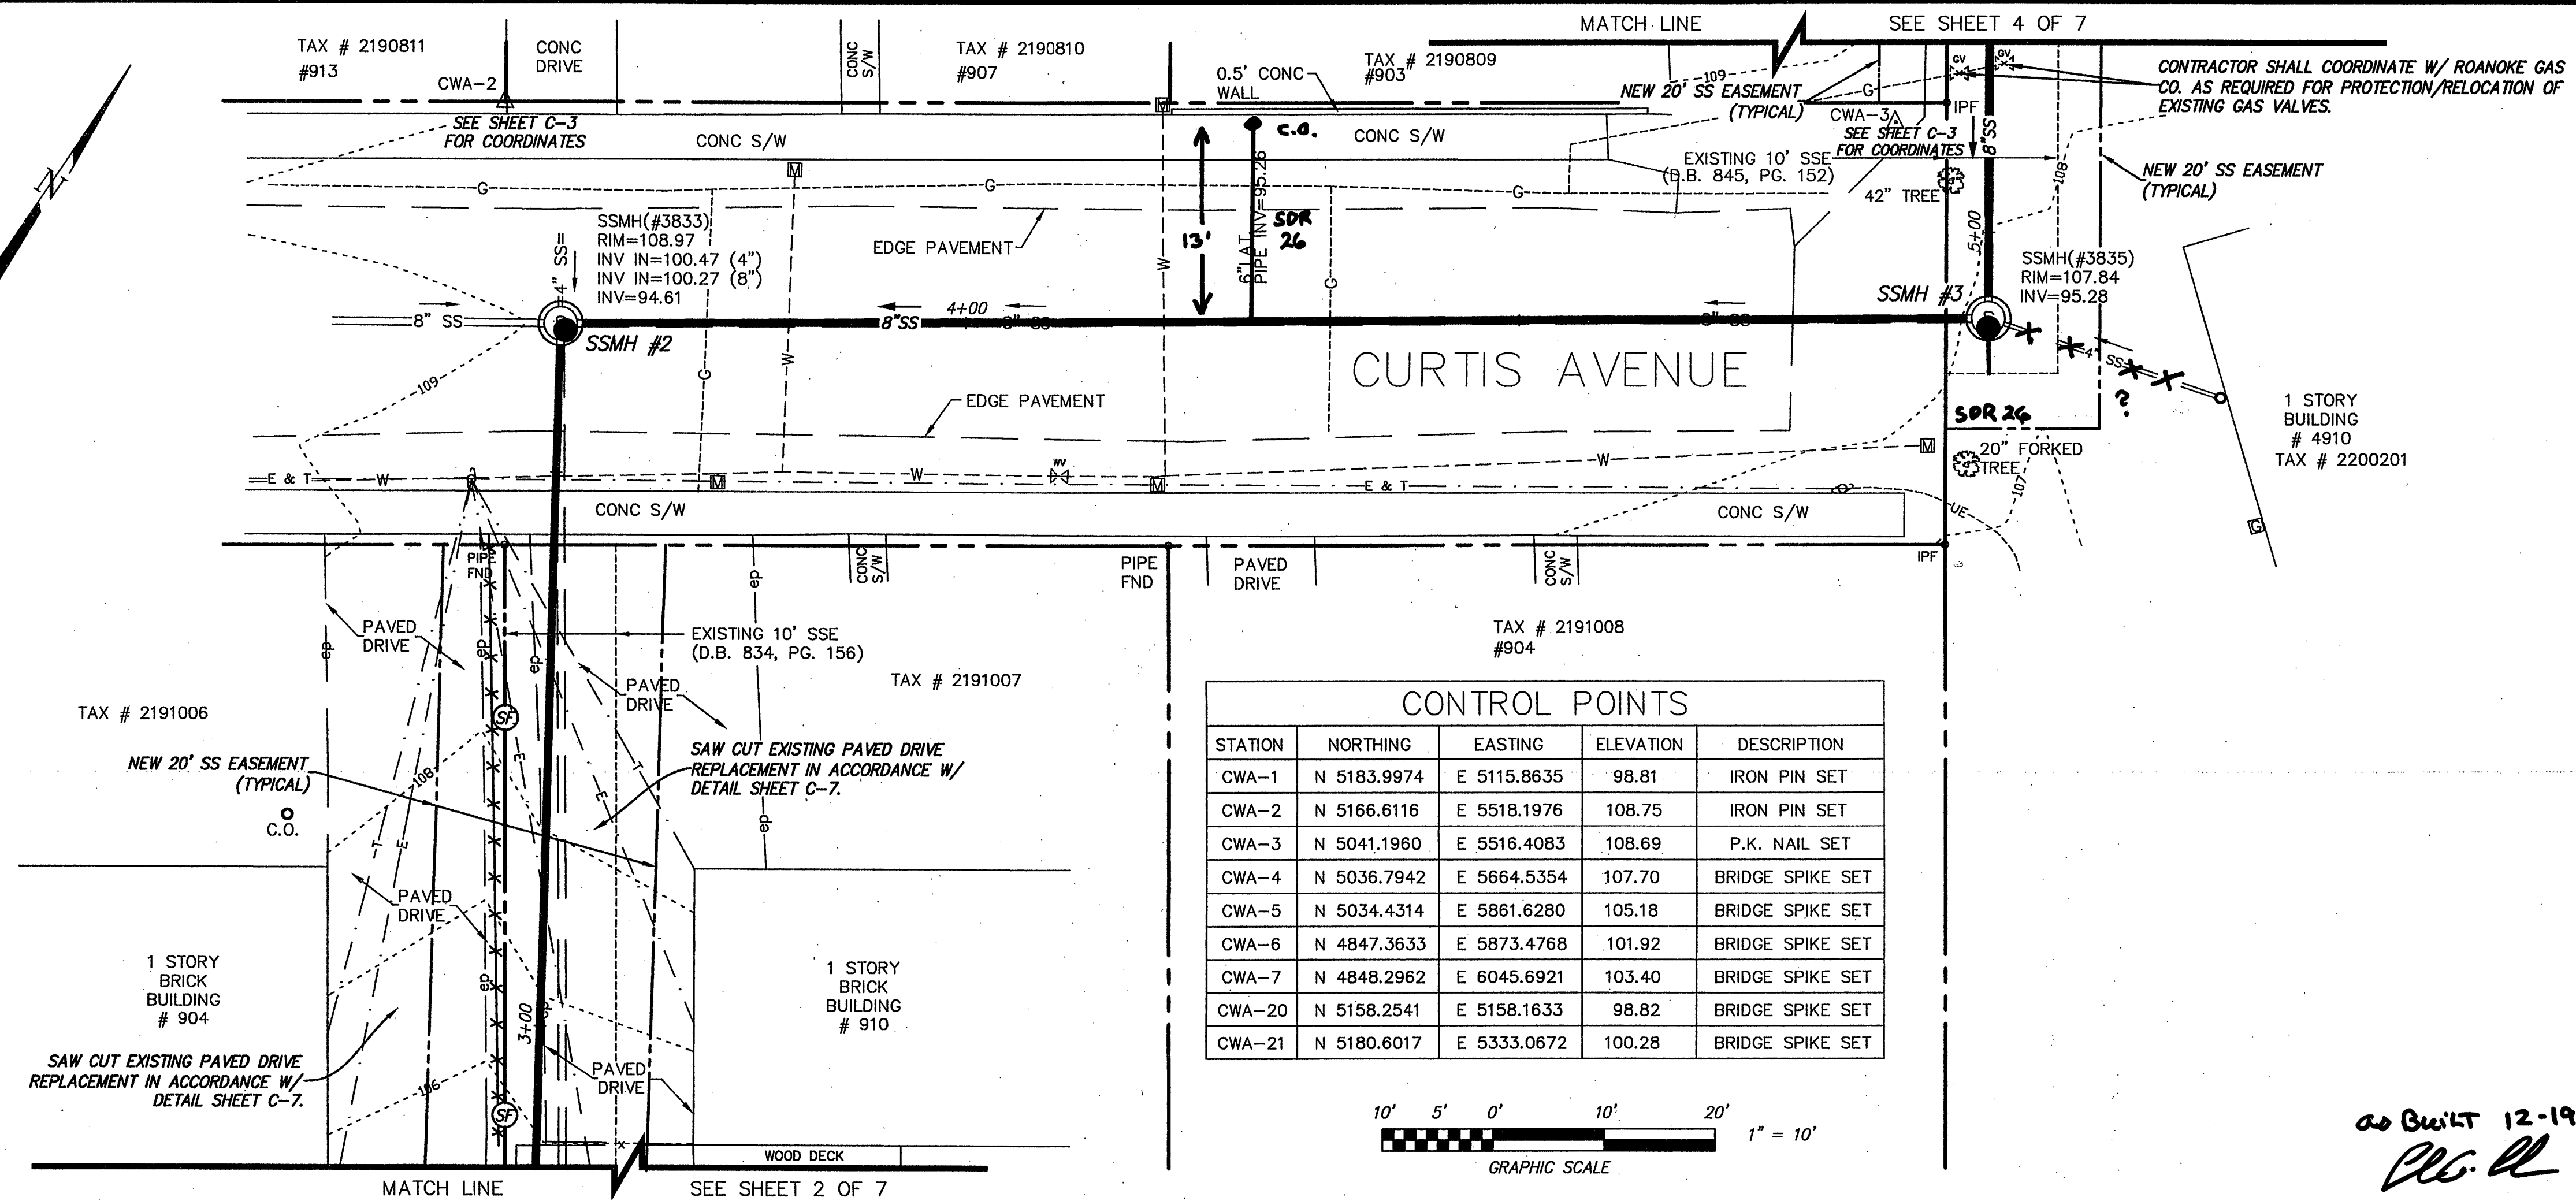


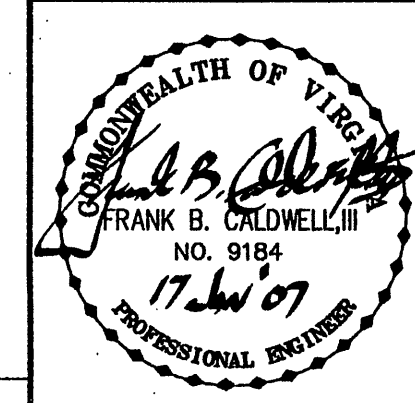

STATION	NORTHING	EASTING	ELEVATION	DESCRIPTION
CWA-1	N 5183.9974	E 5115.8635	98.81	IRON PIN SET
CWA-2	N 5166.6116	E 5518.1976	108.75	IRON PIN SET
CWA-3	N 5041.1960	E 5516.4083	108.69	P.K. NAIL SET
CWA-4	N 5036.7942	E 5664.5354	107.70	BRIDGE SPIKE SET
CWA-5	N 5034.4314	E 5861.6280	105.18	BRIDGE SPIKE SET
CWA-6	N 4847.3633	E 5873.4768	101.92	BRIDGE SPIKE SET
CWA-7	N 4848.2962	E 6045.6921	103.40	BRIDGE SPIKE SET
CWA-20	N 5158.2541	E 5158.1633	98.82	BRIDGE SPIKE SET
CWA-21	N 5180.6017	E 5333.0672	100.28	BRIDGE SPIKE SET

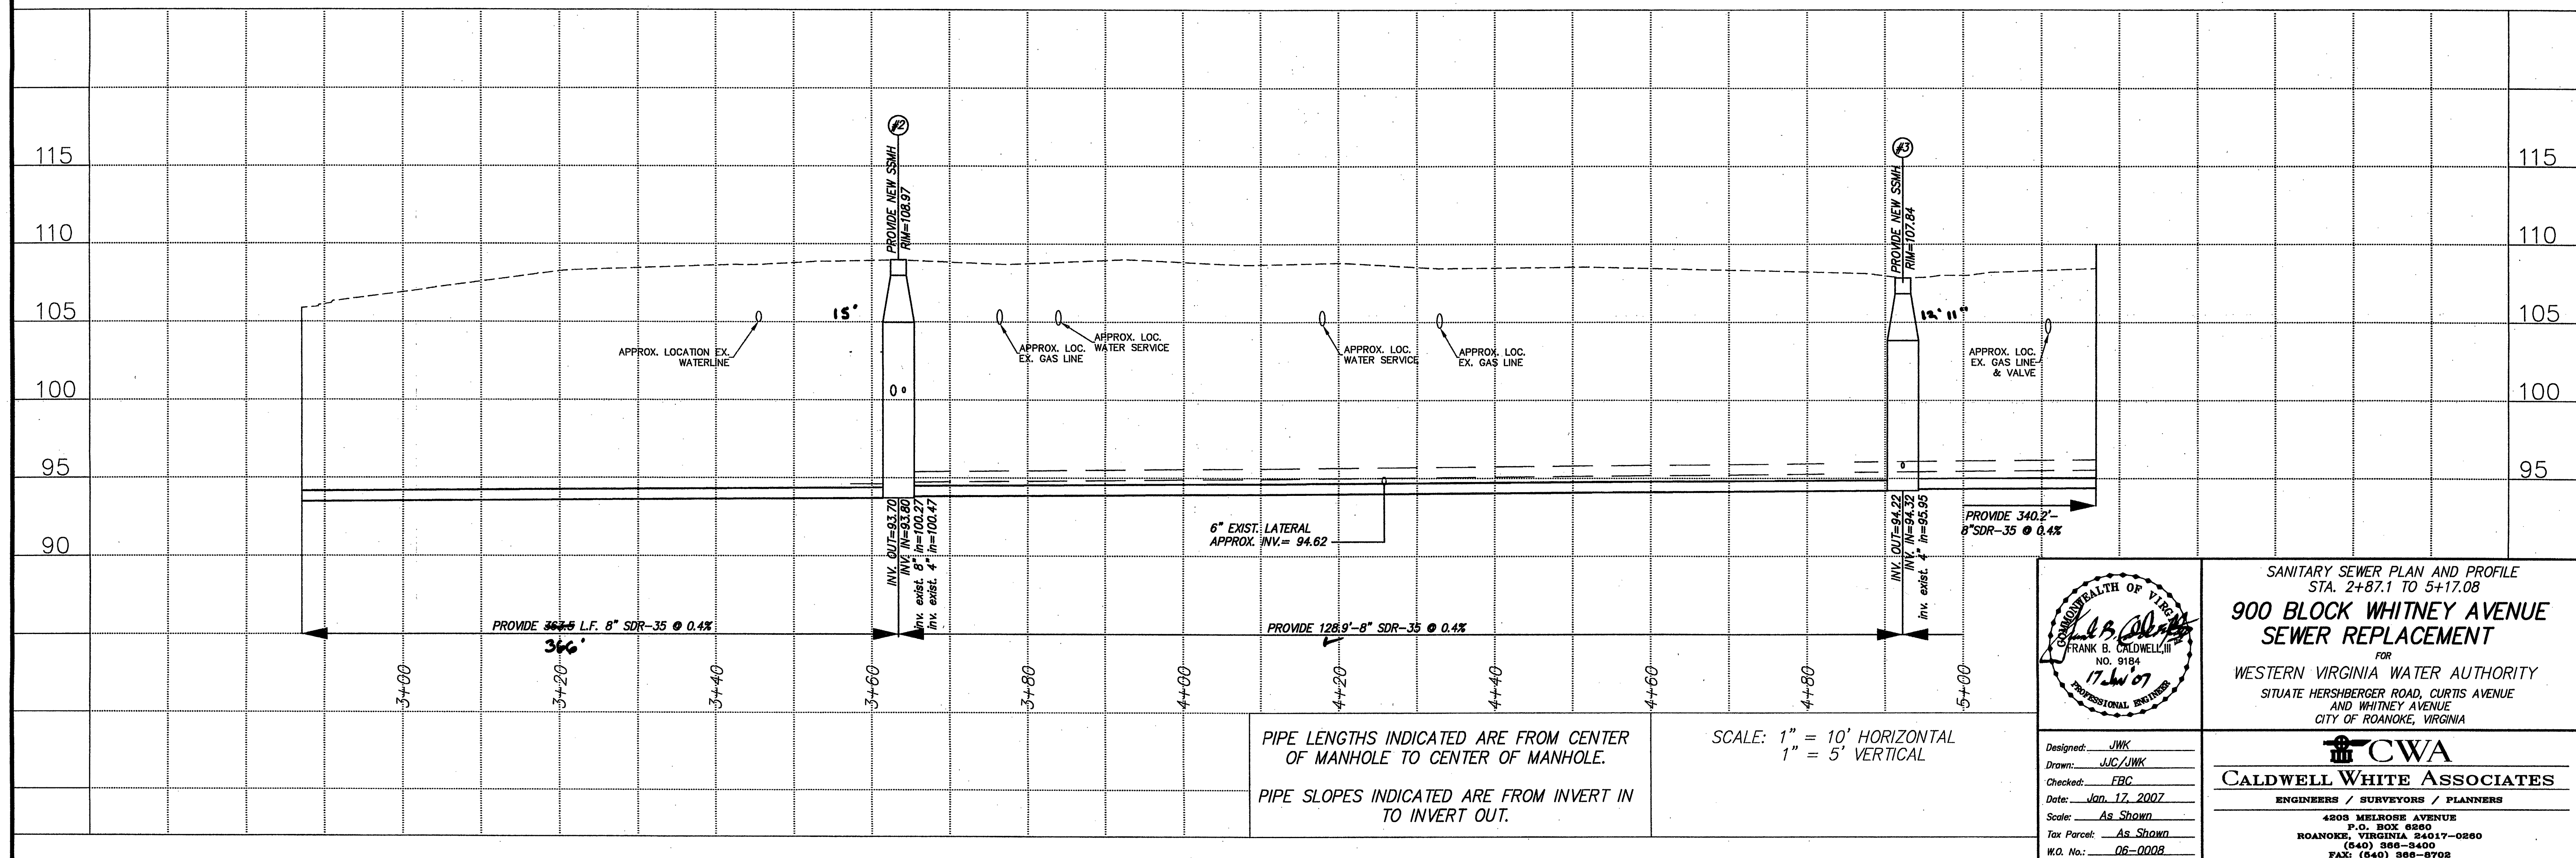

SANITARY SEWER PLAN AND PROFILE
STA. 2+87.1 TO 5+17.08
**900 BLOCK WHITNEY AVENUE
SEWER REPLACEMENT**
FOR
WESTERN VIRGINIA WATER AUTHORITY
SITUATE HERSHBERGER ROAD, CURTIS AVENUE
AND WHITNEY AVENUE
CITY OF ROANOKE, VIRGINIA

CWA
CALDWELL WHITE ASSOCIATES
ENGINEERS / SURVEYORS / PLANNERS
4205 MELROSE AVENUE
P.O. BOX 4260
ROANOKE, VIRGINIA 24017-0260
(540) 386-3400
FAX: (540) 386-8702

Designed: JWK
Drawn: JJC/JWK
Checked: EBC
Date: Jan. 17, 2007
Scale: As Shown
Tax Parcel: As Shown
W.O. No.: 06-0008