
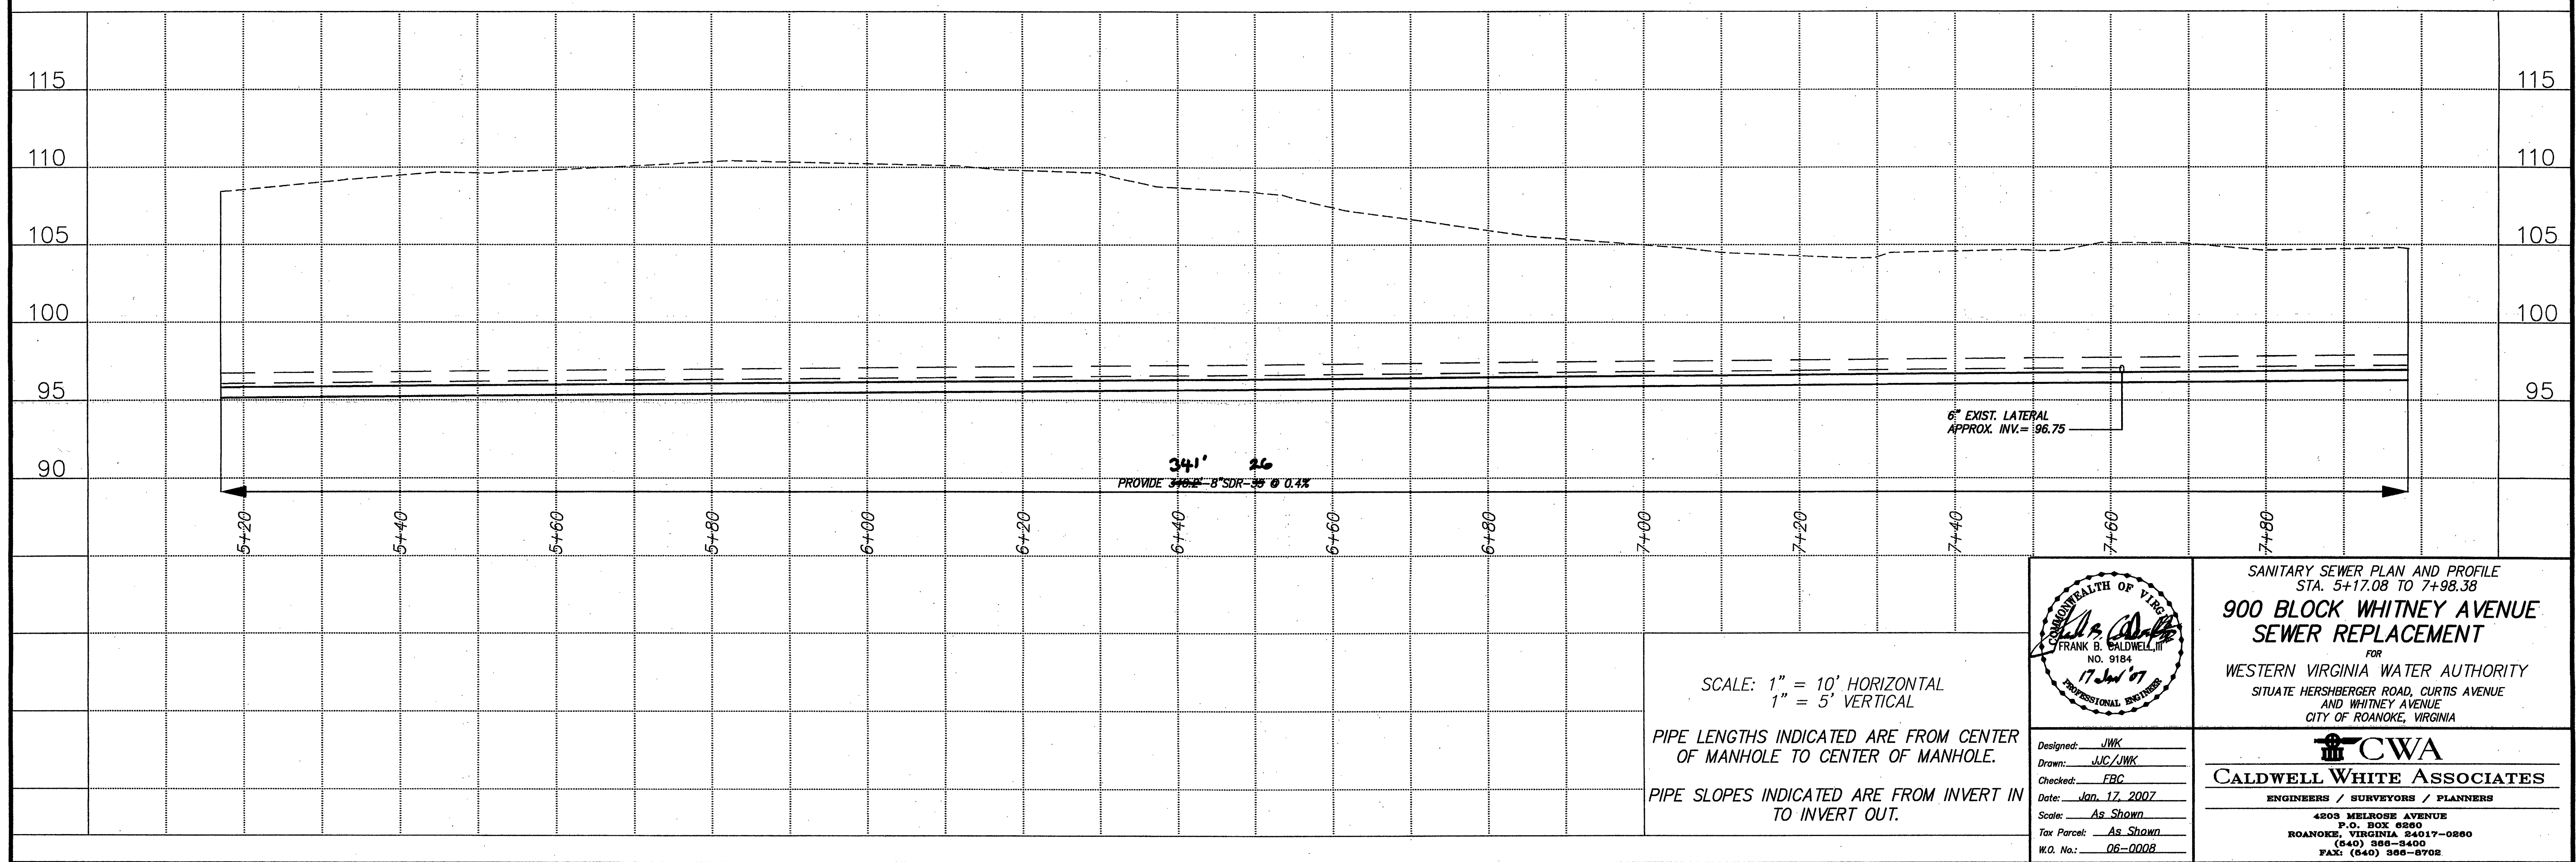


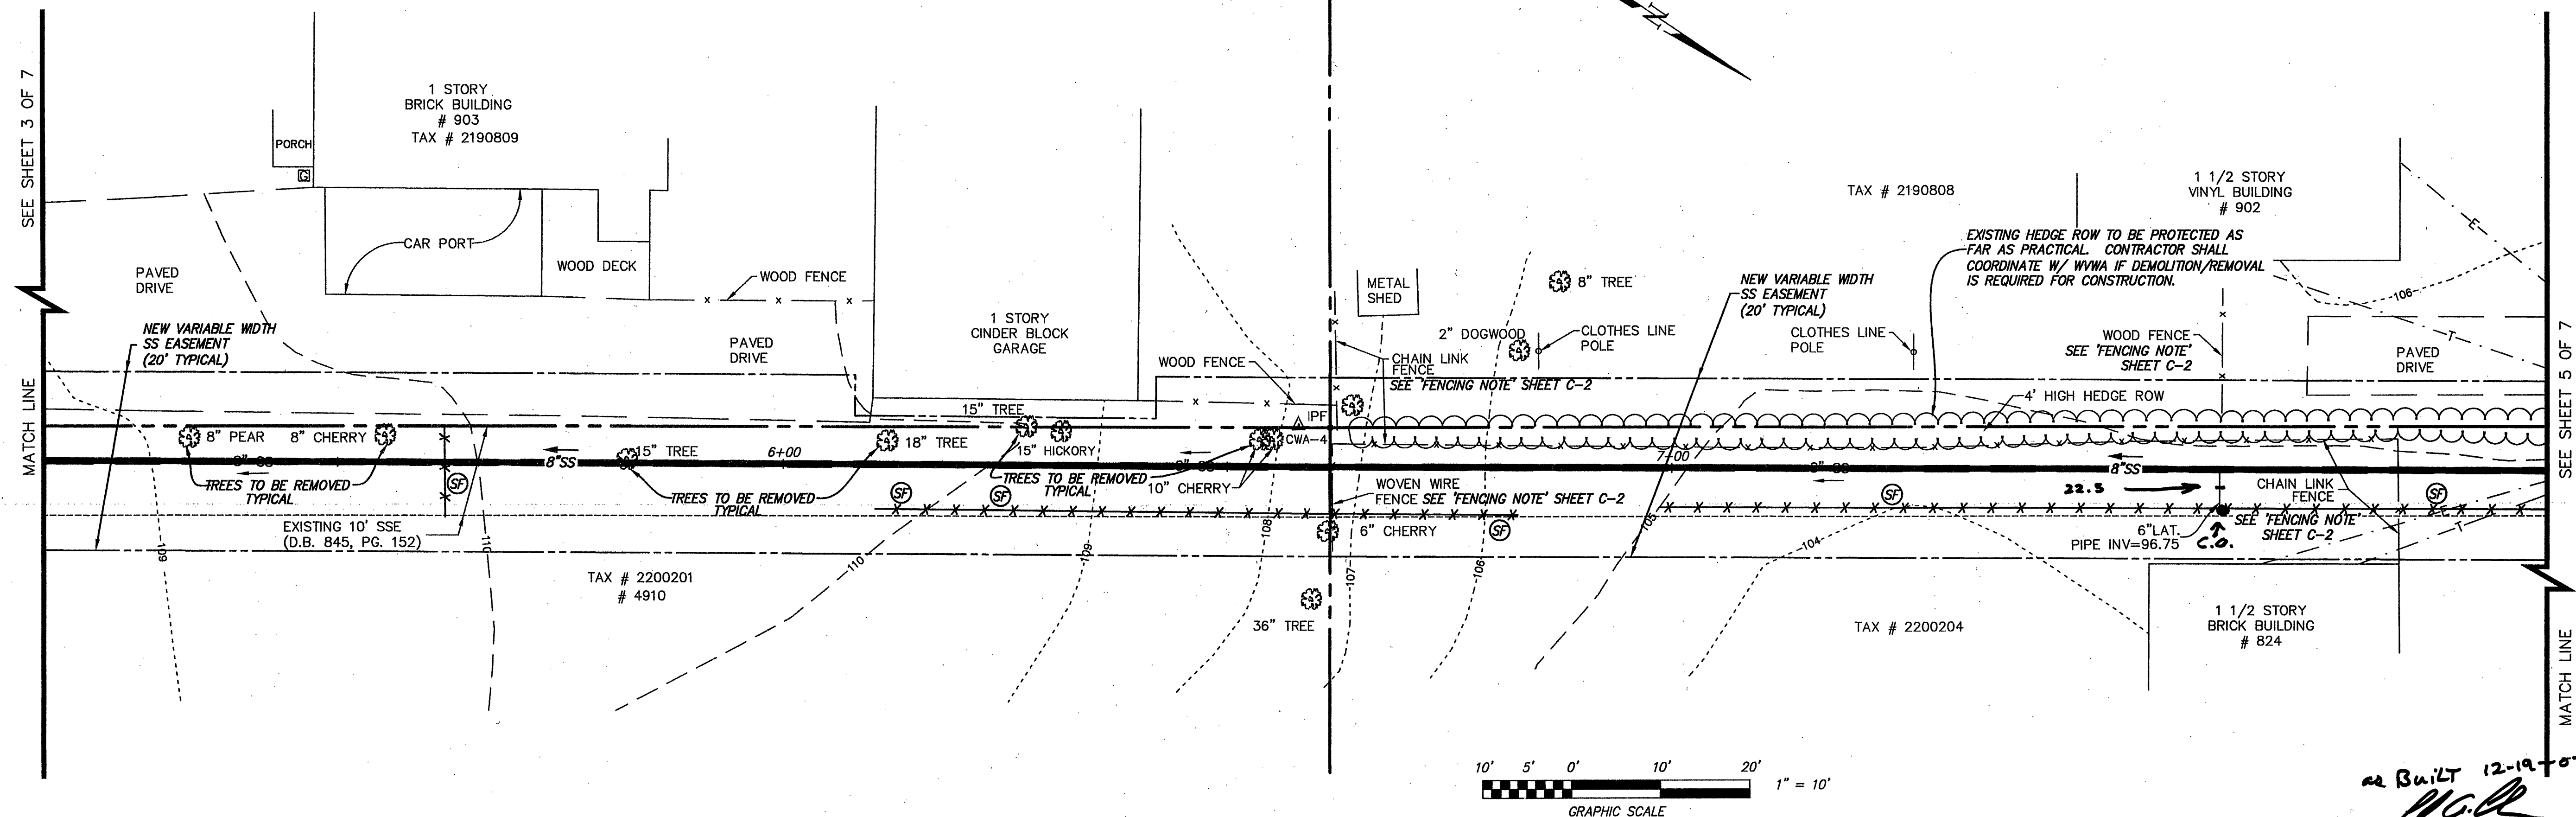

SCALE: 1" = 10' HORIZONTAL
1" = 5' VERTICAL

PIPE LENGTHS INDICATED ARE FROM CENTER OF MANHOLE TO CENTER OF MANHOLE.

PIPE SLOPES INDICATED ARE FROM INVERT IN TO INVERT OUT.

COMMONWEALTH OF VIRGINIA

FRANK B. CALDWELL, III

NO. 9184

17 Jul 07

PROFESSIONAL ENGINEER

Designed: JWK

Drawn: JWC/JWK

Checked: EBC

Date: Jan. 17, 2007

Scale: As Shown

Tax Parcel: As Shown

W.D. No.: 06-0008

SANITARY SEWER PLAN AND PROFILE
STA. 5+17.08 TO 7+98.38

**900 BLOCK WHITNEY AVENUE
SEWER REPLACEMENT**

FOR
WESTERN VIRGINIA WATER AUTHORITY

SITUATE HERSHBERGER ROAD, CURTIS AVENUE
AND WHITNEY AVENUE
CITY OF ROANOKE, VIRGINIA

CWA
CALDWELL WHITE ASSOCIATES

ENGINEERS / SURVEYORS / PLANNERS

4203 MELROSE AVENUE
P.O. BOX 6260
ROANOKE, VIRGINIA 24017-0260
(840) 366-8400
FAX: (840) 366-8708

SHEET C-4 OF 7