

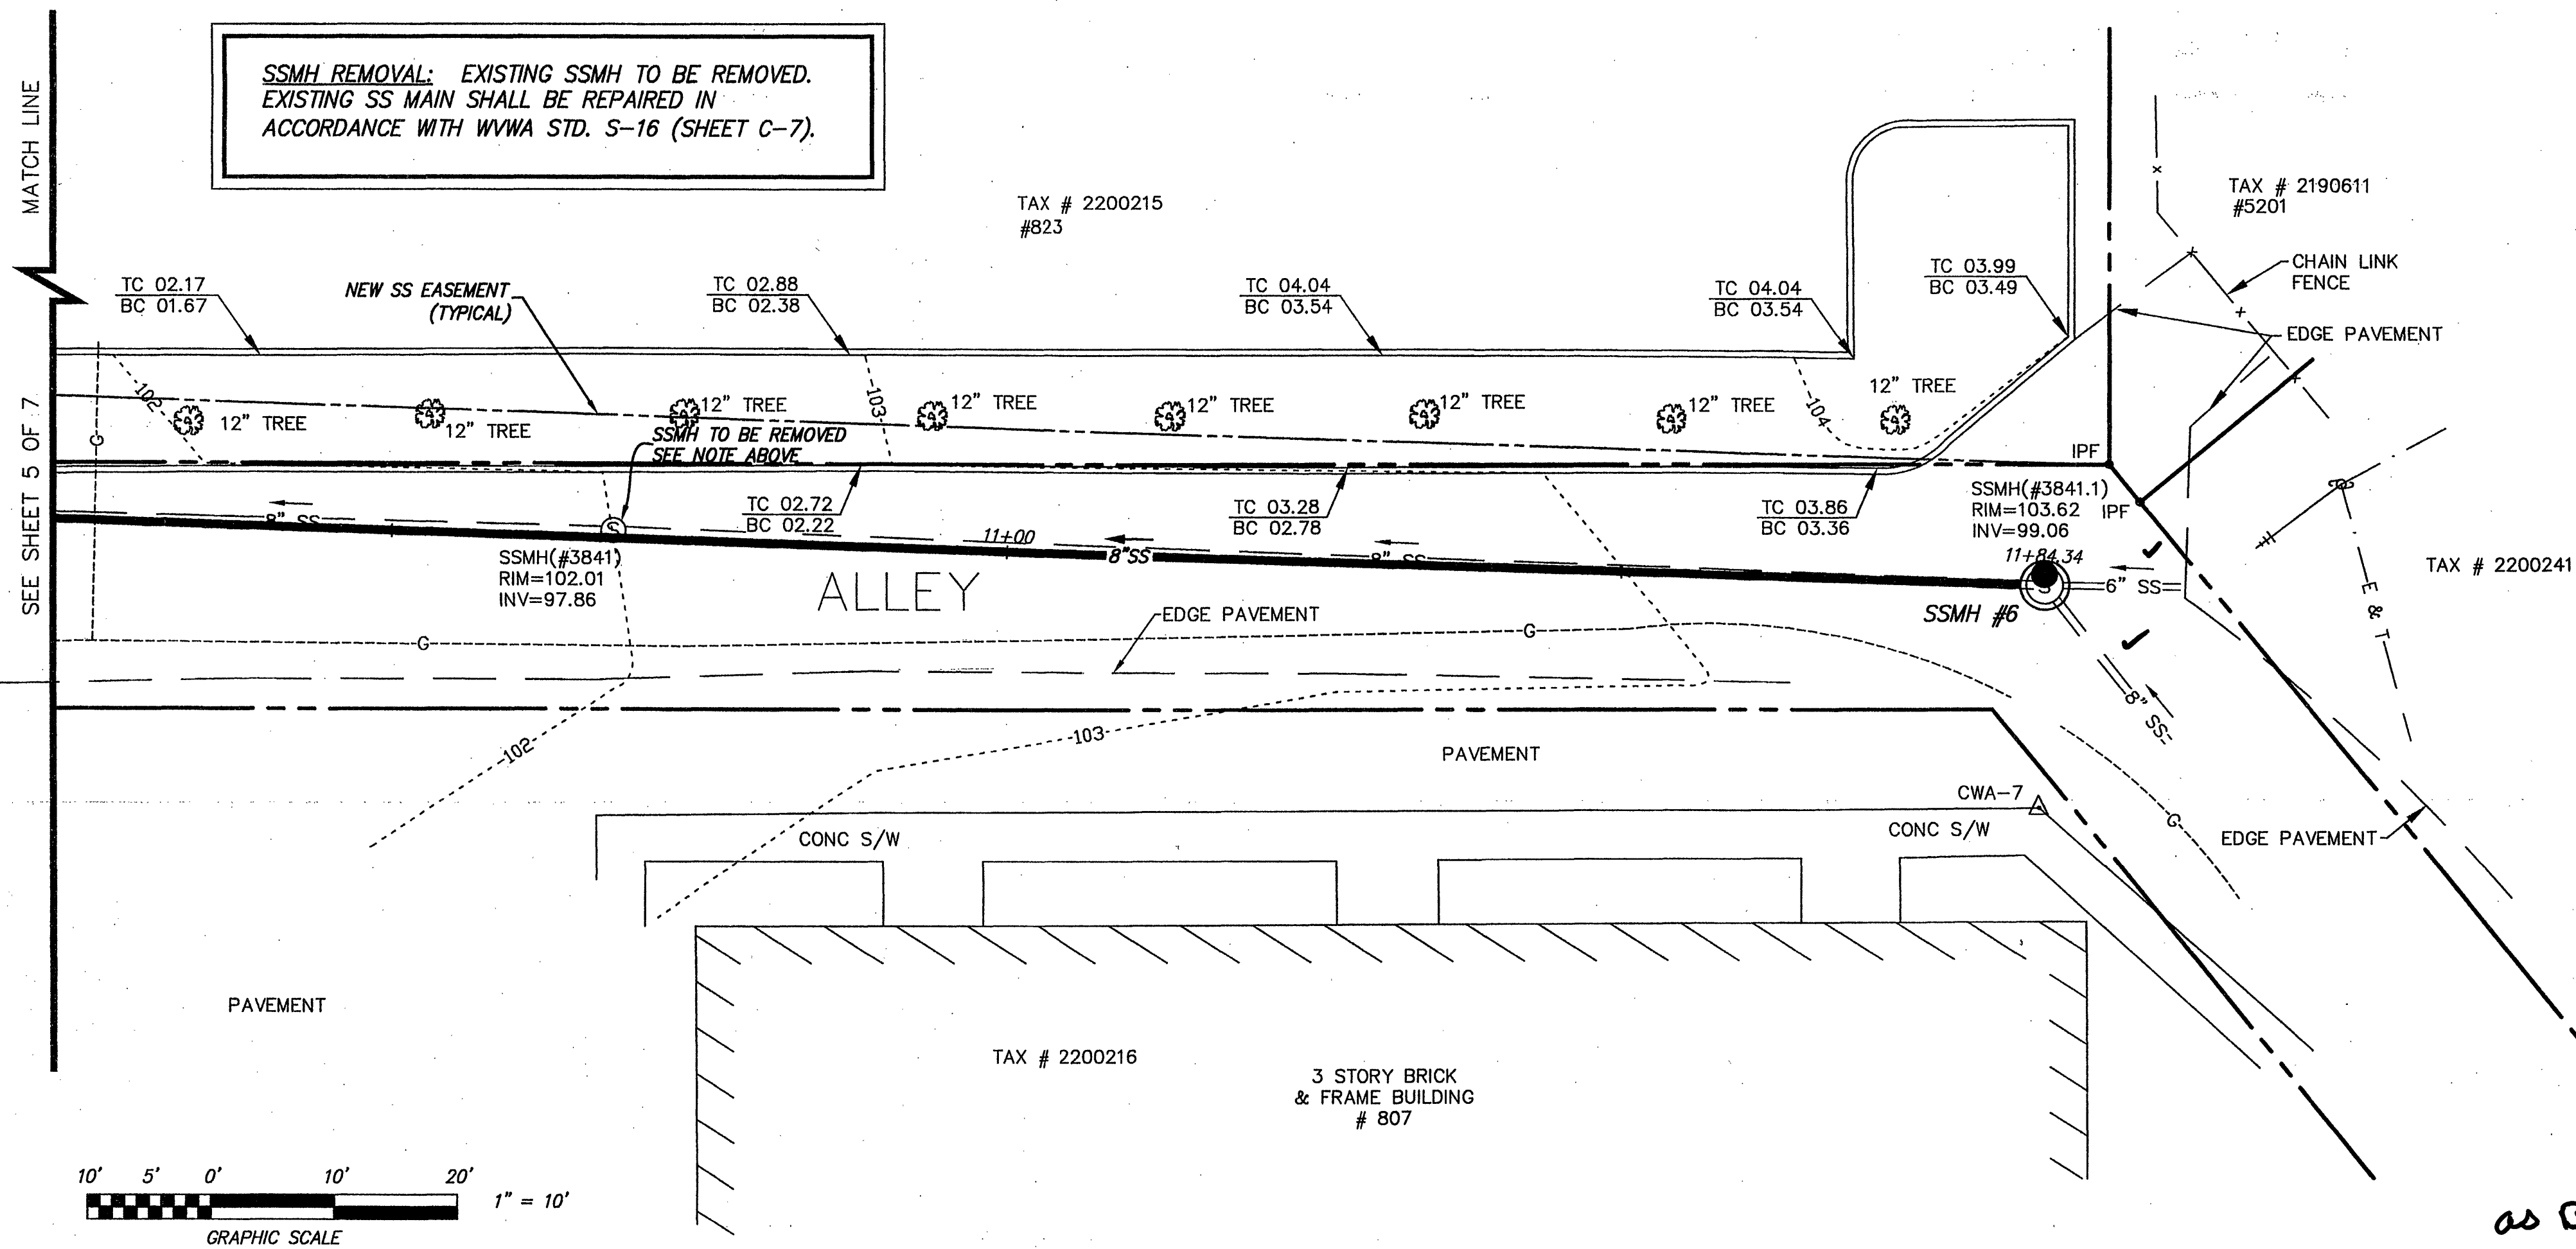


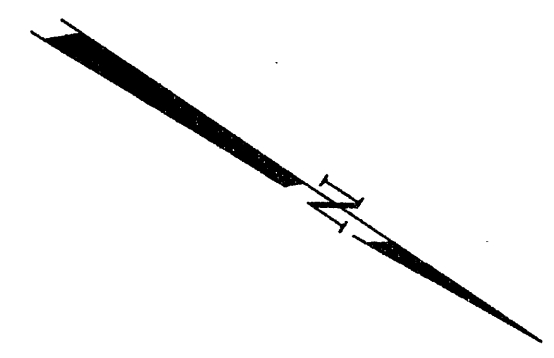

as BUILT 12-19-07
UGL

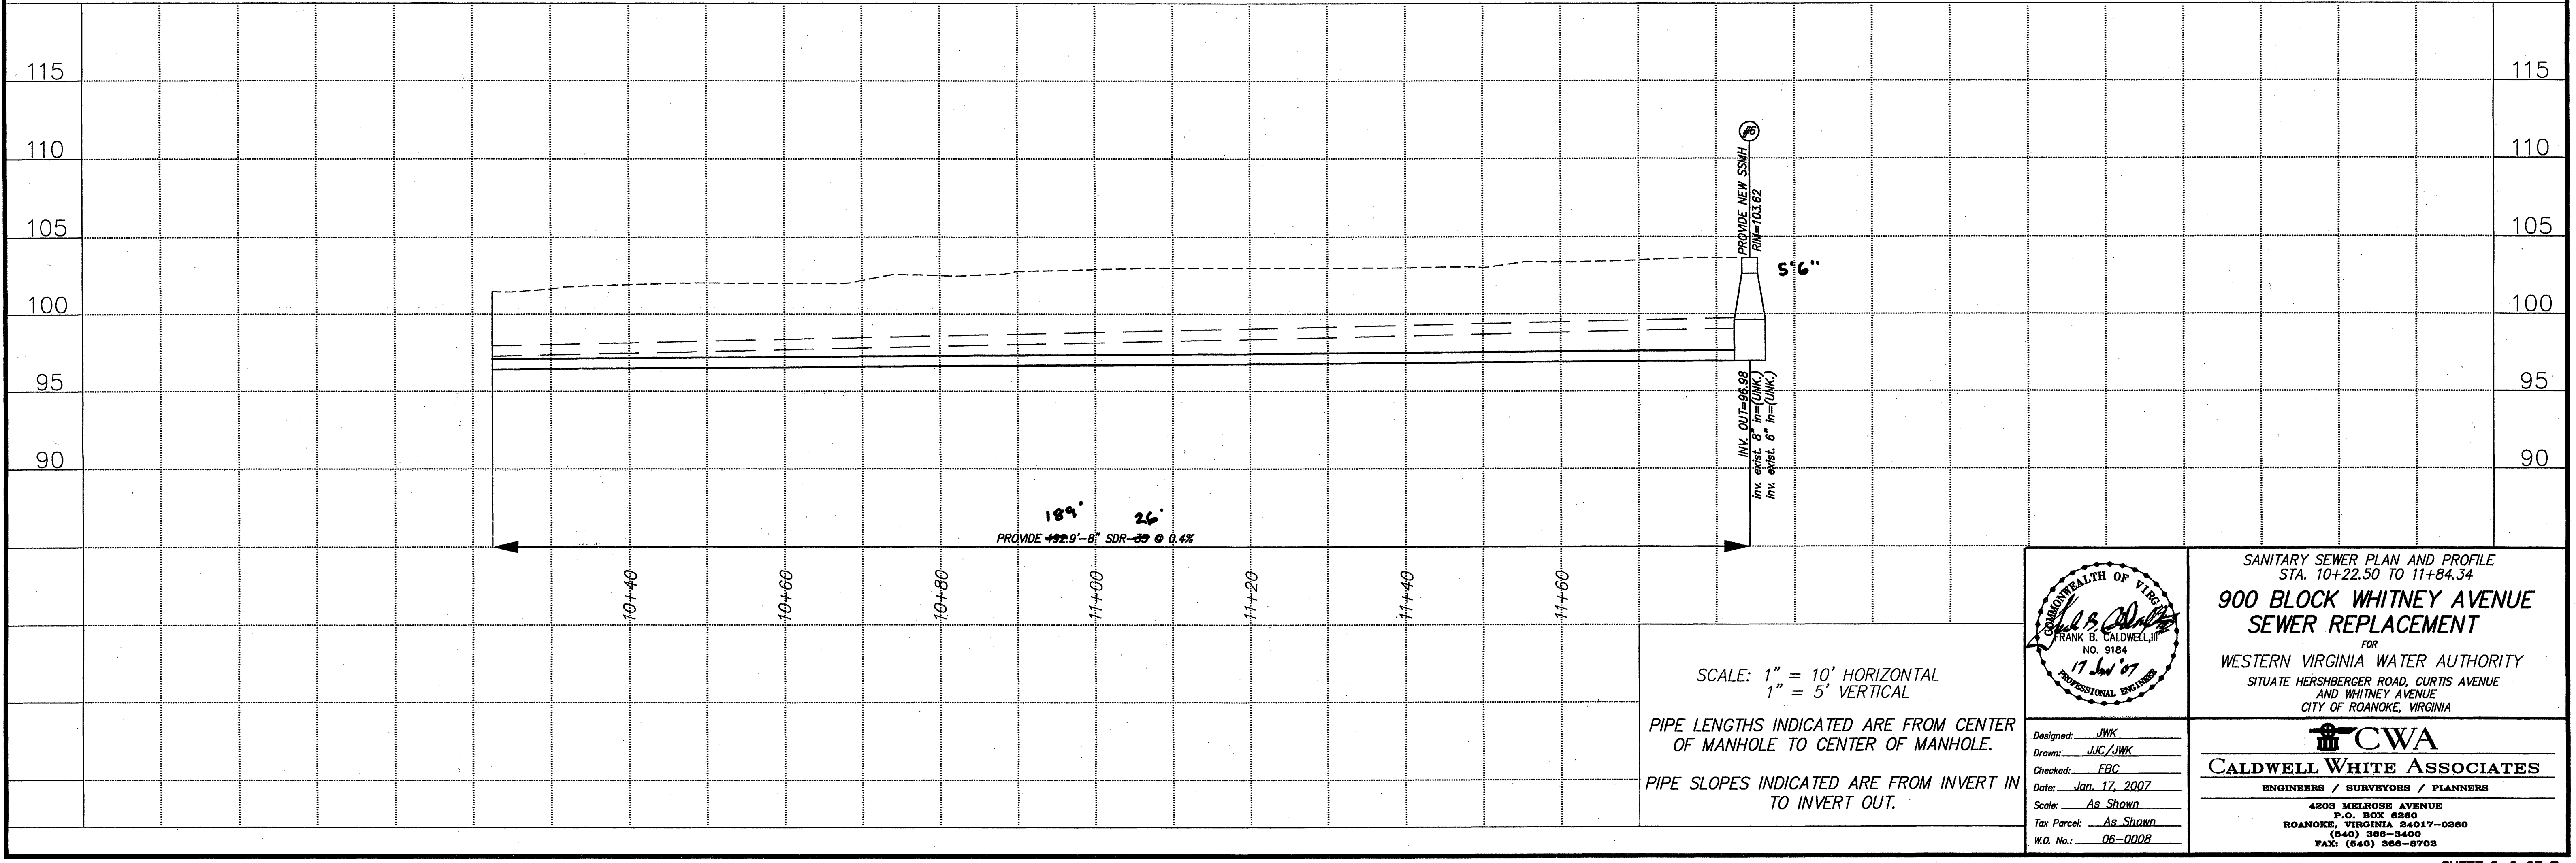

SCALE: 1" = 10' HORIZONTAL
1" = 5' VERTICAL

PIPE LENGTHS INDICATED ARE FROM CENTER OF MANHOLE TO CENTER OF MANHOLE.

PIPE SLOPES INDICATED ARE FROM INVERT IN TO INVERT OUT.

DESIGNED: JWK
DRAWN: JWC/JWK
CHECKED: EBC
DATE: Jan. 17, 2007
SCALE: As Shown
TAX PARCEL: As Shown
W.O. NO.: 06-0008

SANITARY SEWER PLAN AND PROFILE
STA. 10+22.50 TO 11+84.34

**900 BLOCK WHITNEY AVENUE
SEWER REPLACEMENT**

FOR
WESTERN VIRGINIA WATER AUTHORITY
SITUATE HERSHBERGER ROAD, CURTIS AVENUE
AND WHITNEY AVENUE
CITY OF ROANOKE, VIRGINIA

CALDWELL WHITE ASSOCIATES
ENGINEERS / SURVEYORS / PLANNERS

4203 MELROSE AVENUE
P.O. BOX 6260
ROANOKE, VIRGINIA 24017-0260
(540) 386-3400
FAX: (540) 386-3702