
 


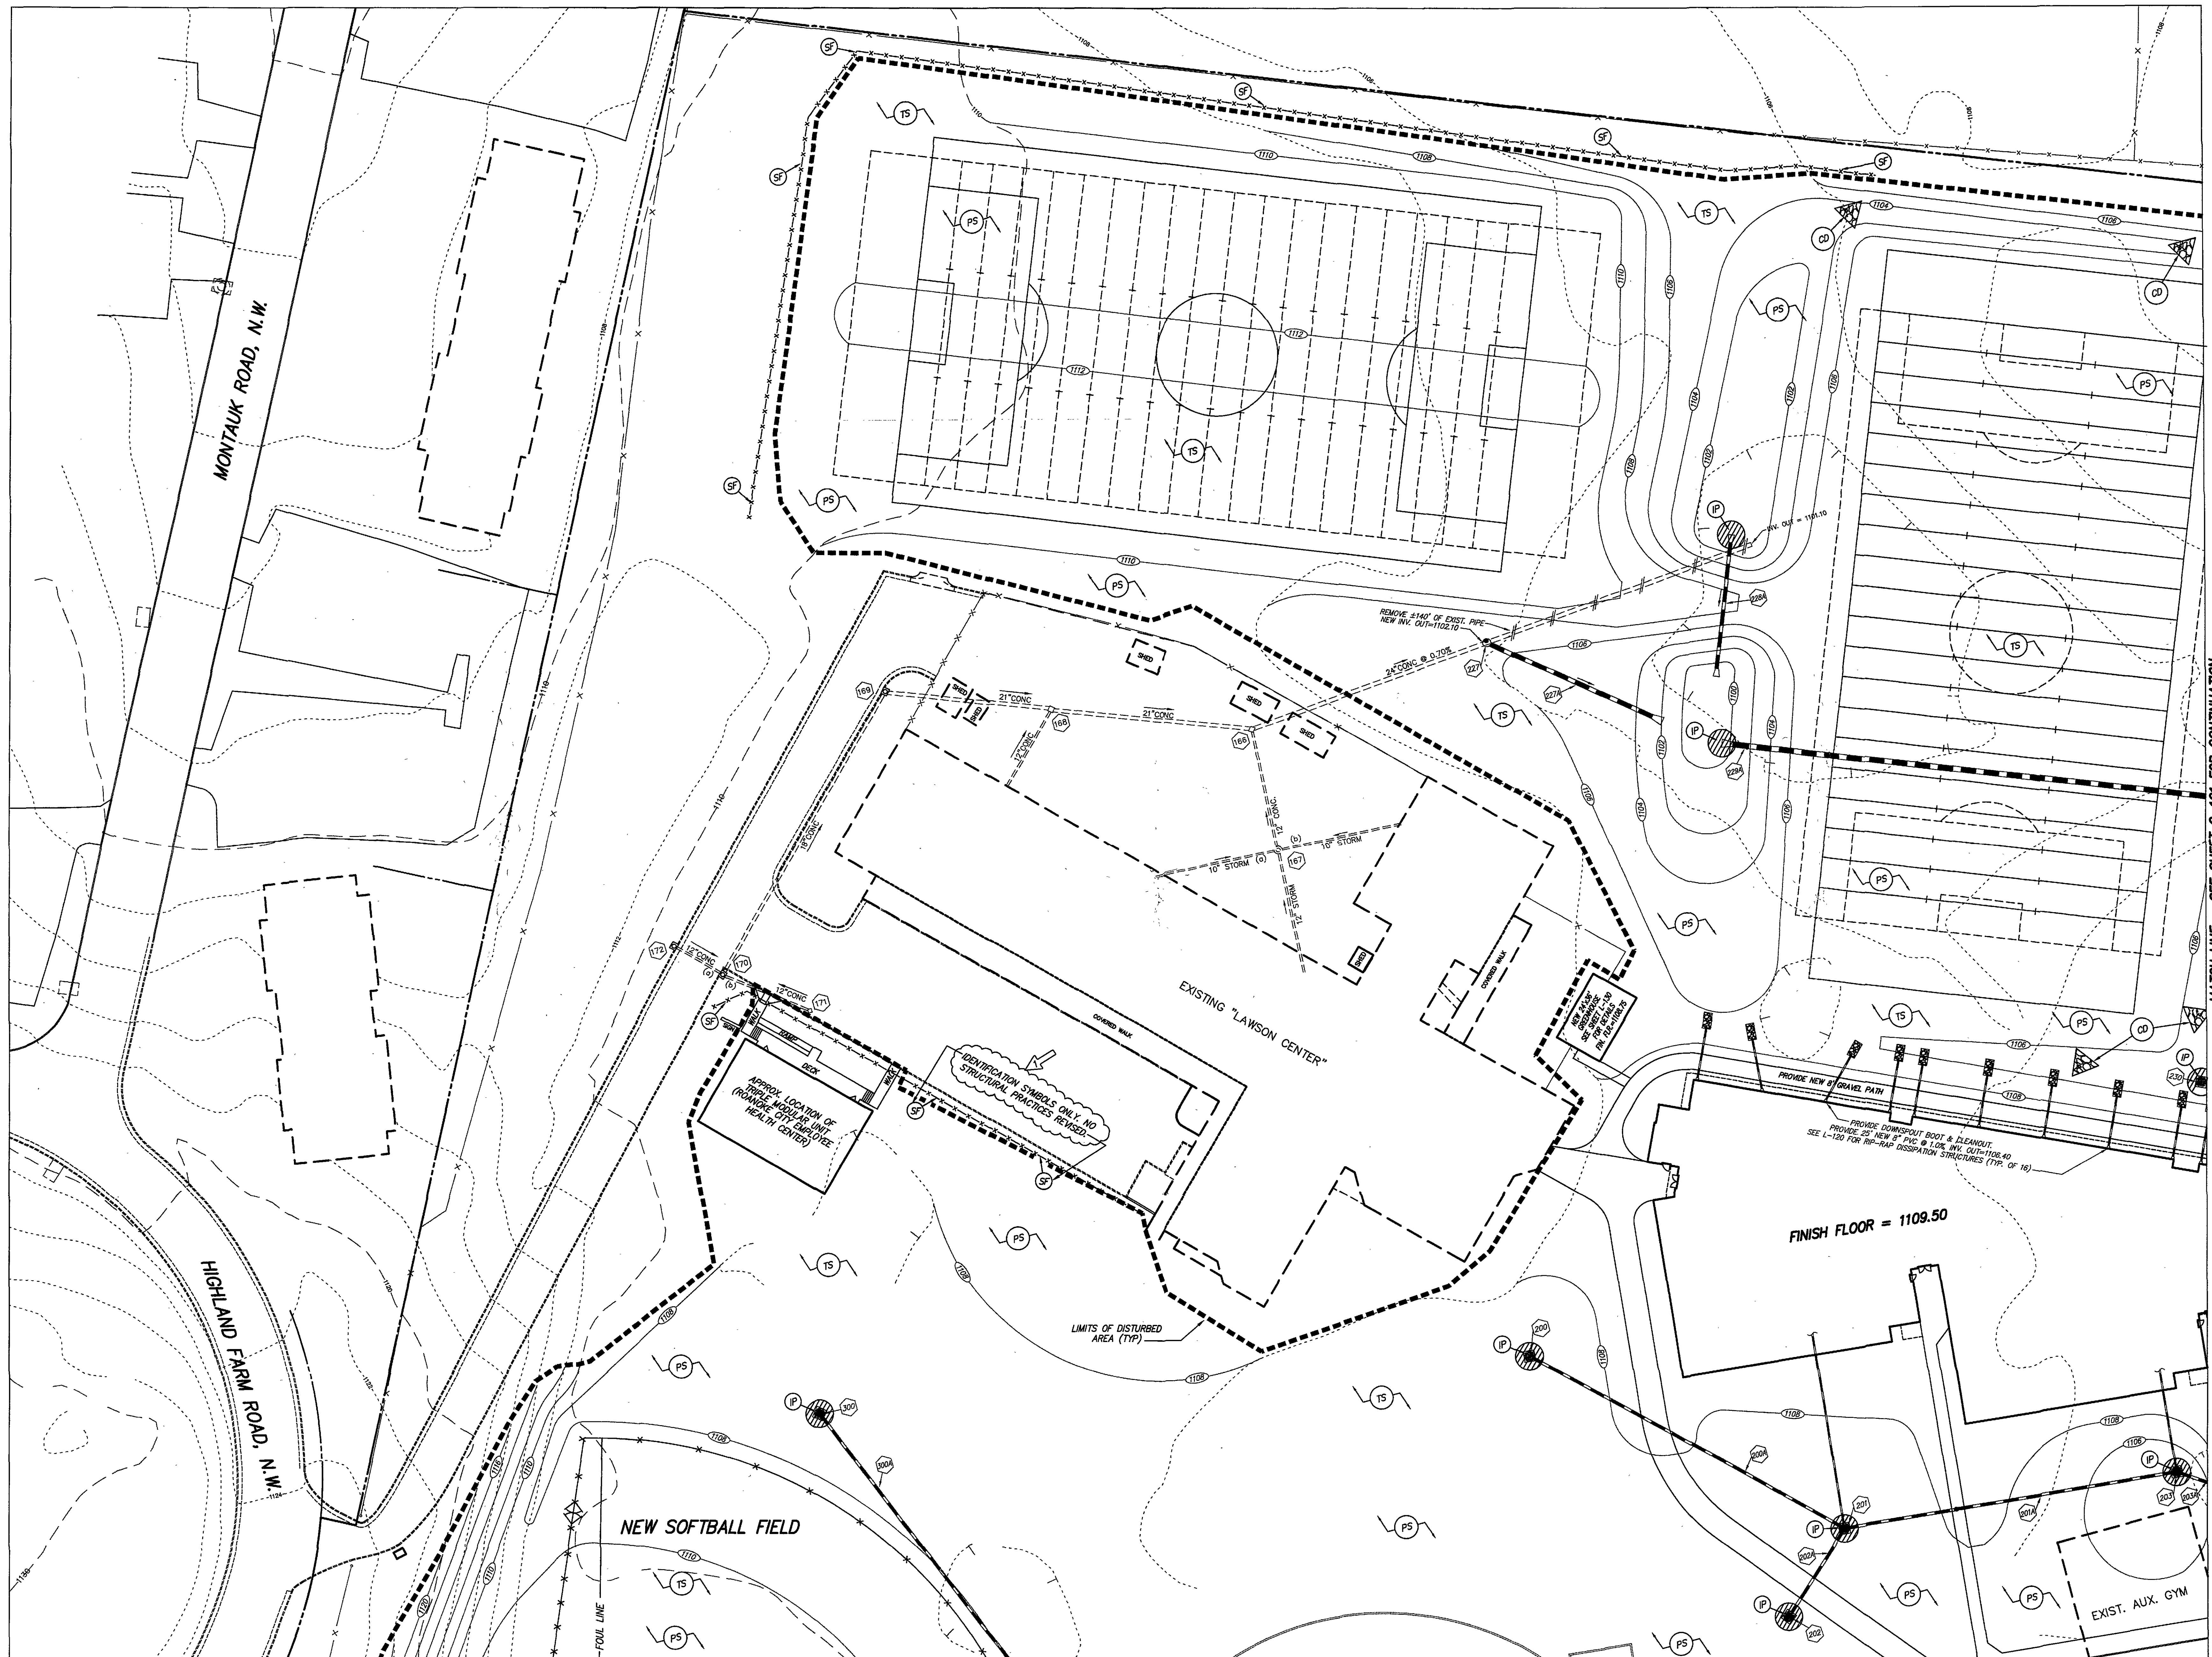

MATCH LINE - SEE SHEET C-123 FOR CONTINUATION



# PERKINS + WILL

1882 Peachtree St. NE  
Atlanta, GA 30309  
404.873.2500  
404.862.5523  
www.perkinswill.com

## Rife + Wood ARCHITECTS

128 Gaudin Road, Roanoke, Virginia 24011  
(904) 441-1111

In association with:

### Calder White Associates

Civil Consultant  
4203 Midway Avenue  
Roanoke, Virginia 24017  
540-386-3400 (o) 540-386-5702 (f)

### Fossan & Associates

Food Service Consultant  
6525 Southview Drive  
Charlotte, North Carolina 28227  
704-536-9234 (o) 704-535-4020 (f)

### Lawrence Perry & Associates

Mechanical & Electrical Consultants  
324 West Church Avenue  
Roanoke, Virginia 24011  
540-342-1816 (o) 540-344-3410 (f)

### R.A. Meador

Landscape Consultant  
P.O. Box 372  
Hardy, Virginia 24101  
540-890-4533 (o)

### Stewart Acoustical Consultants

Acoustical Consultant  
7408 L Chapel Hill Road  
Raleigh, North Carolina 27607  
919-858-0899 (o) 919-858-0878 (f)

### Uzun & Coe Engineers

Structural Consultant  
1180 West Peachtree Street - Suite 120  
Atlanta, Georgia 30308  
678-553-5200 (o) 678-553-5270 (f)


County of Loudoun, P.E. & P.S. 5

## CWA ENGINEERS / SURVEYORS / PLANNERS

CWA NO. 06-0089 NE: Rte. City Schools

## WILLIAM FLEMING HIGH SCHOOL

School Site Project No. 124-40A  
Literary Loan No. 11255

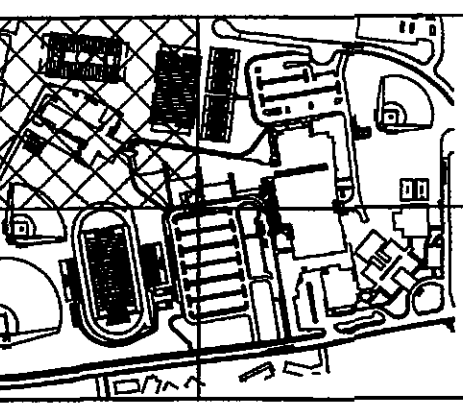


### KEY PLAN

| NO. | REVISION | DATE |
|-----|----------|------|
|     |          |      |
|     |          |      |
|     |          |      |
|     |          |      |
|     |          |      |

PER CITY AND ADDEN. 2 06/13/07  
NUMBER ISSUE DATE

### Revisions

Copyright © 2007 PERKINS + WILL

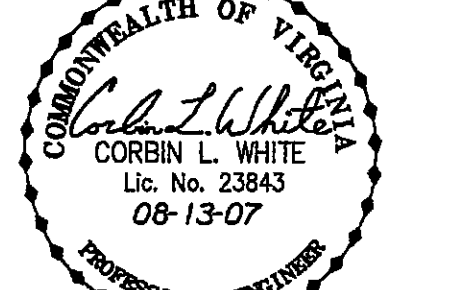

### Sheet Information

Date May 15, 2007  
Job Number 800372.000  
Scale 1" = 30'  
Drawn C.L. White  
Checked  
Approved

## SOIL EROSION CONTROL PLAN

Sheet

C-122

ISSUED FOR CONSTRUCTION