 




MATCH LINE - SEE SHEET C-133 FOR CONTINUATION



PERKINS + WILL

1382 Peachtree St. NE
Atlanta, GA 30309
t 404.873.2800
f 404.882.2623
www.perkinswill.com



In association with:

Calhoun White Associates
Civil Consultant
4203 Melrose Avenue
Roanoke, Virginia 24011
540-366-3400 (p) 540-366-8702 (f)


Fassett & Associates
Food Service Consultant
8526 Sunflower Drive
Charlotte, North Carolina 28227
704-536-9234 (p) 704-535-4028 (f)

Lawrence Perry & Associates
Mechanical & Electrical Consultants
324 West Church Avenue
Roanoke, Virginia 24011
540-342-1816 (p) 540-344-3410 (f)

R.A. Meador
Landscape Consultant
P.O. Box 372
Hardy, Virginia 24101
540-890-4533 (p)

Stewart Acoustical Consultants
Acoustical Consultant
7406 L Chapel Hill Road
Raleigh, North Carolina 27607
919-858-0659 (p) 919-858-0678 (f)


Uzun & Case Engineers
Structural Consultant
1190 West Peachtree Street - Suite 120
Atlanta, Georgia 30309
678-553-5200 (p) 678-553-5270 (f)

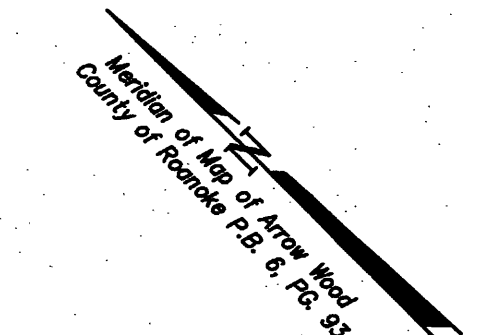

CWA
ENGINEERS / SURVEYORS / PLANNERS
CWA No. 06-0089 ME: Rife, City, Schools

WILLIAM FLEMING HIGH SCHOOL

School Site Project No. 124-40A
Literary Loan No. 11265

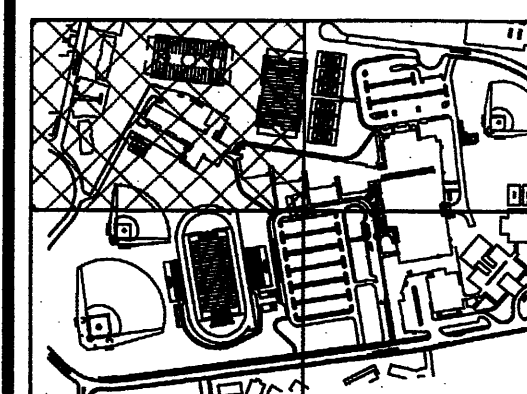


KEY PLAN

NUMBER	ISSUE	DATE

Revisions

Copyright © 2007 PERKINS + WILL

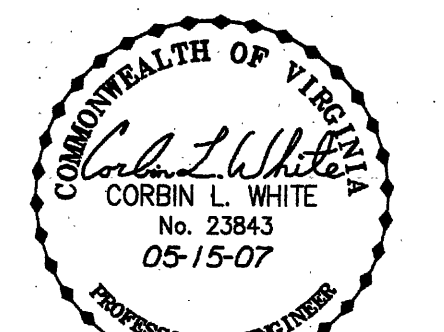

Sheet Information

Date: May 15, 2007
Job Number: 800372.000
Scale: 1" = 30'
Drawn: C.L. White
Checked:
Approved:

Title

GRADING AND
STORM
DRAINAGE PLAN

Sheet

C-132

ISSUED FOR CONSTRUCTION