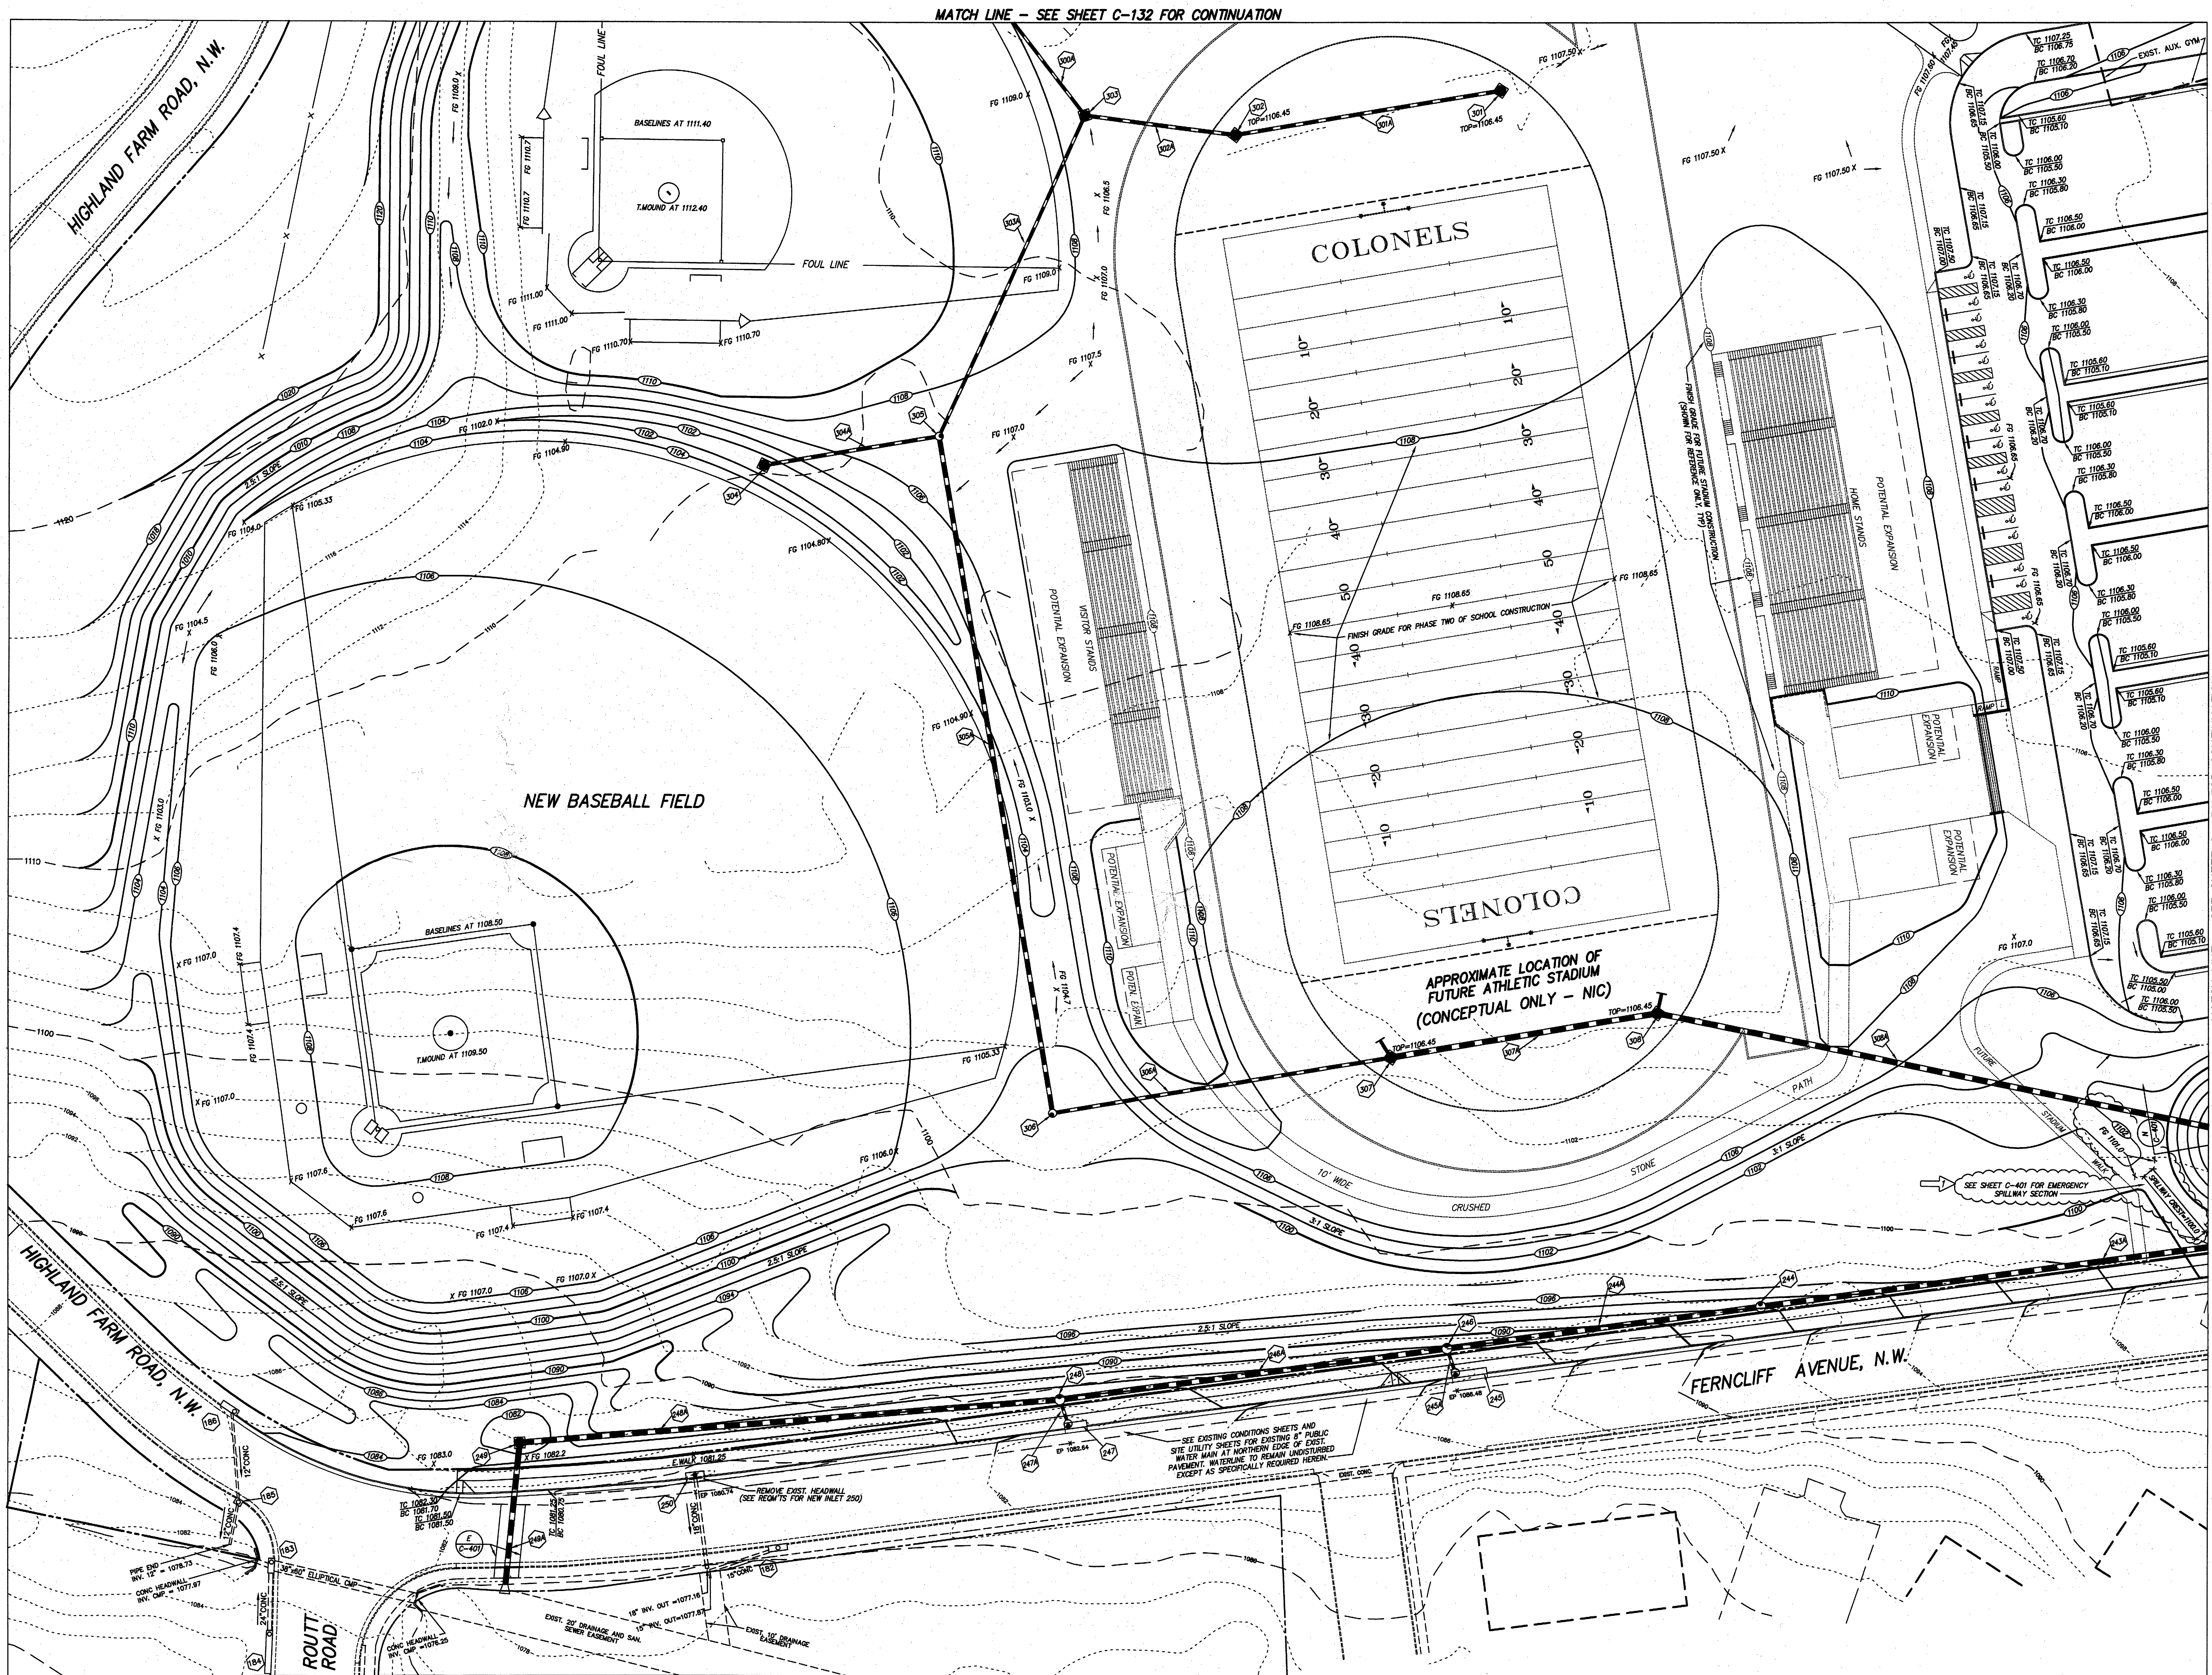


PERKINS + WILL

1382 Peachtree St. NE
Atlanta, GA 30309
T: 404.873.2800
F: 404.892.5823
www.perkinswill.com

Rife + Wood ARCHITECTS
1330 Peachtree Avenue, N.E.
(404) 344-4811 Fax (404) 344-9282

In association with:

Calder White Associates
Civil Consultant
4203 Metros Avenue
Roswell, Georgia 30075
540-356-3400 (p) 540-356-5702 (f)

Fasson & Associates
Food Service Consultant
2525 Safflower Drive
Charlotte, North Carolina 28227
704-538-9234 (p) 704-535-4020 (f)

Lawrence Perry & Associates
Mechanical & Electrical Consultants
304 West Church Avenue
Roanoke, Virginia 24011
540-342-1818 (p) 540-344-3410 (f)

R.A. Meador
Landscape Consultant
P.O. Box 372
Hardy, Virginia 24101
540-890-4533 (p)

Stewart Acoustical Consultants
Acoustical Consultant
7406 L Chapel Hill Road
Raleigh, North Carolina 27607
919-858-0889 (p) 919-858-0878 (f)

Uran & Case Engineers
Structural Consultant
1180 West Peachtree Street - Suite 120
Atlanta, Georgia 30309
678-553-5200 (p) 678-553-5270 (f)

CWA
ENGINEERS / SURVEYORS / PLANNERS
CWA REG. 06-0089 NR. Rite City Schools

WILLIAM FLEMING HIGH SCHOOL
School Site Project No. 124-40A
Literary Loan No. 11255

KEY PLAN

NUMBER	ISSUE	DATE
1	PER CITY AND ADDEN. 2	08/13/07

Revisions

Copyright © 2007 PERKINS + WILL

Seal of the State of Virginia
CORBIN L. WHITE
Lic. No. 23863
08-13-07
PROFESSIONAL ENGINEER

Sheet Information

Date: May 15, 2007
Job Number: 800372.000
Scale: 1" = 30'
Drawn: C.L. White
Checked:
Approved:

Title

GRADING AND STORM DRAINAGE PLAN

Sheet

C-133

ISSUED FOR CONSTRUCTION