



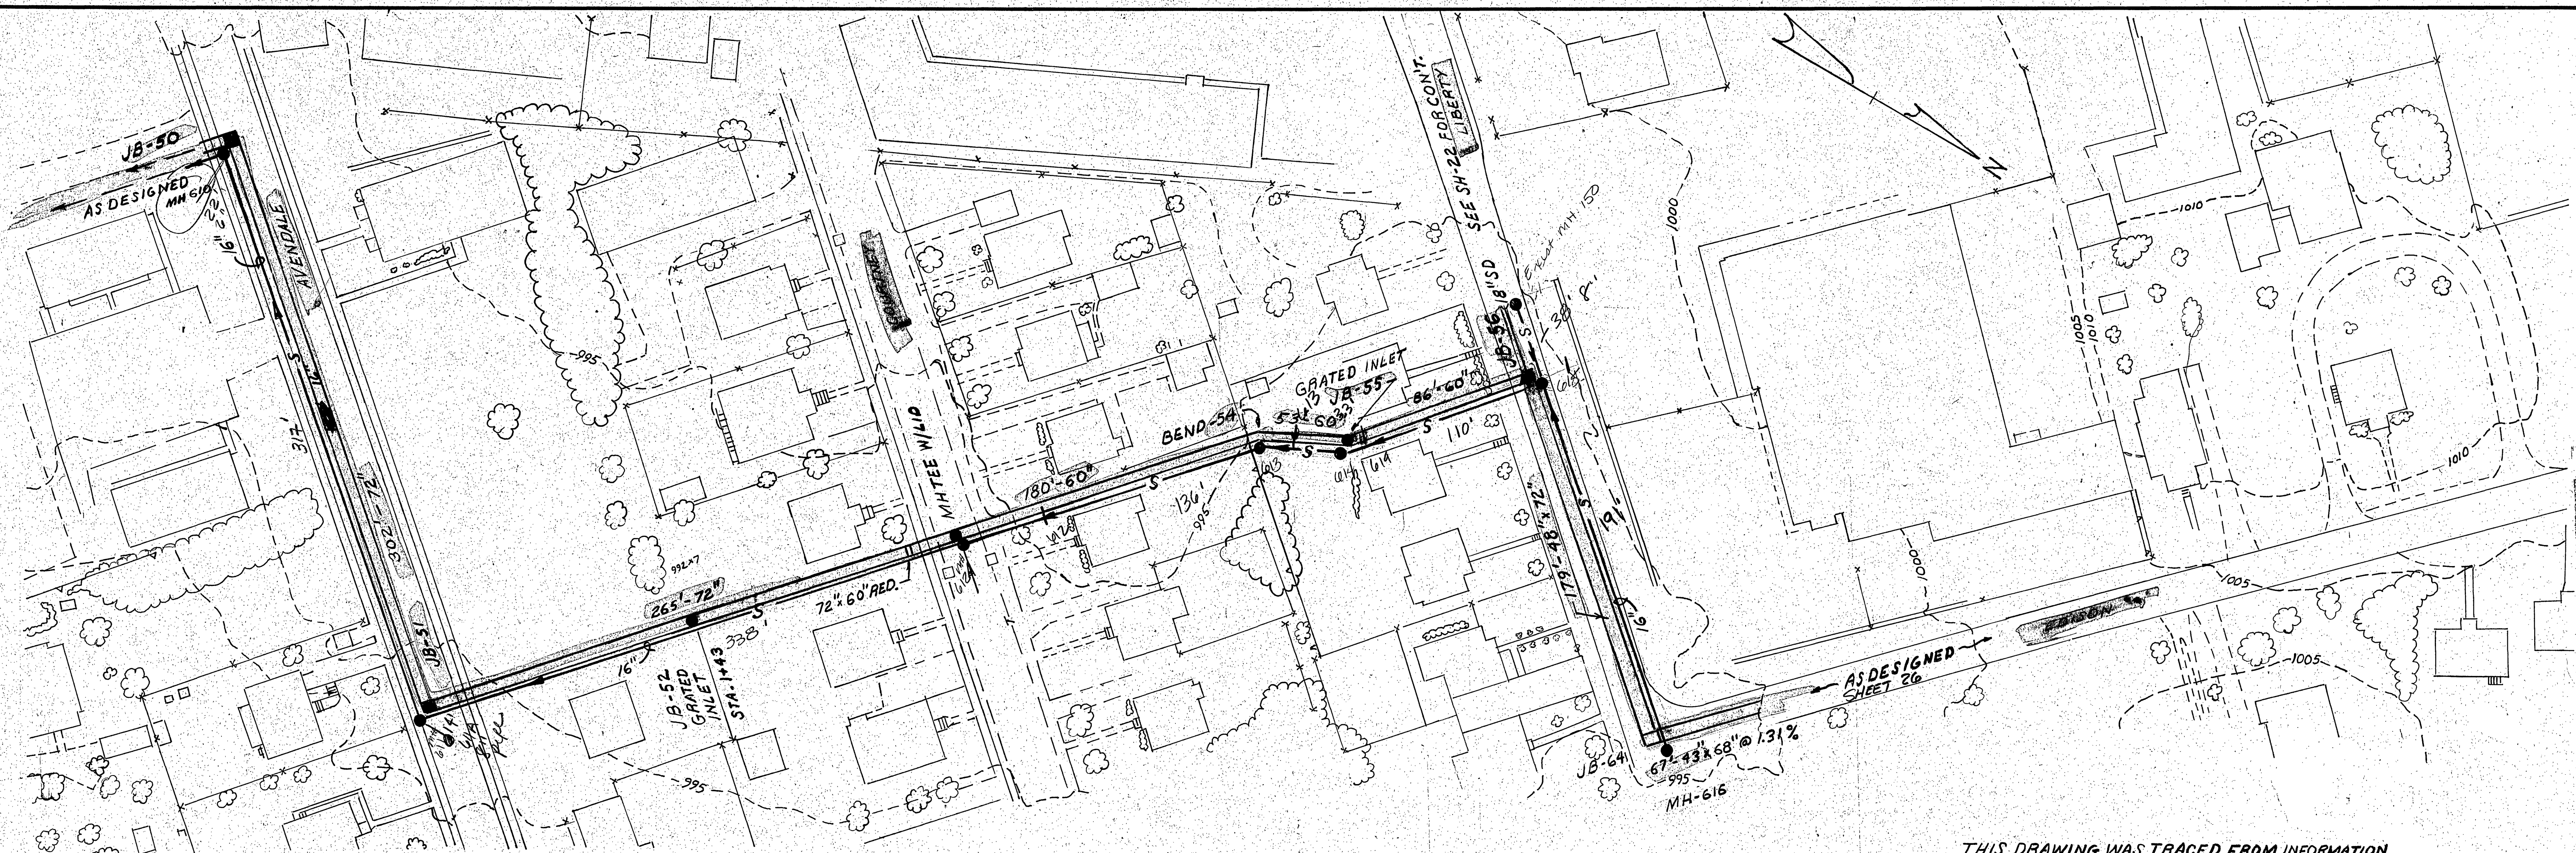

PLAN OF
 SANITARY SEWER AND STORM DRAIN RELOCATIONS
 SAN MH 610 - MH 616, S.D. JB-50 - JB-64
 PLAN SCALE: 1"=40'

THIS DRAWING WAS TRACED FROM INFORMATION
 FURNISHED BY LARRY CONNER OF THE AARON J.
 CONNER CONSTRUCTION CO. (SCALE: 1"=40').
 AS PART OF RECORDED DRAWINGS.

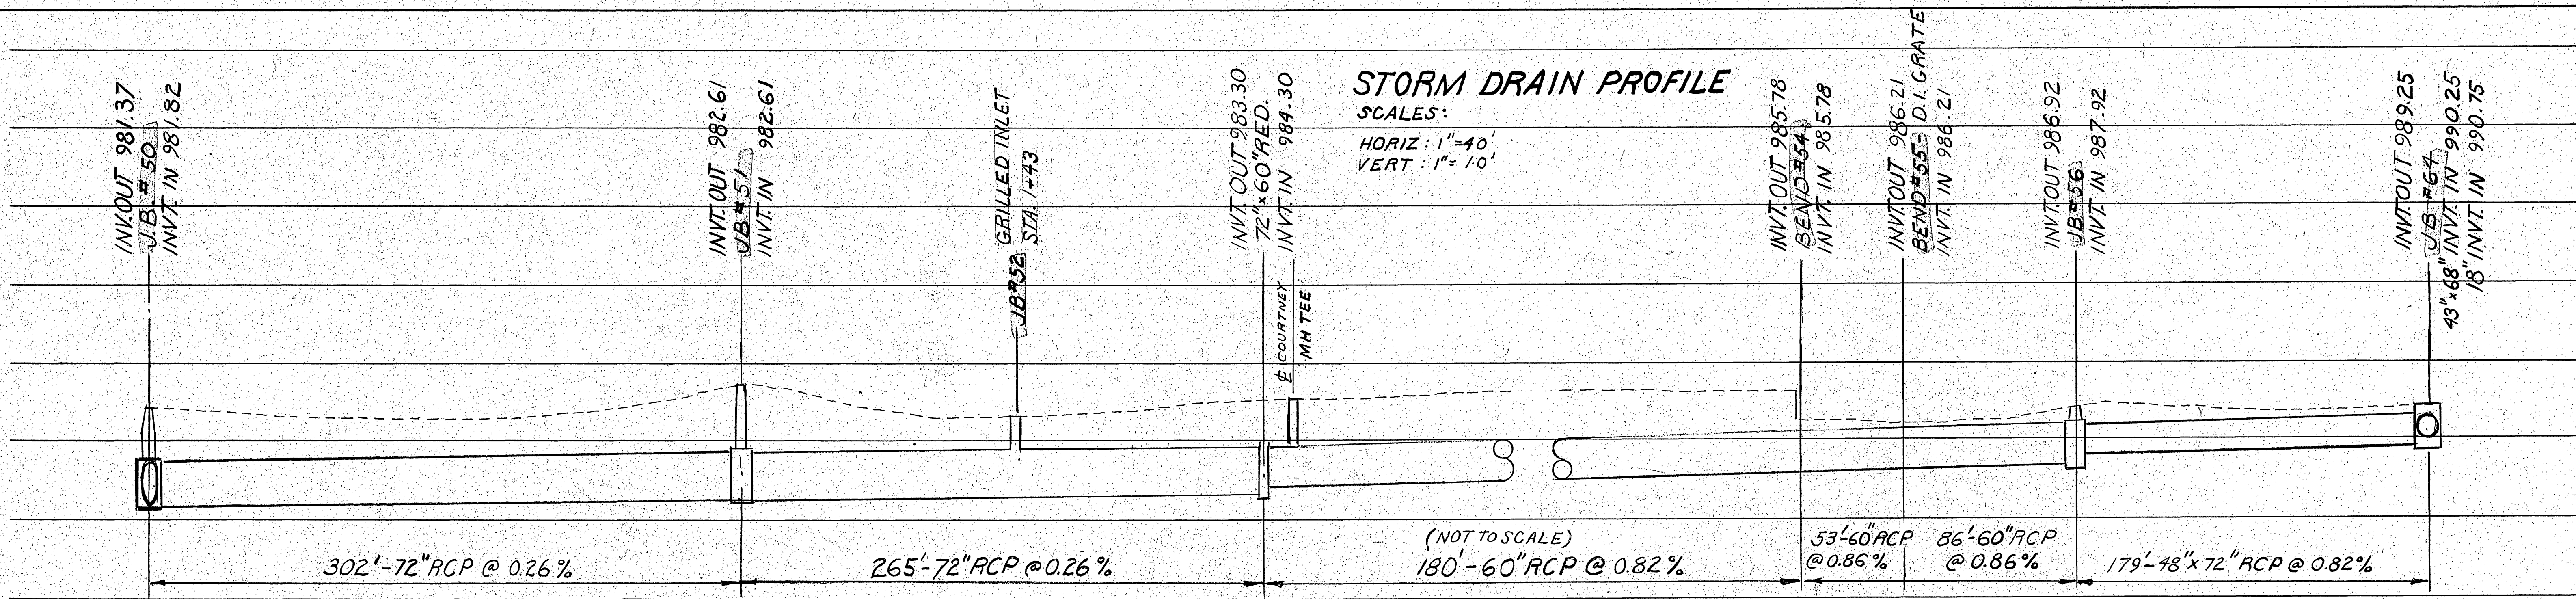

STORM DRAIN PROFILE
 SCALES:
 HORIZ: 1"=40'
 VERT: 1"=10'



DESIGNED:
 CHECKED:
 APPROVED:

REVISION	DATE	DESCRIPTION	BY	APP.
1	11-10-86	RECORD DRAWINGS	JD	

DATE
NOV. 1986
 COMM.
428

WILLIAMSON ROAD STORM DRAIN - PHASE 1
CONTRACT I
 ROANOKE, VIRGINIA
PLAN AND PROFILE

SHEET
20A