


PROJECT LOCATION MAP

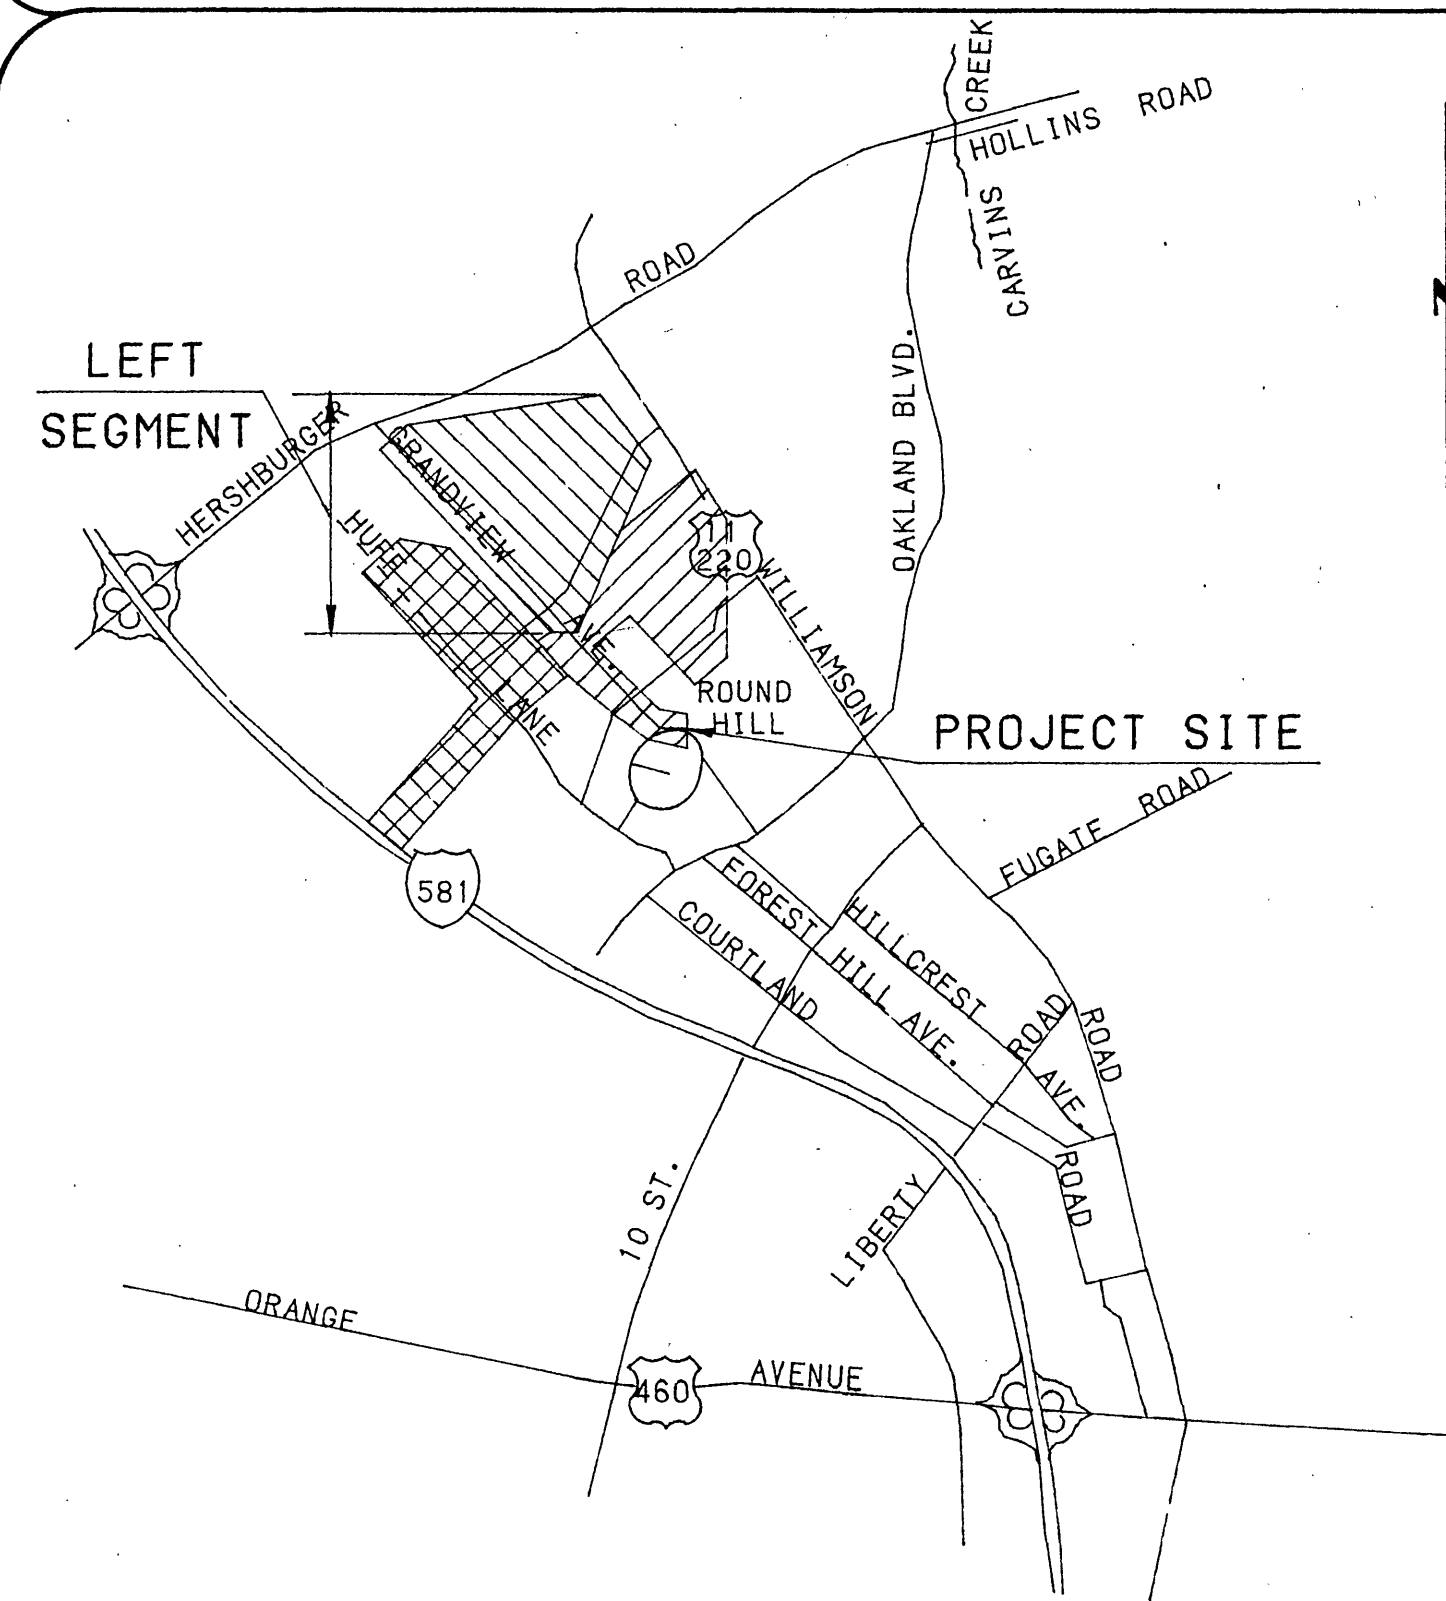

CITY OF
ROANOKE
VIRGINIA

OFFICE OF CITY ENGINEER
ROOM 350
MUNICIPAL BUILDING
215 CHURCH AVENUE, S.W.
ROANOKE, VIRGINIA 24011

INDEX OF SHEETS

SHEET NO.	TITLE	SHEET NO.	TITLE
1.	COVER SHEET	32.	PLAN AND PROFILE
2.	QUANTITY SHEET	33.	PLAN AND PROFILE
3.	ABBREVIATIONS, LEGEND AND GENERAL NOTES	34.	PLAN AND PROFILE
4.	INDEX MAP	35.	PLAN AND PROFILE
5.	PLAN AND PROFILE	36.	PLAN AND PROFILE
6.	PLAN AND PROFILE	37.	PLAN AND PROFILE
7.	PLAN AND PROFILE	38.	PLAN AND PROFILE
8.	PLAN AND PROFILE	39.	PLAN AND PROFILE
9.	PLAN AND PROFILE	40.	SEWER PROFILE
10.	PLAN AND PROFILE	41.	SEWER PROFILE
11.	PLAN AND PROFILE	42.	SEWER PROFILE
12.	PLAN AND PROFILE	43.	SEWER PROFILE
13.	PLAN AND PROFILE	44.	SEWER PROFILE
14.	PLAN AND PROFILE	45.	NOT USED
15.	PLAN AND PROFILE	46.	INLET SCHEDULE
16.	PLAN AND PROFILE		
17.	PLAN AND PROFILE		
18.	PLAN AND PROFILE		
19.	PLAN AND PROFILE		
20.	PLAN AND PROFILE		
21.	PLAN AND PROFILE		
22.	PLAN AND PROFILE		
23.	PLAN AND PROFILE		
24.	PLAN AND PROFILE		
25.	PLAN AND PROFILE		
25A.	PLAN AND PROFILE		
25B.	PLAN AND PROFILE		
26.	PLAN AND PROFILE		
27.	PLAN AND PROFILE		
28.	PLAN AND PROFILE		
29.	PLAN AND PROFILE		
30.	PLAN AND PROFILE		
31.	PLAN AND PROFILE		
31A.	PLAN AND PROFILE		

CONSULTING ENGINEERS

MATTERN & CRAIG


CONSULTING ENGINEERS

SURVEYORS

701 FIRST STREET

ROANOKE, VIRGINIA

COMMISSION NUMBER: 582

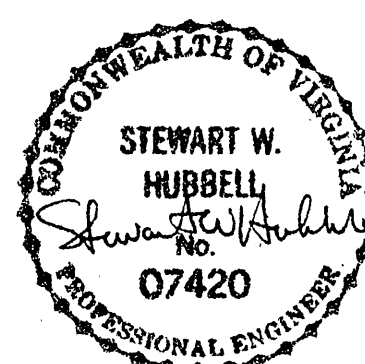

PROJECT NAME

WILLIAMSON ROAD STORM DRAIN
PHASE 2 CONTRACT I-G
LEFT SEGMENT

PROJECT NUMBER: 5831

RECORD DRAWINGS

REVISION BY	DESCRIPTION	DATE
REVISION BY	DESCRIPTION	DATE
REVISION BY	DESCRIPTION	DATE
REVISION BY	DESCRIPTION	DATE

APPROVED FOR CONSTRUCTION

Charles M. Huffer
ROANOKE CITY ENGINEER

7/18/89
DATE

William M. Mullen
DIRECTOR OF PUBLIC WORKS

7/18/89
DATE

Jim D. ...
DIRECTOR OF PUBLIC UTILITIES AND OPERATIONS

7/20/89
DATE

DATE

DATE

DATE

ADVERTISED DATE: JULY 30, 1989

SET NUMBER: 7

SHEET NUMBER: 1 OF 46

Tony L. Scott
4304 Caryville St.
3627579