

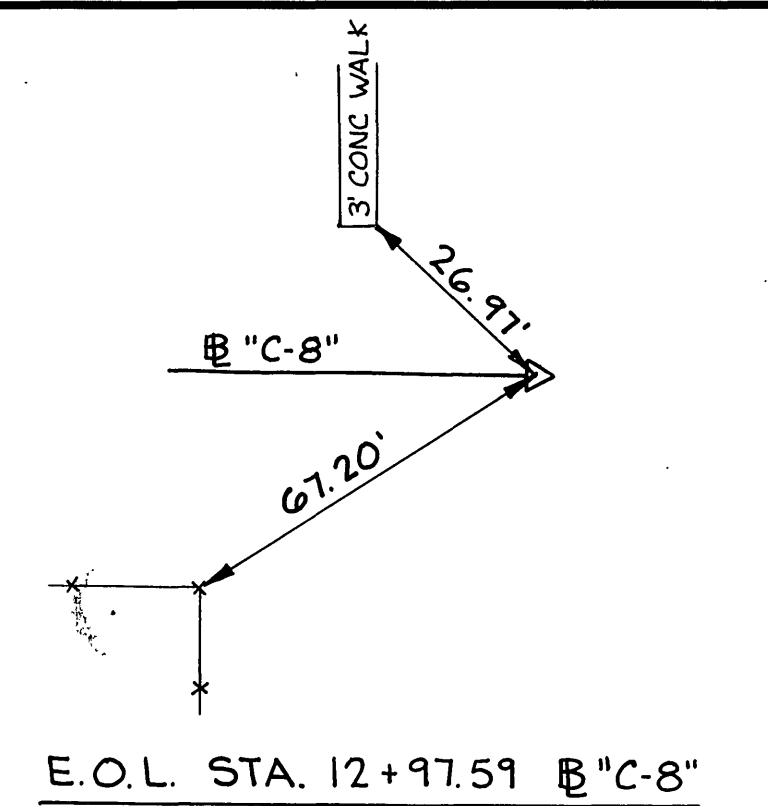


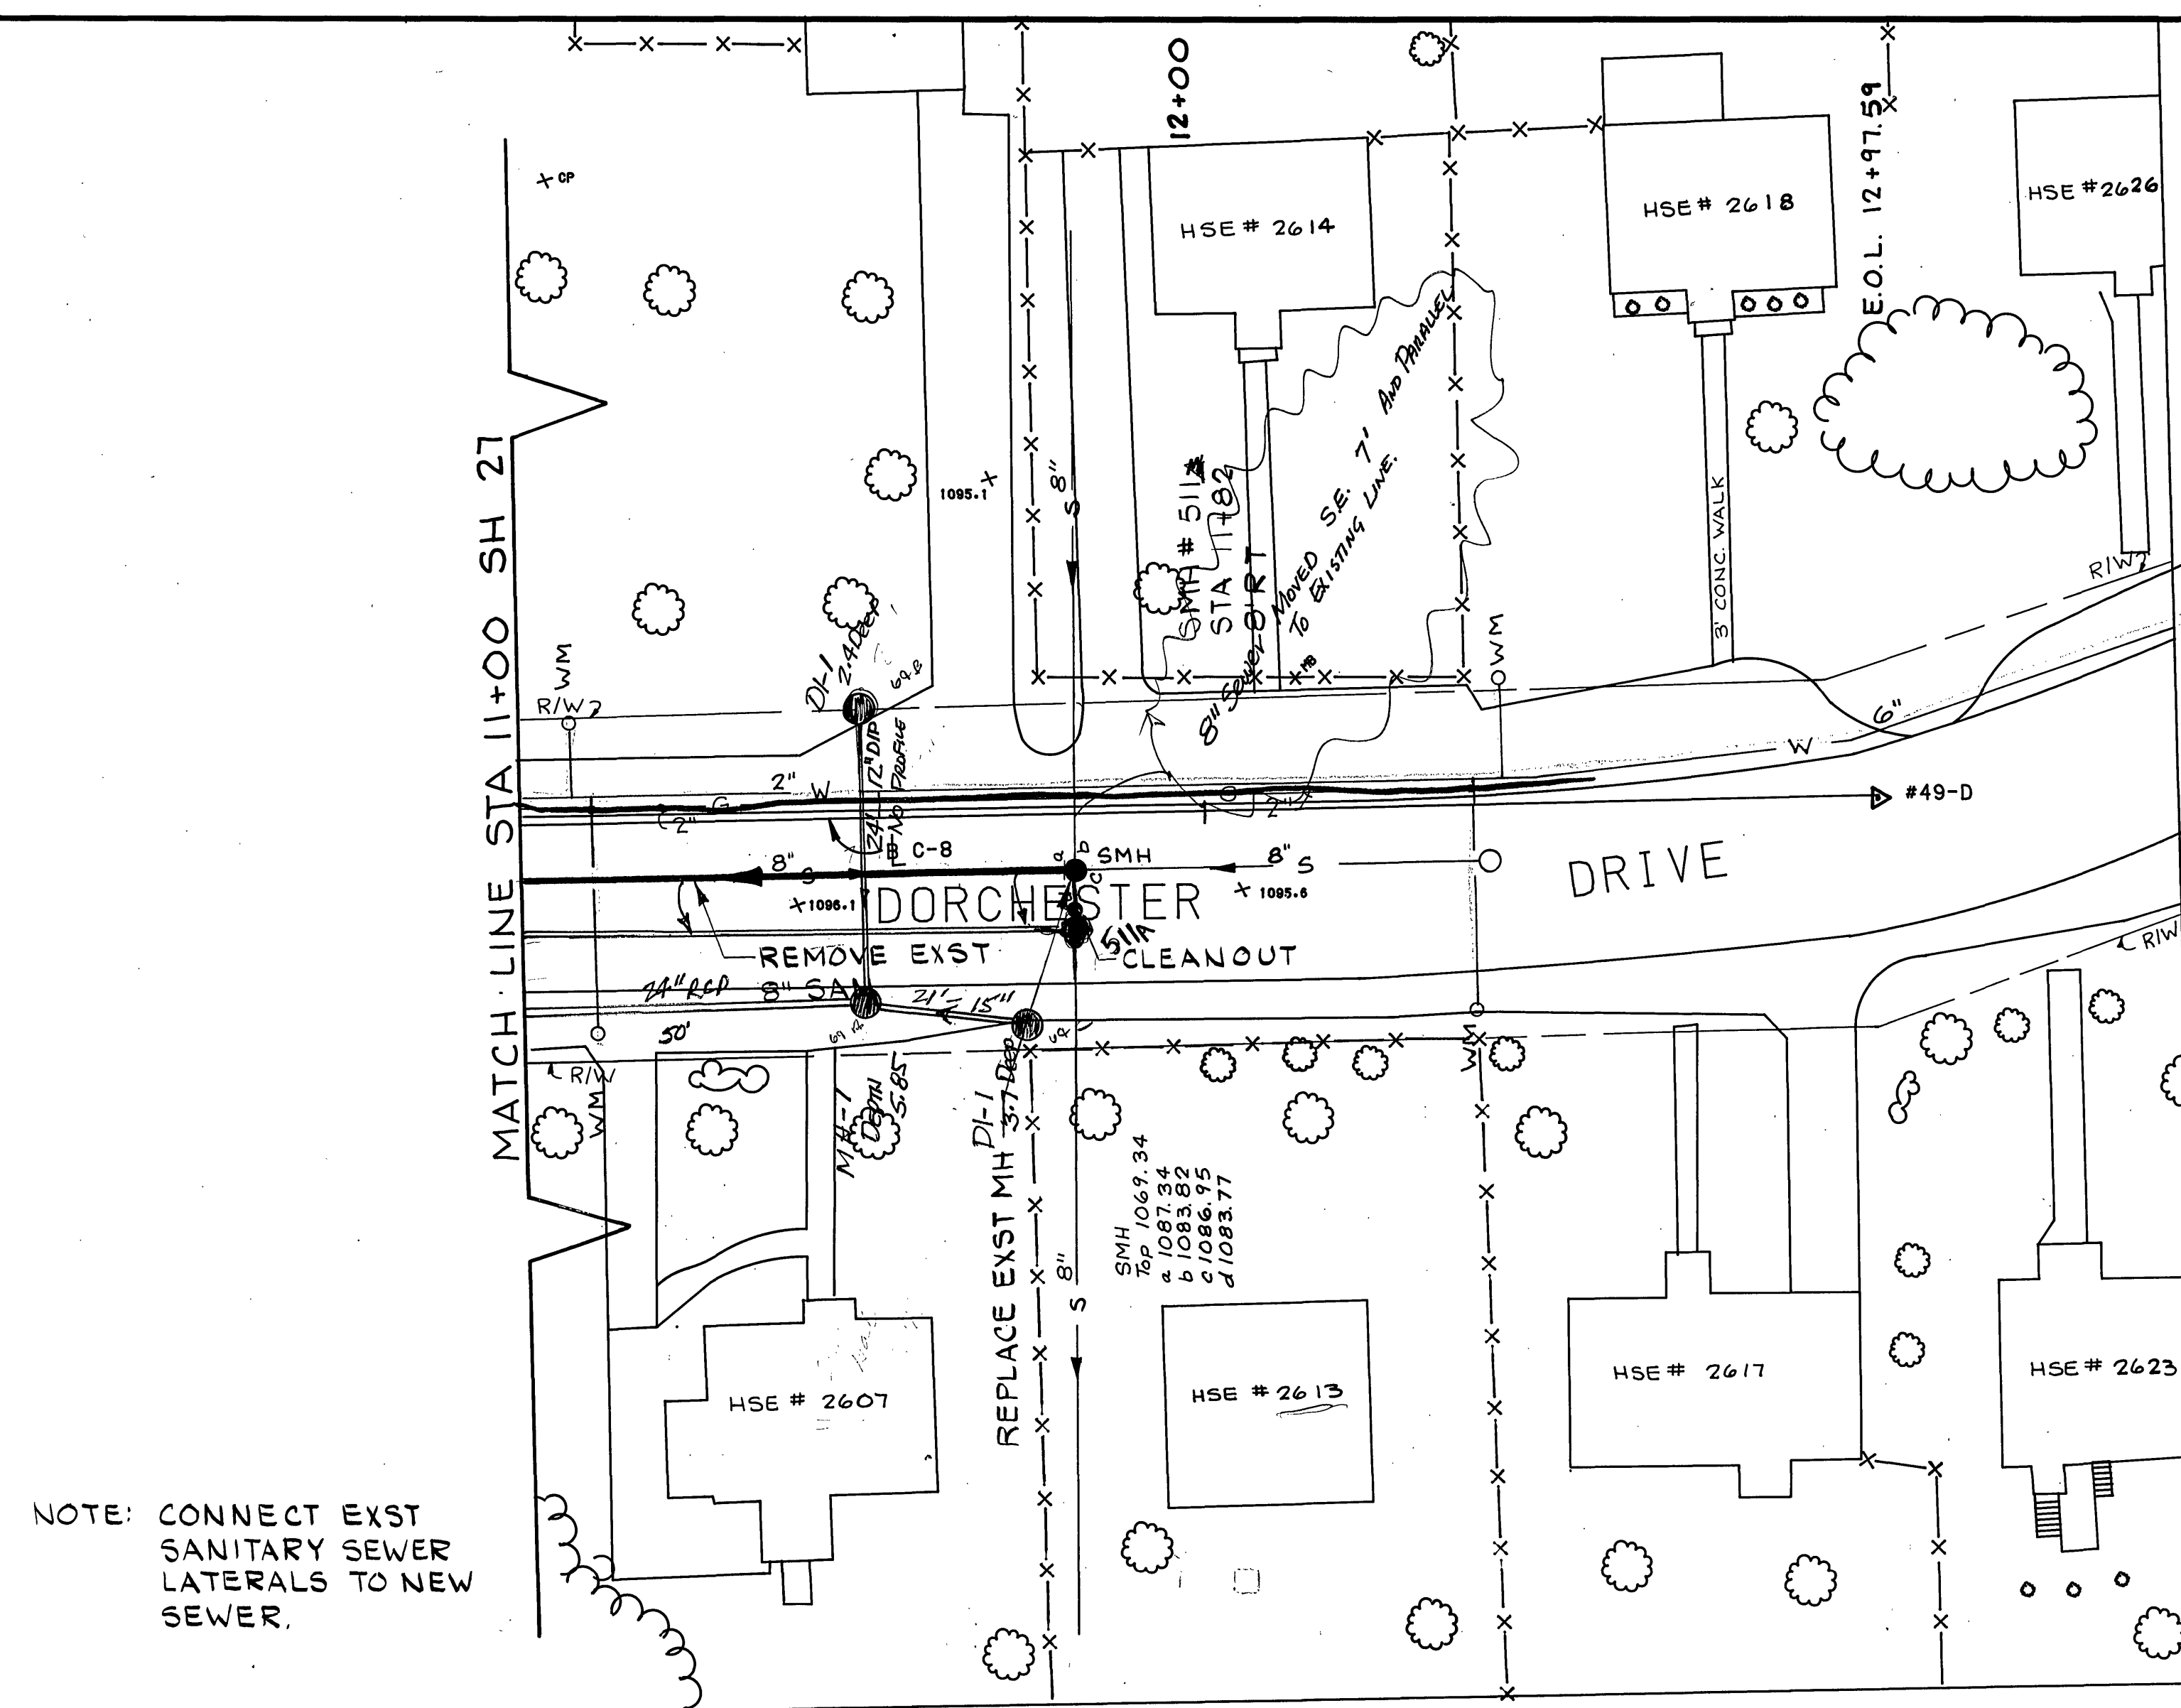



SCALE: HORIZ 1"=20'
VERT 1"=10'

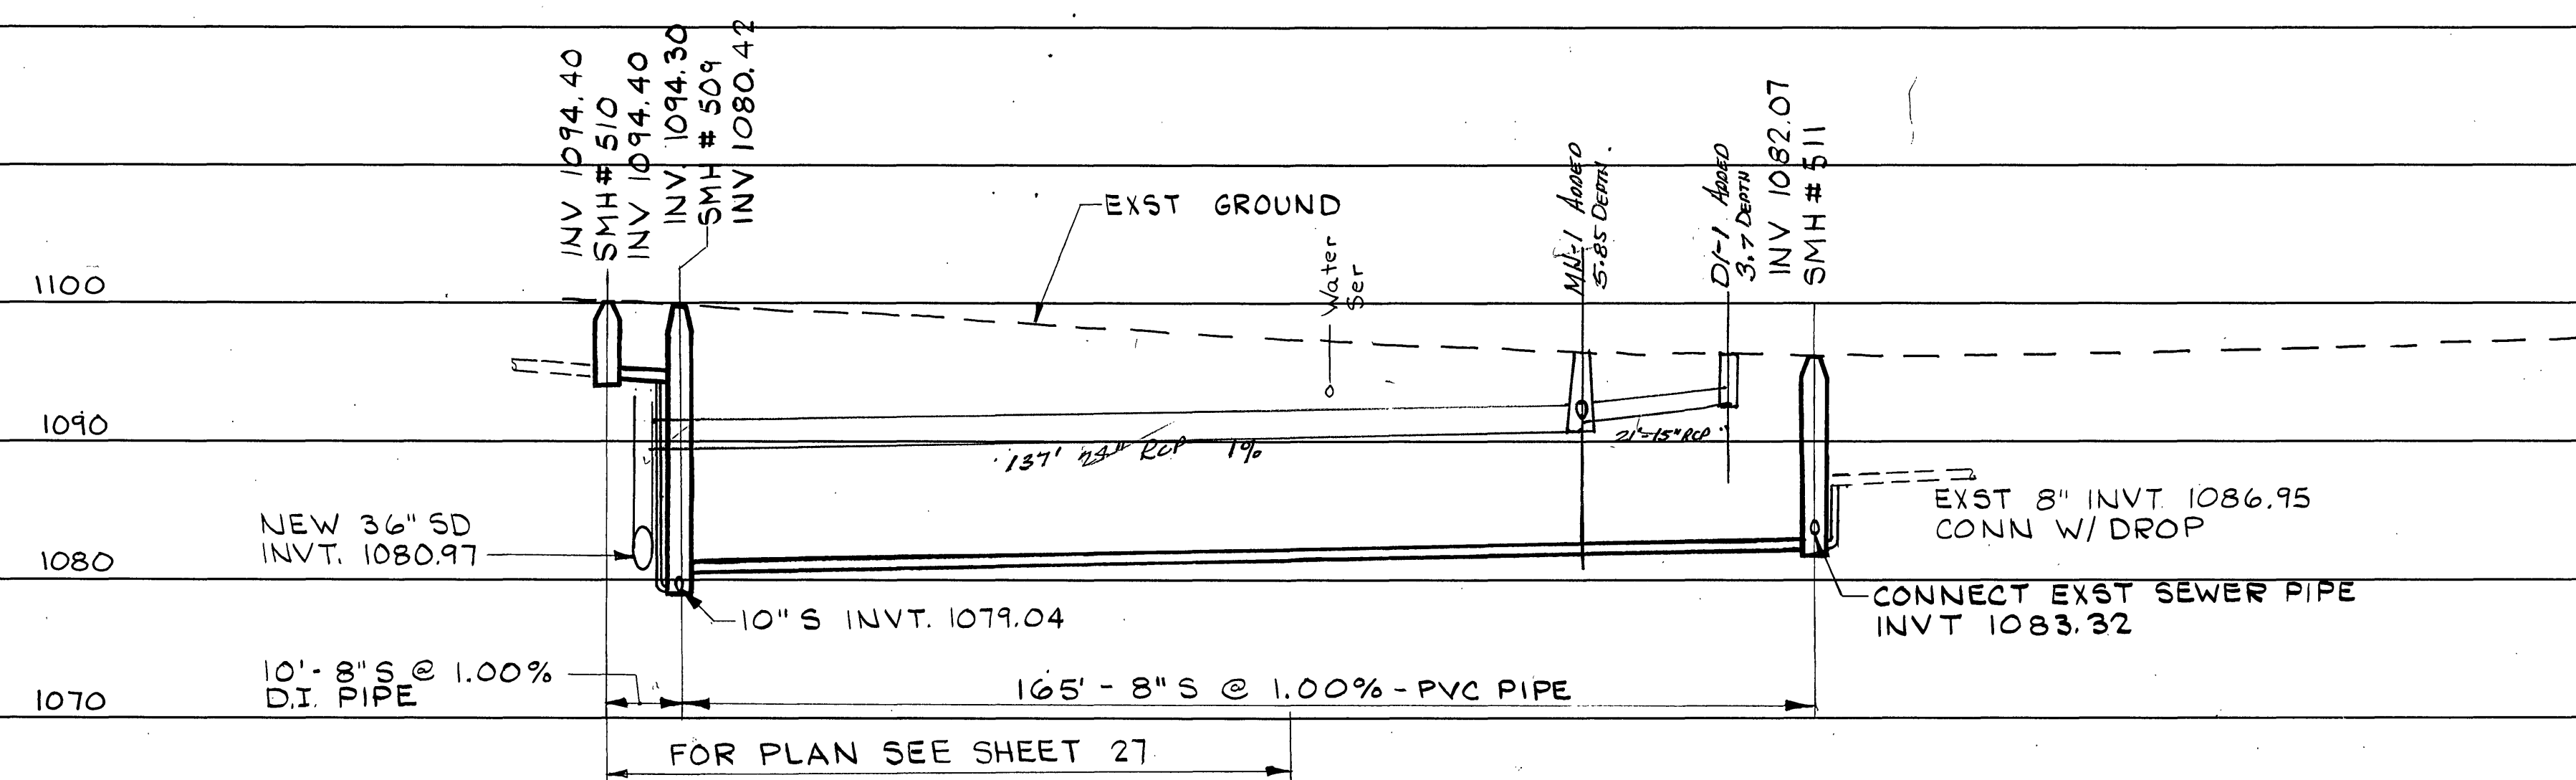

Mattern & Craig
CONSULTING ENGINEERS - SURVEYORS

701 FIRST STREET, ROANOKE, VIRGINIA 24016. (703) 345-8342

DESIGNED:	JLJ / SWH
CHECKED:	SWH
APPROVED:	SWH

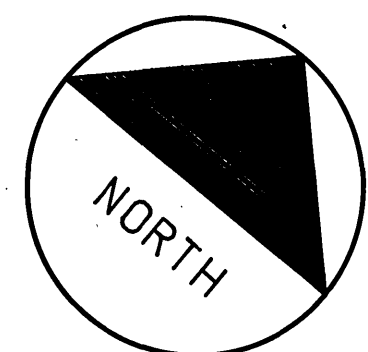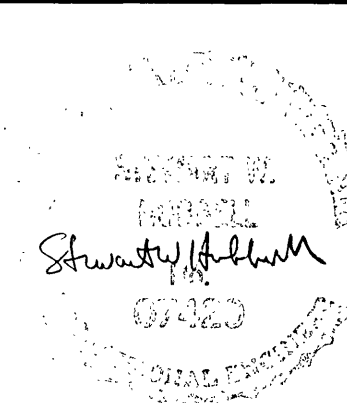[illegible]

DATE
JULY
1986
COMM.
582

WILLIAMSON ROAD STORM DRAIN- PHASE 2
CONTRACT I-C
ROANOKE, VIRGINIA

PLAN AND PROFILE

1A