



MATCH LINE STA. 10+90 SH. 42

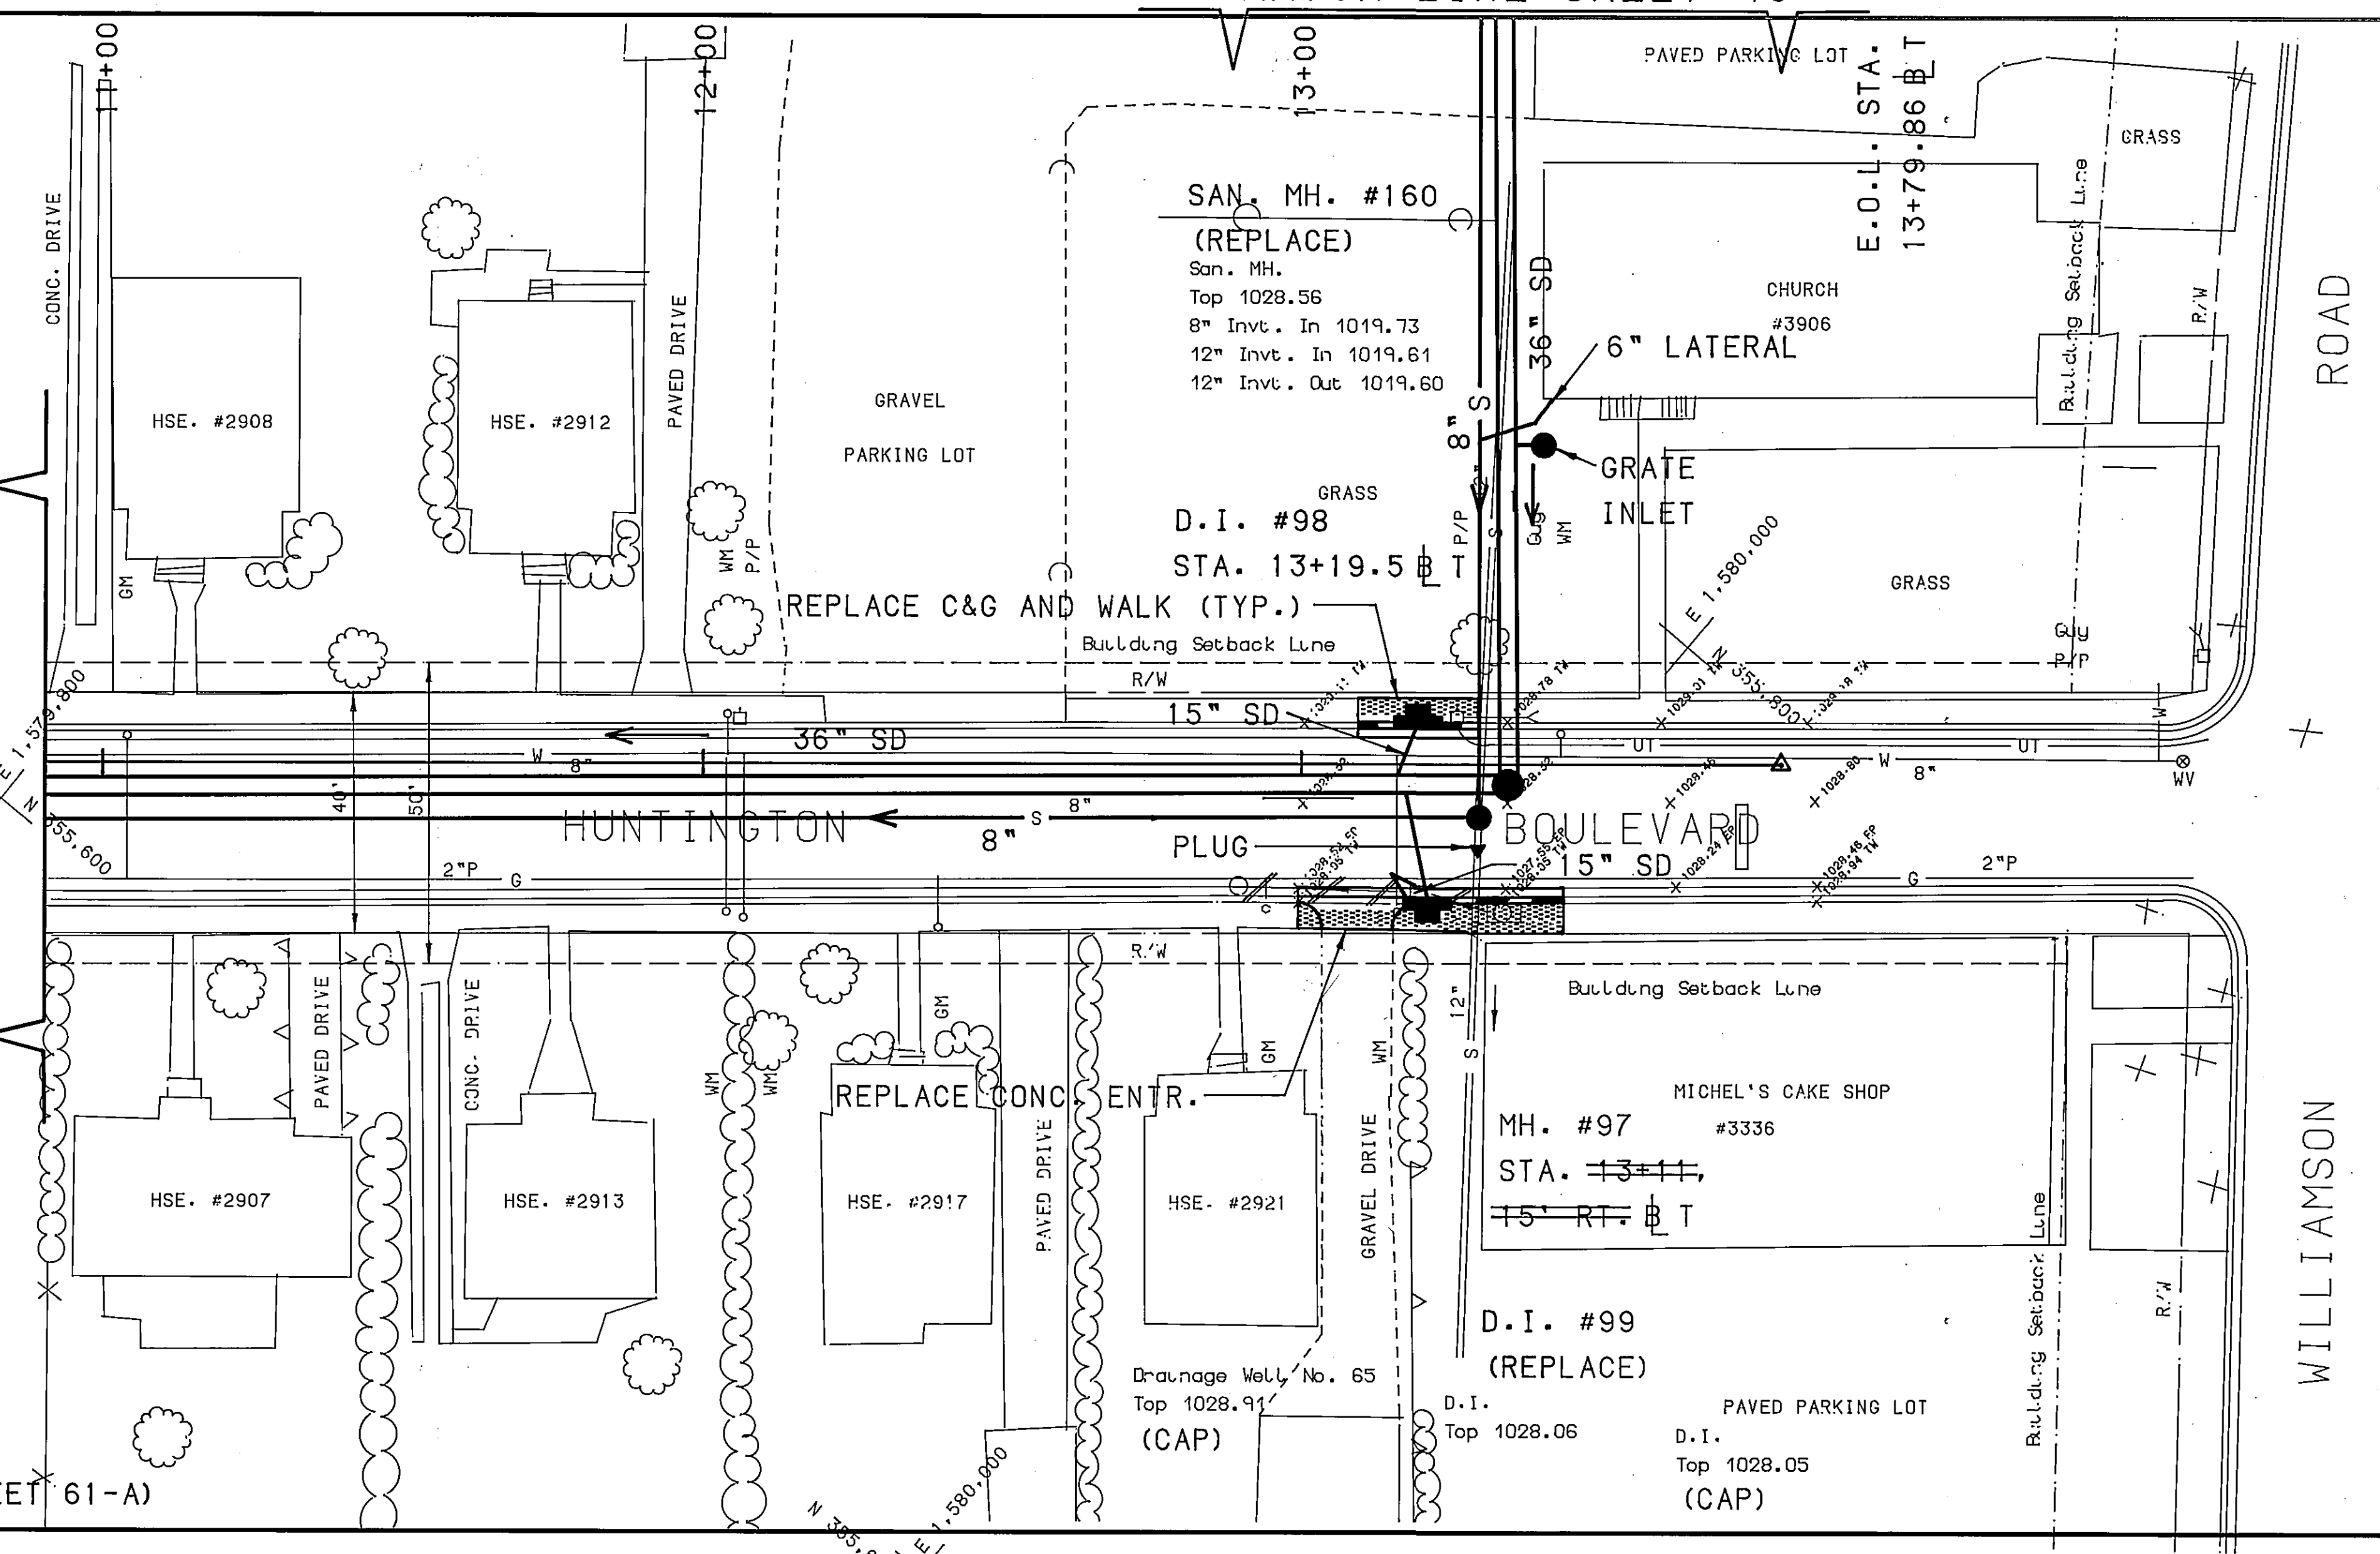



(FOR SANITARY PROFILE SEE SHEET 61-A)

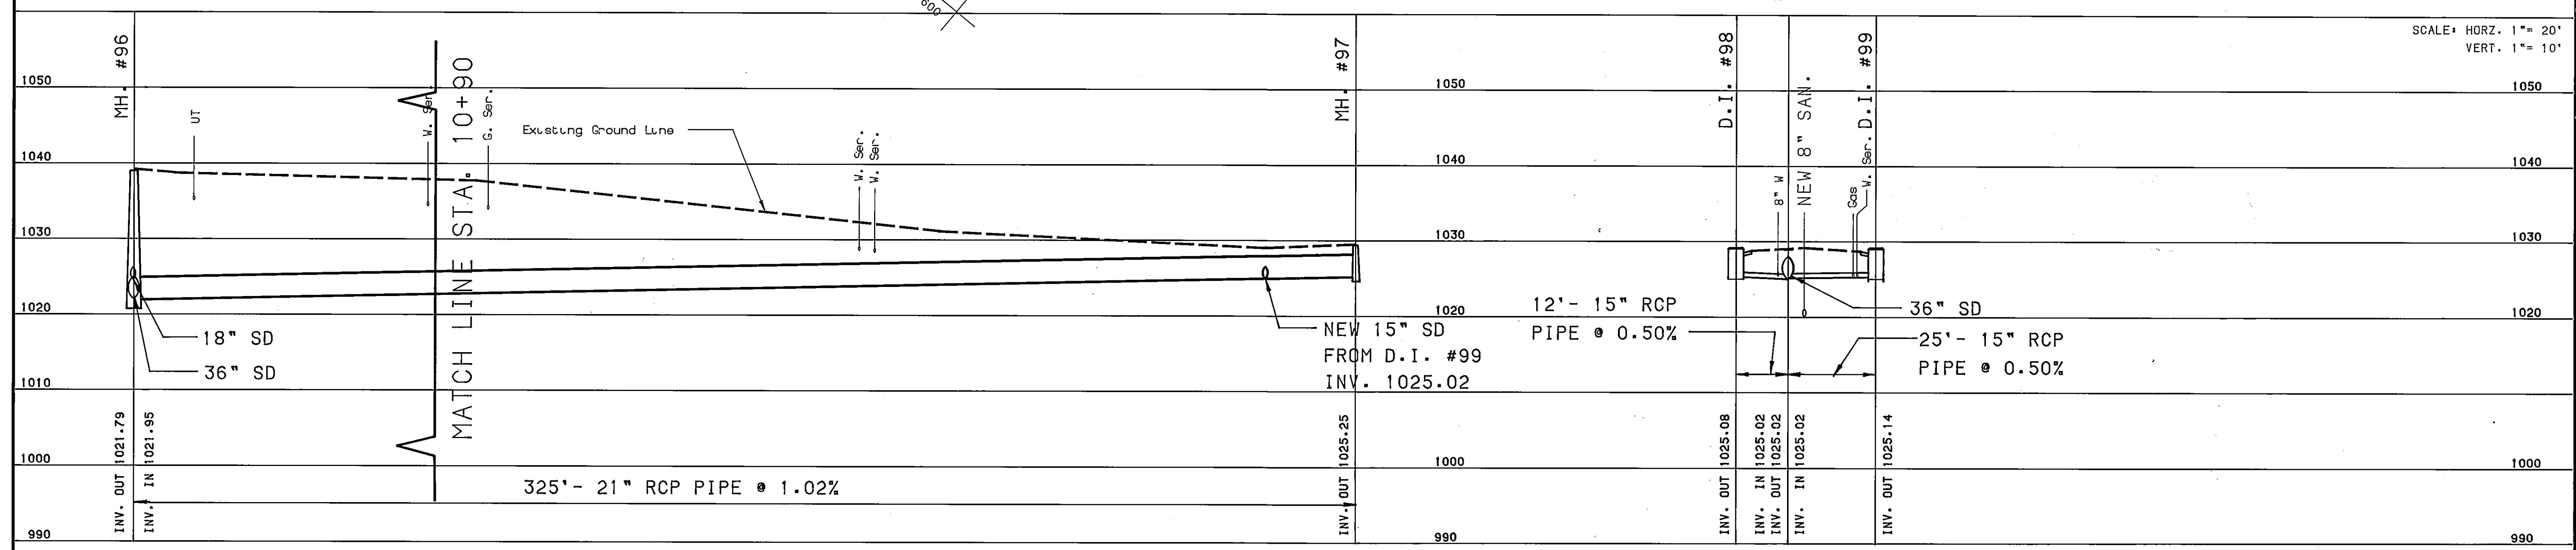

SCALE: HORZ. 1" = 20'
VERT. 1" = 10'

Mattern & Craig
CONSULTING ENGINEERS - SURVEYORS
701 FIRST STREET, ROANOKE, VIRGINIA 24016, (703) 345-0342

DESIGNED: ARB/SWH
CHECKED: GRN
APPROVED:

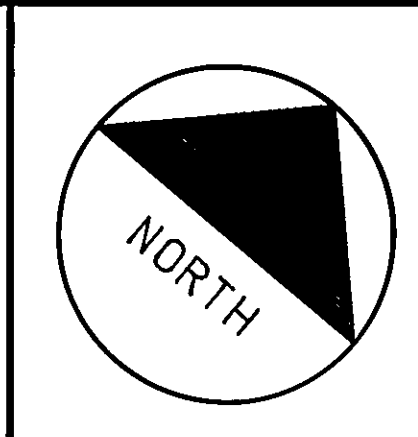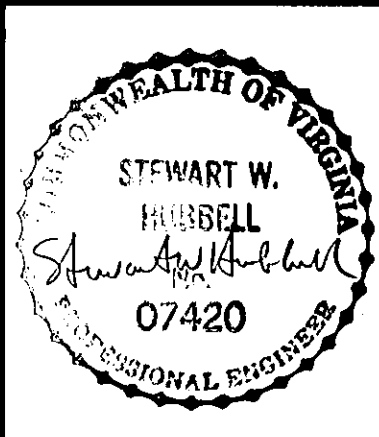

REVISION	DATE	DESCRIPTION	BY	APP.
1	DEC. 89	RECORD DRAWING	JLJ	SWH

DATE
JULY 1987
COMM.
580/581

WILLIAMSON ROAD STORM DRAIN- PHASE 2
CONTRACT II-A
ROANOKE, VIRGINIA
PLAN AND PROFILE

SHEET
47