


File: V:\PROJECTS\ANY\K4\33338\CA00\1\ACAD\DWG\C-300-33338-PLAN AND PROFILE.DWG
Saved: 11/27/2018 2:41:40 PM Plotted: 1/23/2019 10:54:20 AM Current User: Squires, Alan LastSavedBy: 5548

SEE SHEET C-301



MATCHLINE STA. 3+80

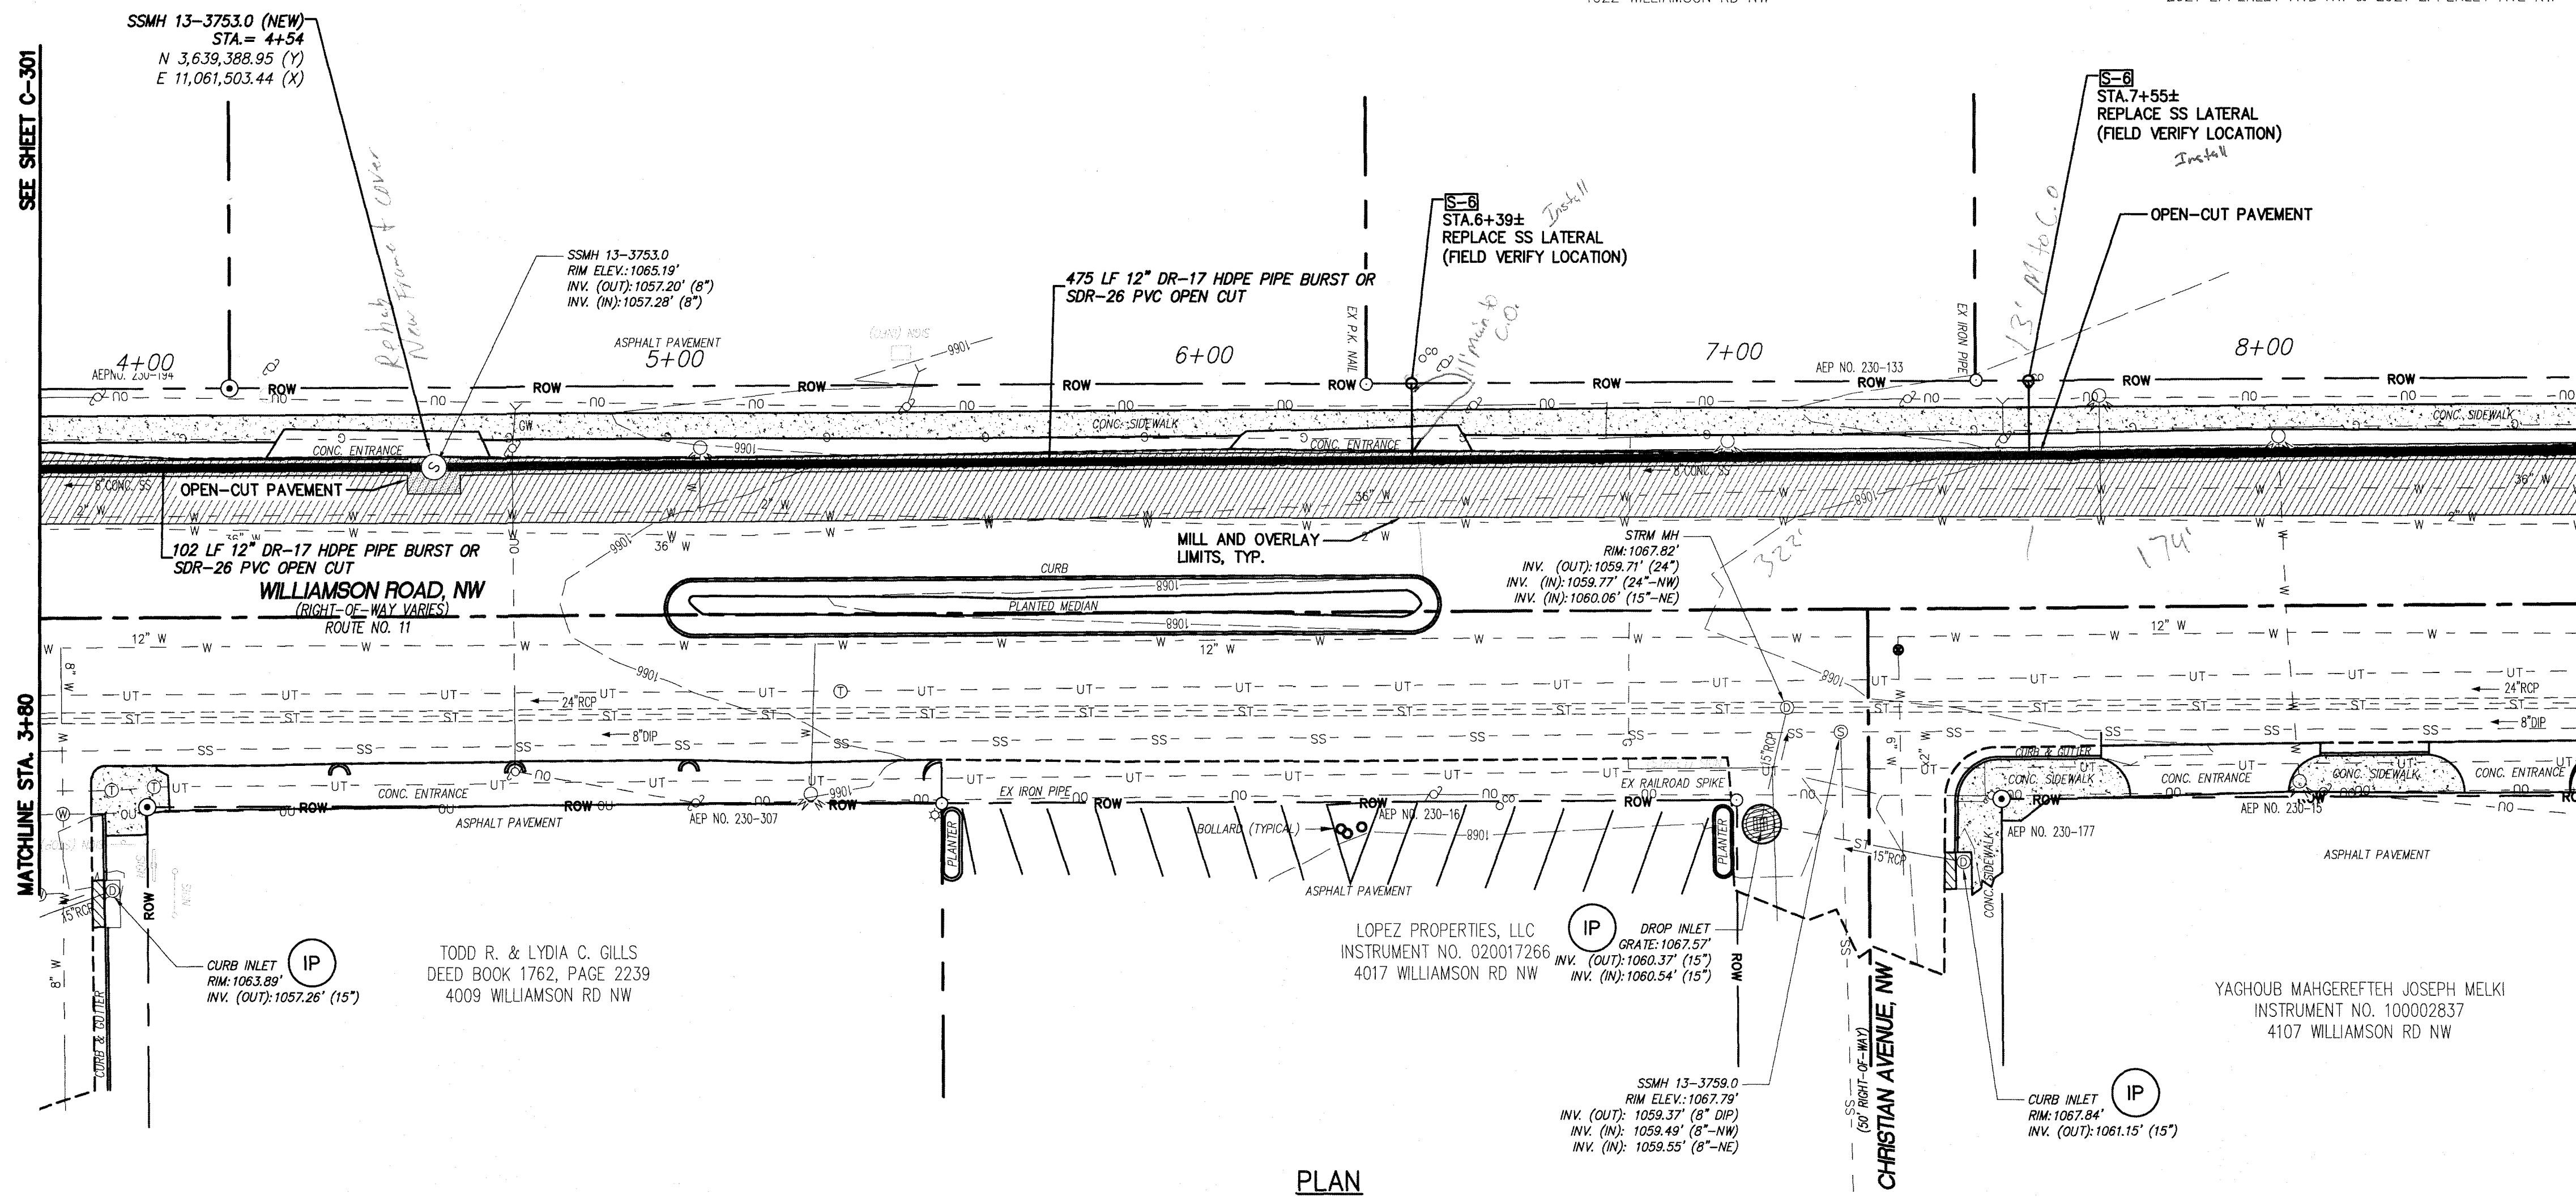


SEE SHEET C-303

MATCHLINE STA. 8+80




- GENERAL NOTES:
- REFER TO SHEETS C-600 THROUGH C-605 FOR TYPICAL ROAD/LANE CLOSURE DETAILS AND REQUIREMENTS.
 - CONTRACTOR SHALL PROVIDE BY-PASS PUMPING AS PER SPECIFICATIONS.
 - REFER TO DETAIL S-3, SHEET C-502 FOR INSIDE DROPS IN MANHOLE.

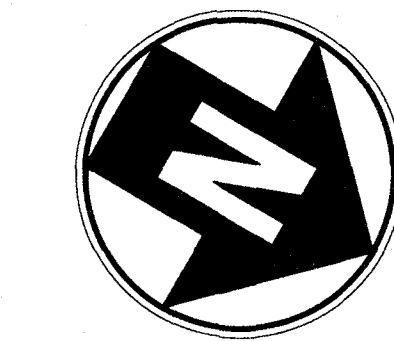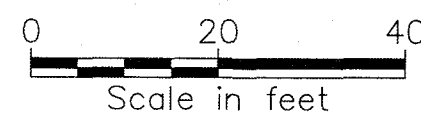

PLAN

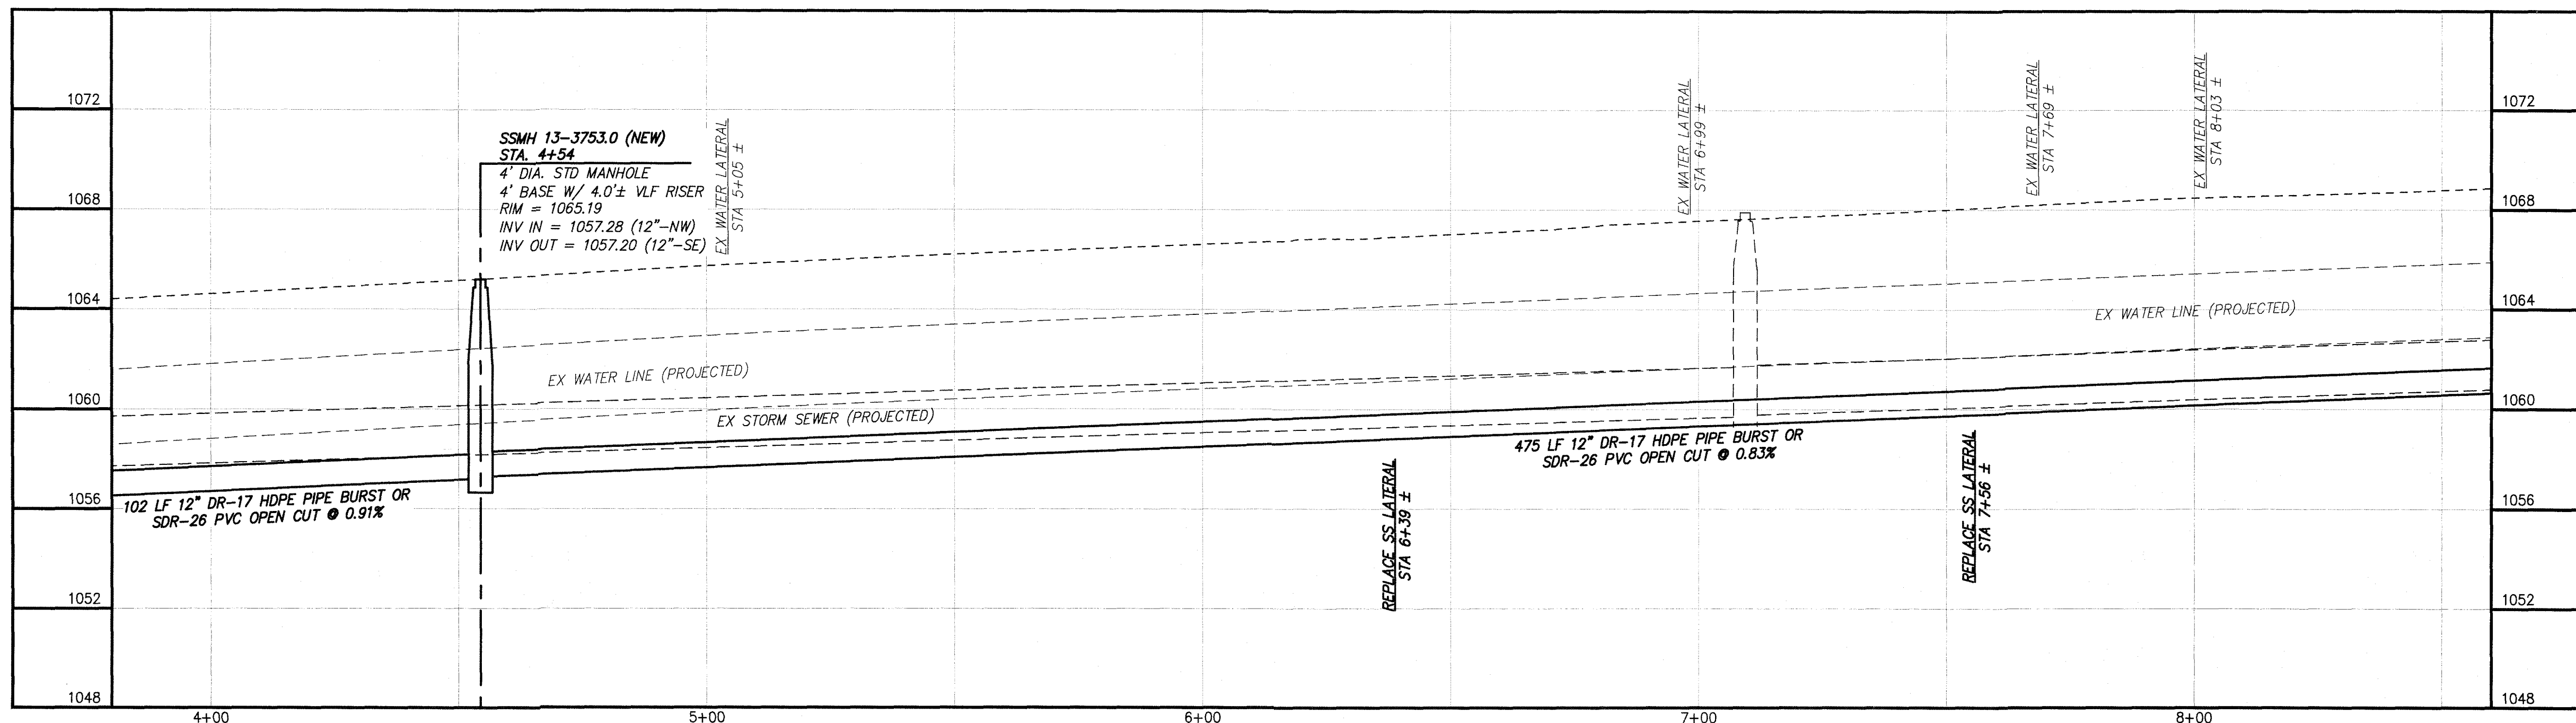

PROFILE

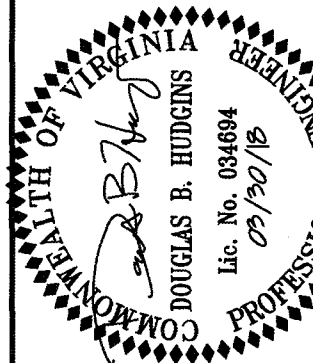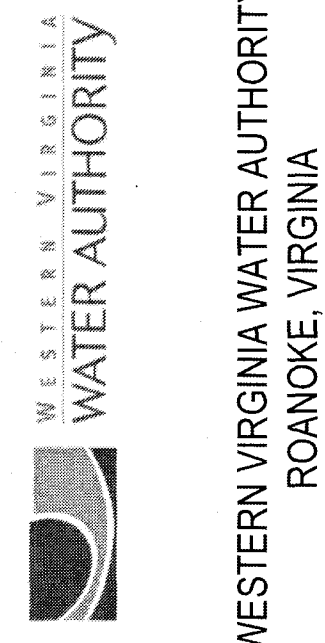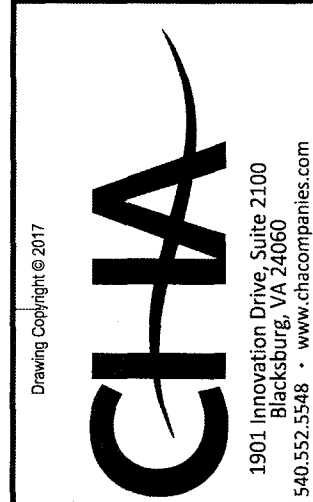

WESTERN VIRGINIA WATER AUTHORITY
WILLIAMSON ROAD SANITARY SEWER REPLACEMENT
ROANOKE, VIRGINIA

No.	Submital / Revision	App'd By	Date
1	BID ISSUE	DBH/MBH	3-30-18
2	CONSTRUCTION ISSUE	DBH/MBH	01-21-19

Designed By:	Drawn By:	Checked By:
MBH	MBH	DBH
Issue Date:	Project No:	Scale:
3-30-18	33338	AS SHOWN

Drawing No.:
C-302