

 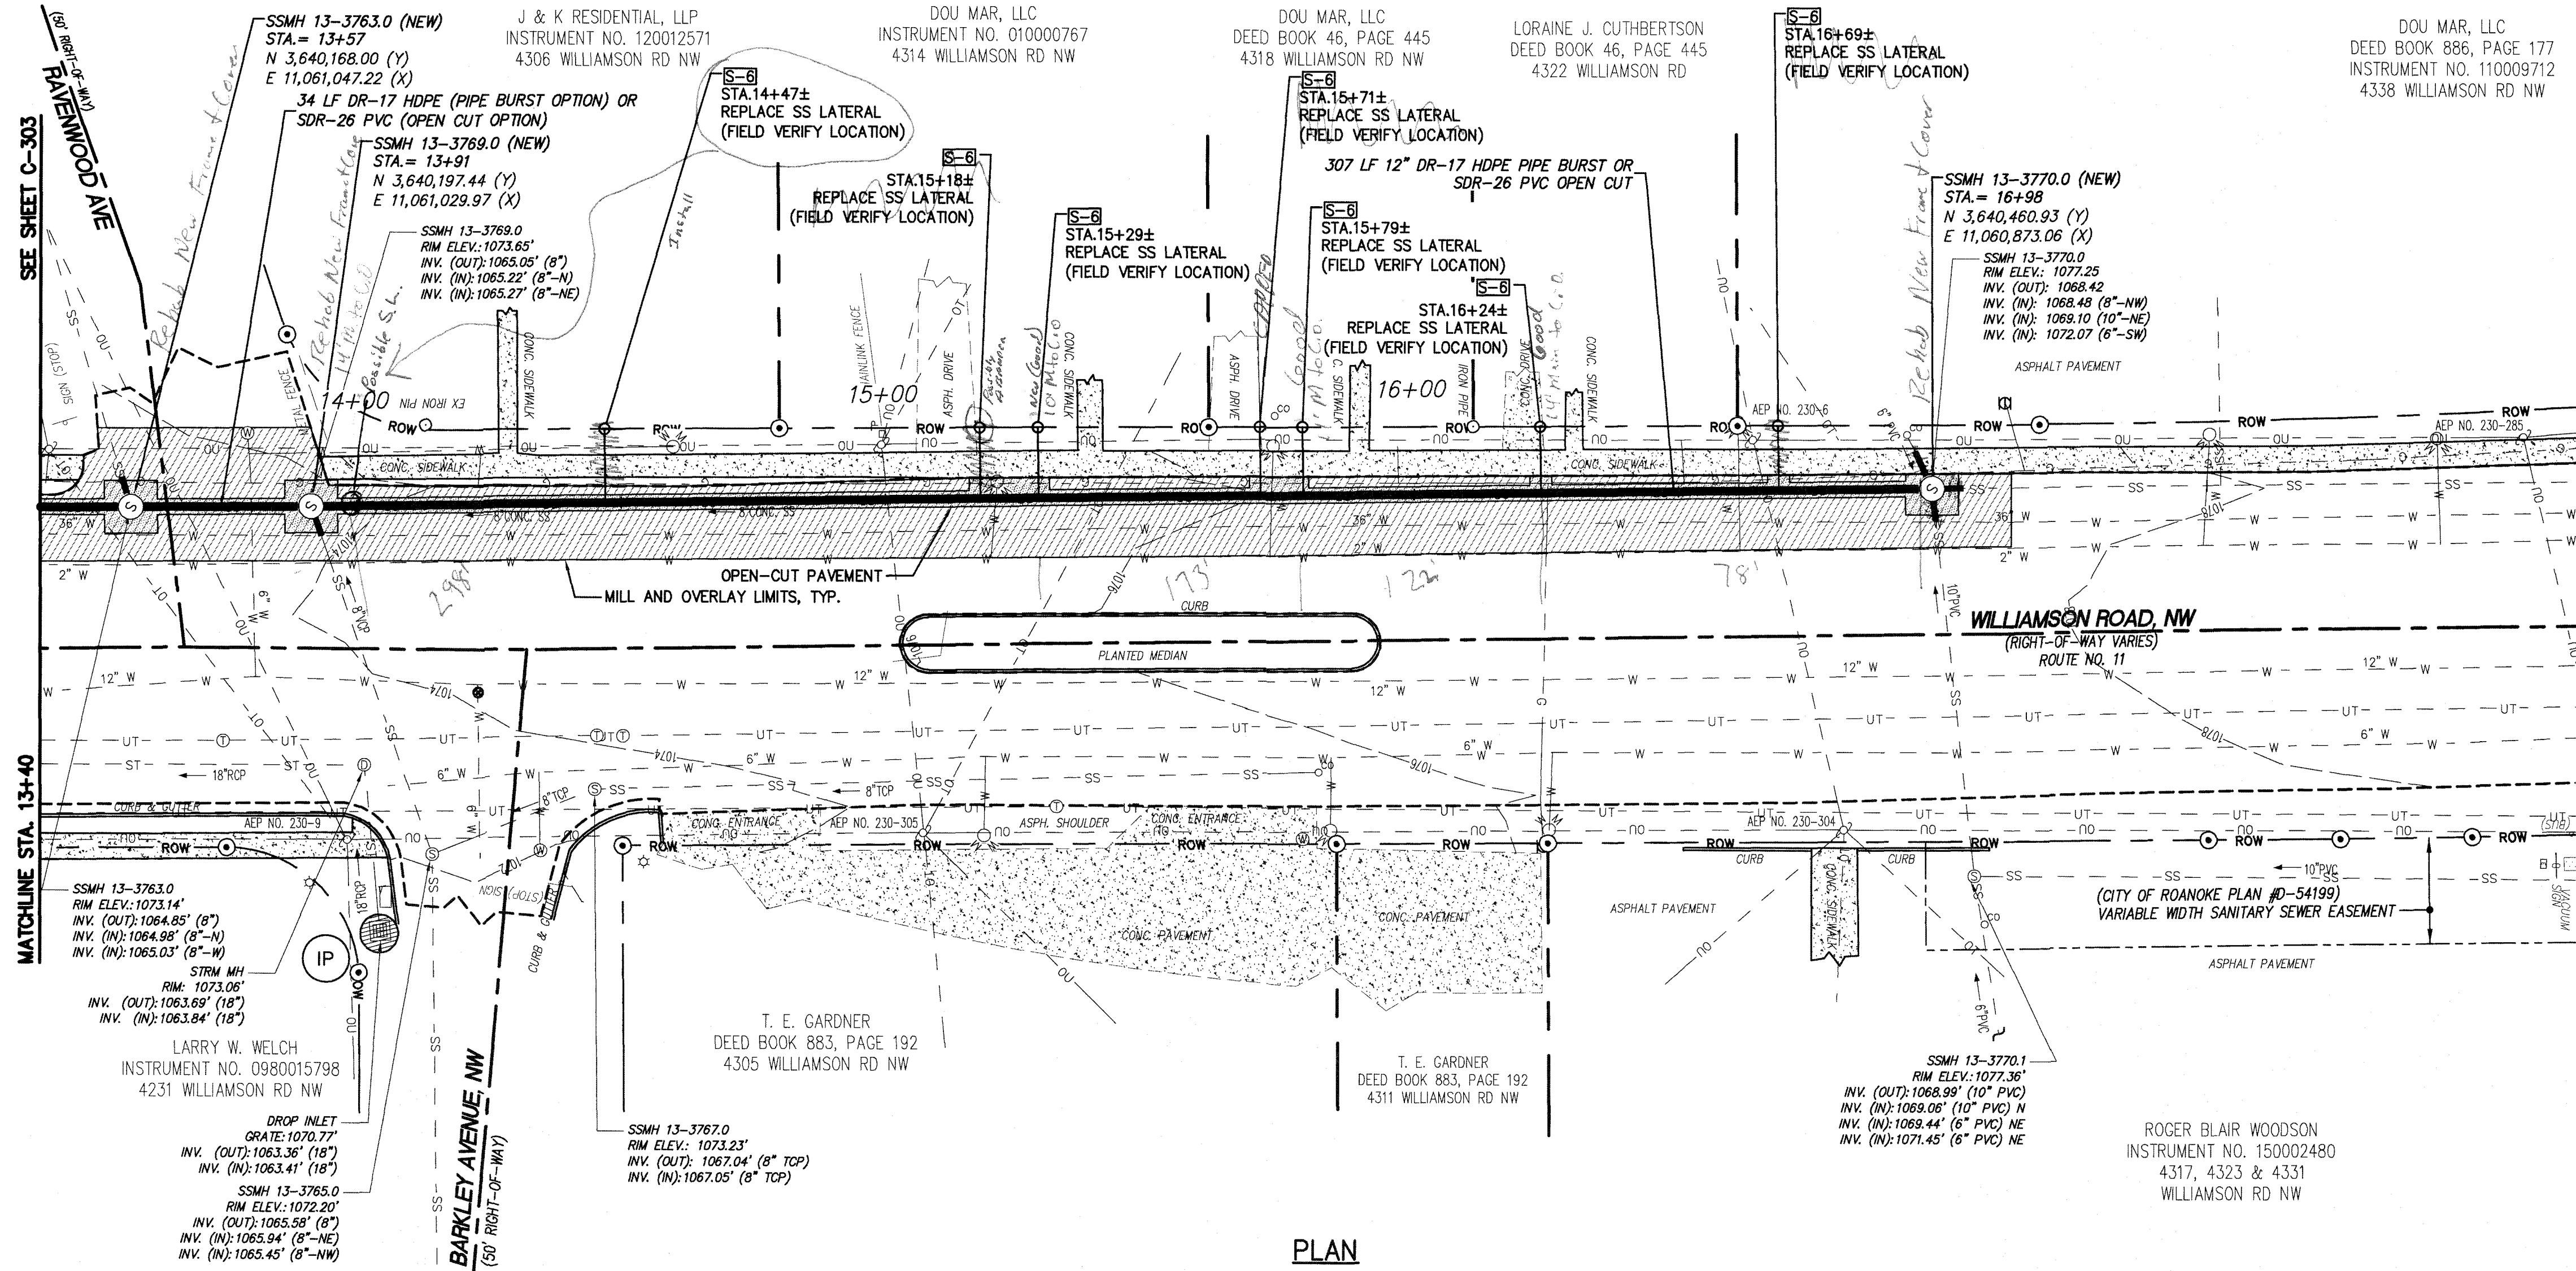


File: V:\PROJECTS\WV\33338\CAUD\ACAD\C-300-33338-PLAN AND PROFILE.dwg
Saved: 11/21/2018 2:41:40 PM Plotted: 1/23/2019 11:14:02 AM Current User: Sources, Alan, LeeSweeney, 5548

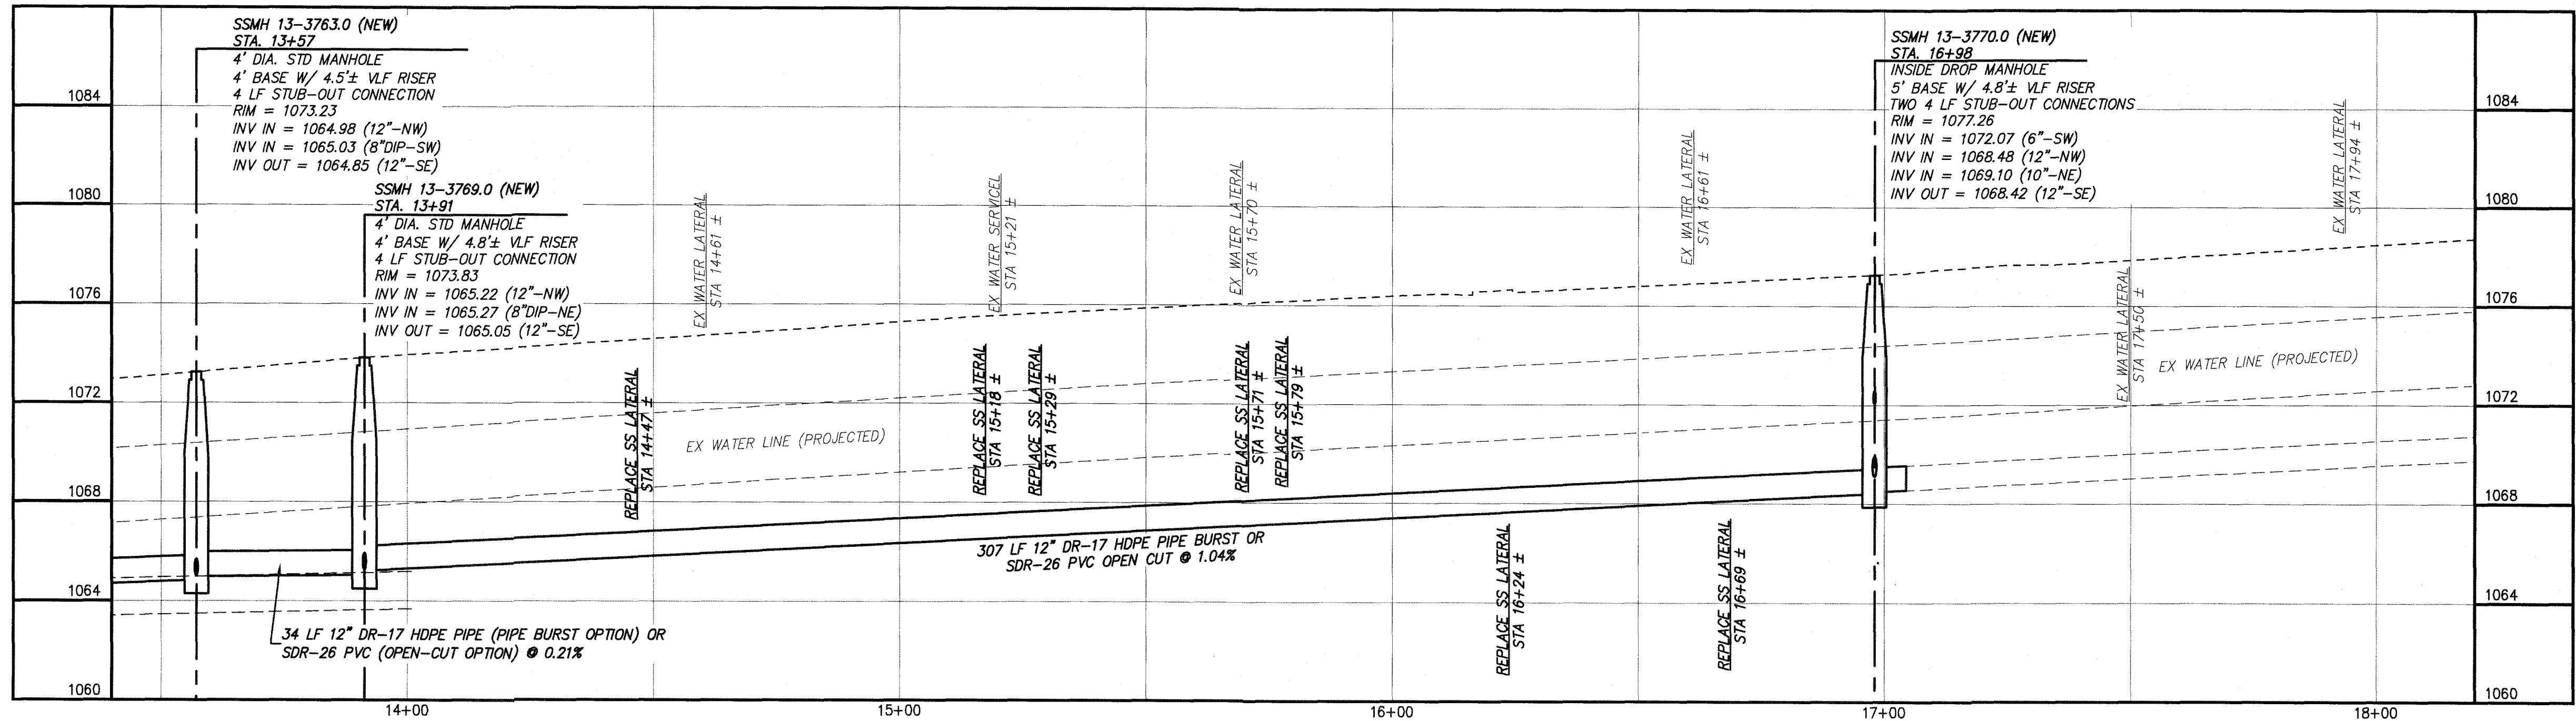

GENERAL NOTES:

- REFER TO SHEETS C-600 THROUGH C-605 FOR TYPICAL ROAD/LANE CLOSURE DETAILS AND REQUIREMENTS.
- CONTRACTOR SHALL PROVIDE BY-PASS PUMPING AS PER SPECIFICATIONS.
- REFER TO DETAIL S-3, SHEET C-502 FOR INSIDE DROPS IN MANHOLE.



PROFILE

WESTERN VIRGINIA WATER AUTHORITY
ROANOKE, VIRGINIA

WESTERN VIRGINIA WATER AUTHORITY
WILLIAMSON ROAD SANITARY SEWER REPLACEMENT
ROANOKE, VIRGINIA

No.	Submital / Revision	App'd. By	Date
1	BID ISSUE	DBH/MBH	3-30-18
2	CONSTRUCTION	DBH/MBH	01-21-19

WILLIAMSON ROAD
SANITARY SEWER

PLAN AND PROFILE
STA 13+40 - E.O.L.

Designed By	Drawn By	Checked By
MBH	MBH	DBH

Issue Date	Project No.	Scale
3-30-18	33338	AS SHOWN

Drawing No.:
C-304