
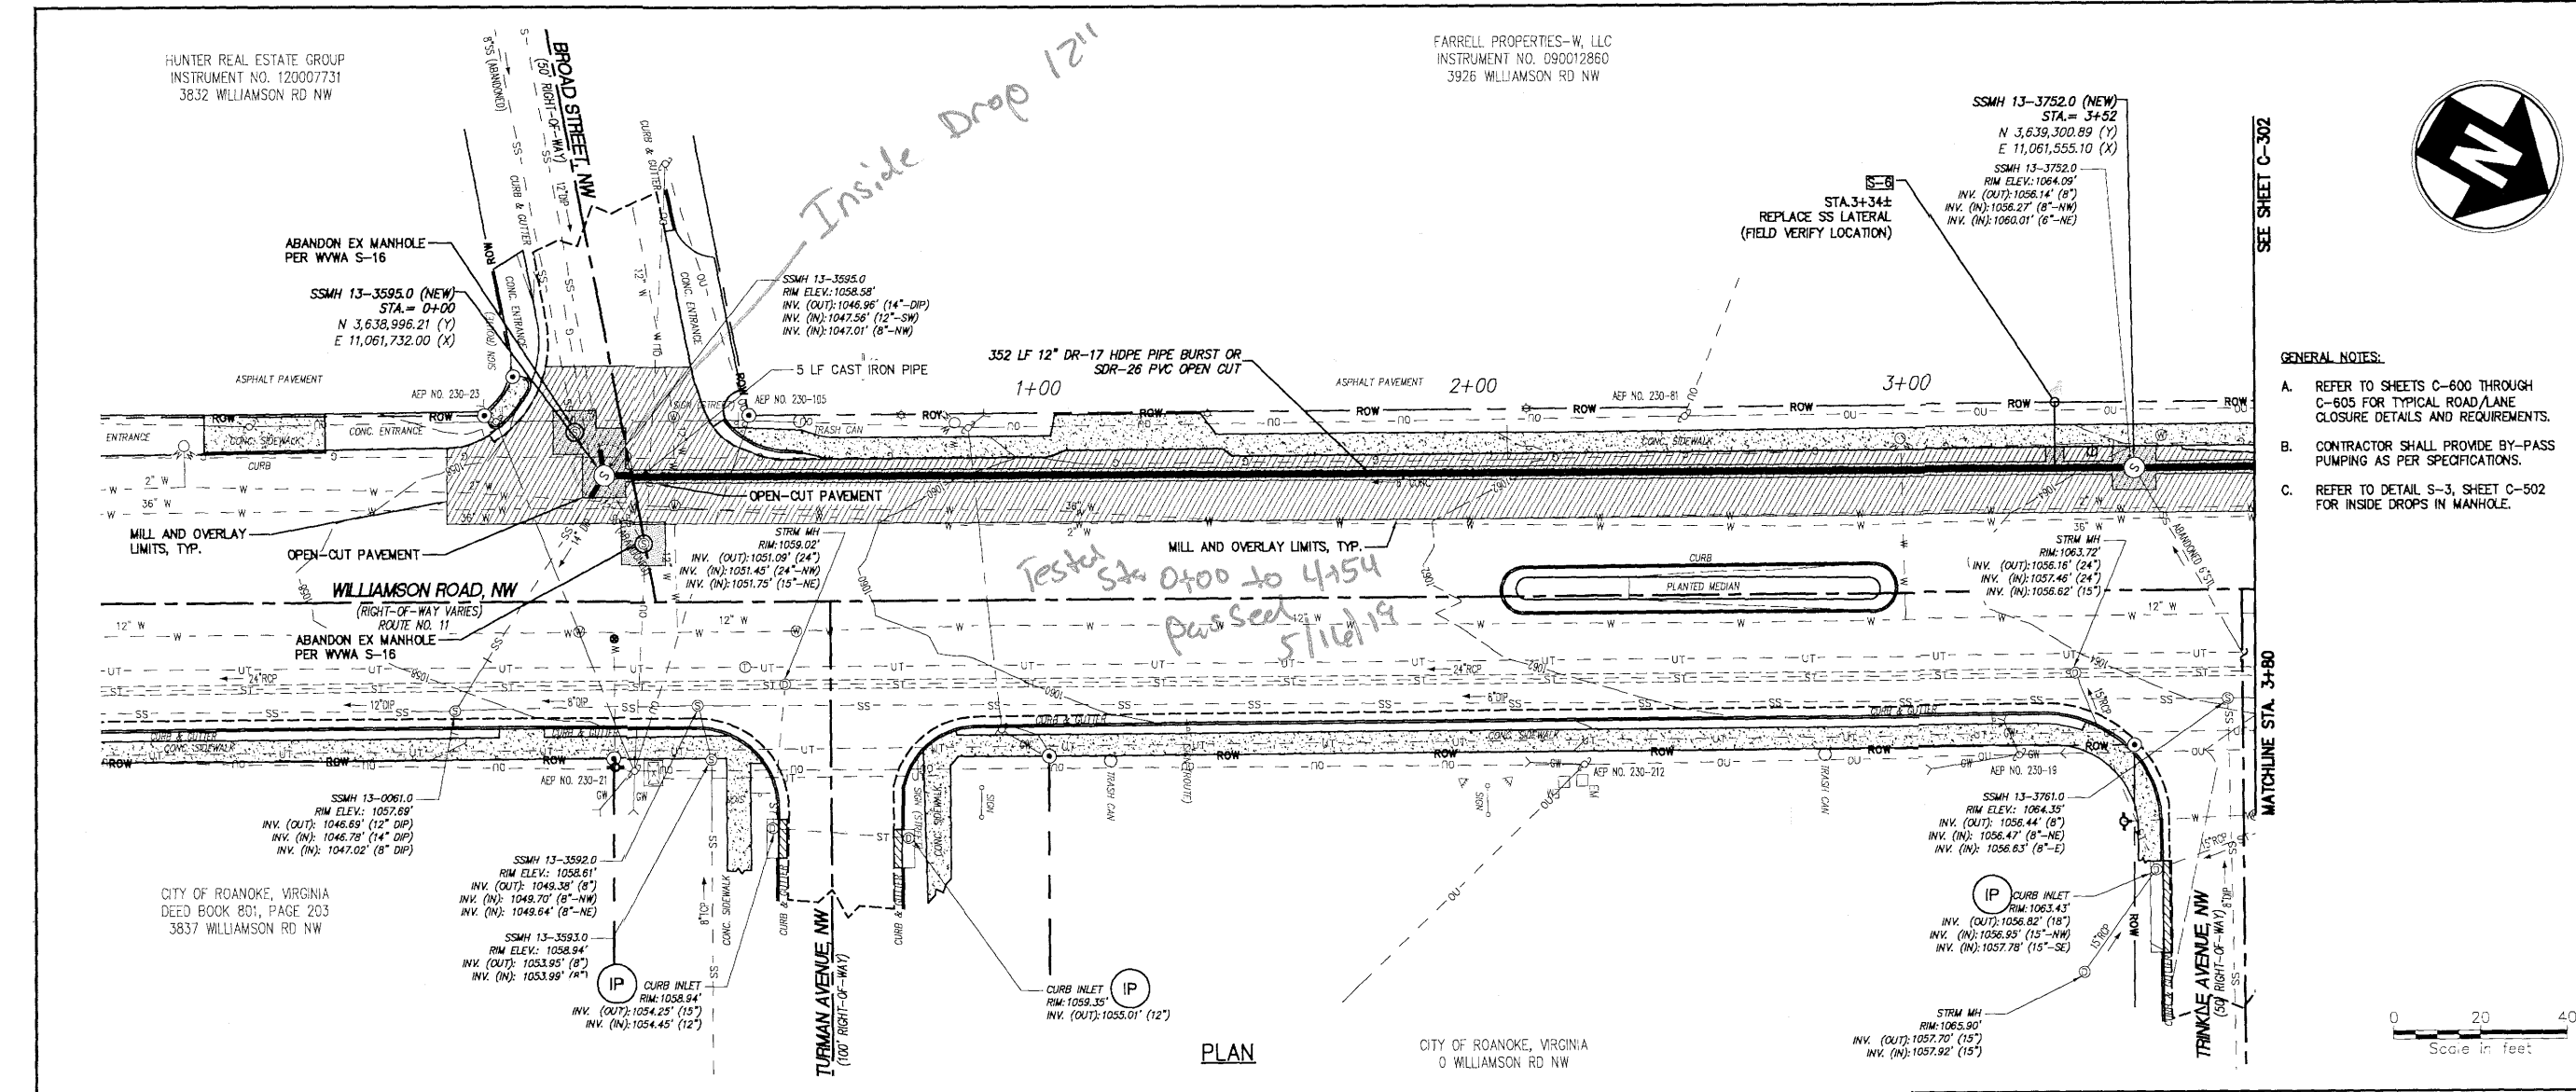


File: V:\PROJECTS\ANYK4\33338\CA00\C-300-33338-PLAN AND PROFILE.DWG
Saved: 11/21/2018 2:41:40 PM Plotted: 1/23/2019 10:54:13 AM Current User: Squire, Alan Last Saved By: 5548

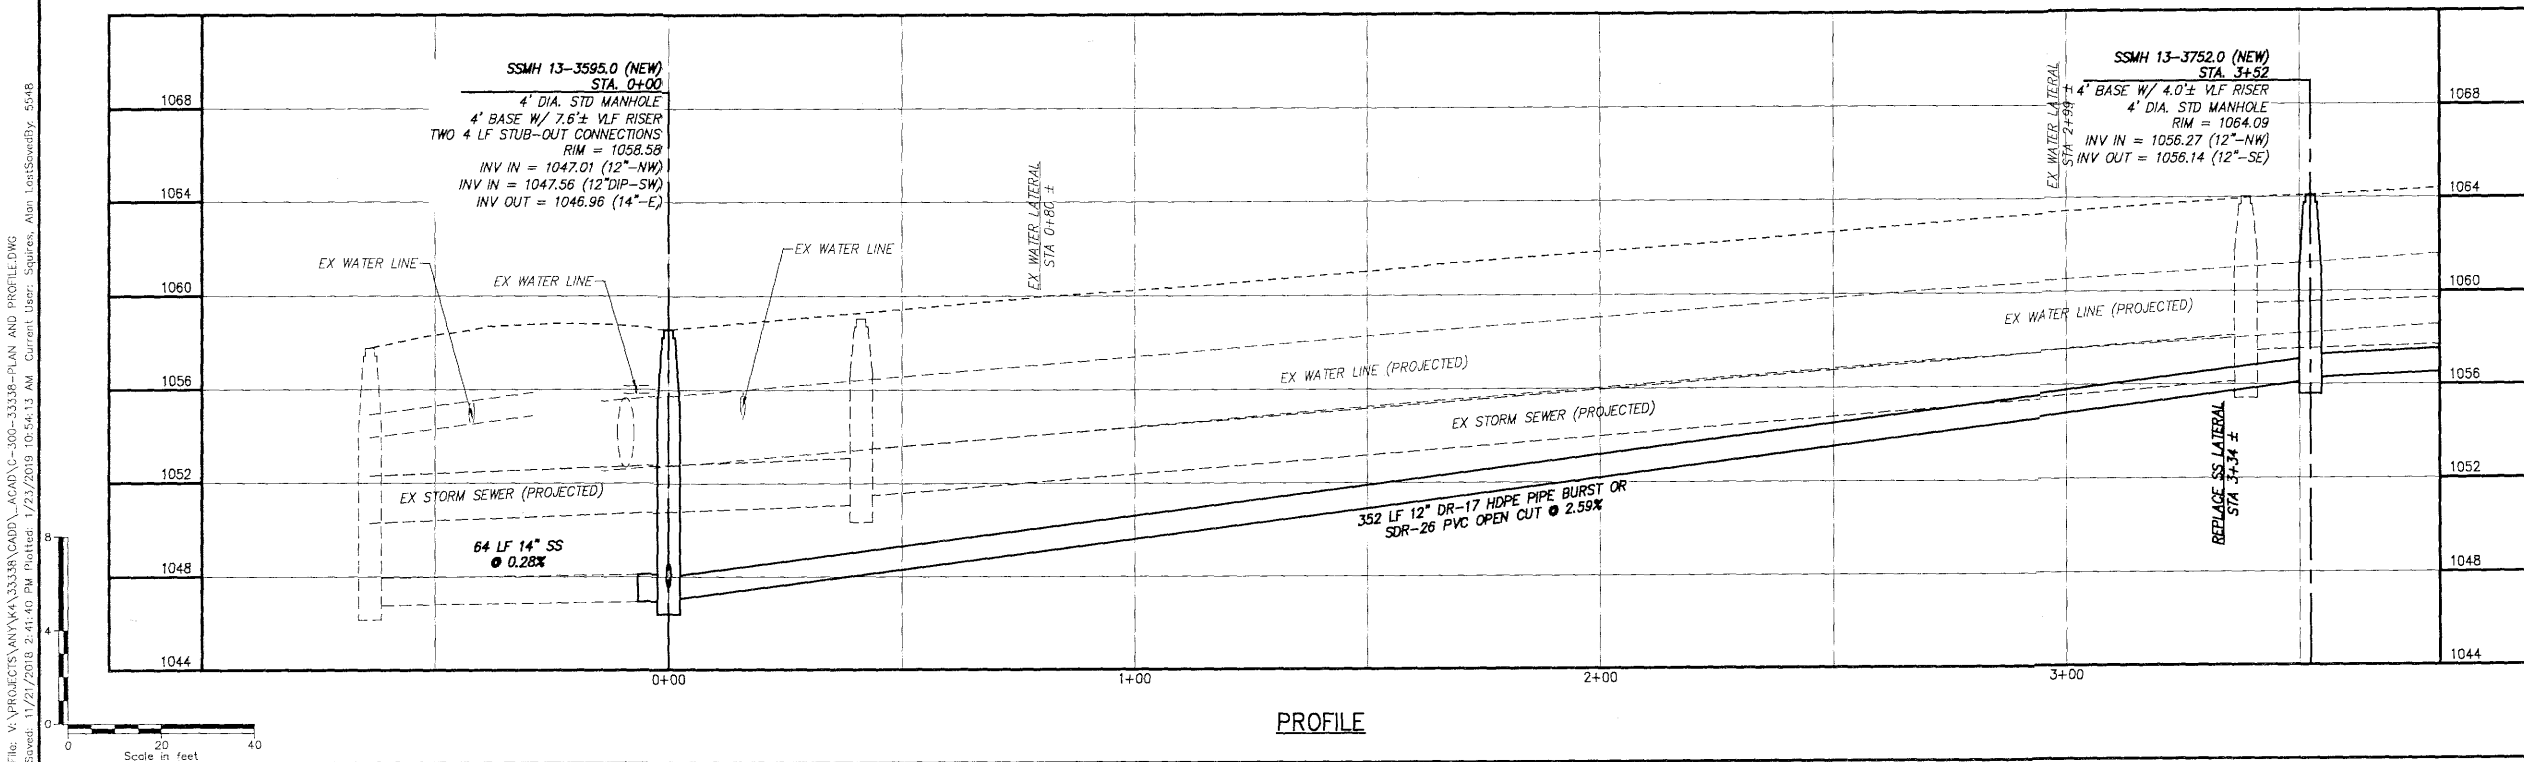

CH2M HILL

1901 Williamsburg Road, Suite 2100
Blacksburg, VA 24060
540.537.5548 • www.ch2m.com

WESTERN VIRGINIA WATER AUTHORITY
ROANOKE, VIRGINIA

WESTERN VIRGINIA WATER AUTHORITY
ROANOKE, VIRGINIA

WESTERN VIRGINIA WATER AUTHORITY
WILLIAMSON ROAD SANITARY SEWER REPLACEMENT
ROANOKE, VIRGINIA

WESTERN VIRGINIA WATER AUTHORITY
WILLIAMSON ROAD SANITARY SEWER REPLACEMENT
STA 0+00 - STA 3+80

PLAN AND PROFILE
STA 0+00 - STA 3+80

Designed By: MBH
Issue Date: 3-30-18

Drawn By: MSH
Project No: 33338

Checked By: DBH
Scale: AS SHOWN

Drawing No.: C-301