


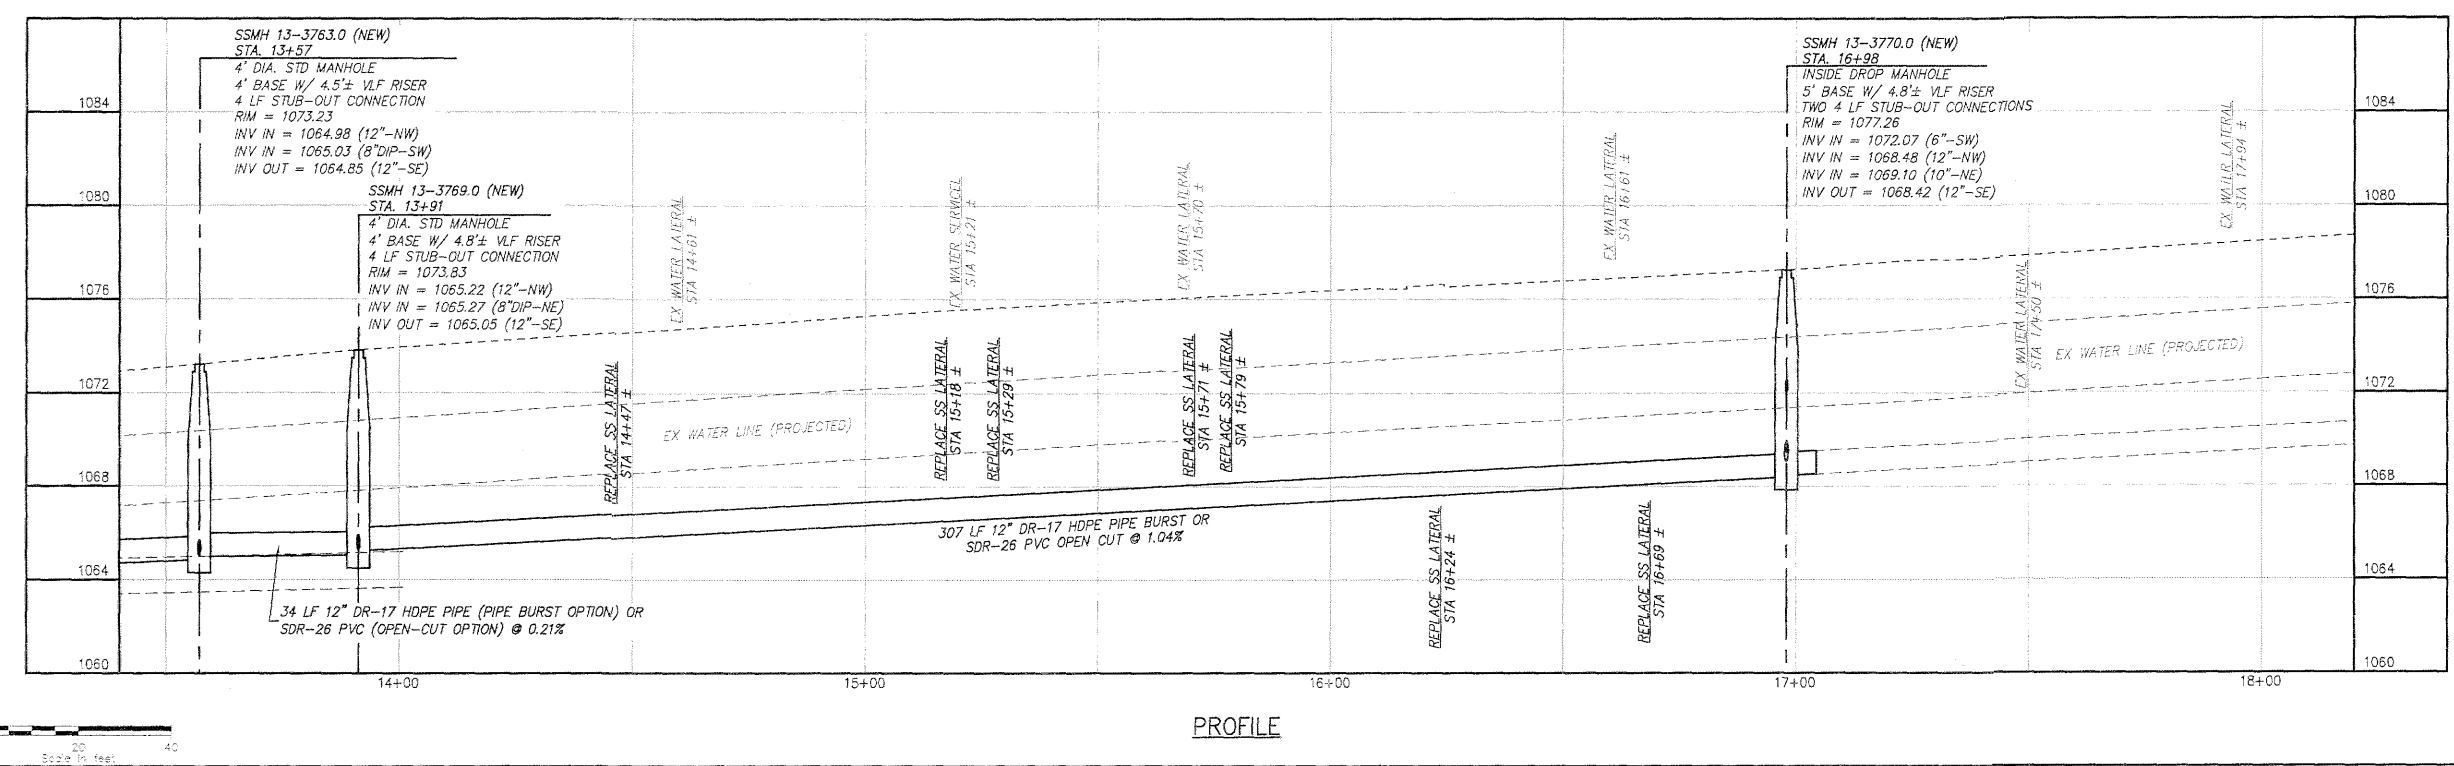


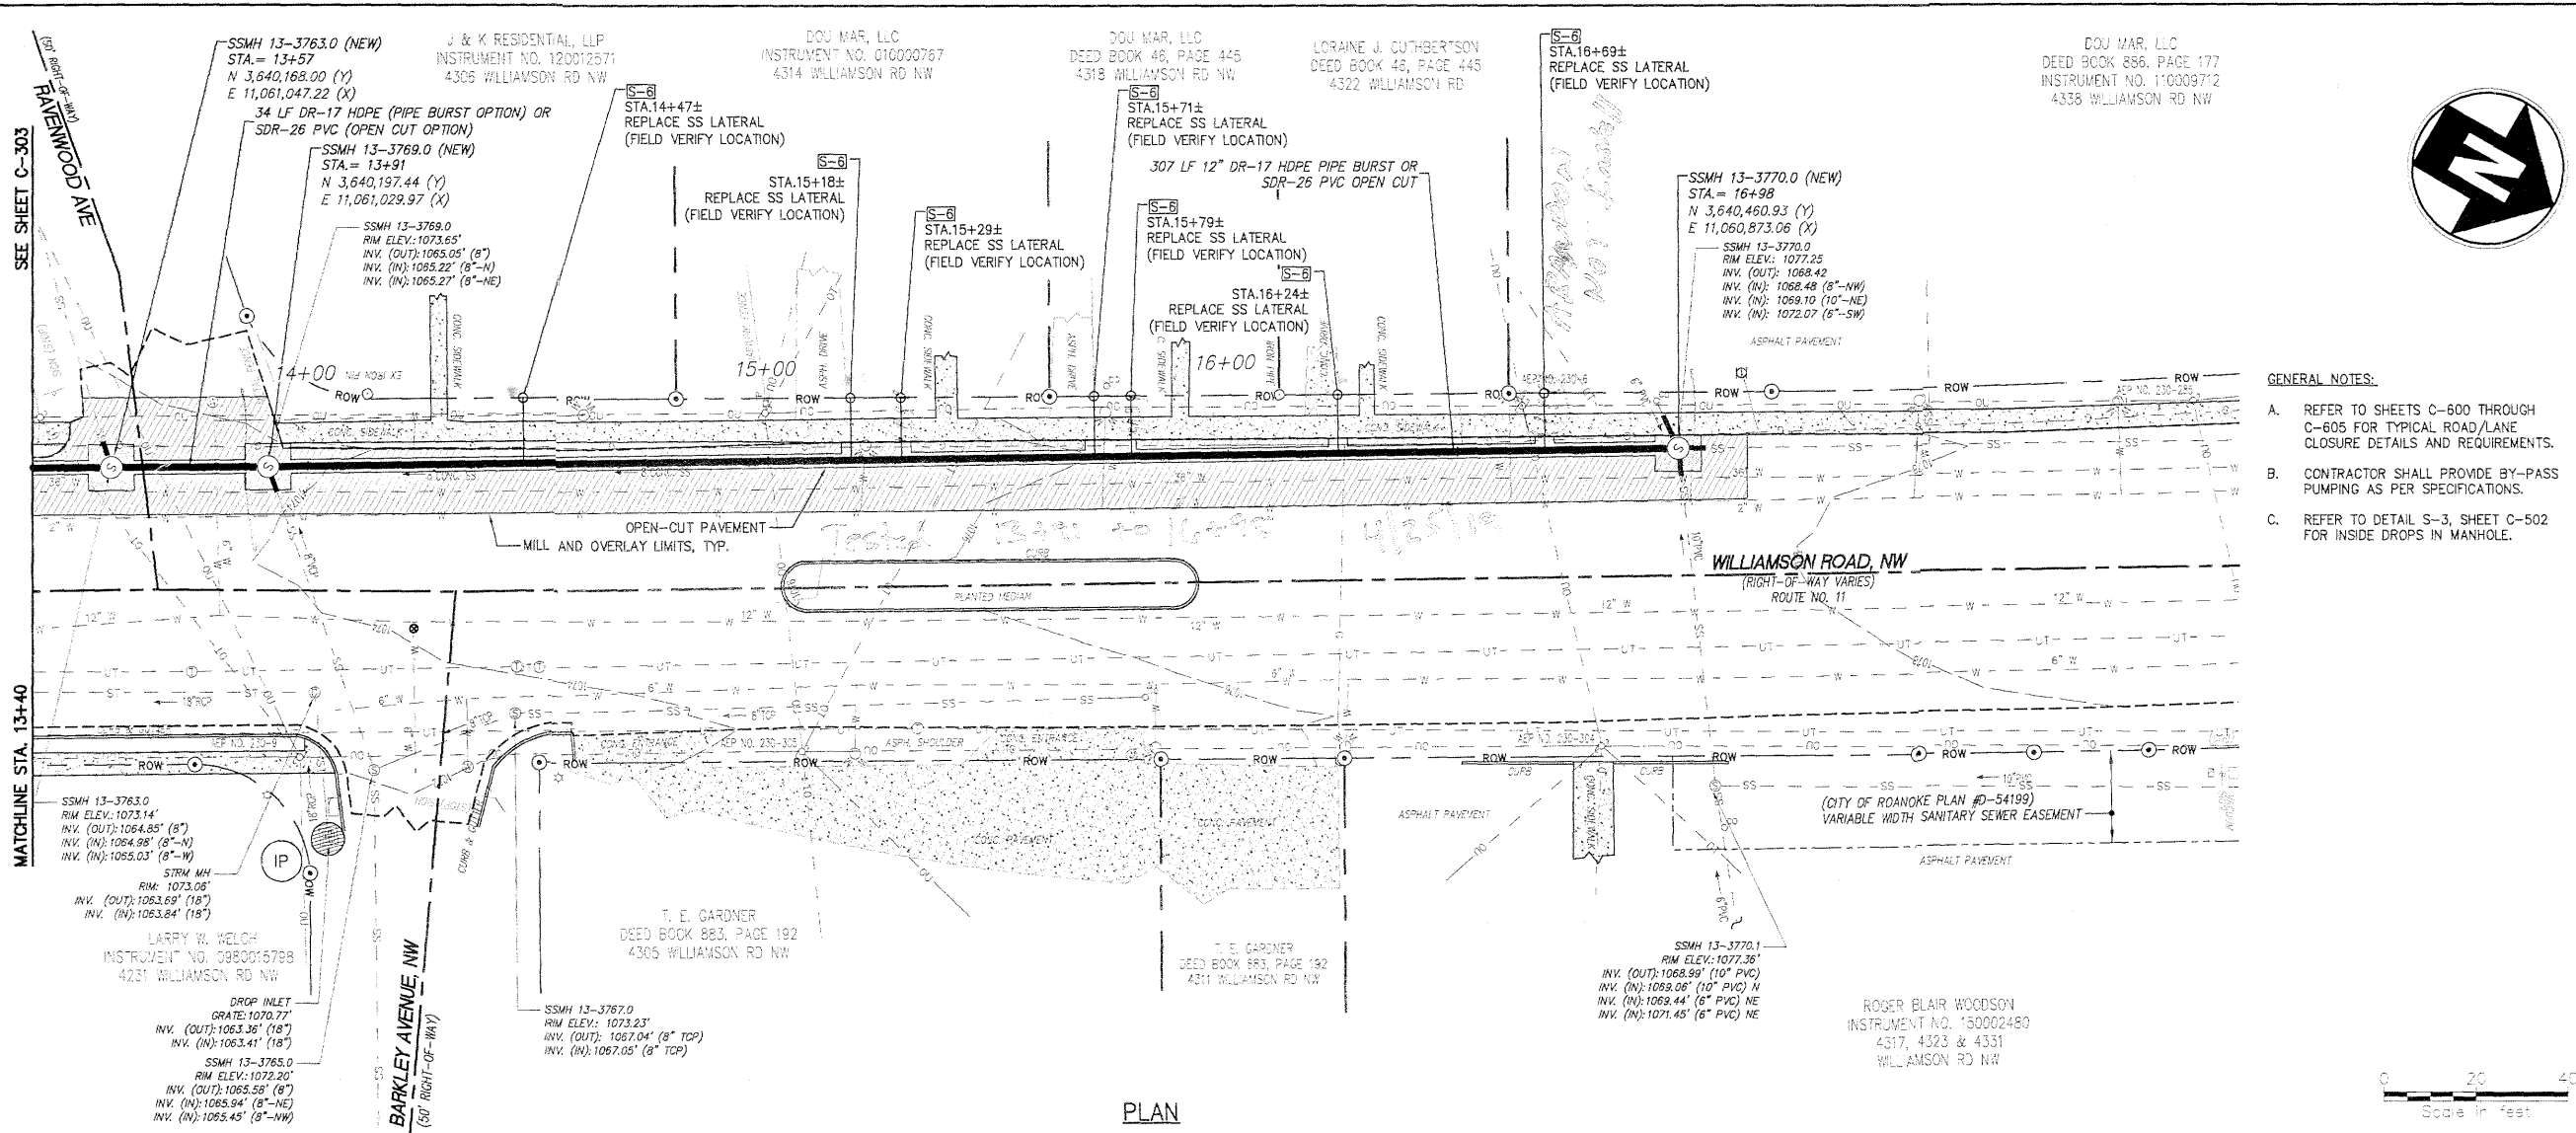

- GENERAL NOTES:
- A. REFER TO SHEETS C-600 THROUGH C-605 FOR TYPICAL ROAD/LANE CLOSURE DETAILS AND REQUIREMENTS.
 - B. CONTRACTOR SHALL PROVIDE BY-PASS PUMPING AS PER SPECIFICATIONS.
 - C. REFER TO DETAIL S-3, SHEET C-502 FOR INSIDE DROPS IN MANHOLE.

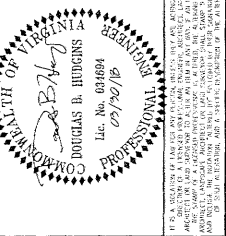

Scale in feet

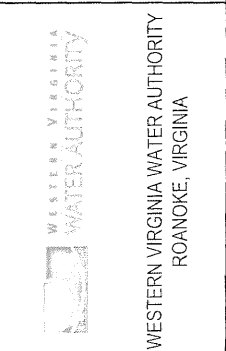

WESTERN VIRGINIA WATER AUTHORITY
WILLIAMSON ROAD SANITARY SEWER REPLACEMENT
ROANOKE, VIRGINIA

No.	Submitted / Revision	App'd By	Date
1	ISSUED FOR CONSTRUCTION	MBH	3-30-18
2	CONSTRUCTION	DBH	01-21-19

WILLIAMSON ROAD
SANITARY SEWER
PLAN AND PROFILE
STA 13+40 - E.O.L.

Designed By:	Drawn By:	Checked By:
MBH	MBH	DBH
Issue Date:	Project No:	Scale:
3-30-18	33338	AS SHOWN

Drawing No.:
C-304