

WILLOW ROAD/LINWOOD ROAD WATERLINE REPLACEMENT

WESTERN VIRGINIA WATER AUTHORITY

CITY OF ROANOKE, VIRGINIA

MAY 3, 2018

COMM. NO. 3812

SHEET LIST

- 1 TITLE SHEET
- 2 ABBREVIATIONS AND LEGEND
- 3 SHEET INDEX AND GENERAL NOTES
- 4 PLAN AND PROFILE - 8" WATERLINE
- 5 PLAN AND PROFILE - 8" WATERLINE
- 6 PLAN AND PROFILE - 8" WATERLINE
- 7 PLAN AND PROFILE - 8" WATERLINE
- 8 PLAN AND PROFILE - 8" WATERLINE
- 9 PLAN AND PROFILE - 8" WATERLINE
- 10 DETAILS
- 11 DETAILS
- 12 FIRE HYDRANT EXHIBIT
- 13 MAINTENANCE OF TRAFFIC PLAN - PROJECT LIMITS SIGNING
- 14 MAINTENANCE OF TRAFFIC PLAN - PHASE A
- 15 MAINTENANCE OF TRAFFIC PLAN - PHASE B



PREPARED FOR:



APPROVED FOR CONSTRUCTION



LOCATION MAP
NOT TO SCALE

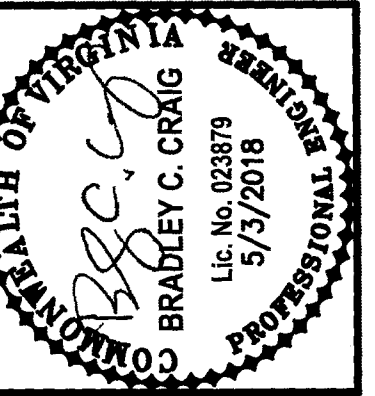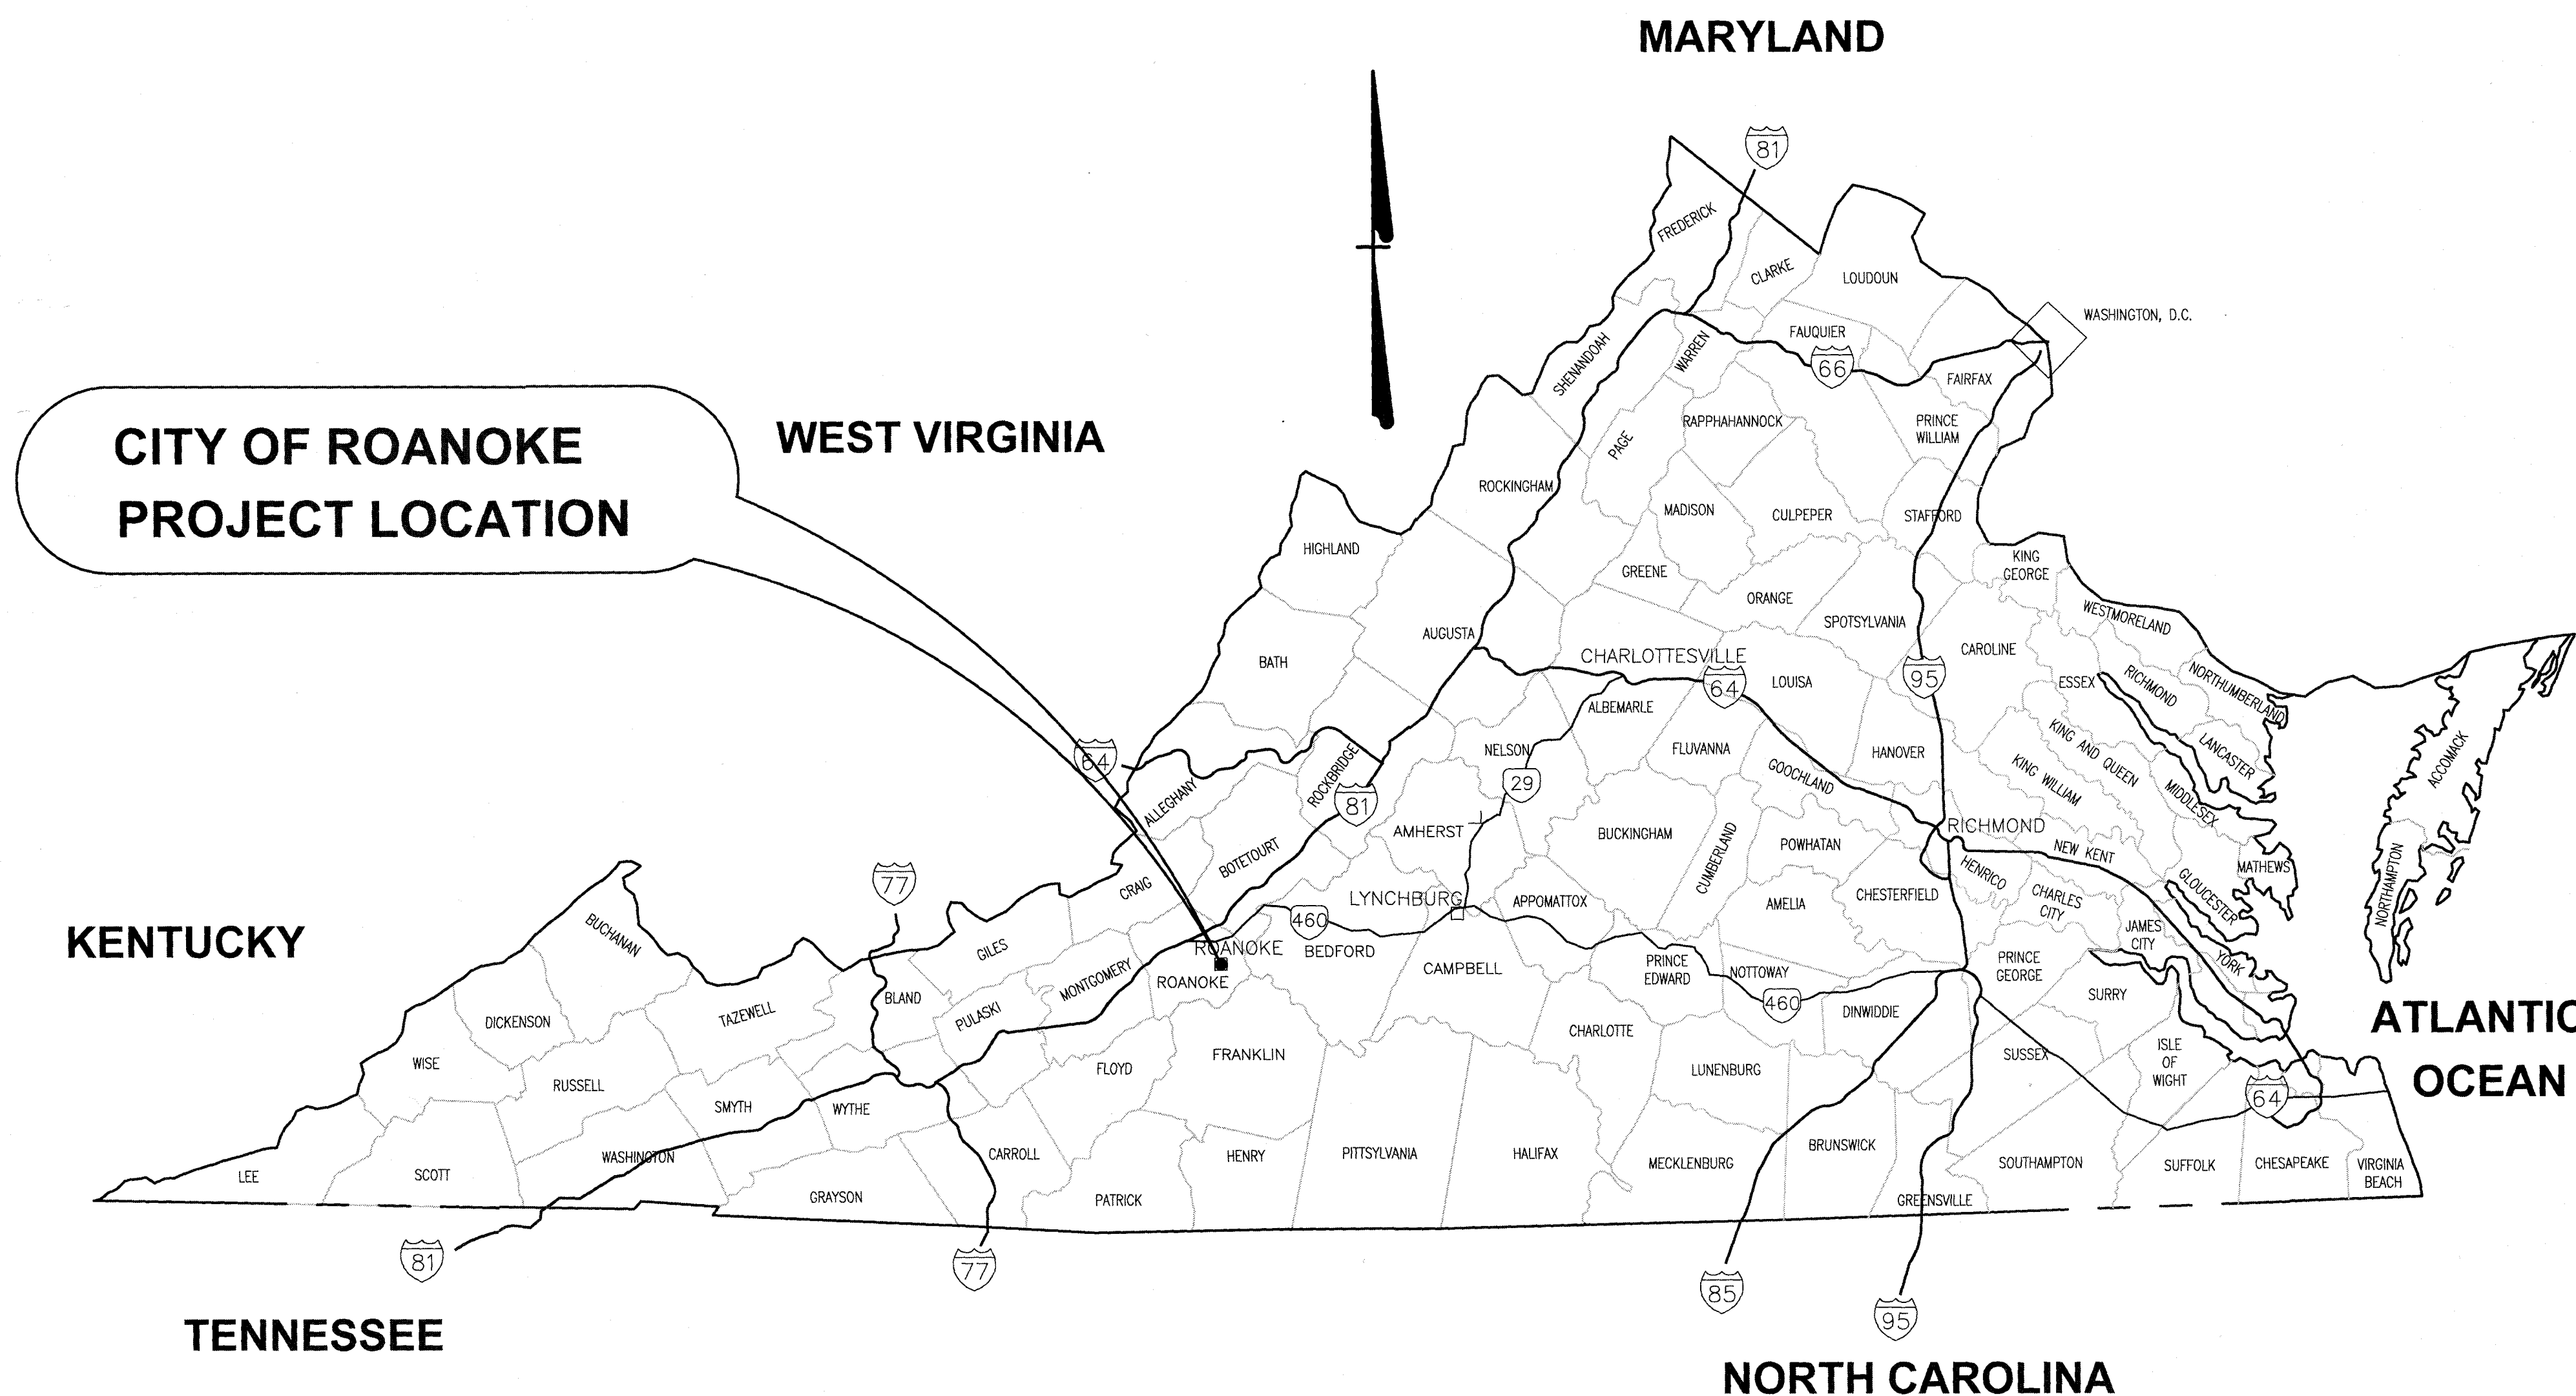

Revisions	Date
REVISED PER ADDENDUM # 2	5/3/18

Issue Date:	MAY 3, 2018
Drawn By:	DBL/ARE
Designed By:	DBL
Checked By:	BCC
Date:	5/3/2018

Mattern & Craig
ENGINEERS/SURVEYORS
701 FIRST STREET, S.W.
ROANOKE, VIRGINIA 24016
(540) 345-9342
FAX (540) 345-7891

WILLOW ROAD/LINWOOD ROAD WATERLINE REPLACEMENT

TITLE SHEET

WESTERN VIRGINIA WATER AUTHORITY

Vertical Scale:	N/A
Horizontal Scale:	N/A
Commission Number:	3812
Sheet No.:	1