
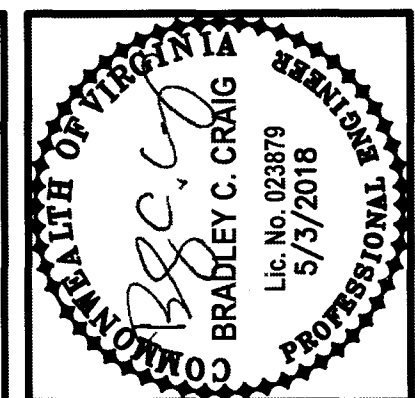
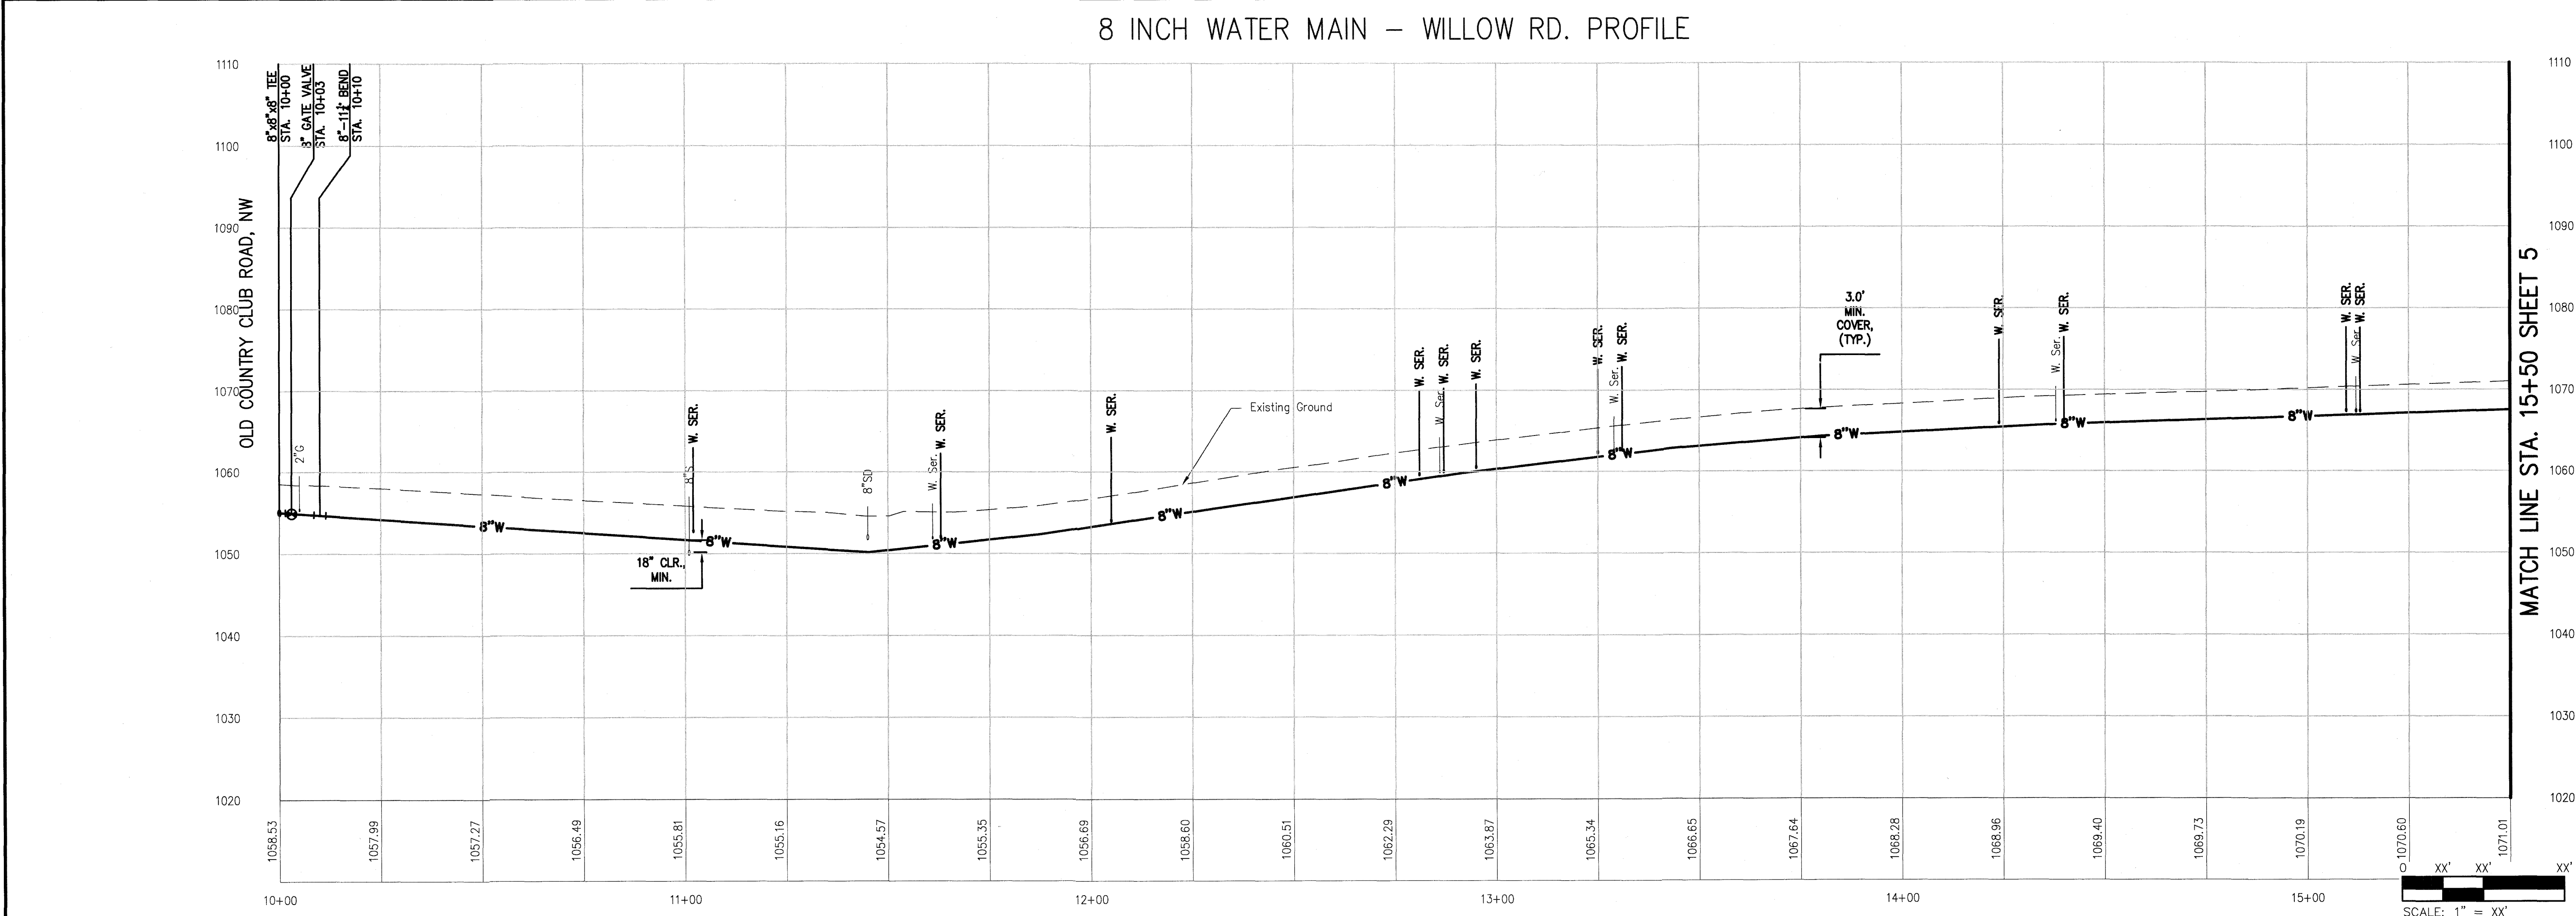


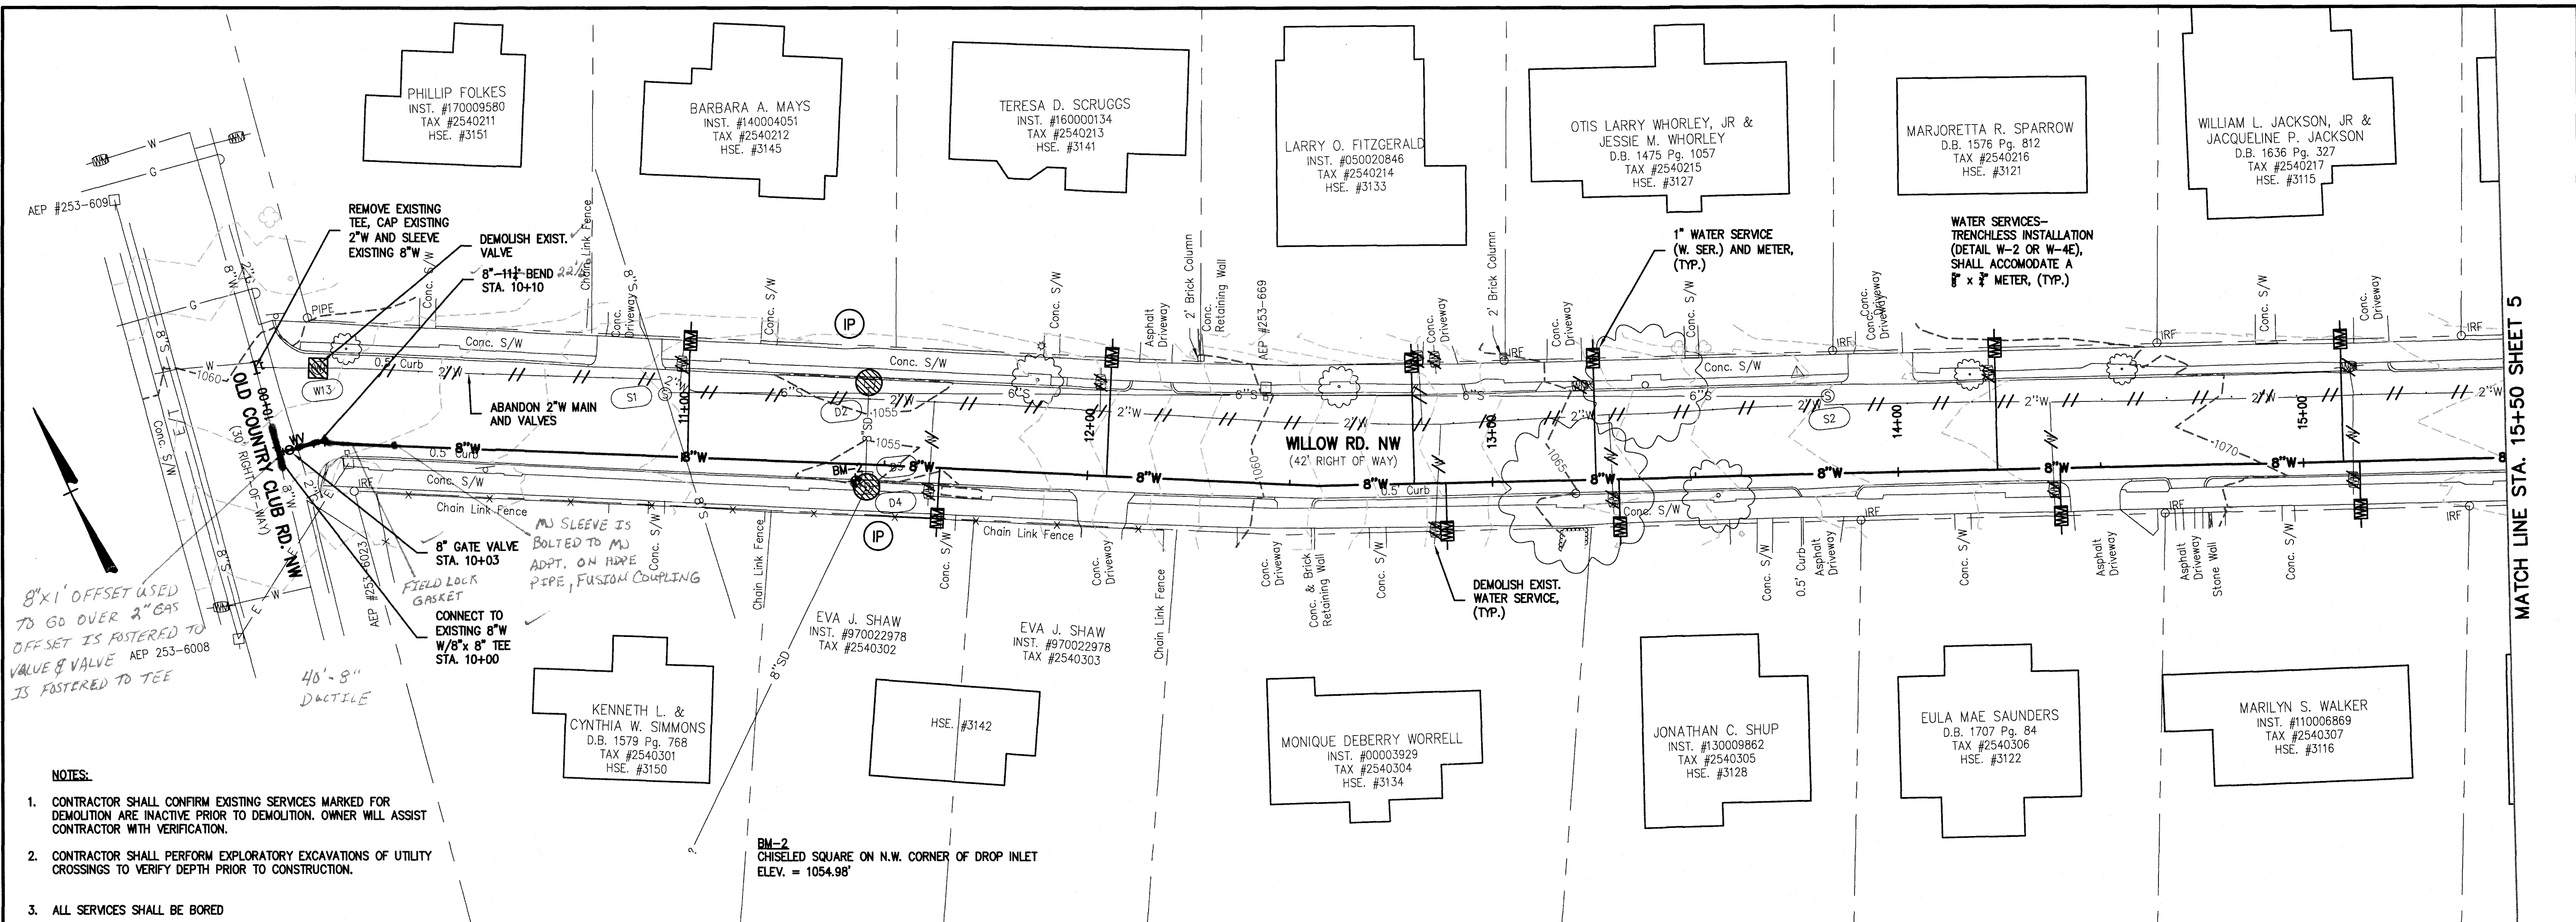

Revisions	Date
REVISED PER ADDENDUM #2	5/3/18

Issue Date:	MAY 3, 2018
Drawn By:	BCC
Designed By:	DBL
Checked By:	BCC
Date:	5/3/2018

Mattern & Craig
ENGINEERS/SURVEYORS
701 FIRST STREET, S.W.
ROANOKE, VIRGINIA 24016
(540) 345-9342
FAX (540) 345-7891

PLAN AND PROFILE - 8" WATERLINE

WILLOW ROAD/LINWOOD ROAD WATERLINE REPLACEMENT

WESTERN VIRGINIA WATER AUTHORITY

Vertical Scale: 1" = 10'

Horizontal Scale: 1" = 20'

Commission Number: 3812

Sheet No.: 4