




INSTALLED 5-20-19 ID 11598

MATCH LINE STA. 15+50 SHEET 4

MATCH LINE STA. 21+00 SHEET 6

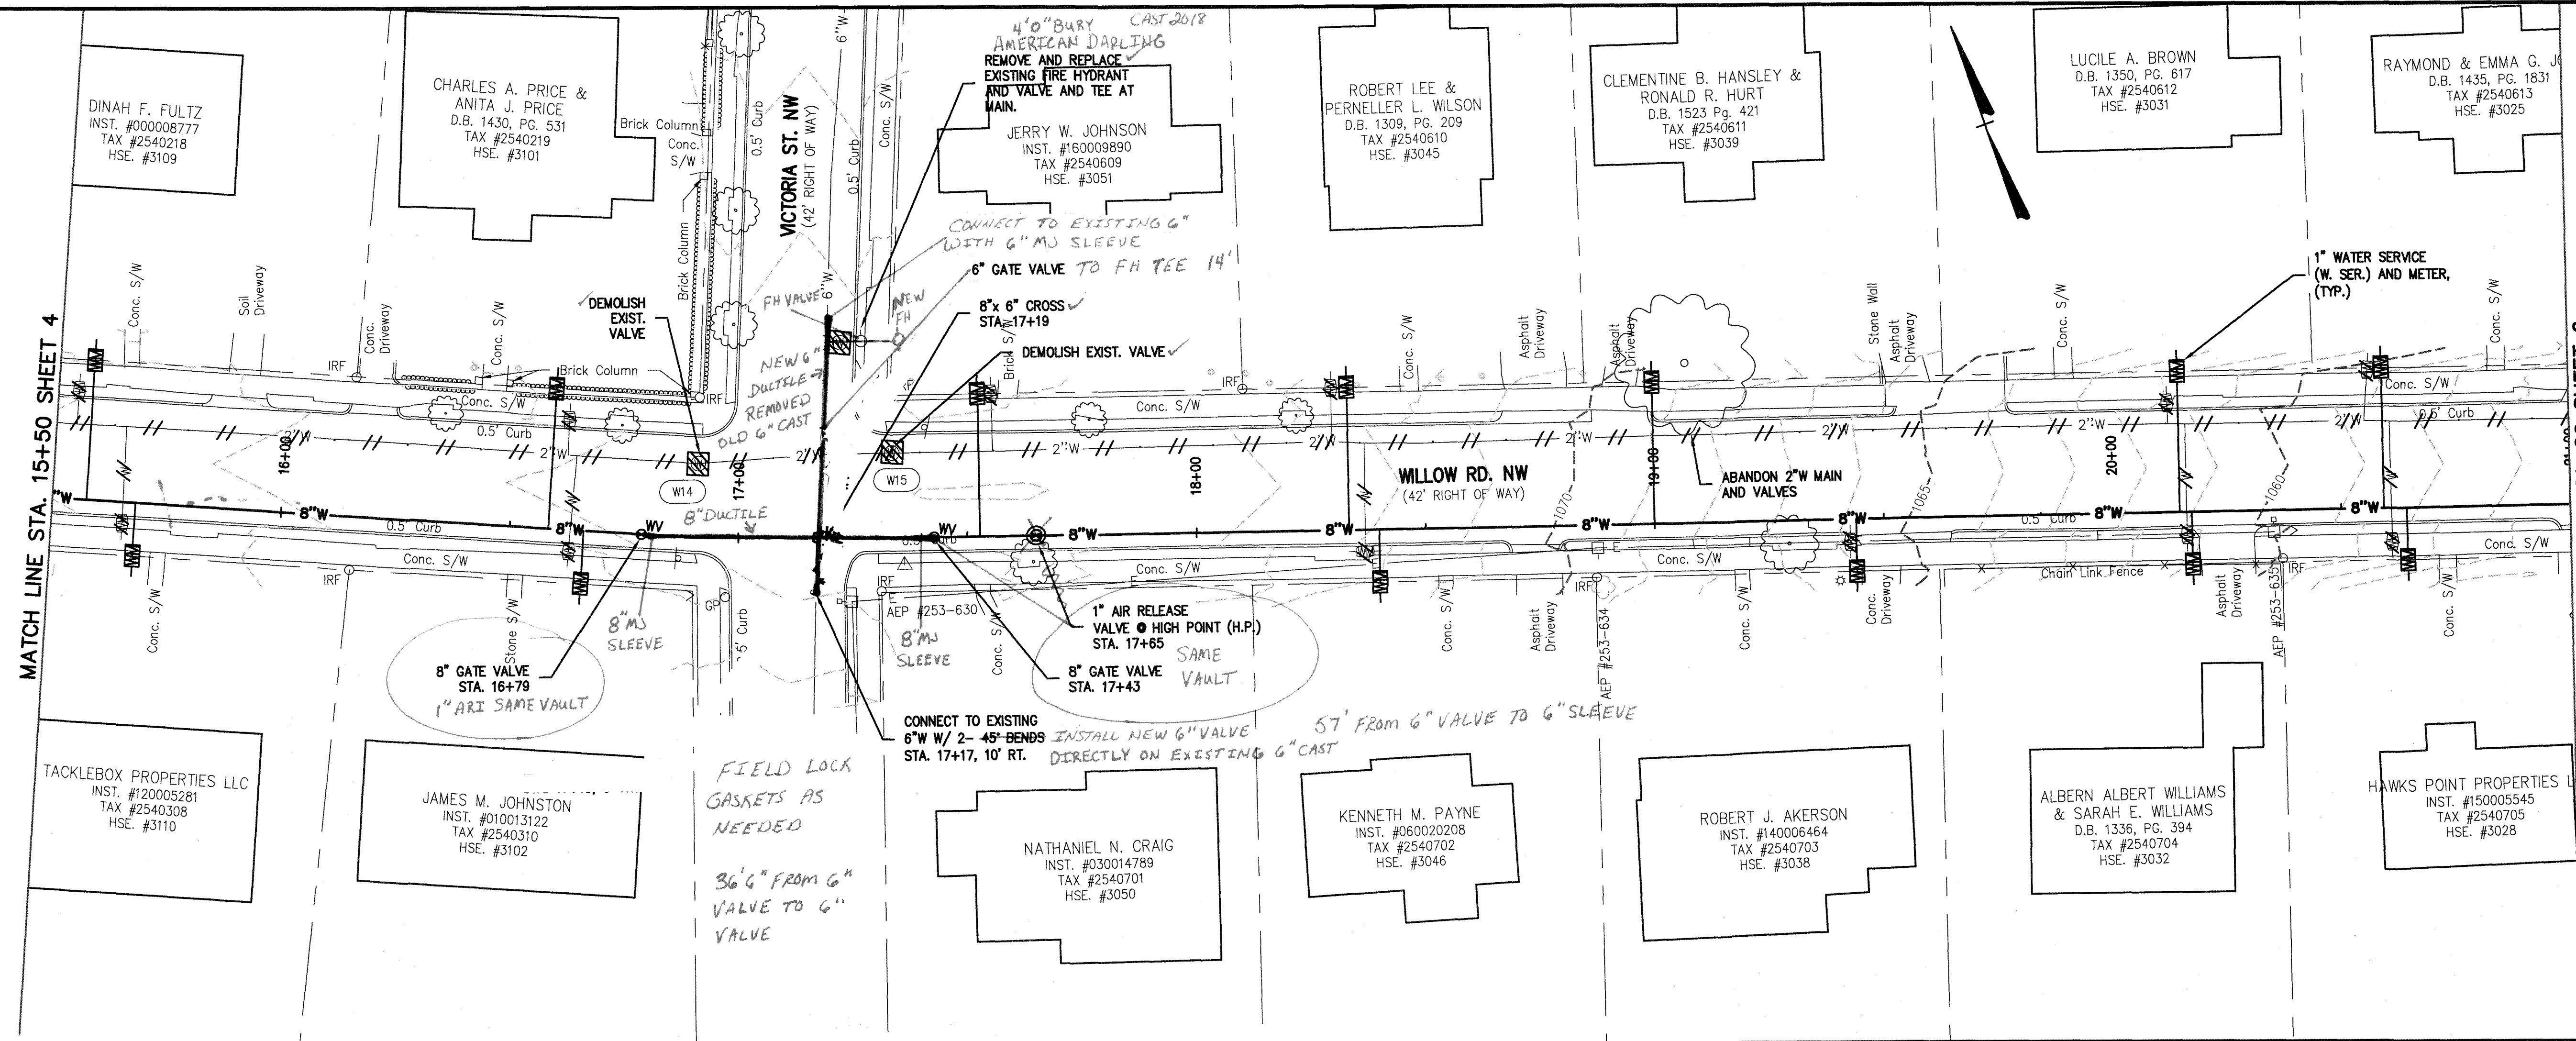

8 INCH WATER MAIN – WILLOW RD. PROFILE

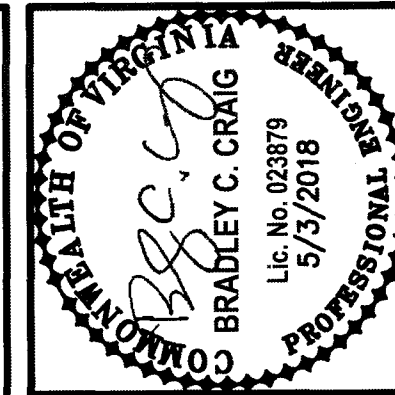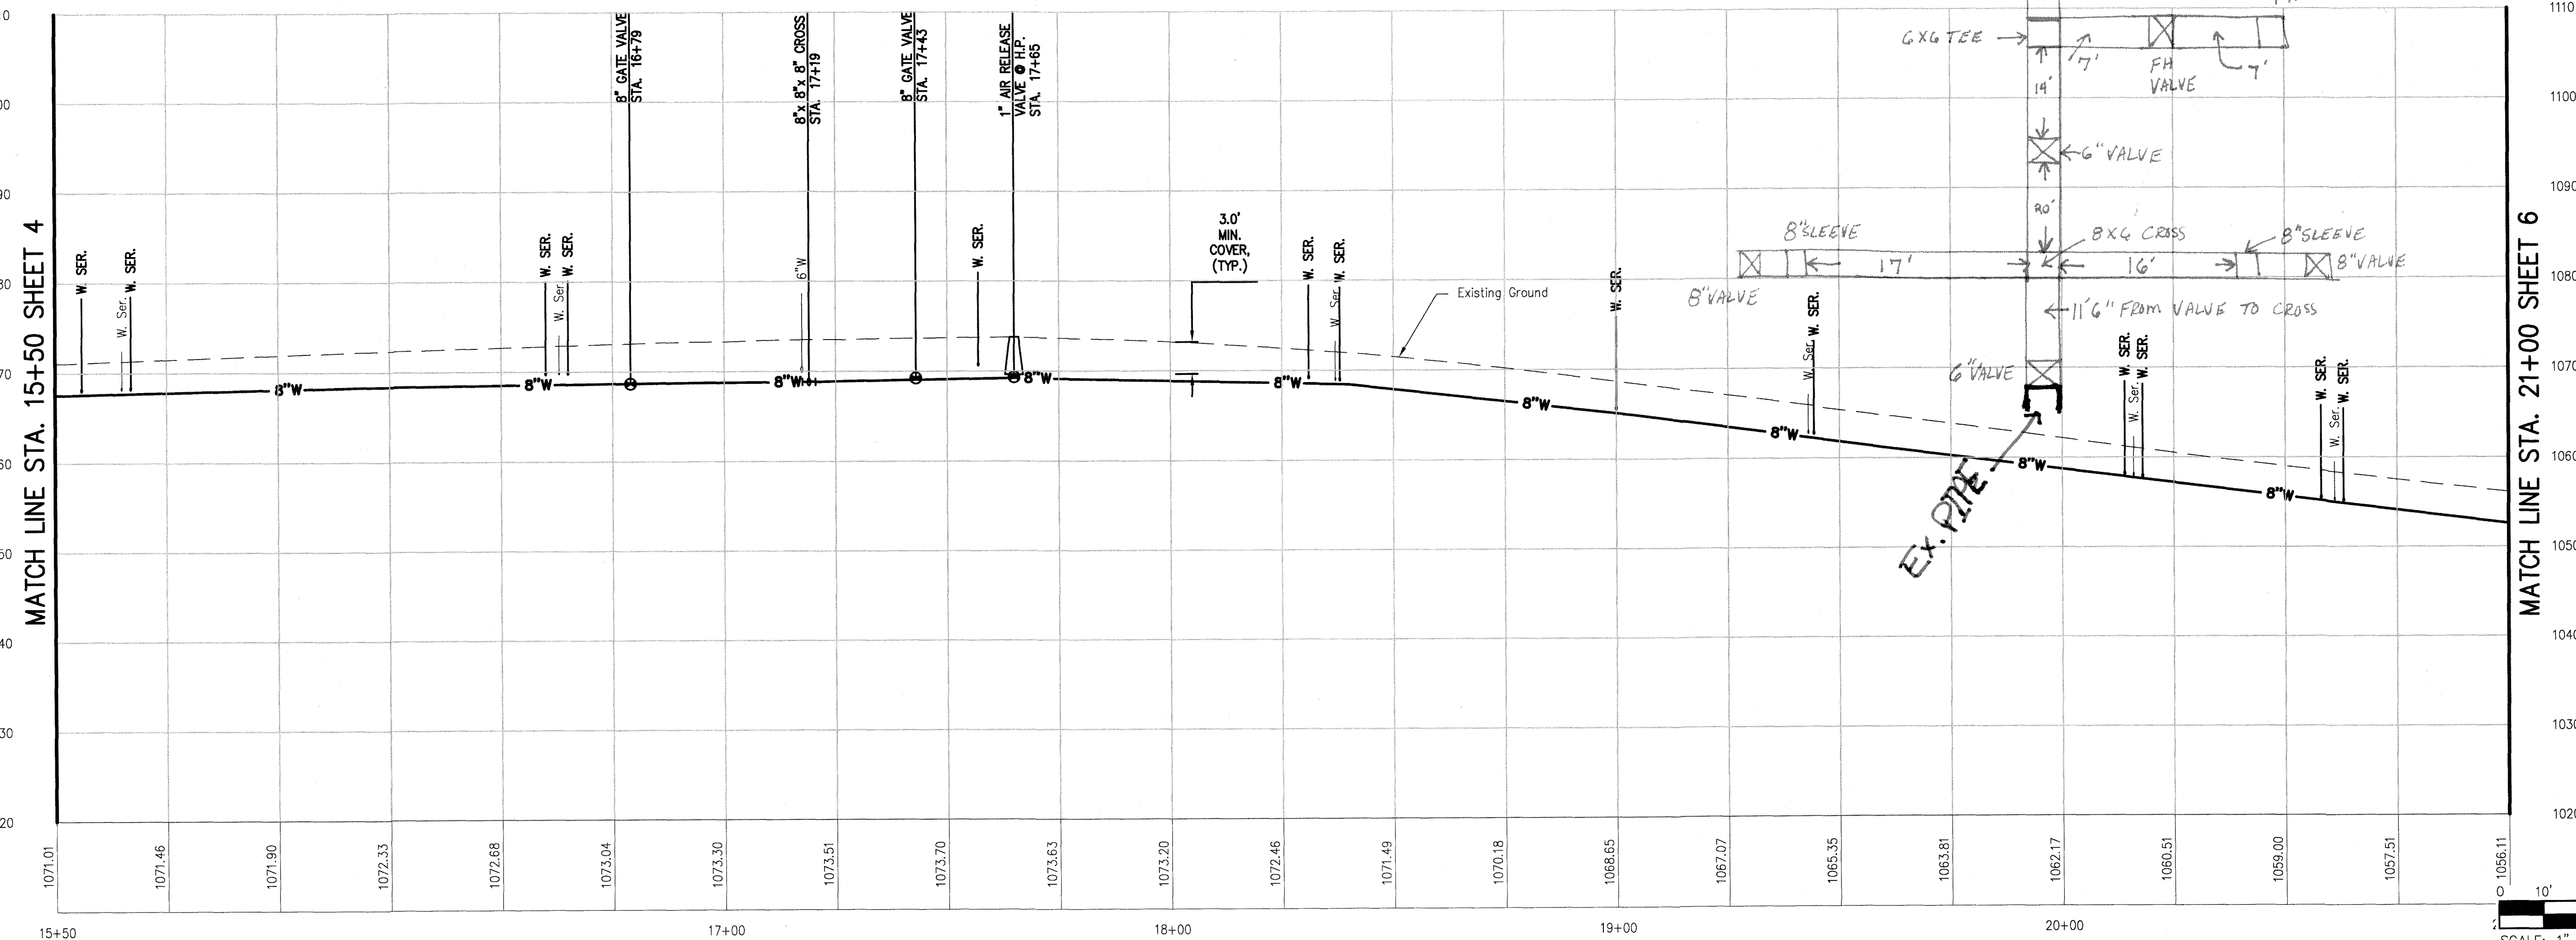

Revisions	Date
REVISED PER ADDENDUM # 2	5/3/18

Issue Date:	MAY 3, 2018
Drawn By:	DBL/ARB
Designed By:	DBL
Checked By:	BCC
Date:	5/3/2018

Mattern & Craig
ENGINEERS/SURVEYORS
701 FIRST STREET, S.W.
ROANOKE, VIRGINIA 24016
(540) 345-9342
FAX (540) 345-7891

WILLOW ROAD/LINWOOD ROAD WATERLINE REPLACEMENT
PLAN AND PROFILE – 8" WATERLINE
WESTERN VIRGINIA WATER AUTHORITY

Vertical Scale:	1" = 10'
Horizontal Scale:	1" = 20'
Commission Number:	3812
Sheet No.:	5