
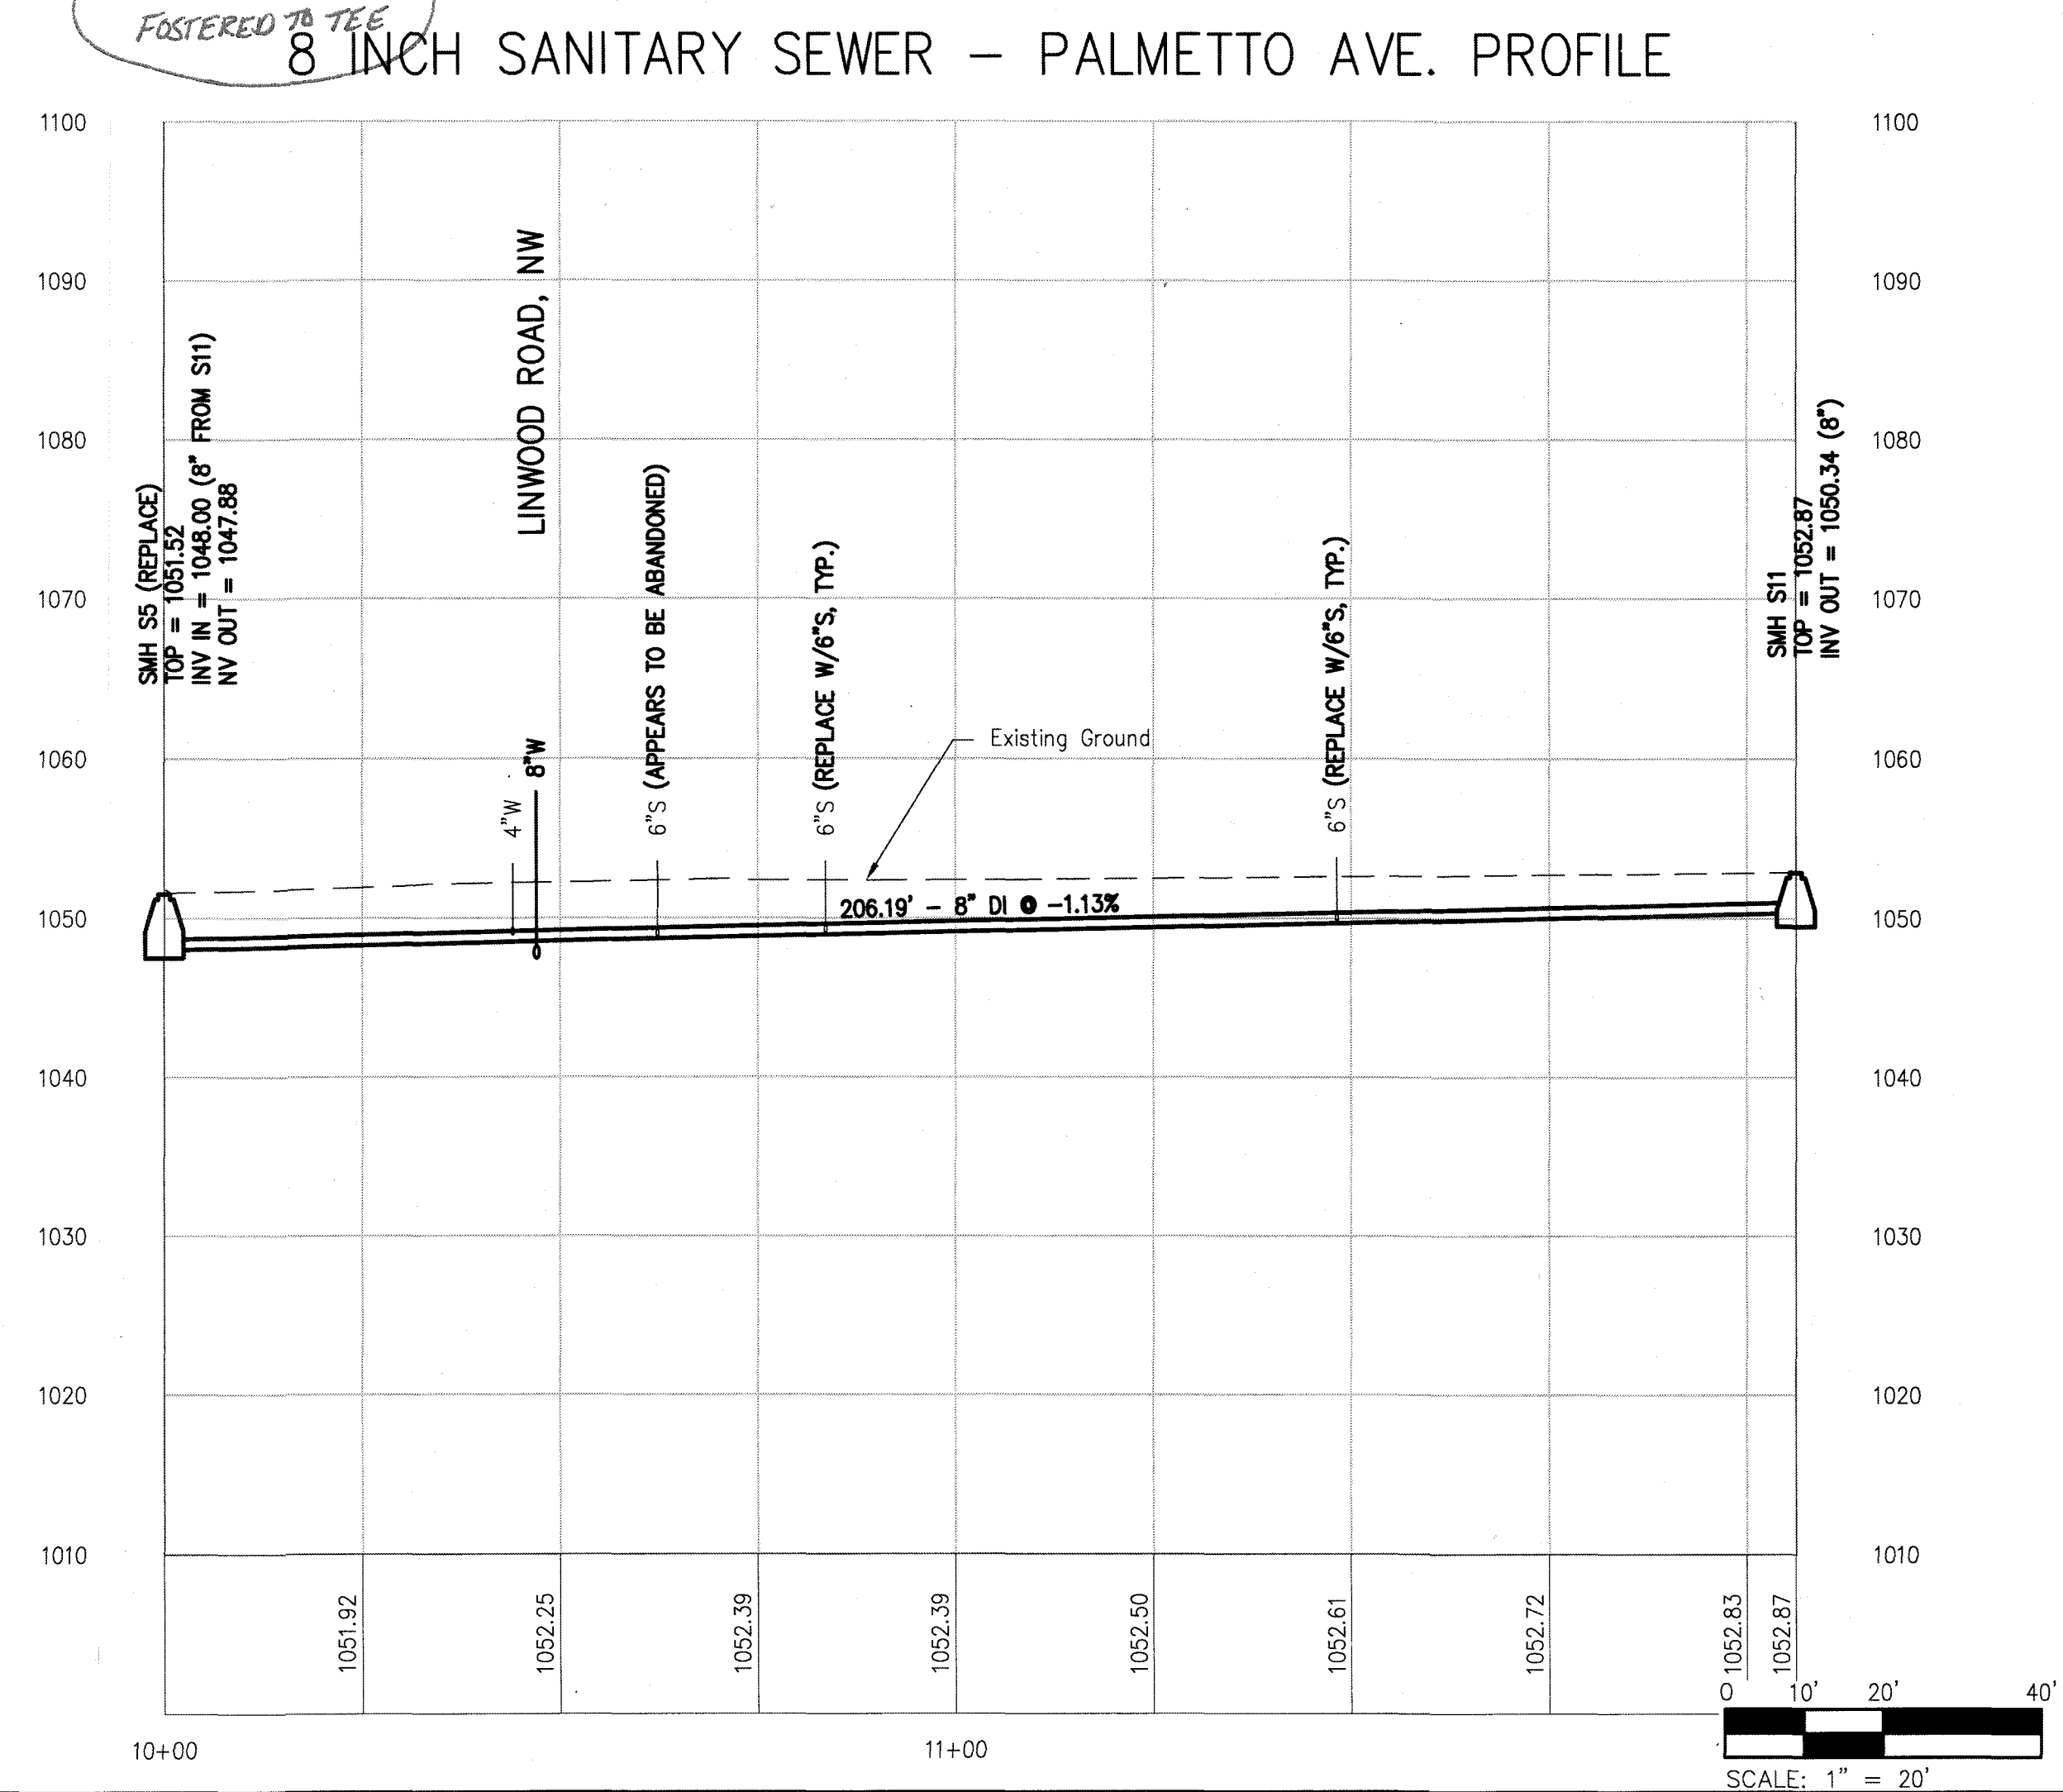
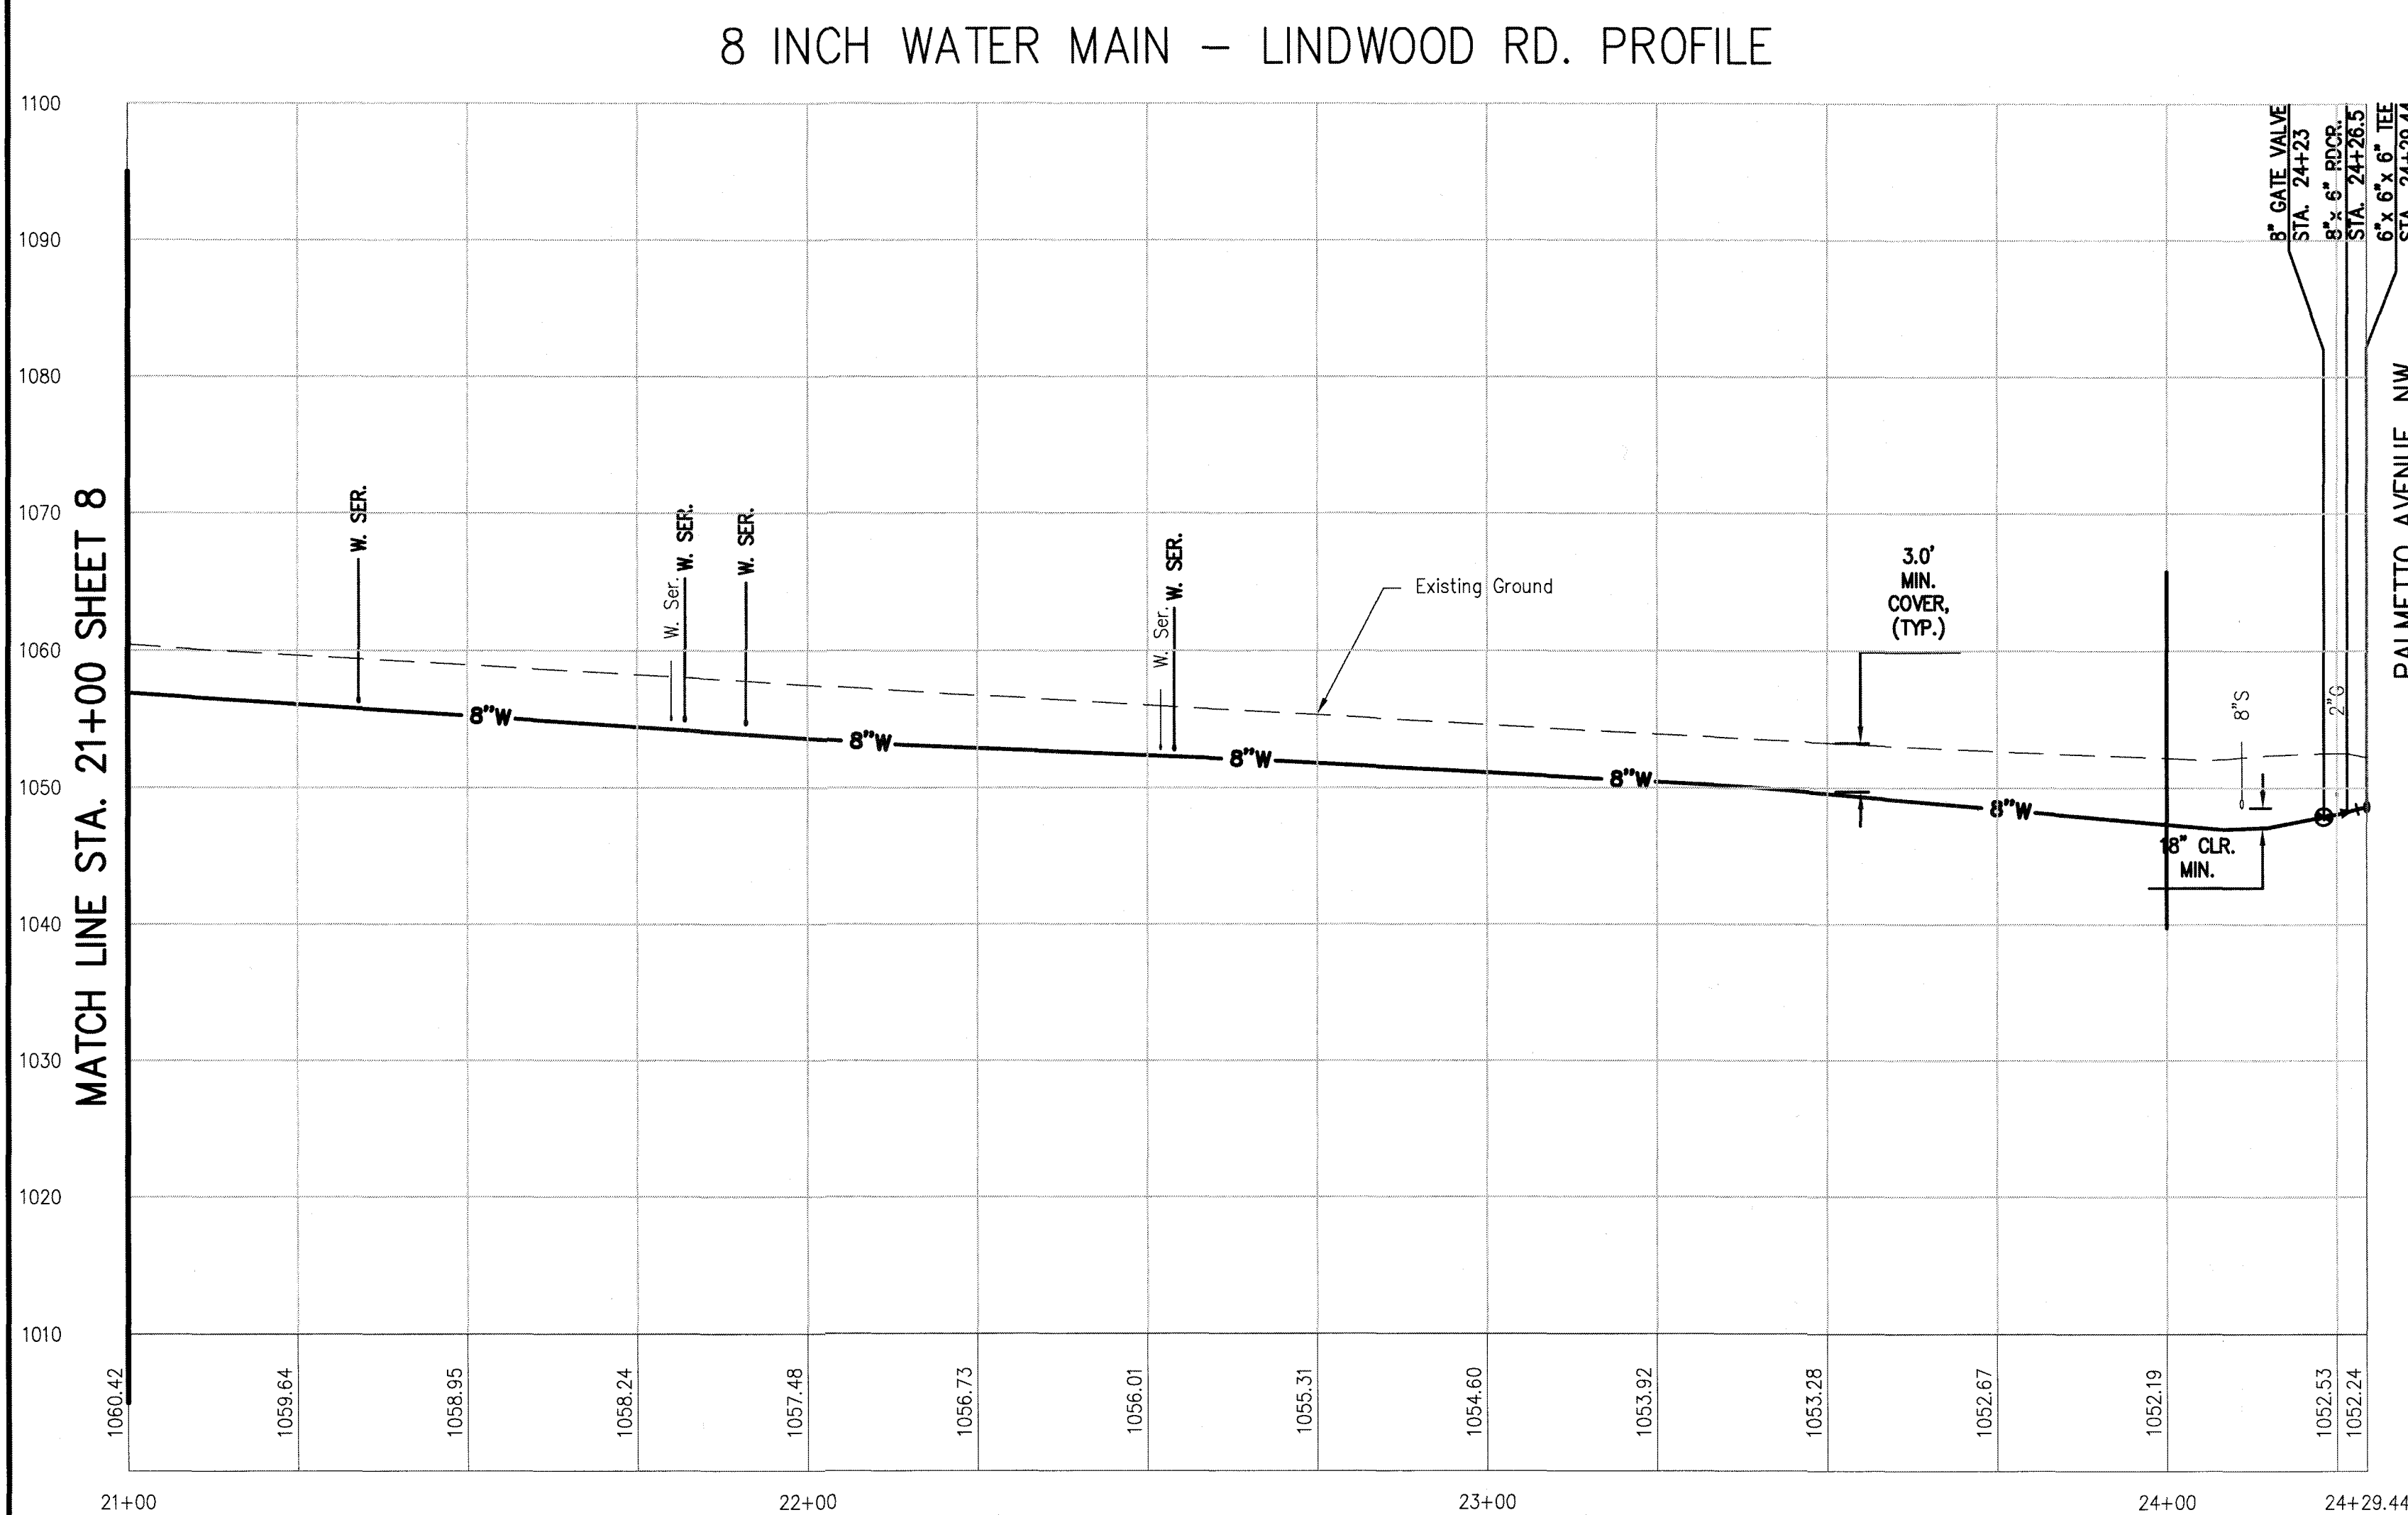


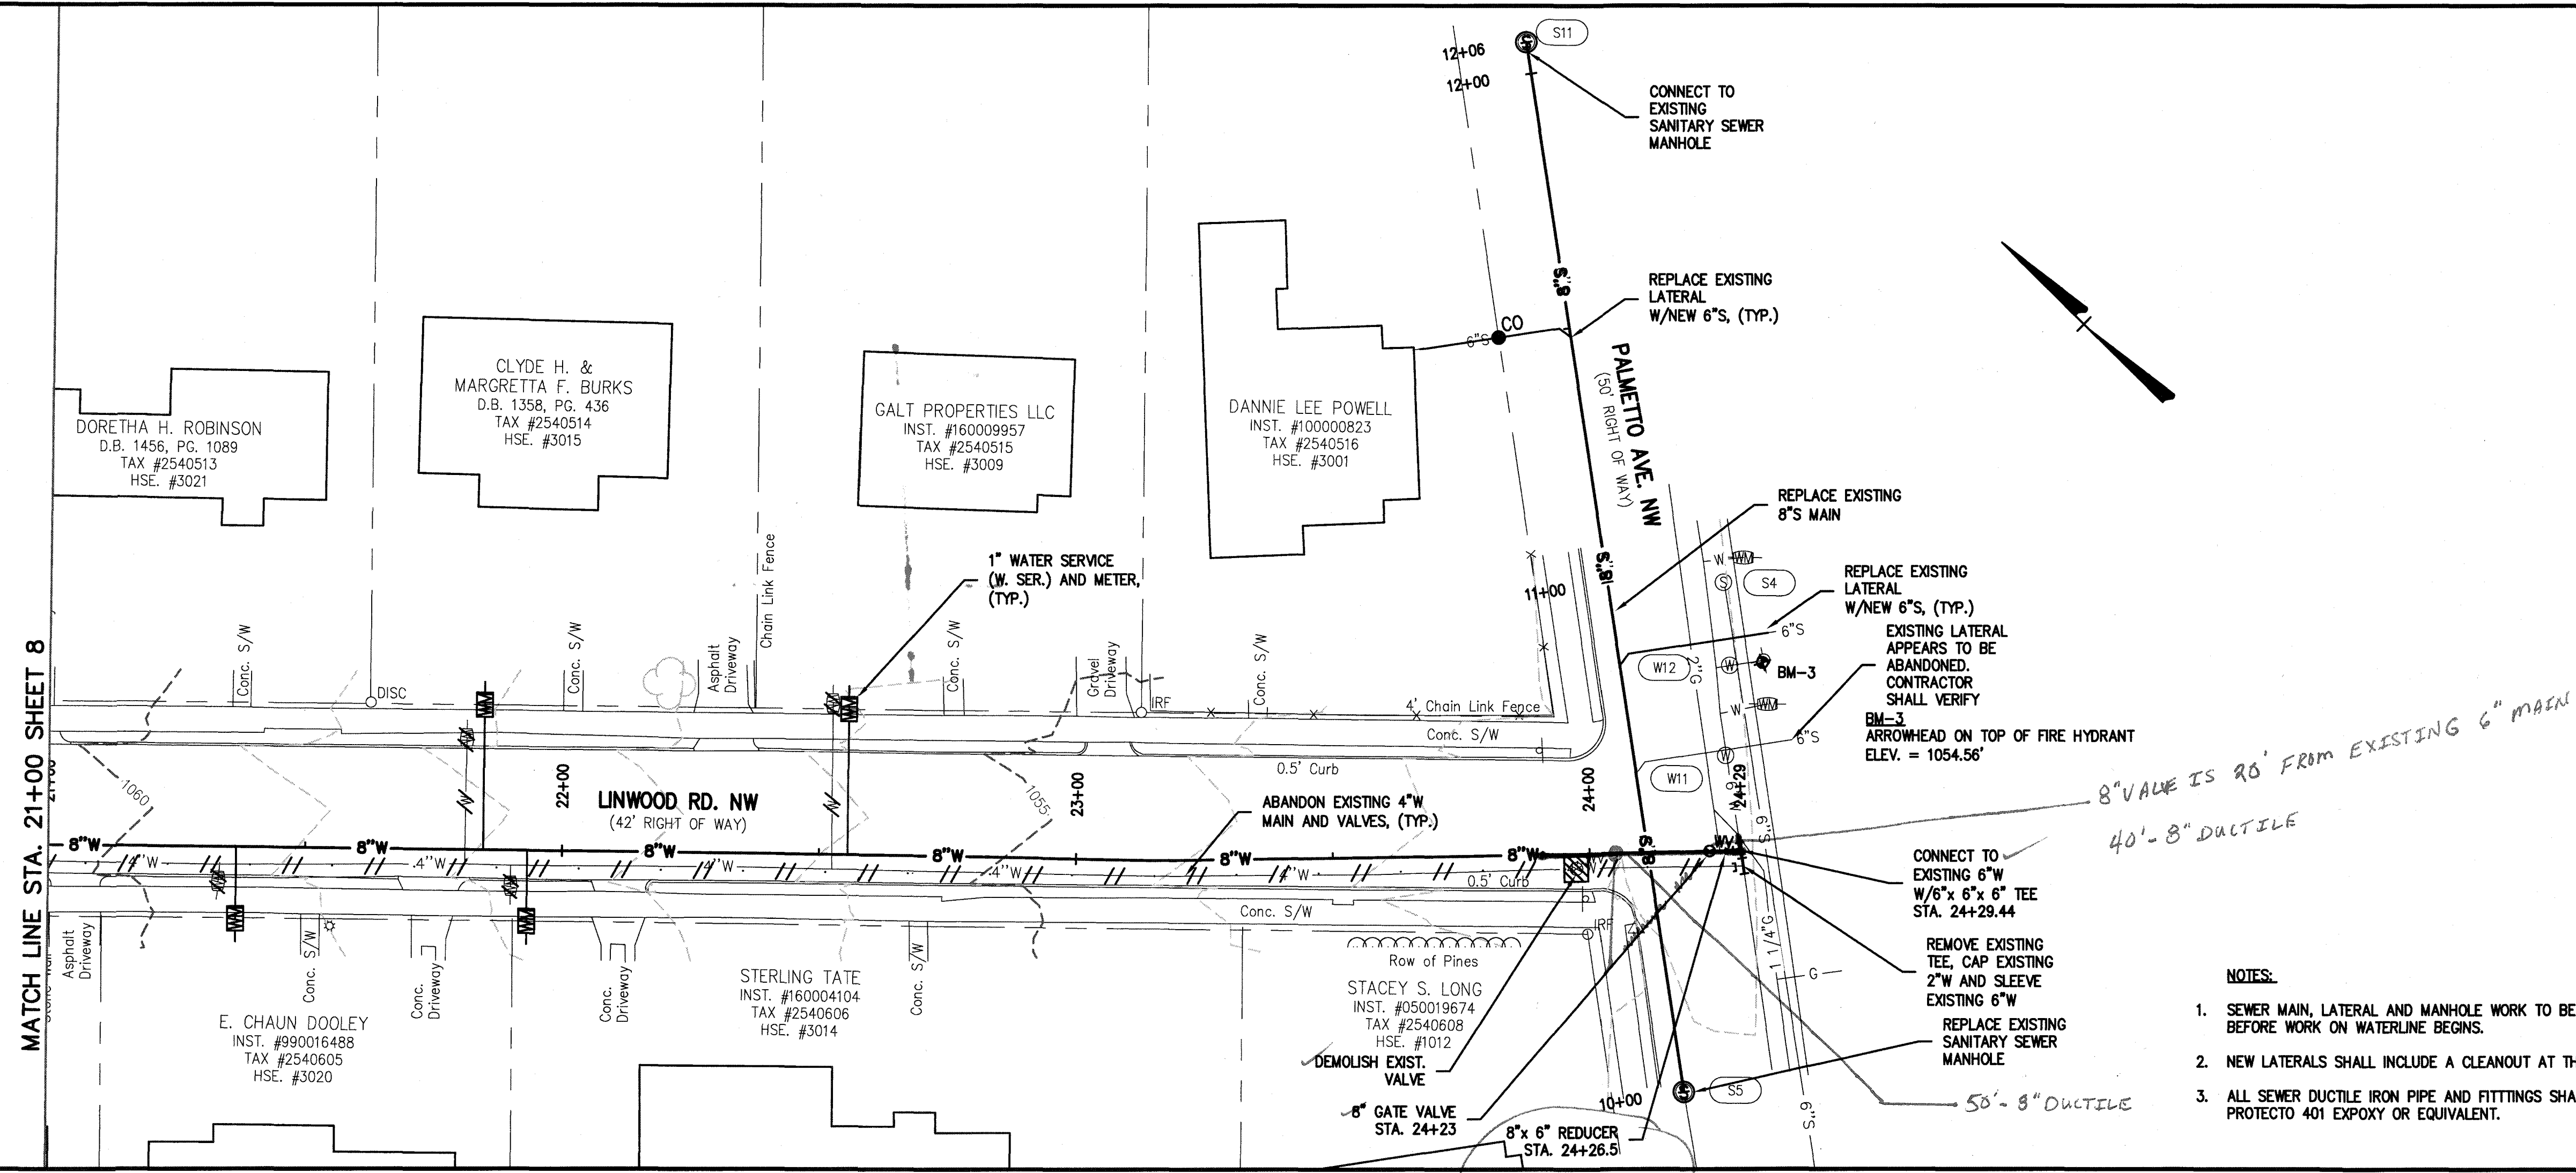

Revisions		Date
1	REVISED PER ADDENDUM # 2	5/3/18

Issue Date: MAY 3, 2018	Drawn By: DBL/ARB	Checked By: BCC
	Designed By: DBL	Date: 5/3/2018

Mattern & Craig
ENGINEERS/SURVEYORS

701 FIRST STREET, S.W.
ROANOKE, VIRGINIA 24016
(540) 345-9342
FAX (540) 345-7691

WILLOW ROAD/LINWOOD ROAD WATERLINE REPLACEMENT
PLAN AND PROFILE- 8" WATERLINE
WESTERN VIRGINIA WATER AUTHORITY

Vertical Scale:
1" = 10'

Horizontal Scale:
1" = 20'

Commission Number:
3812

Sheet No.:

9