
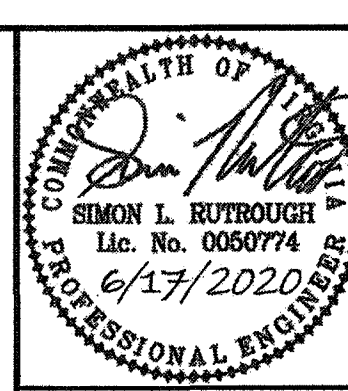


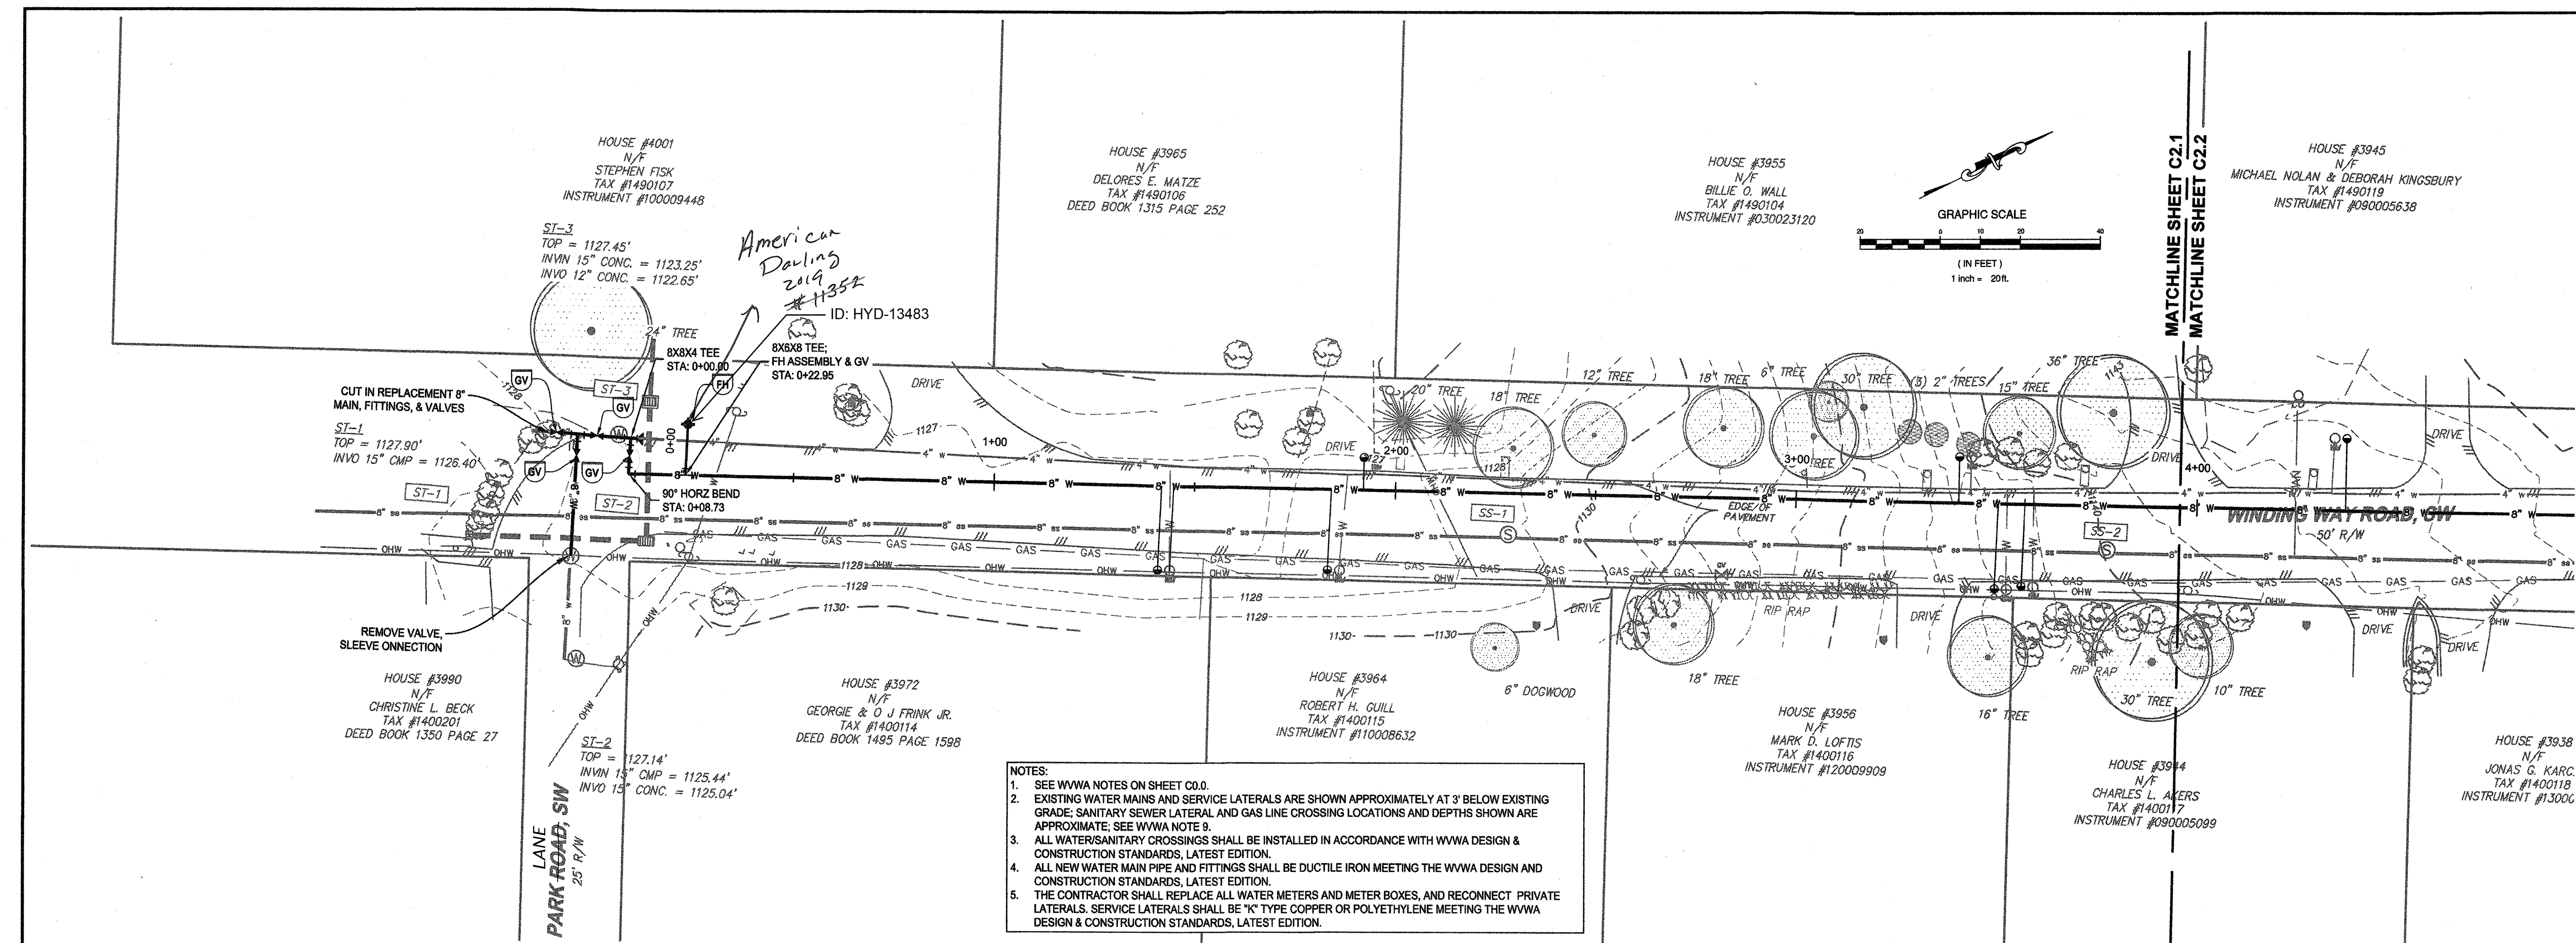

parker
DESIGN GROUP
PLANNERS • LANDSCAPE ARCHITECTS
2122 Carolina Ave. SW
Roanoke, VA 24014
(540)-387-1153
1915-B W. Cary Street
Richmond, VA 23220
(804)-358-2947
www.parkerdg.com

These documents are the property of Parker Design Group (PDG) and may not be reproduced or used without the express permission of PDG. Any reuse of these documents without authorization of PDG will be at the sole risk of the individual or entity utilizing said documents.

**WINDING WAY RD & DOGWOOD LN
WATER MAIN REPLACEMENT PLAN
WESTERN VIRGINIA WATER AUTHORITY
CITY OF ROANOKE, VIRGINIA**

REVISIONS

DESIGNED BY:
CEP

DRAWN BY:
CEP

CHECKED BY:
SLR

SCALE:
1" = 20'

DATE:
JUNE 17, 2020

PROJECT NUMBER:
20-0034

SHEET TITLE:
**PLAN AND PROFILE
- STA 0+00 TO STA
4+00**

C2.1
12 OF 23

