
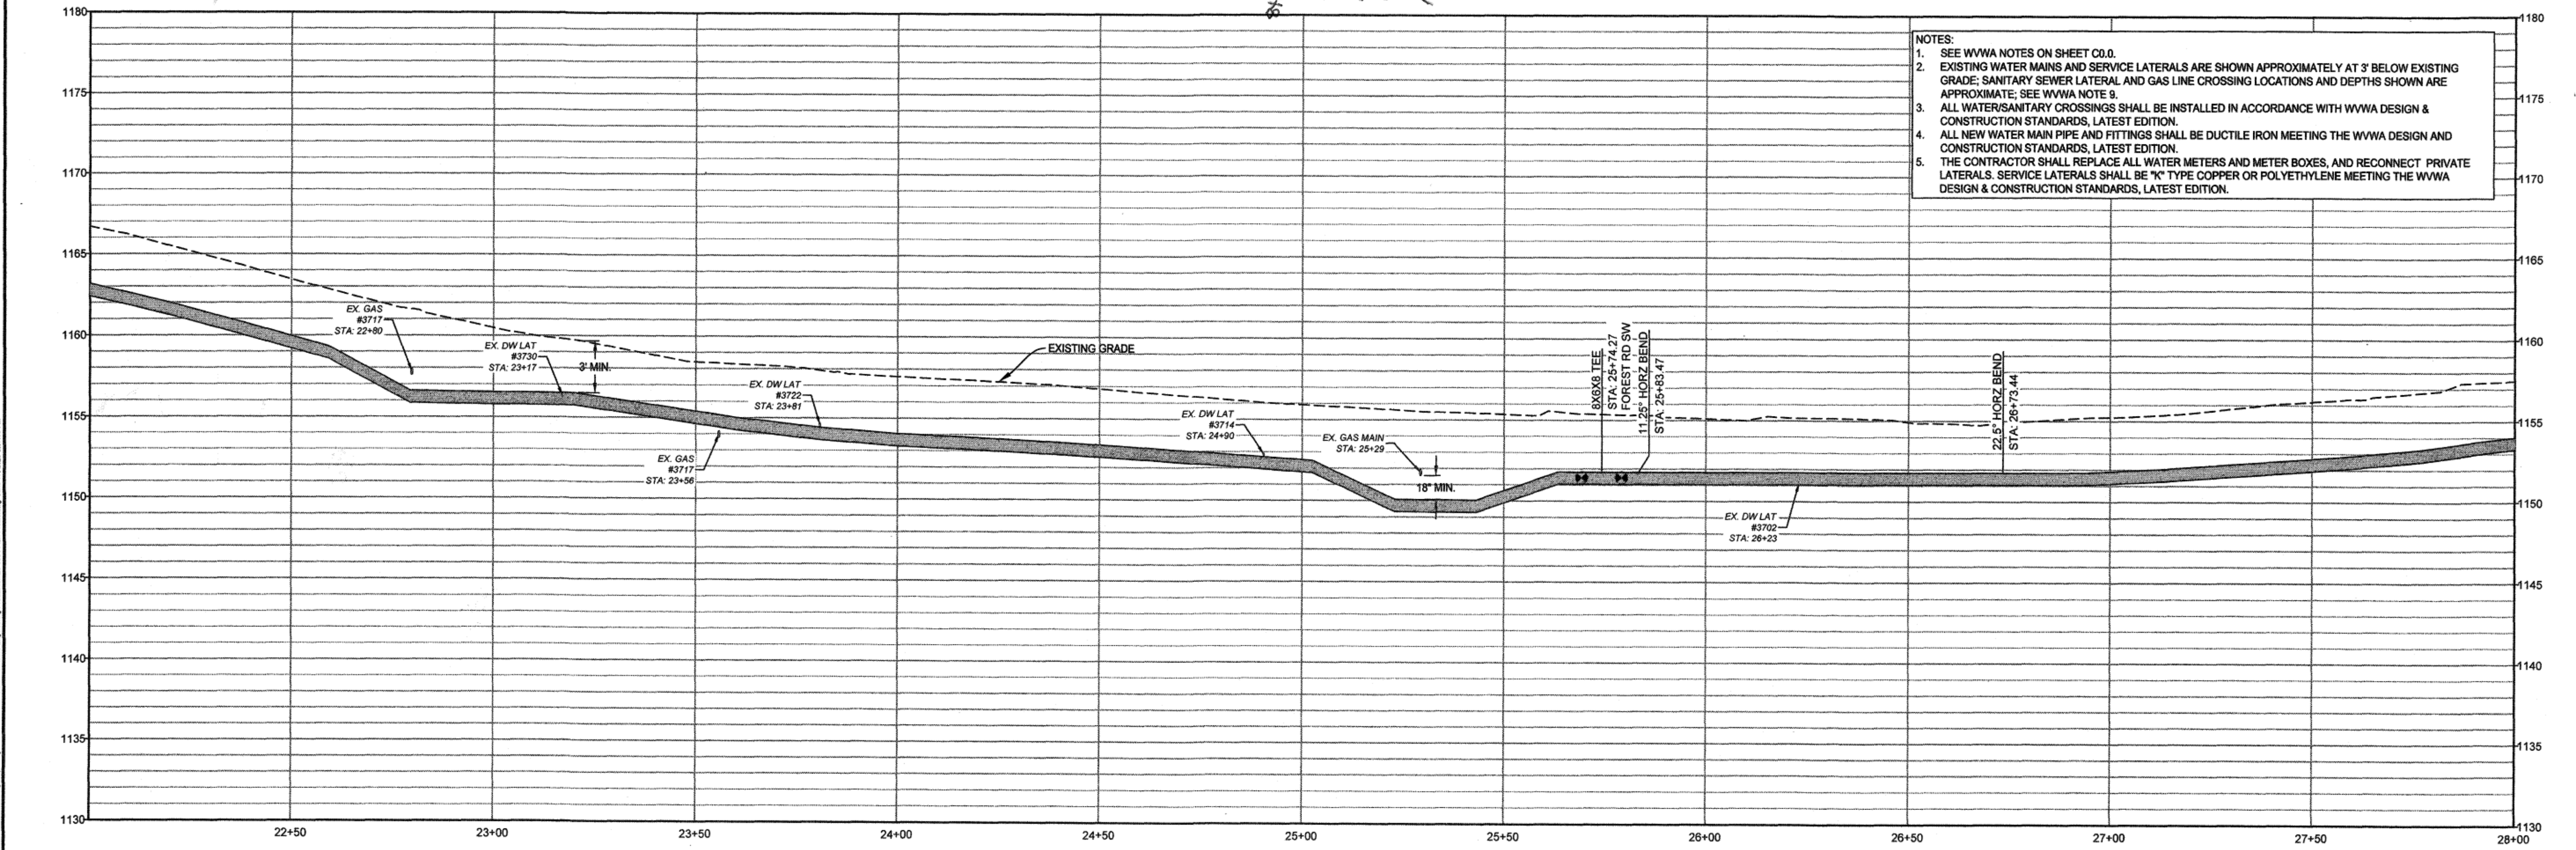


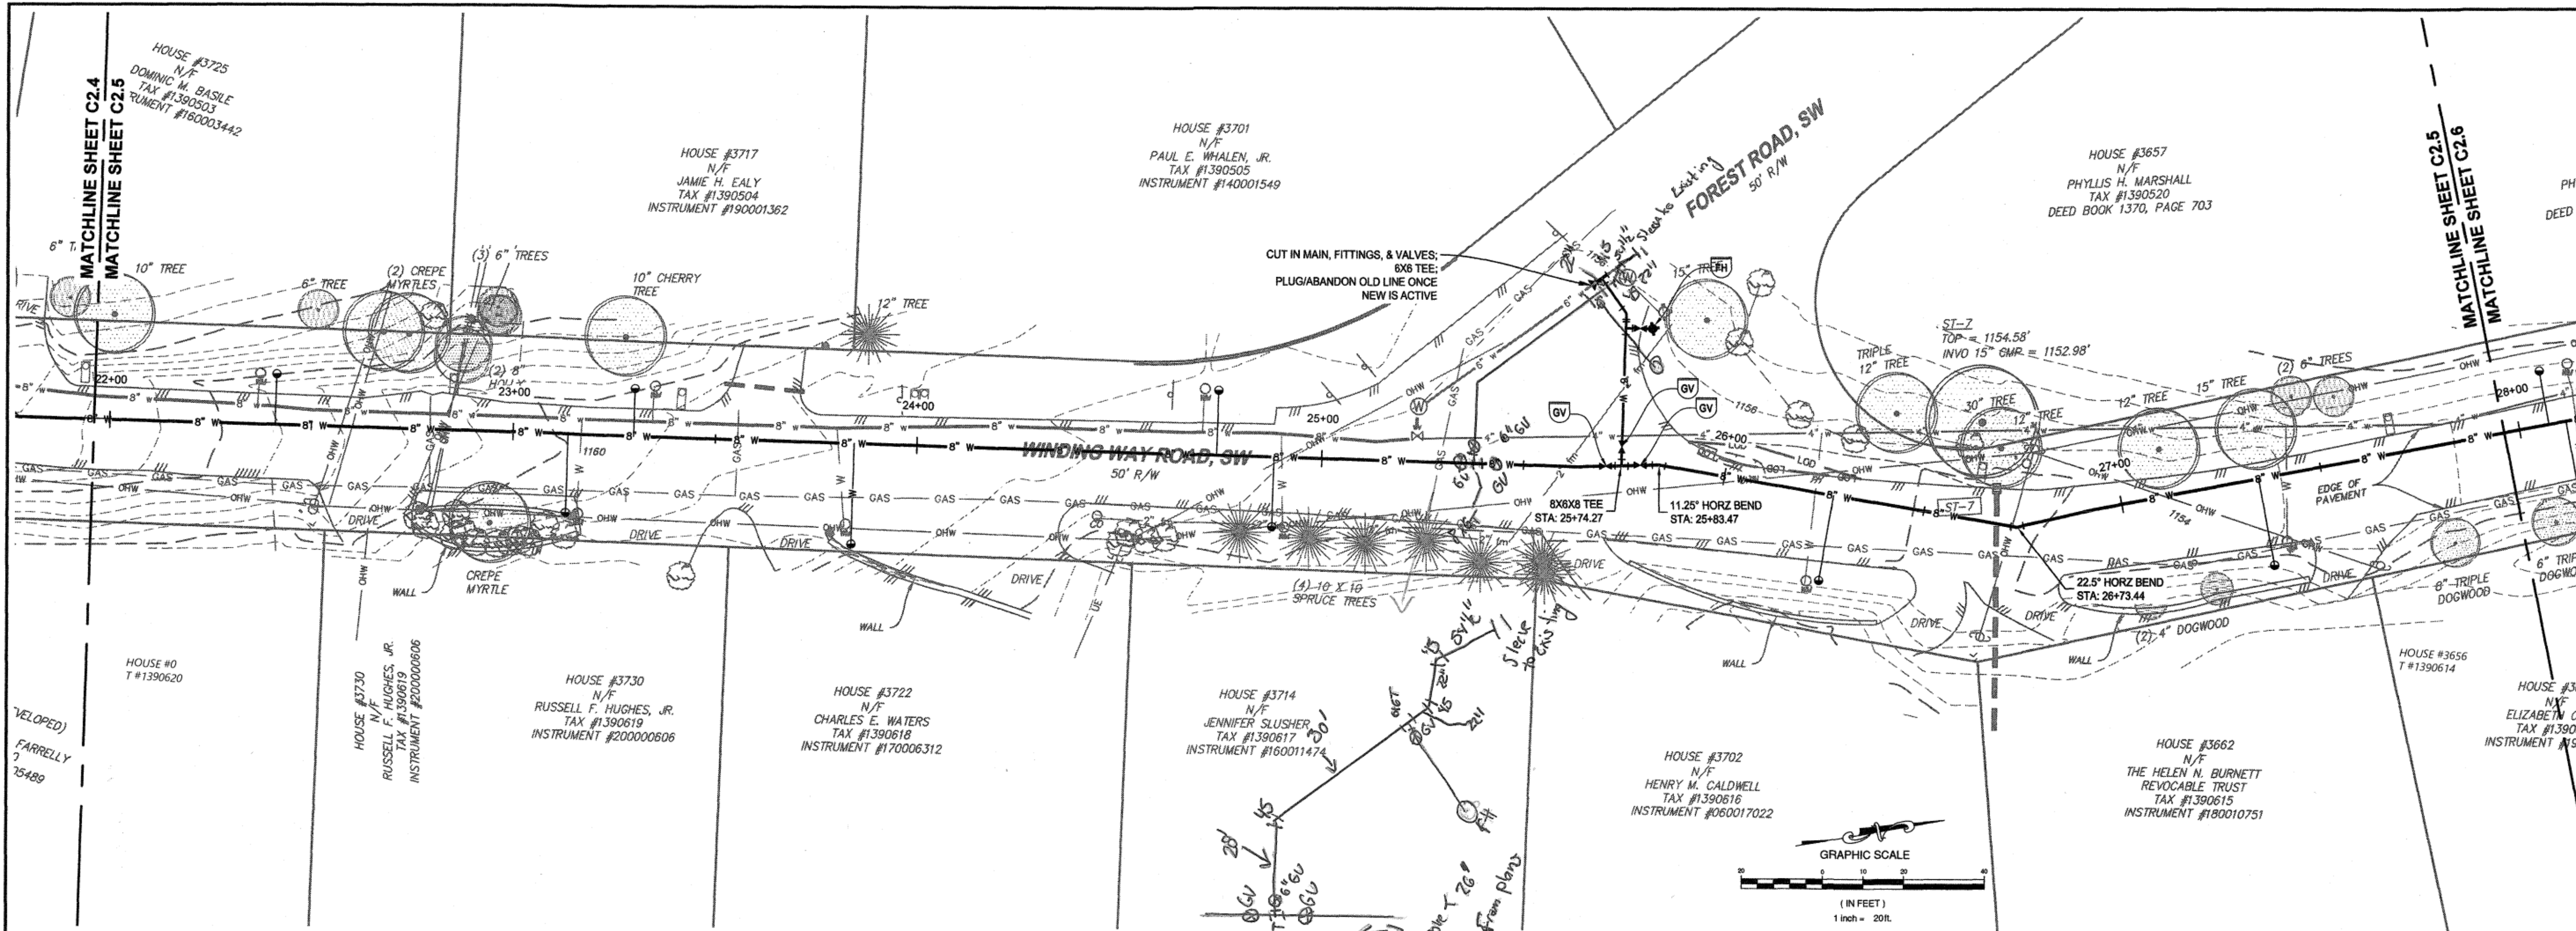

PROFILE: STA 22+00 TO STA 28+00 - Scale: H: 1"=20', V: 1"=5'

SEAL

COMMUNITY OF

SIMON L. RUTENFRANZ

Lic. No. 0080774

6/17/2020

PROFESSIONAL ENGINEER

parker

DESIGN GROUP

ENGINEERS & SURVEYORS

PLANNERS & LANDSCAPE ARCHITECTS

2122 Carolina Ave. SW

Roanoke, VA 24014

(540) 387-1153

1915-B W. Cary Street

Richmond, VA 23220

(804) 358-2947

www.parkerdg.com

These documents are the property of Parker Design Group/PGC and may not be reproduced or used without the express permission of PGC. Any reuse of these documents without authorization of PGC will be at the sole risk of the individual or entity utilizing said documents.

WINDING WAY RD & DOGWOOD LN

WATER MAIN REPLACEMENT PLAN

WESTERN VIRGINIA WATER AUTHORITY

CITY OF ROANOKE, VIRGINIA

REVISIONS

DESIGNED BY:	CEP
DRAWN BY:	CEP
CHECKED BY:	SLR
SCALE:	1" = 20'
DATE:	JUNE 17, 2020
PROJECT NUMBER:	20-0034
SHEET TITLE:	PLAN AND PROFILE - STA 22+00 TO STA 28+00

C2.5

16 OF 23