



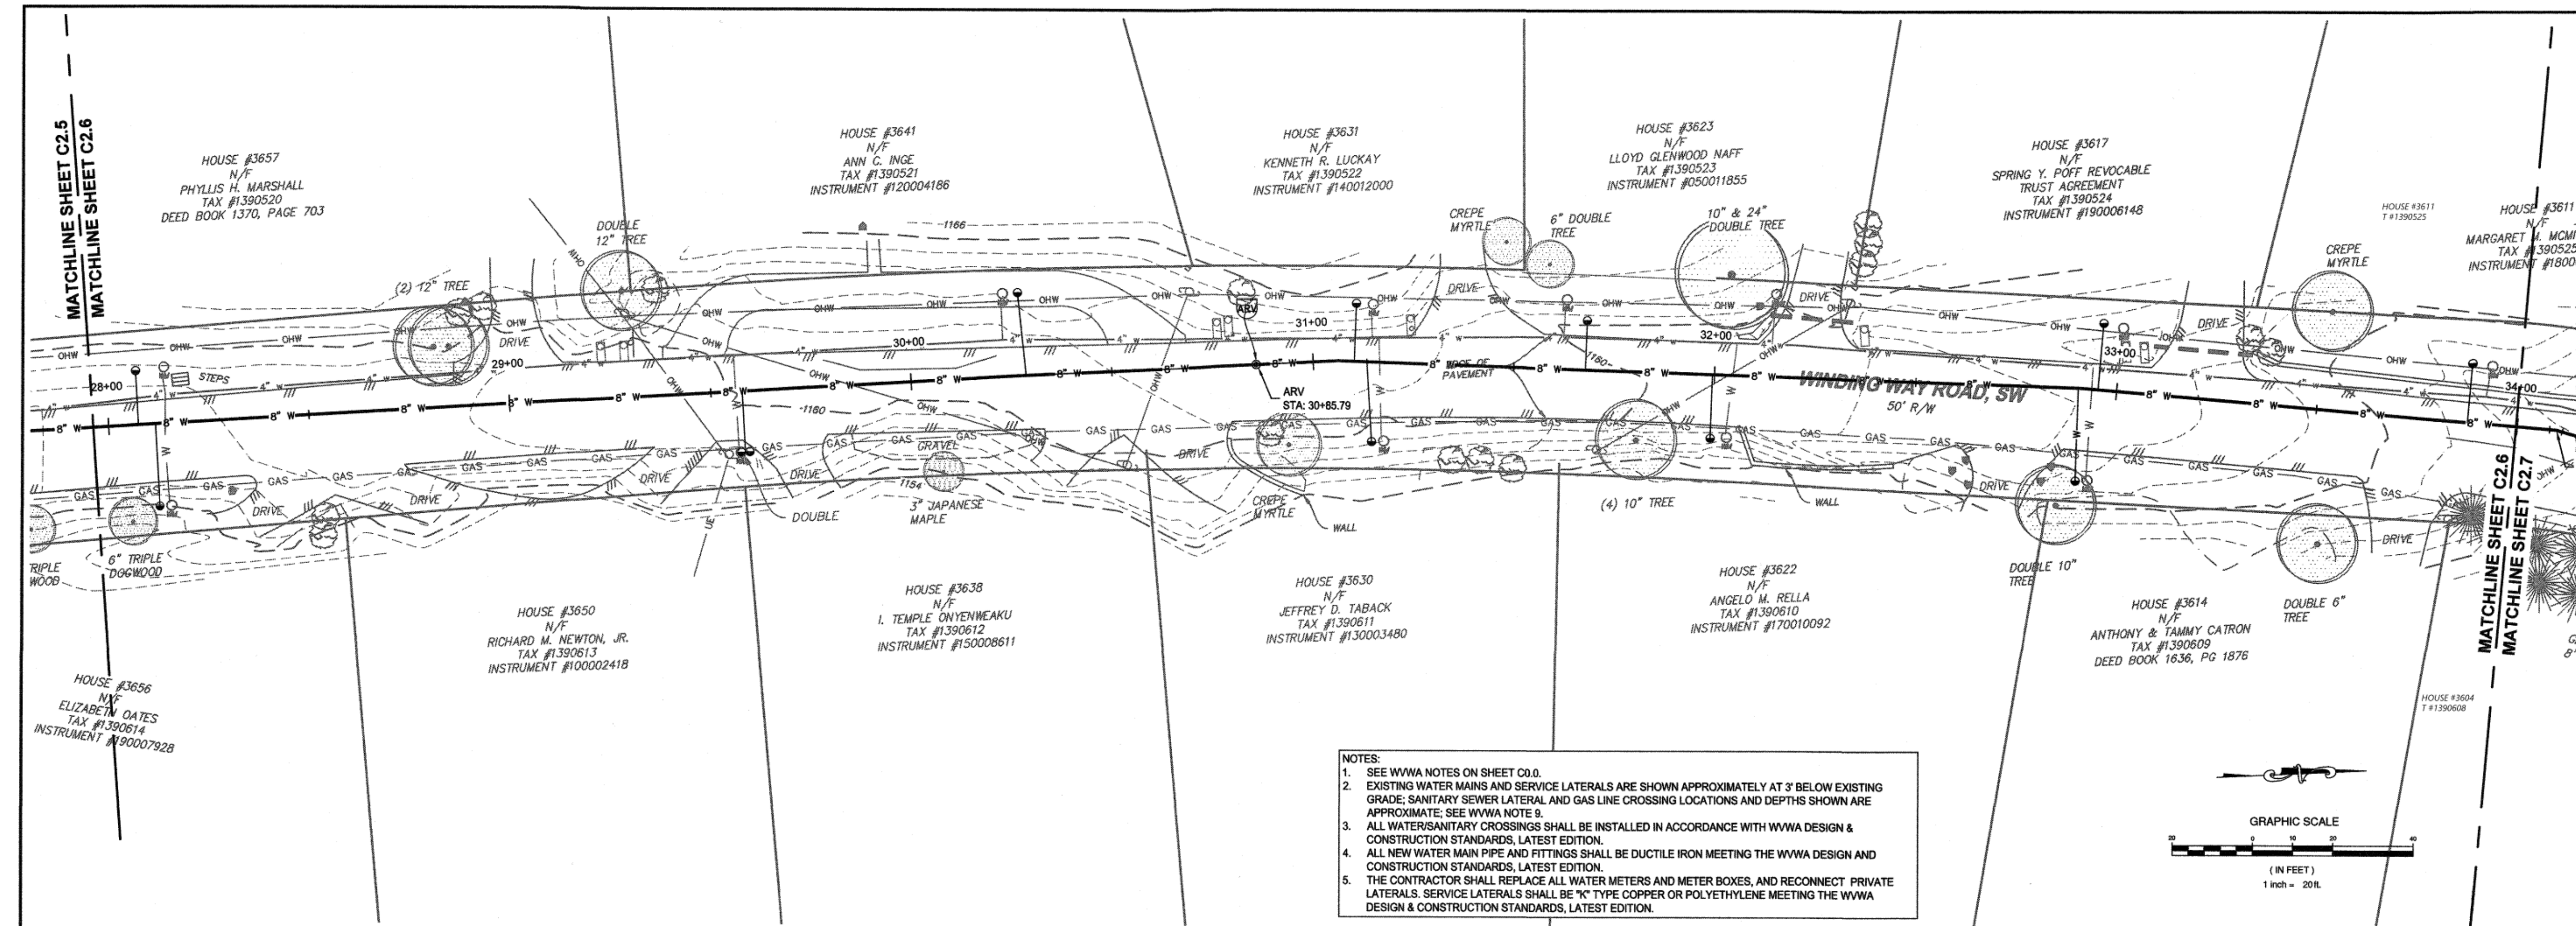

- NOTES:
1. SEE WWA NOTES ON SHEET C0.0.
 2. EXISTING WATER MAINS AND SERVICE LATERALS ARE SHOWN APPROXIMATELY AT 3' BELOW EXISTING GRADE. SANITARY SEWER LATERAL AND GAS LINE CROSSING LOCATIONS AND DEPTHS SHOWN ARE APPROXIMATE. SEE WWA NOTE 9.
 3. ALL WATER/SANITARY CROSSINGS SHALL BE INSTALLED IN ACCORDANCE WITH WWA DESIGN & CONSTRUCTION STANDARDS, LATEST EDITION.
 4. ALL NEW WATER MAIN PIPE AND FITTINGS SHALL BE DUCTILE IRON MEETING THE WWA DESIGN AND CONSTRUCTION STANDARDS, LATEST EDITION.
 5. THE CONTRACTOR SHALL REPLACE ALL WATER METERS AND METER BOXES, AND RECONNECT PRIVATE LATERALS. SERVICE LATERALS SHALL BE "K" TYPE COPPER OR POLYETHYLENE MEETING THE WWA DESIGN & CONSTRUCTION STANDARDS, LATEST EDITION.

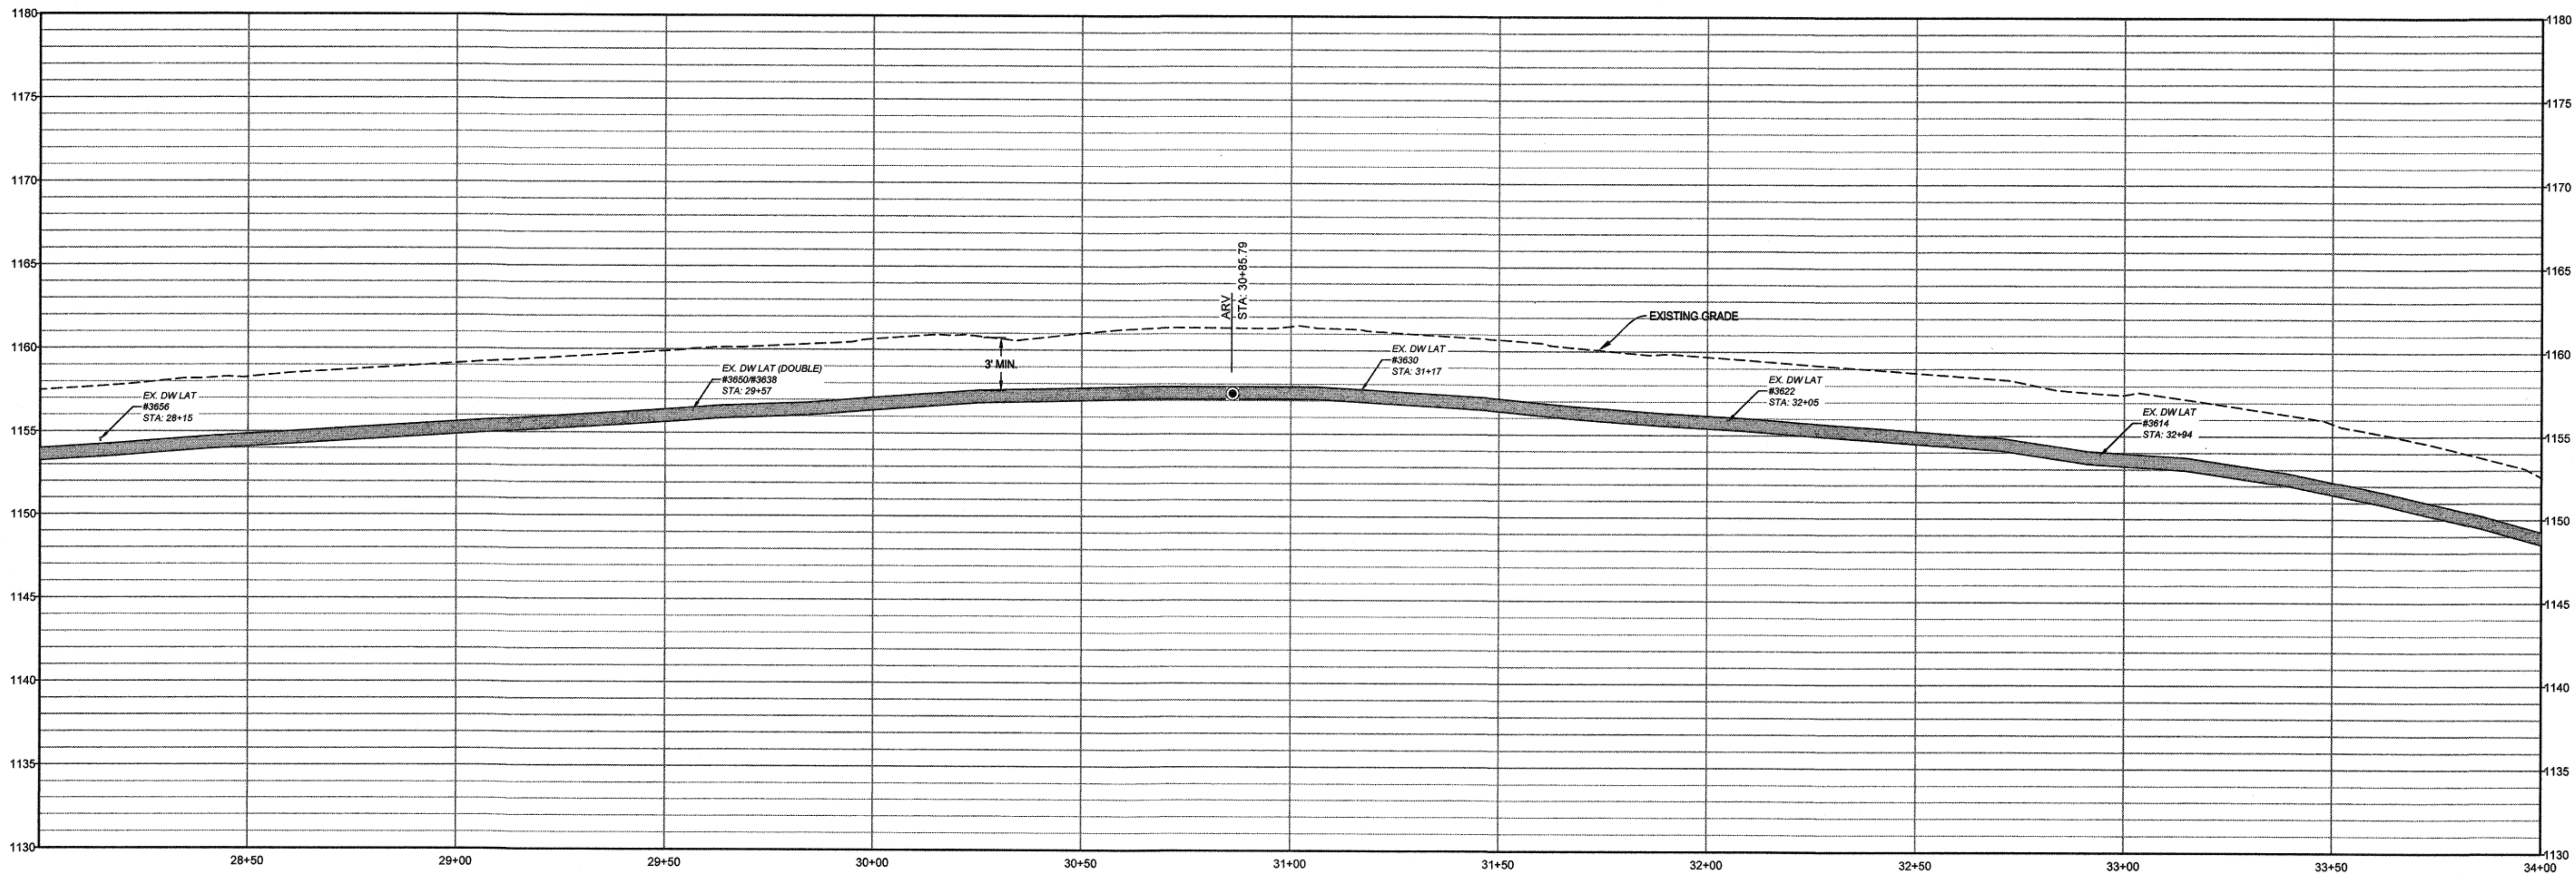

COMMONWEALTH OF VIRGINIA
SEAL
SIMON L. RUTBROUGH
Lic. No. 0050774
6/17/2020
PROFESSIONAL ENGINEER

parker
DESIGN GROUP
ENGINEERS • SURVEYORS
PLANNERS • LANDSCAPE ARCHITECTS
2122 Carolina Ave. SW
Roanoke, VA 24014
(540)-387-1153
1915-B W. Cary Street
Richmond, VA 23220
(804)-358-2947
www.parkerdg.com

These documents are the property of Parker Design Group (PDG) and may not be reproduced or used without the express permission of PDG. Any reuse of these documents without authorization of PDG will be at the sole risk of the individual or entity utilizing said documents.

**WINDING WAY RD & DOGWOOD LN
WATER MAIN REPLACEMENT PLAN
WESTERN VIRGINIA WATER AUTHORITY**
CITY OF ROANOKE, VIRGINIA

REVISIONS

DESIGNED BY: CEP
DRAWN BY: CEP
CHECKED BY: SLR
SCALE: 1" = 20'
DATE: JUNE 17, 2020
PROJECT NUMBER: 20-0034
SHEET TITLE: PLAN AND PROFILE - STA 28+00 TO STA 34+00

C2.6
17 OF 23