

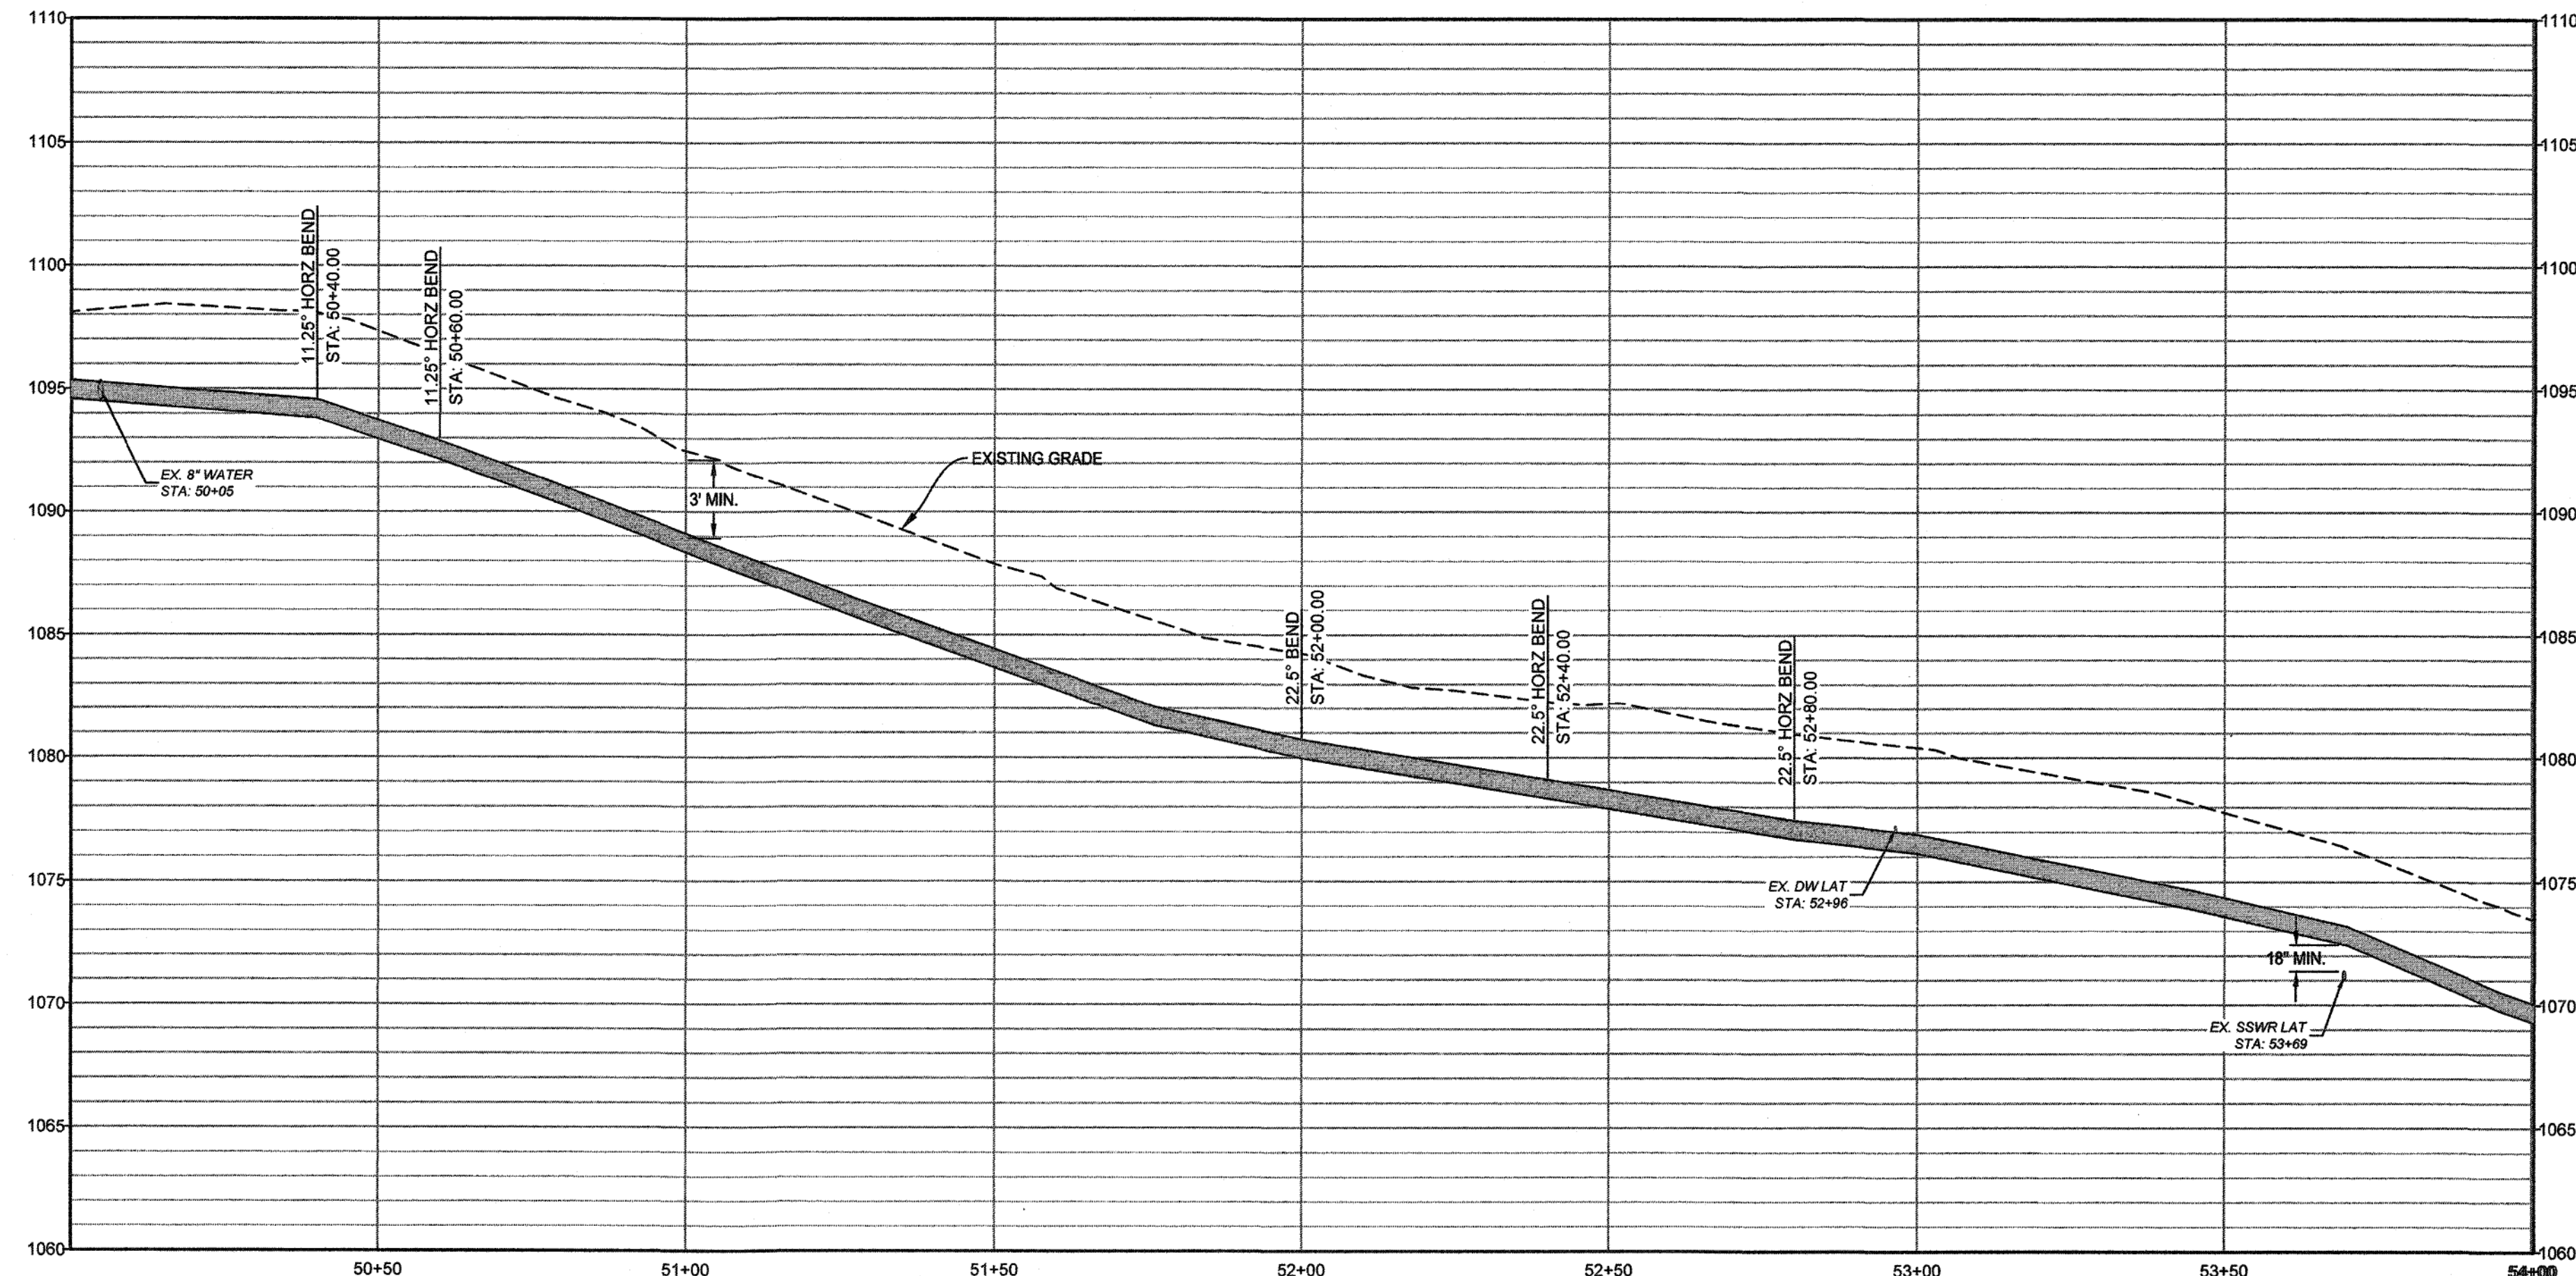
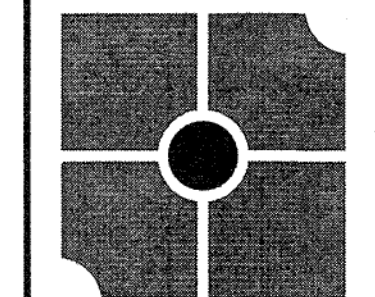


5/20/2020 Project: C2.9 Winding Way Rd & Dogwood Ln Water Main Replacement Plan - Dogwood Ln - STA 50+00 TO STA 54+00 - Scale: H: 1"=20', V: 1"=5' - June 17, 2020 3:57:44 PM

- NOTES:
1. SEE WVWA NOTES ON SHEET C0.0.
 2. EXISTING WATER MAINS AND SERVICE LATERALS ARE SHOWN APPROXIMATELY AT 3' BELOW EXISTING GRADE; SANITARY SEWER LATERAL AND GAS LINE CROSSING LOCATIONS AND DEPTHS SHOWN ARE APPROXIMATE; SEE WVWA NOTE 8.
 3. ALL WATERSANITARY CROSSINGS SHALL BE INSTALLED IN ACCORDANCE WITH WVWA DESIGN & CONSTRUCTION STANDARDS, LATEST EDITION.
 4. ALL NEW WATER MAIN PIPE AND FITTINGS SHALL BE DUCTILE IRON MEETING THE WVWA DESIGN AND CONSTRUCTION STANDARDS, LATEST EDITION.
 5. THE CONTRACTOR SHALL REPLACE ALL WATER METERS AND METER BOXES, AND RECONNECT PRIVATE LATERALS. SERVICE LATERALS SHALL BE "K" TYPE COPPER OR POLYETHYLENE MEETING THE WVWA DESIGN & CONSTRUCTION STANDARDS, LATEST EDITION.

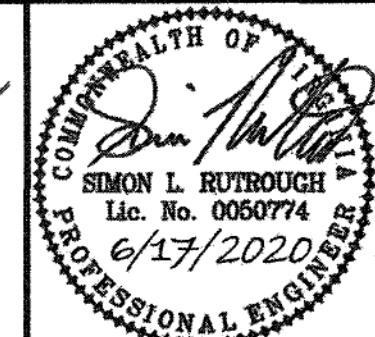

PROFILE: STA 50+00 TO STA 54+00 - Scale: H: 1"=20', V: 1"=5'

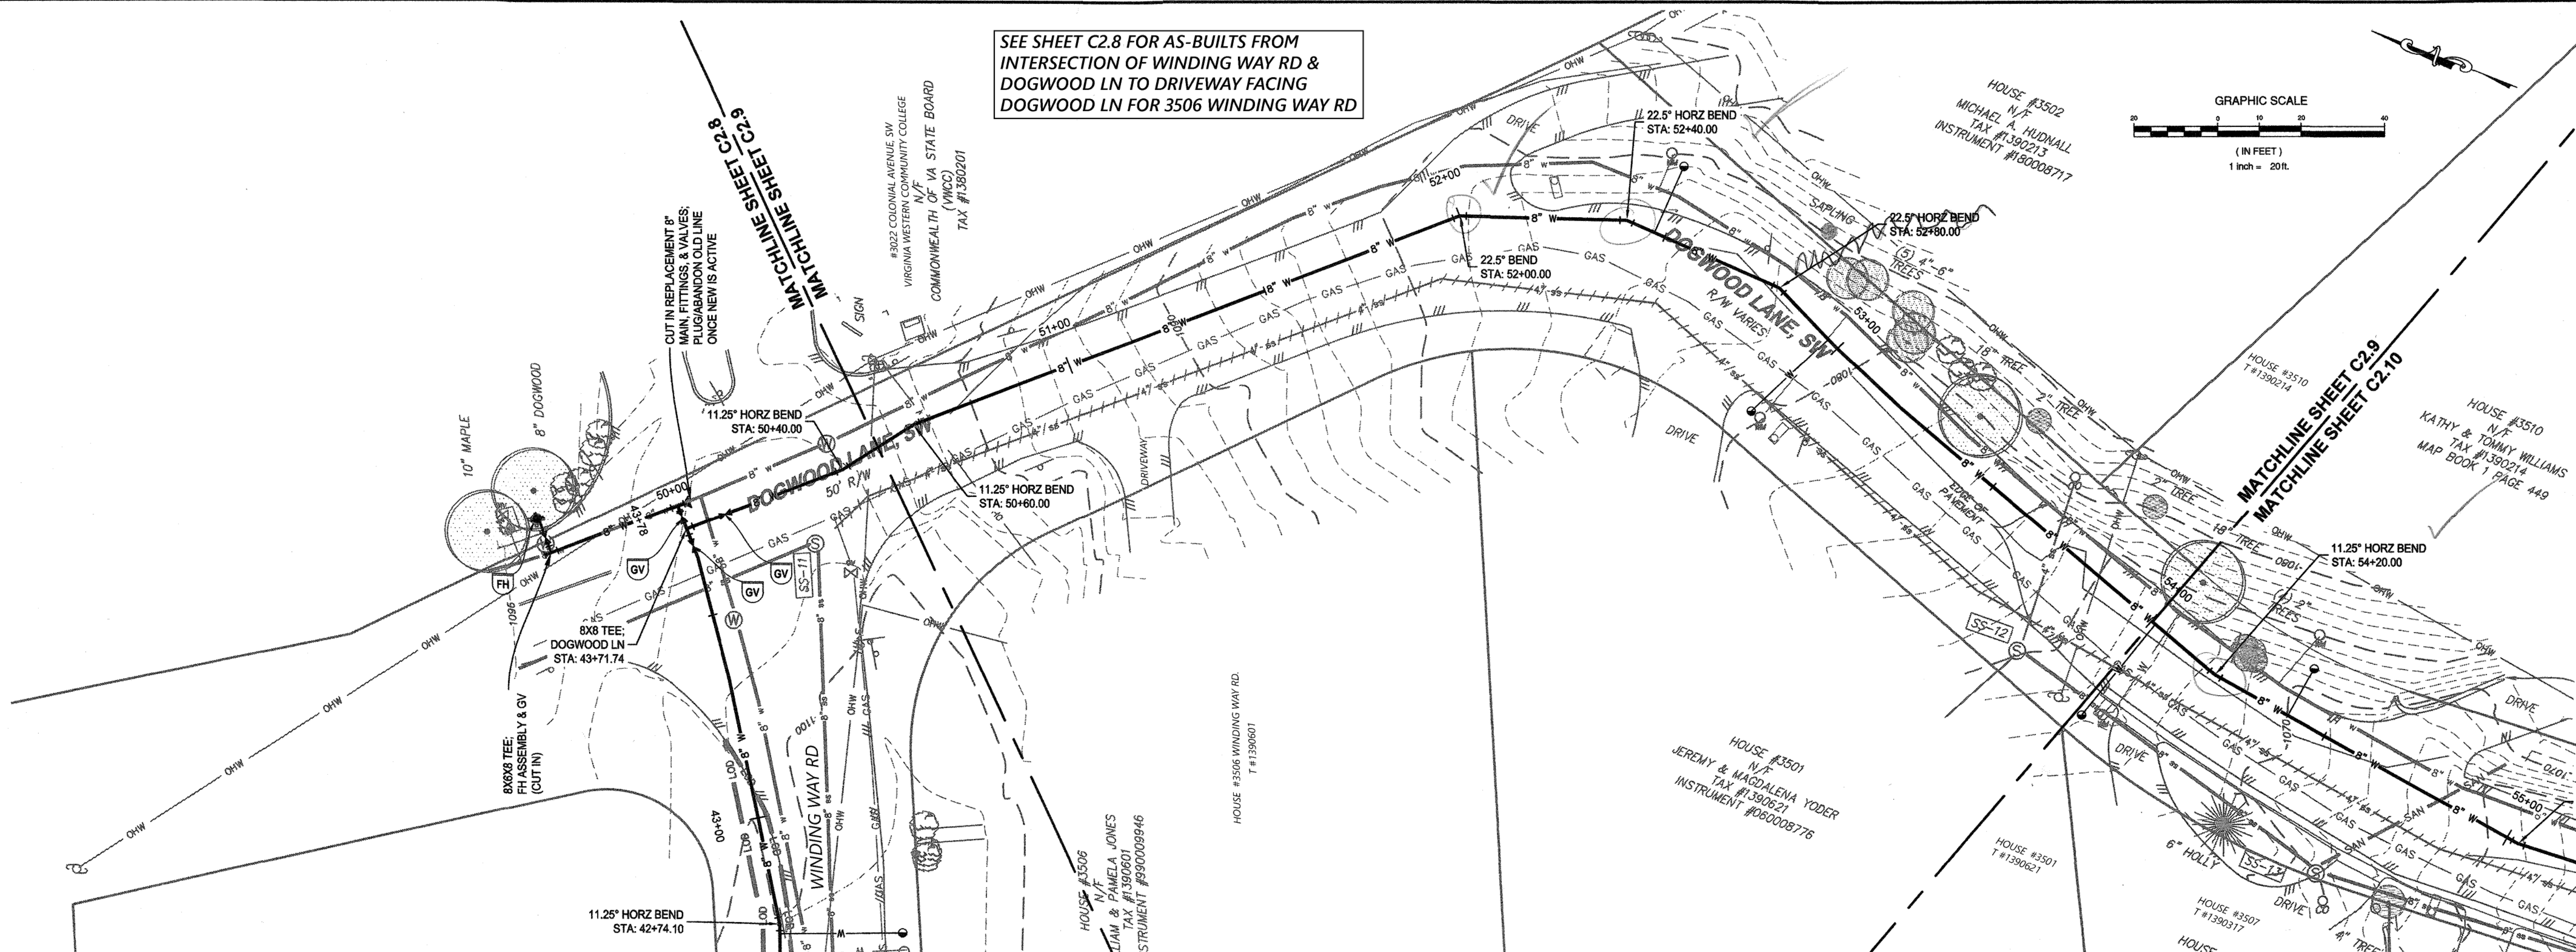

parker
DESIGN GROUP
PLANNERS • ENGINEERS • ARCHITECTS
2122 Carolina Ave. SW
Roanoke, VA 24014
(540) 387-1153

1915-B W. Cary Street
Richmond, VA 23220
(804) 358-2947
www.parkerdg.com

These documents are the property of Parker Design Group (PDG) and may not be reproduced or used without the express permission of PDG. Any reuse of these documents without authorization of PDG will be at the sole risk of the individual or entity utilizing said documents.

**WINDING WAY RD & DOGWOOD LN
WATER MAIN REPLACEMENT PLAN
WESTERN VIRGINIA WATER AUTHORITY**
CITY OF ROANOKE, VIRGINIA

REVISIONS

DESIGNED BY: CEP
DRAWN BY: CEP
CHECKED BY: SLR
SCALE: 1" = 20'
DATE: JUNE 17, 2020
PROJECT NUMBER: 20-0034

SHEET TITLE:
**PLAN AND PROFILE
- STA 50+00 TO STA 54+00**

C2.9