



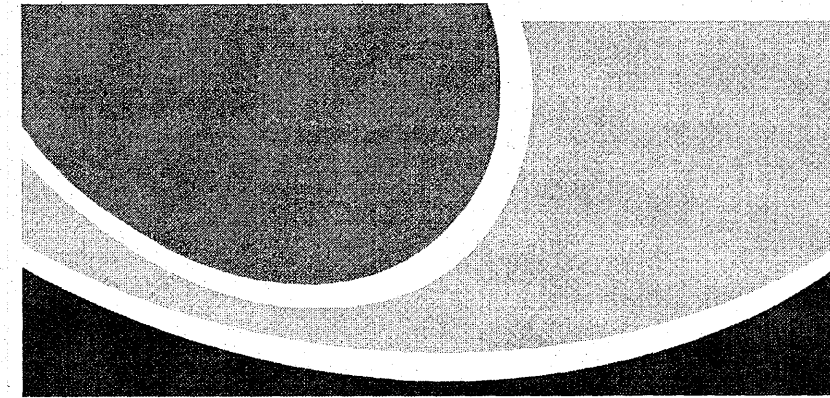

WESTERN VIRGINIA WATER AUTHORITY

WYNDALE AVENUE WATER MAIN REPLACEMENT

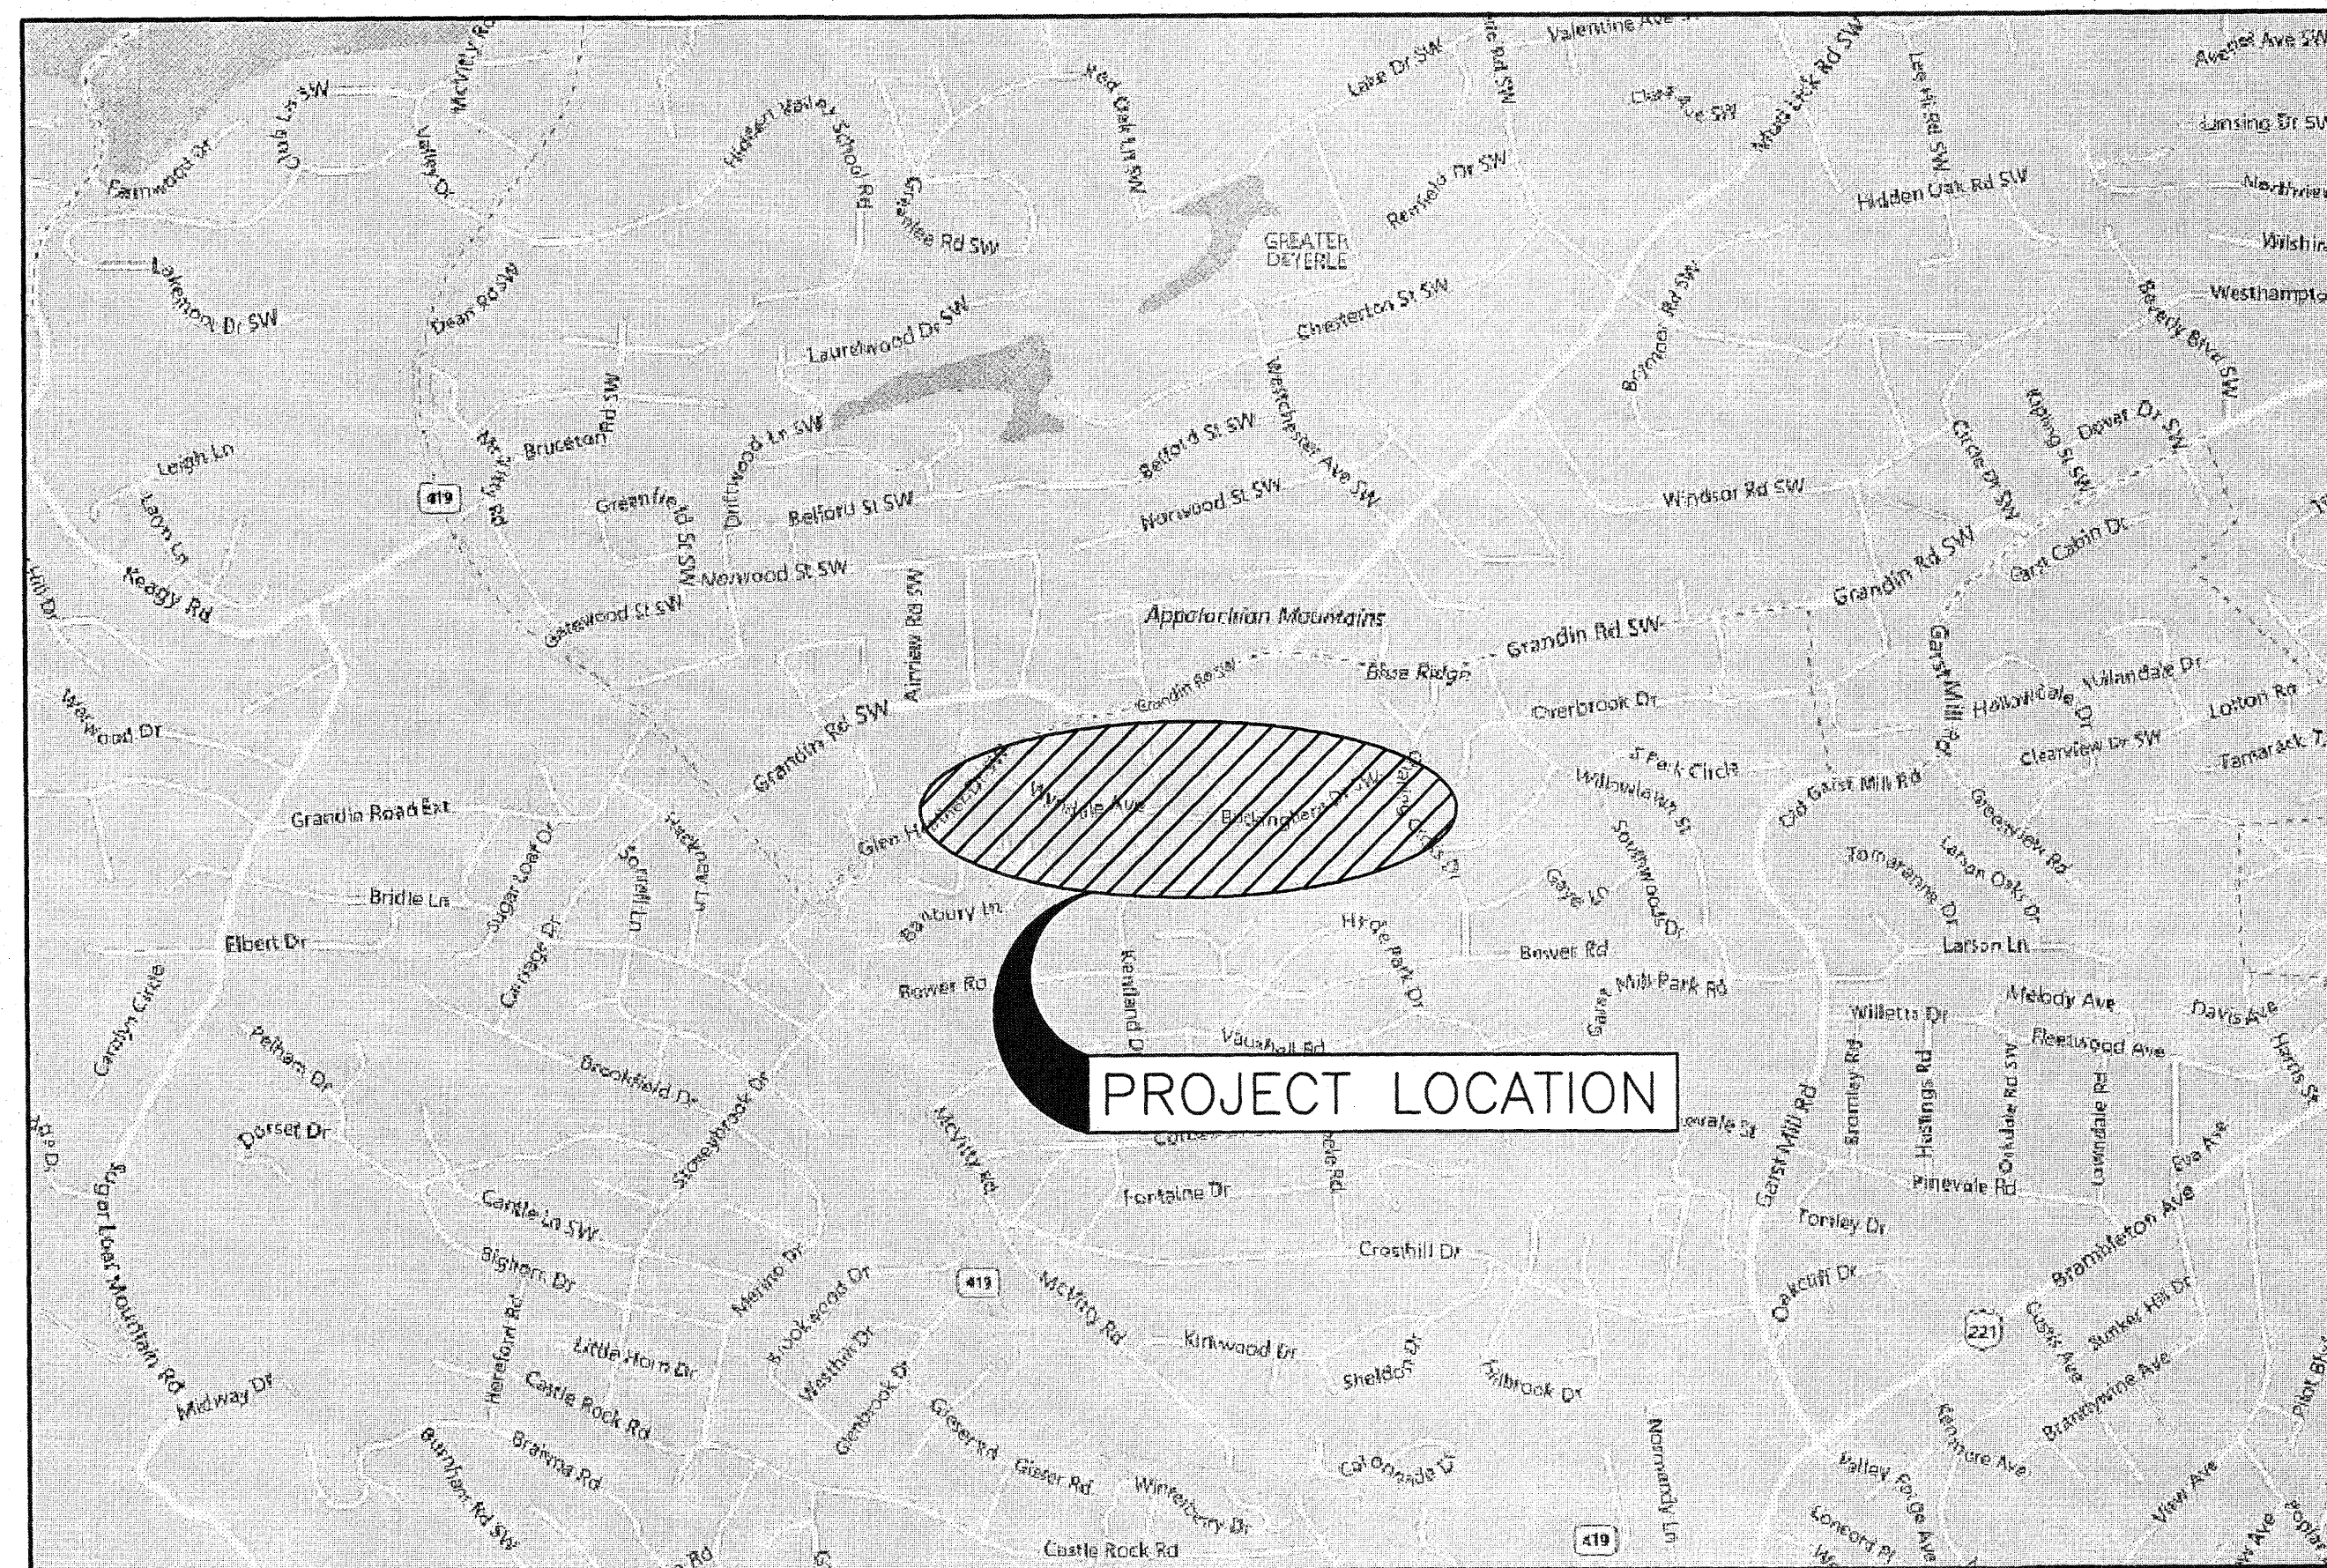


VICINITY MAP
SCALE: NOT TO SCALE

Project Manager: David Barnhart
WWA Inspector: Brian Whitenack
Contractor: Bowman + Griffin

GREELEY AND HANSEN
9020 STONY POINT PARKWAY, SUITE 475
RICHMOND, VIRGINIA 23235

 FEBRUARY 2019



DRAWING INDEX


SHEET NUMBER	DRAWING NUMBER	DESCRIPTION
1	---	COVER
2	G1	GENERAL NOTES, BENCHMARK TABLE, STRUCTURE TABLES, LEGEND, AND ABBREVIATIONS
3	G2	MAINTENANCE OF TRAFFIC NOTES AND DETAILS
4	G3	PAVEMENT RESTORATION PLANS
5	G4	EROSION AND SEDIMENT CONTROL NOTES
6	C1	KEY PLAN AND STATION AND CURVE REPORT
7	C2	PLAN AND PROFILE
8	C3	PLAN AND PROFILE
9	C4	PLAN AND PROFILE
10	C5	PLAN AND PROFILE
11	C6	PLAN AND PROFILE
12	C7	PLAN AND PROFILE
13	C8	DETAILS

Materials - Water Main - 8", 6", 4" CL350 U.S. Pipe DIP

(Services 1" & 2" poly flex (blue poly plastic) main

Hydriants - A.D. See plans for year + TAG Numbers

Valves - 12"-AFC 36 Turns off to Right
8"-AFC 24 Turns off to Right
6"-AFC 18 Turns off to Right

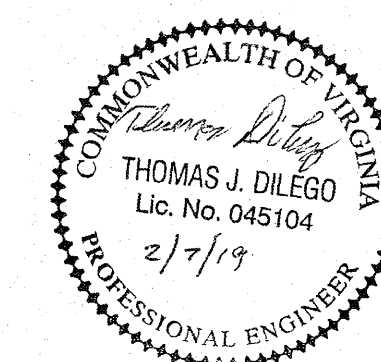

Earl Smith
APPROVED FOR CONSTRUCTION

As-built 1/23/2020 WWA - Brian Whitenack Contractor - Bowman + Griffin