



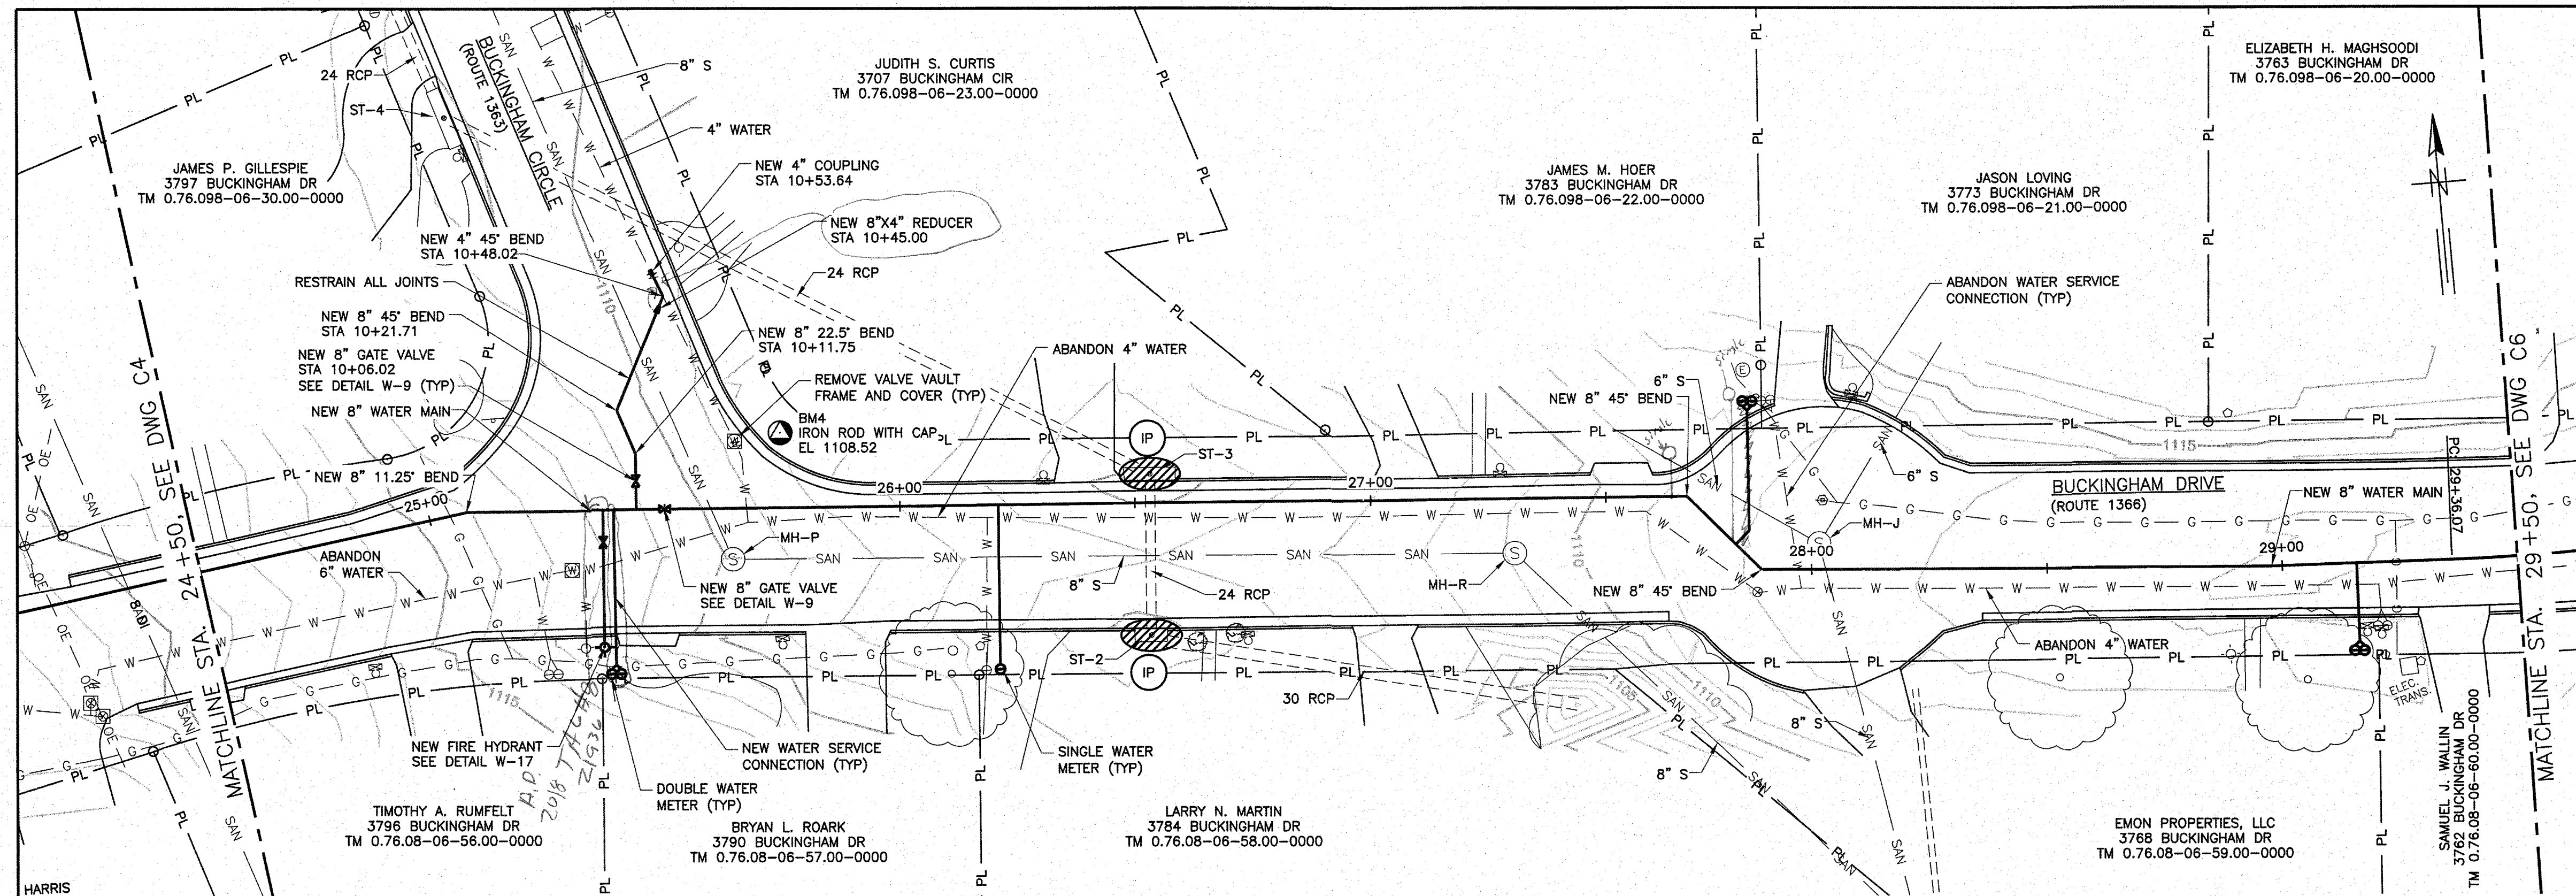

PLAN
SCALE: 1" = 20'

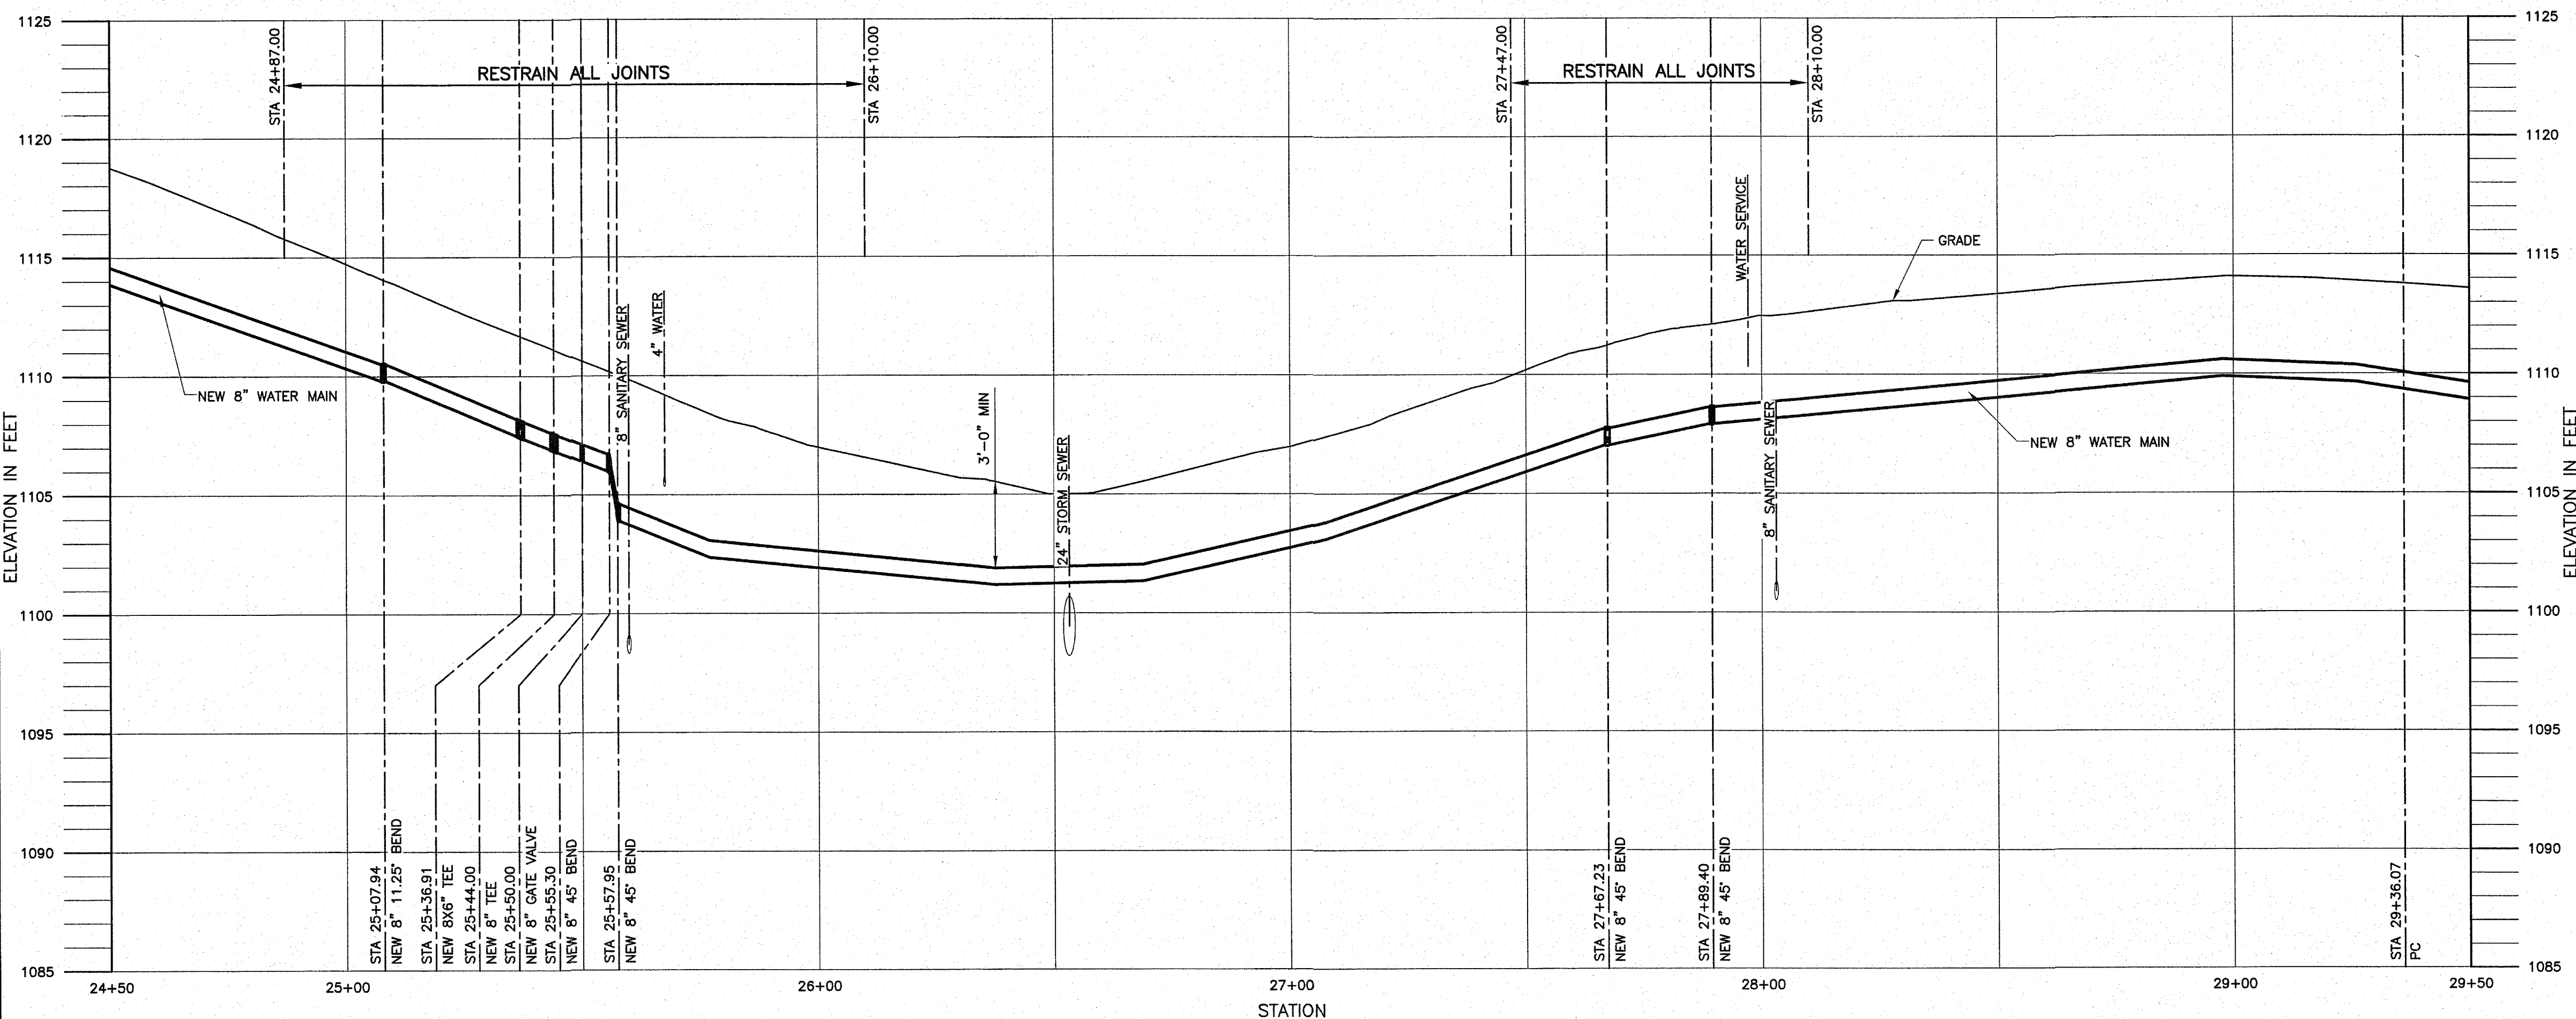


PROFILE
SCALE: HORIZONTAL 1" = 20'
VERTICAL 1" = 4'

- NOTES:
1. THE CONTRACTOR SHALL TEST PIT 200 FEET IN ADVANCE FOR ALL UTILITY CROSSINGS OR POTENTIAL CONFLICTS. ALL CONFLICTS SHALL BE REPORTABLE TO THE OWNER.
 2. ALL REFERENCED DETAILS REFER TO WESTERN VIRGINIA WATER AUTHORITY'S STANDARD DETAILS.


GREELY AND HANSEN
9020 STONY POINT PARKWAY, SUITE 475
RICHMOND, VIRGINIA 23235

DESIGNED TJD
DRAWN DRH
CHECKED RJC

APPROVED

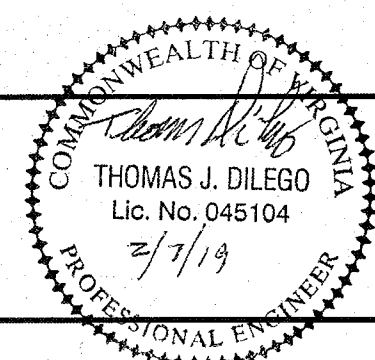

NO.	DATE	APPD	REVISION

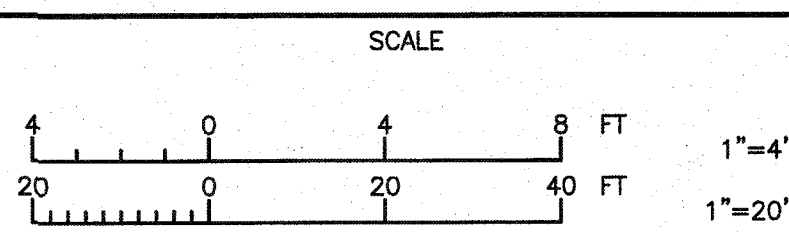

WESTERN VIRGINIA WATER AUTHORITY

WYNDALE AVENUE WATER MAIN REPLACEMENT

CIVIL

PLAN AND PROFILE

PROJECT NO.: 05170.01

DWG **C5**

SHEET 10 OF 13

DATE FEBRUARY 2019 REV 0

S:\WVA\WYNDALE AVE WATER MAIN\21 CAD\21.05 WORKING DWGS\0517001-0005 2019/02/07 11:21 AM HEBBE, DAVID