
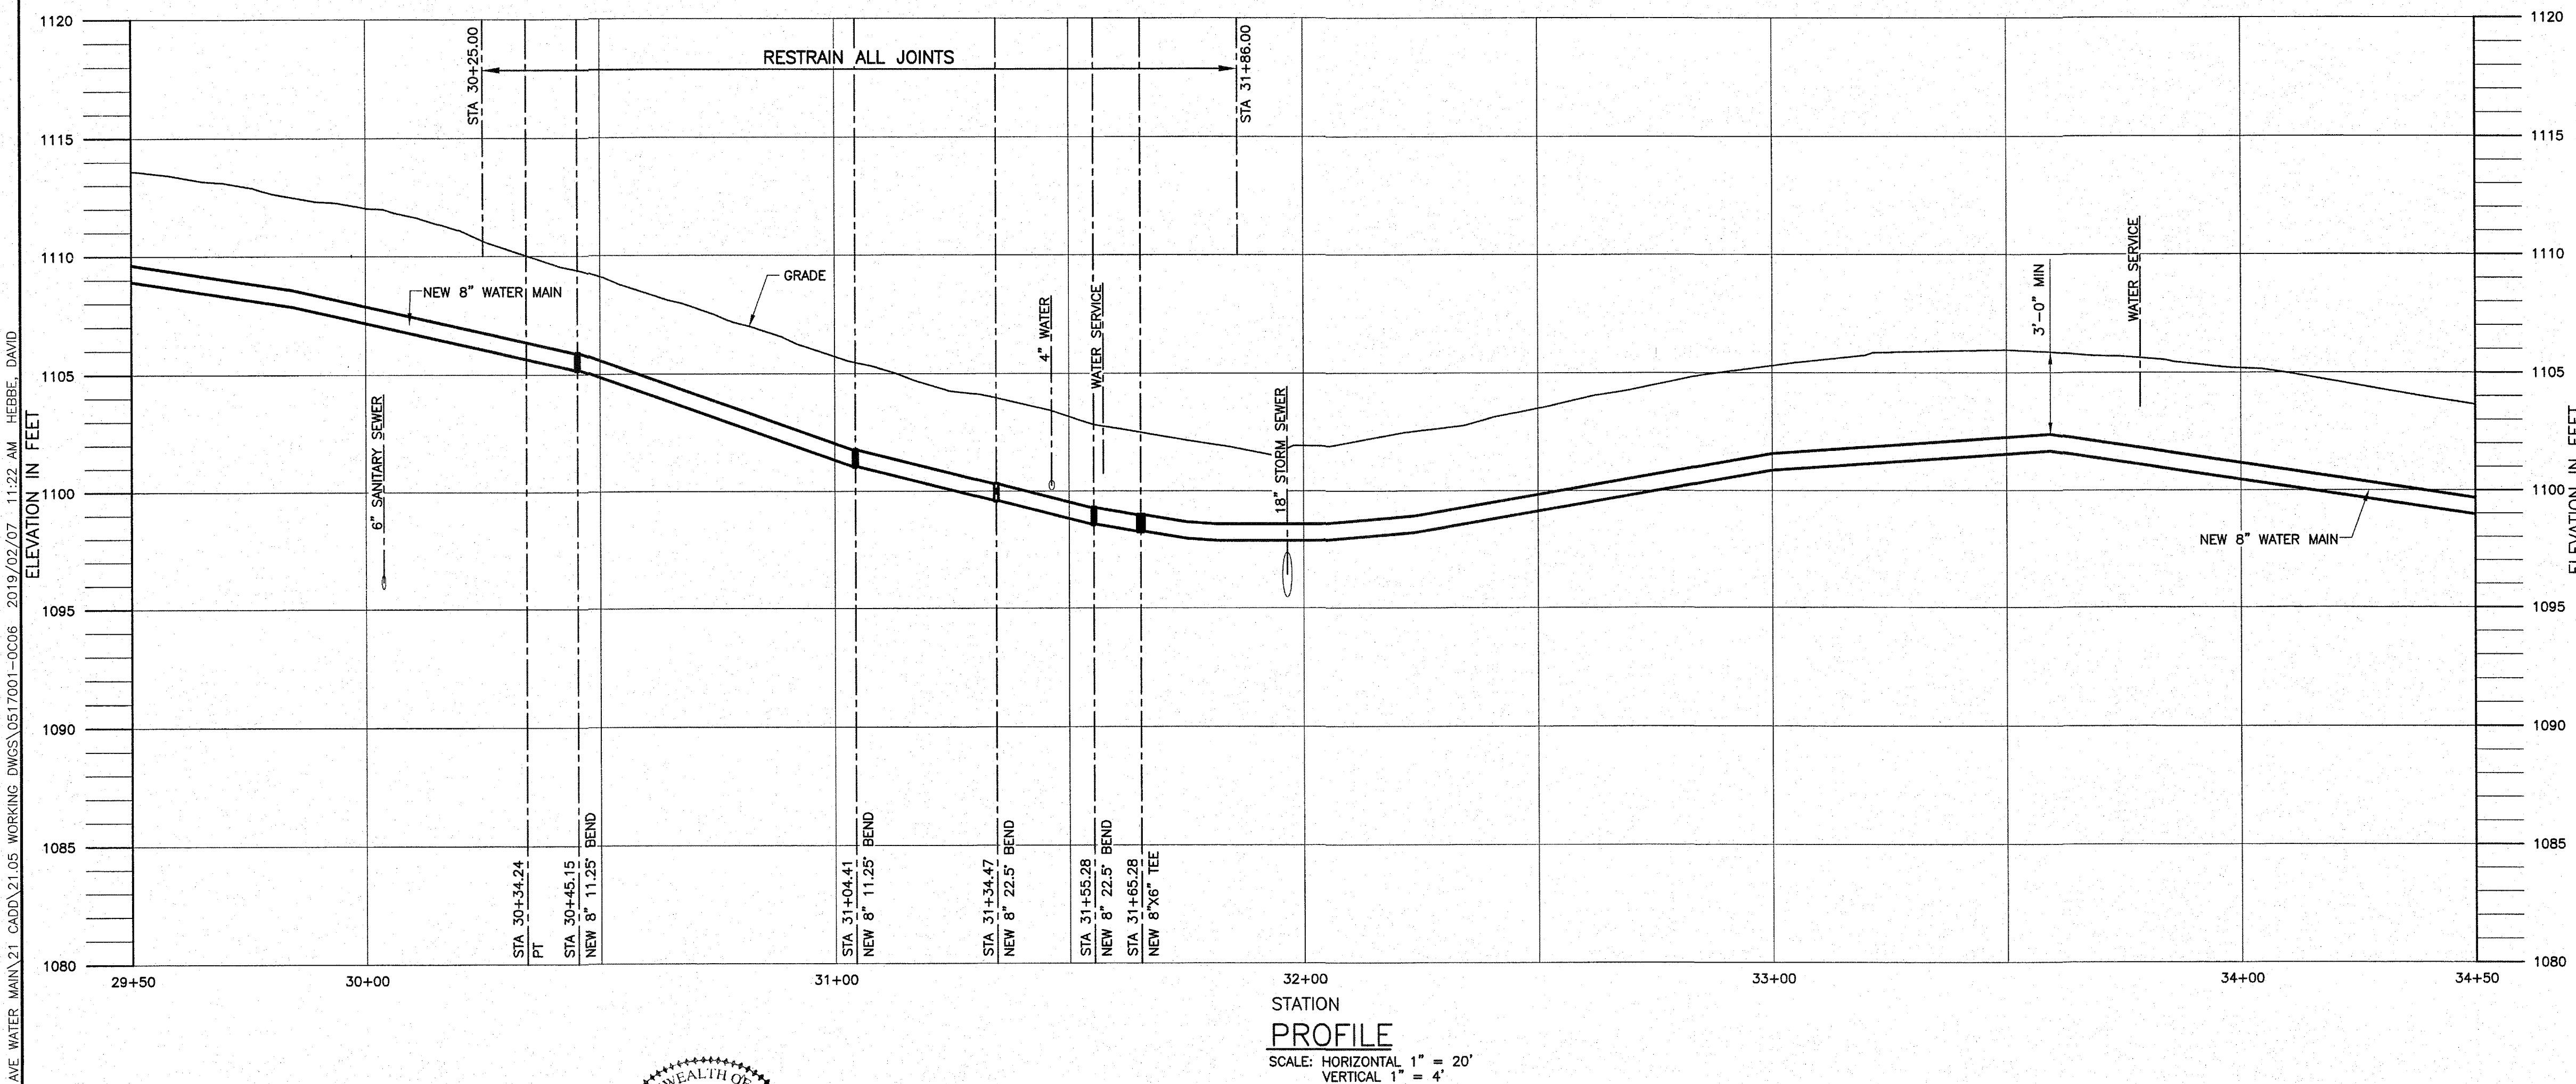


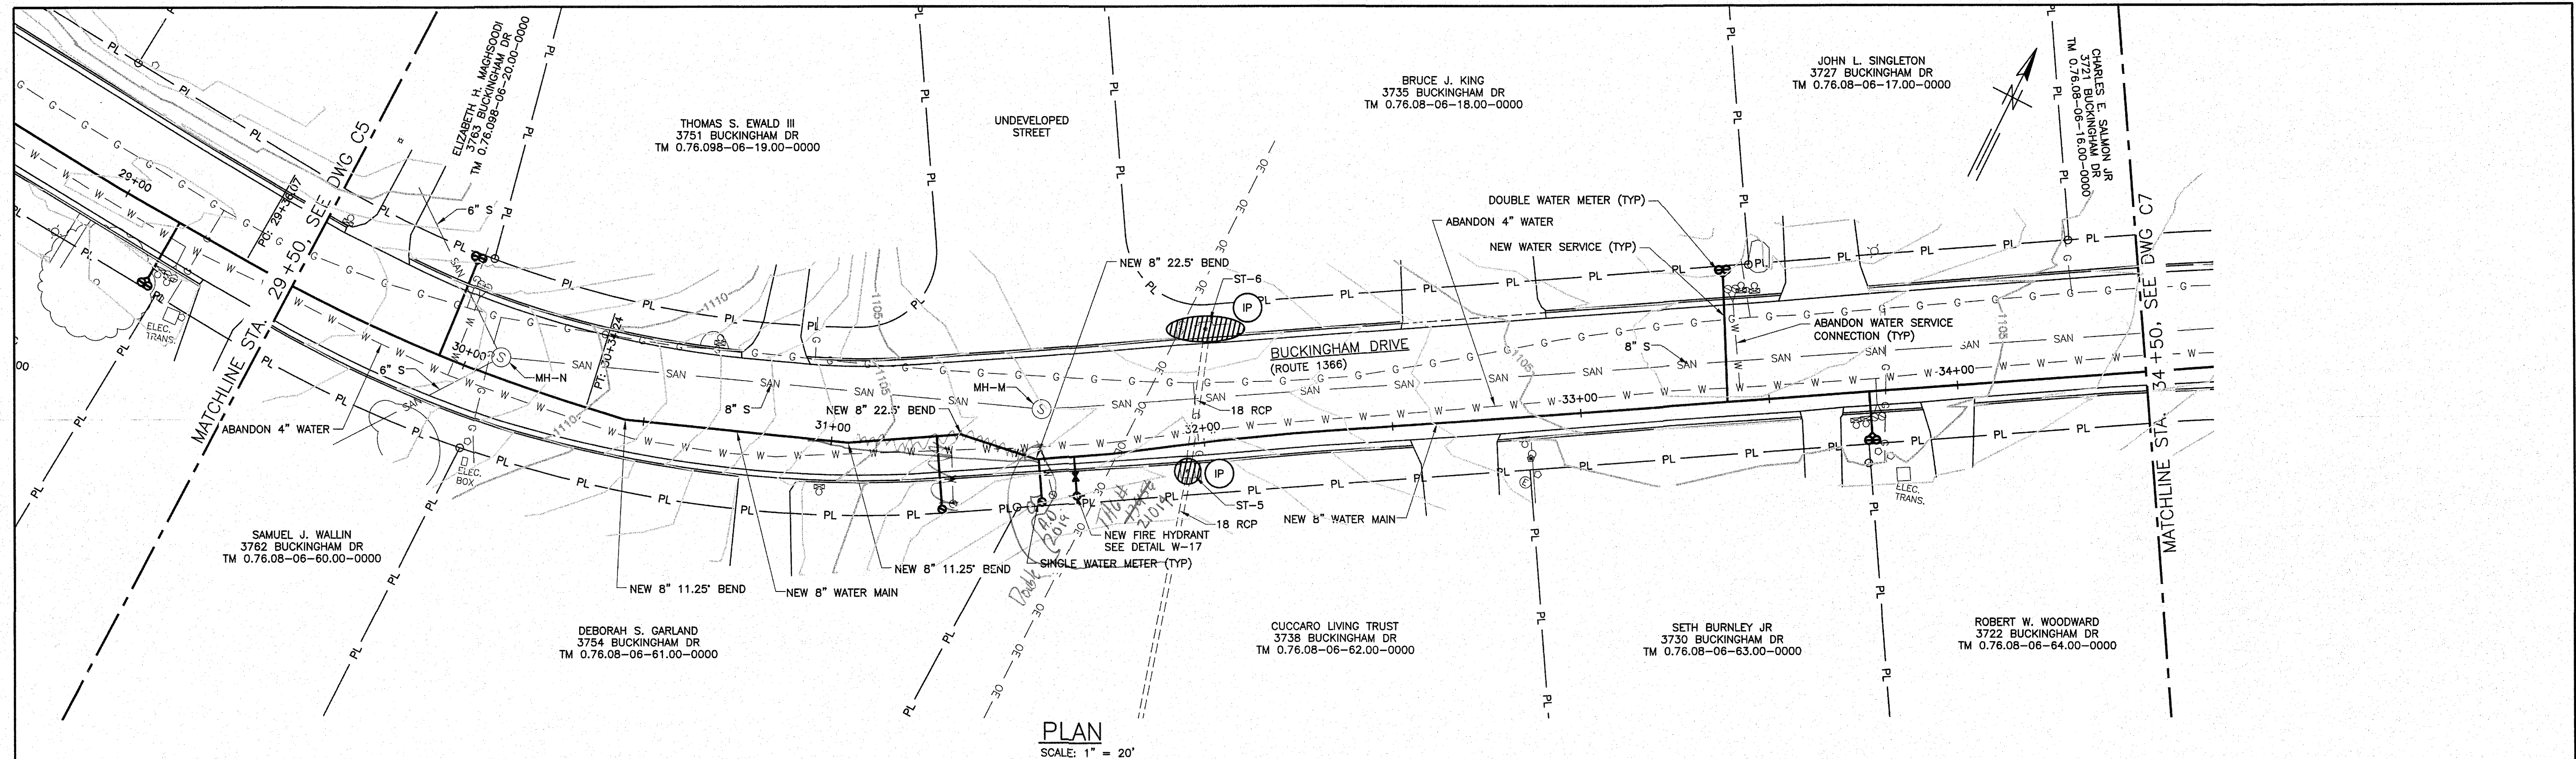

- NOTES:**
1. THE CONTRACTOR SHALL TEST PIT 200 FEET IN ADVANCE FOR ALL UTILITY CROSSINGS OR POTENTIAL CONFLICTS. ALL CONFLICTS SHALL BE REPORTABLE TO THE OWNER.
 2. ALL REFERENCED DETAILS REFER TO WESTERN VIRGINIA WATER AUTHORITY'S STANDARD DETAILS.

 GREALEY AND HANSEN 9020 STONY POINT PARKWAY, SUITE 475 RICHMOND, VIRGINIA 23235	DESIGNED TJD	APPROVED		NO.	DATE	APPD	REVISION	 SCALE 4 0 4 8 FT 20 0 20 40 FT 1"=4' 1"=20'	WESTERN VIRGINIA WATER AUTHORITY WYNDALE AVENUE WATER MAIN REPLACEMENT	CIVIL PLAN AND PROFILE	PROJECT NO.: 05170.01
	DRAWN DRH CHECKED RJC	THOMAS J. DILEGO Lic. No. 045104 2/7/19 PROFESSIONAL ENGINEER									DWG C6 SHEET 11 OF 13 DATE FEBRUARY 2019 REV 0