




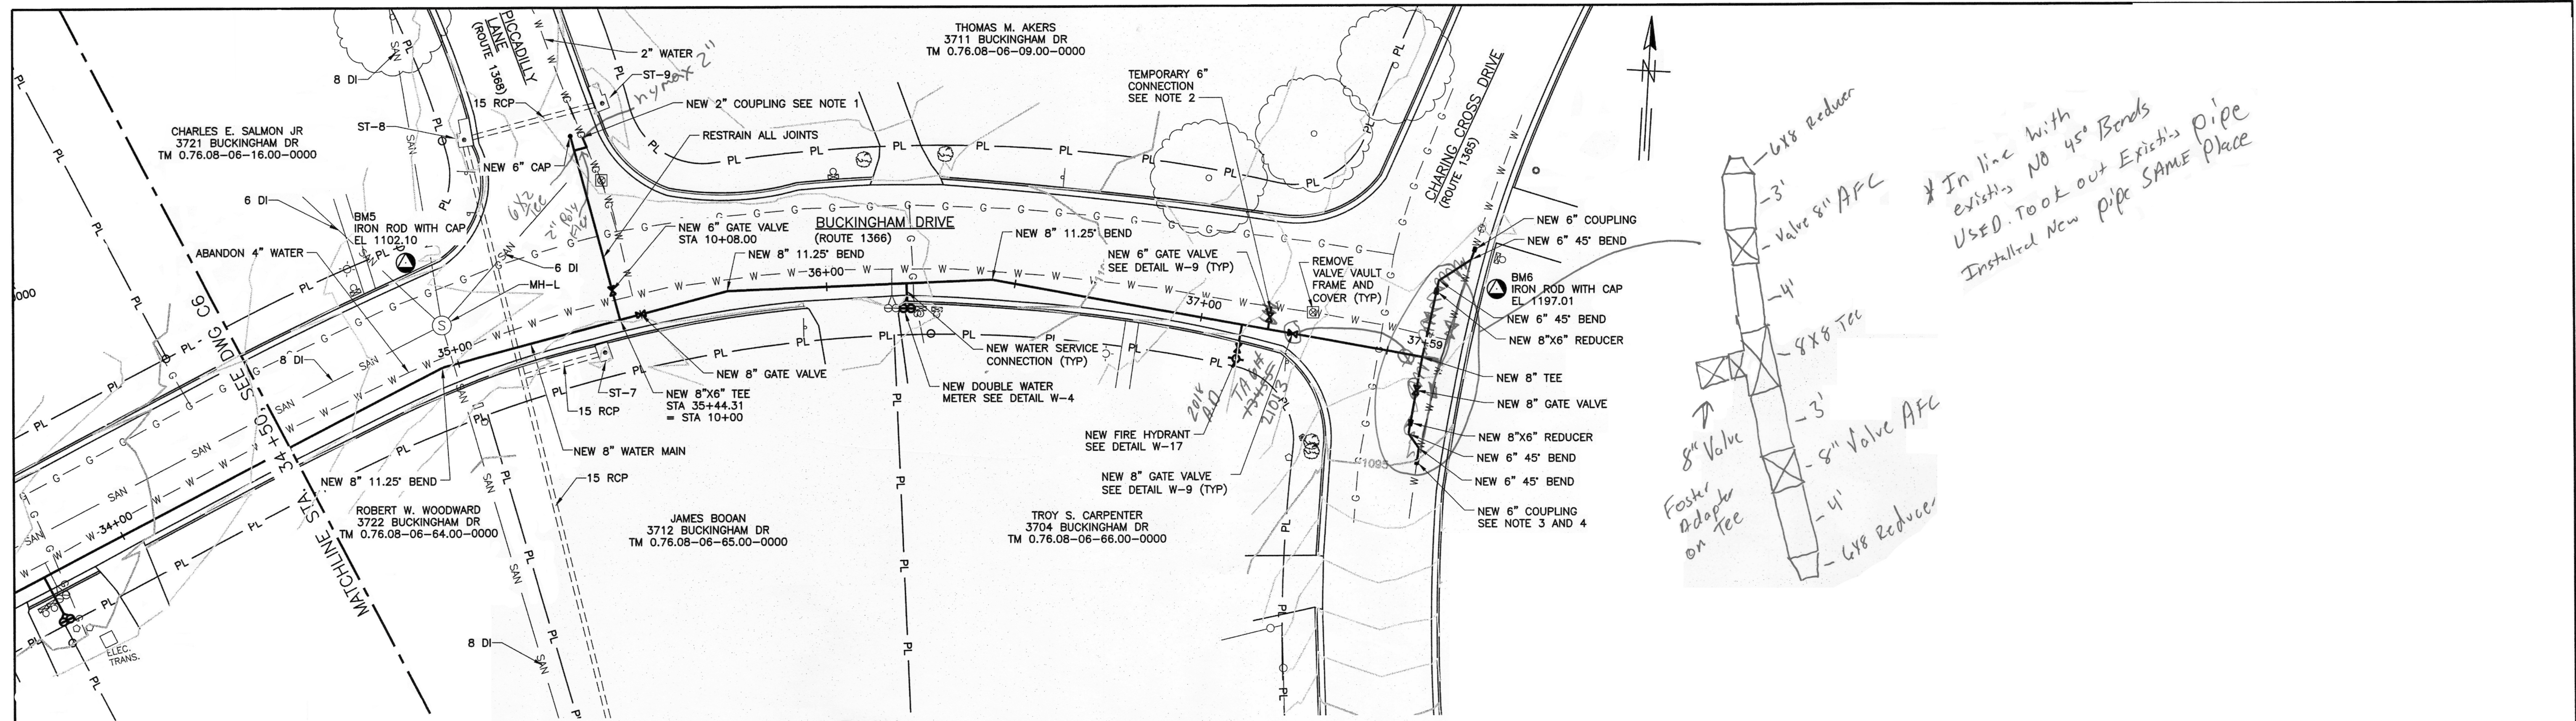

PLAN
SCALE: 1" = 20'

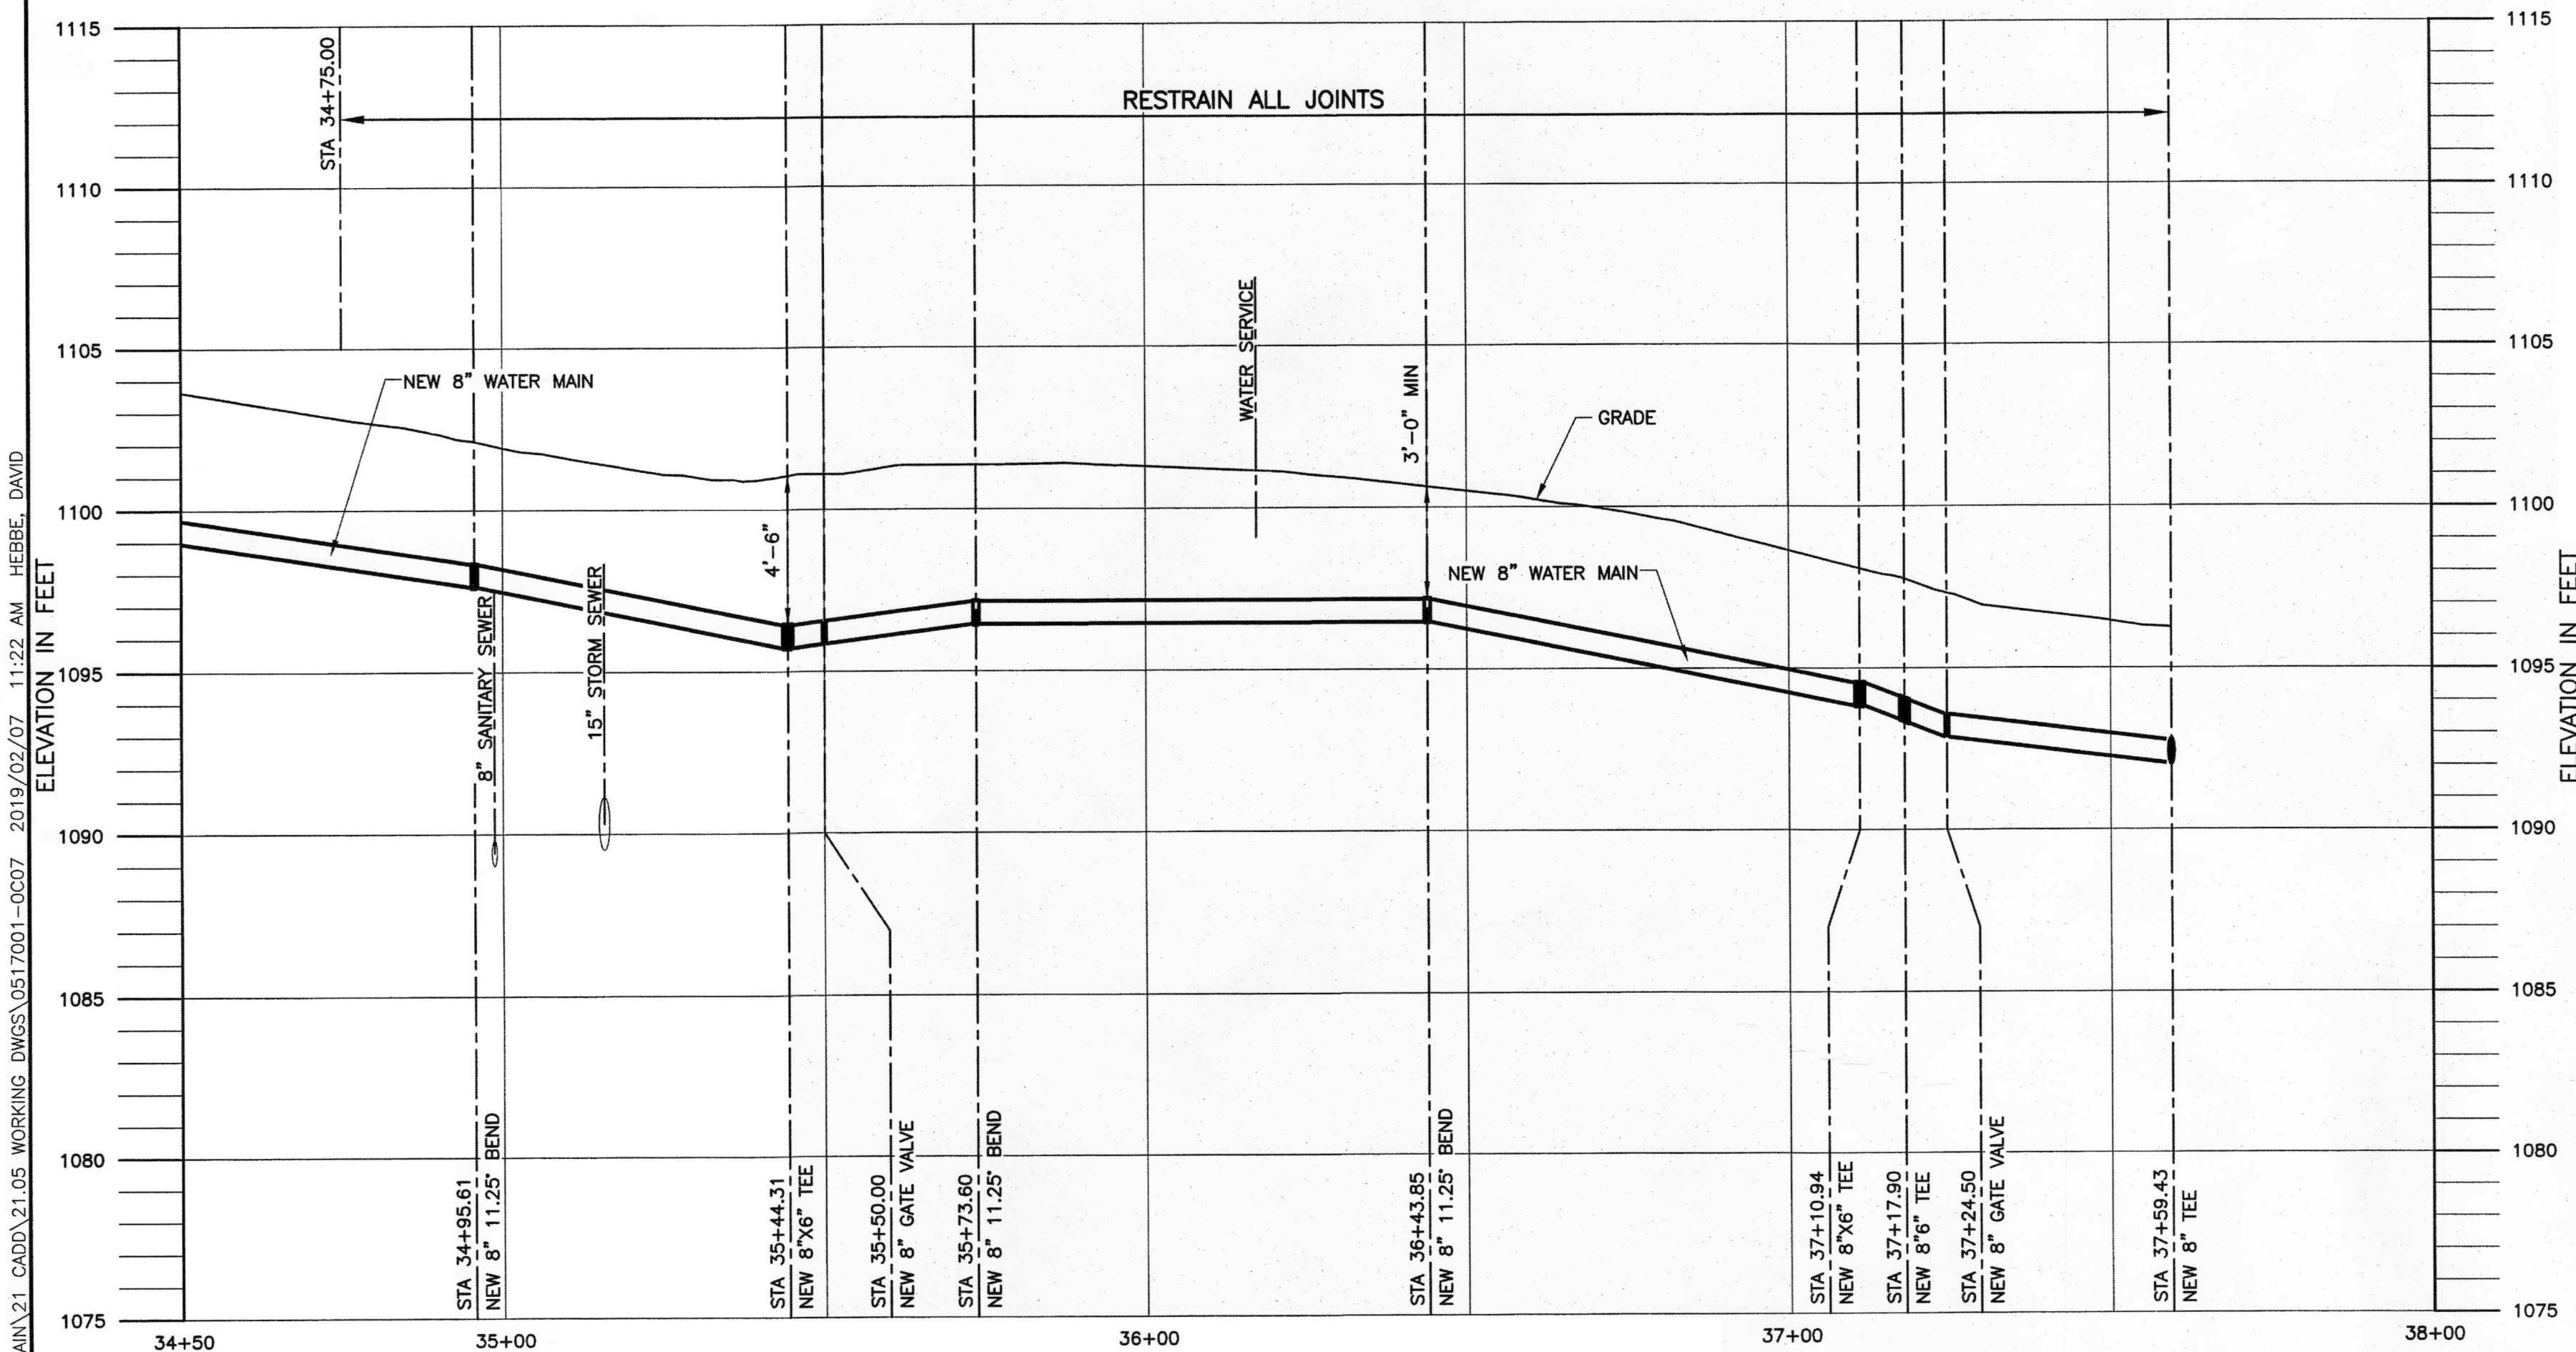

PROFILE
SCALE: HORIZONTAL 1" = 20'
VERTICAL 1" = 4'

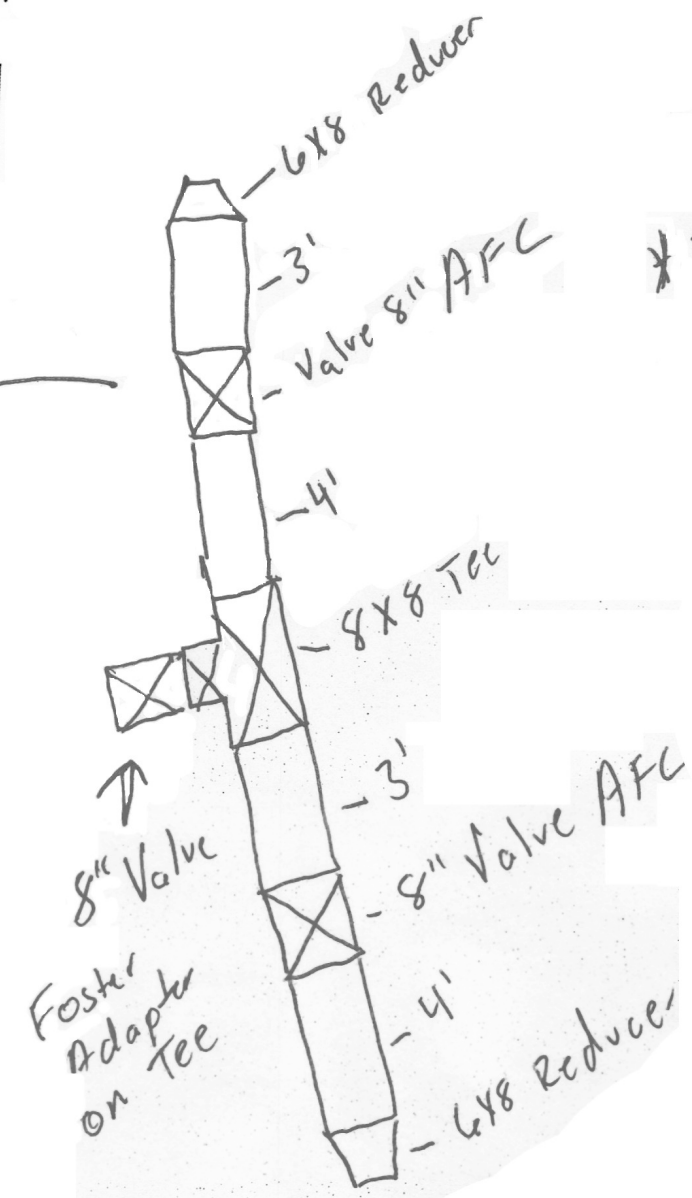

* In line with
existing NO 45° Bonds
USED. Took out Existing pipe
Installed New pipe SAME place

- NOTES:
1. CONTRACTOR SHALL TEST PIT TO CONFIRM SIZE AND MATERIAL OF THE EXISTING WATER LINE. THE CONTRACTOR SHALL TAP THE NEW 6" WATER LINE WITH A NEW PIPE AND CONNECT TO THE EXISTING PIPE MATCHING SIZE AND MATERIAL, IF THE EXISTING PIPE IS NOT 2" THE CONTRACTOR SHALL NOTIFY THE OWNER.
 2. CONTRACTOR SHALL PROVIDE A TEMPORARY 6" CONNECTION TO THE NEW 8" WATER MAIN.
 3. AFTER ALL WATER SERVICES HAVE BEEN CONNECTED TO THE NEW WATER MAIN THE CONTRACTOR SHALL CONNECT THE NEW WATER MAIN IN CHARING CROSS DRIVE TO THE EXISTING 6" WATER MAIN. THE CONTRACTOR SHALL DISCONNECT THE TEMPORARY 6" WATER CONNECTION IN BUCKINGHAM DRIVE, REMOVE VALVE, AND CAP THE 8"x6" TEE.
 4. RESTRAIN ALL JOINTS ALONG CHARING CROSS DRIVE.
 5. THE CONTRACTOR SHALL TEST PIT 200 FEET IN ADVANCE FOR ALL UTILITY CROSSINGS OR POTENTIAL CONFLICTS. ALL CONFLICTS SHALL BE REPORTABLE TO THE OWNER.
 6. ALL REFERENCED DETAILS REFER TO WESTERN VIRGINIA WATER AUTHORITY'S STANDARD DETAILS.

S:\WWW\WYNDALE AVE WATER MAIN\21 CADD\21.05 WORKING DWGS\0517001-0007 2019/02/07 11:22 AM HEBBE, DAVID


GREELEY AND HANSEN
9020 STONY POINT PARKWAY, SUITE 475
RICHMOND, VIRGINIA 23235

DESIGNED TJD
DRAWN DRH
CHECKED RJC

APPROVED

COMMONWEALTH OF VIRGINIA
THOMAS J. DILEGO
Lic. No. 045104
2/7/19
PROFESSIONAL ENGINEER

NO.	DATE	APPD	REVISION

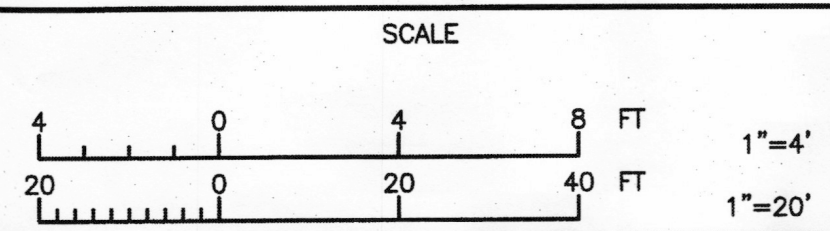

WESTERN VIRGINIA WATER AUTHORITY

WYNDALE AVENUE WATER MAIN REPLACEMENT

CIVIL

PLAN AND PROFILE

PROJECT NO.: 05170.01
DWG C7
SHEET 12 OF 13
DATE FEBRUARY 2019 REV 0