


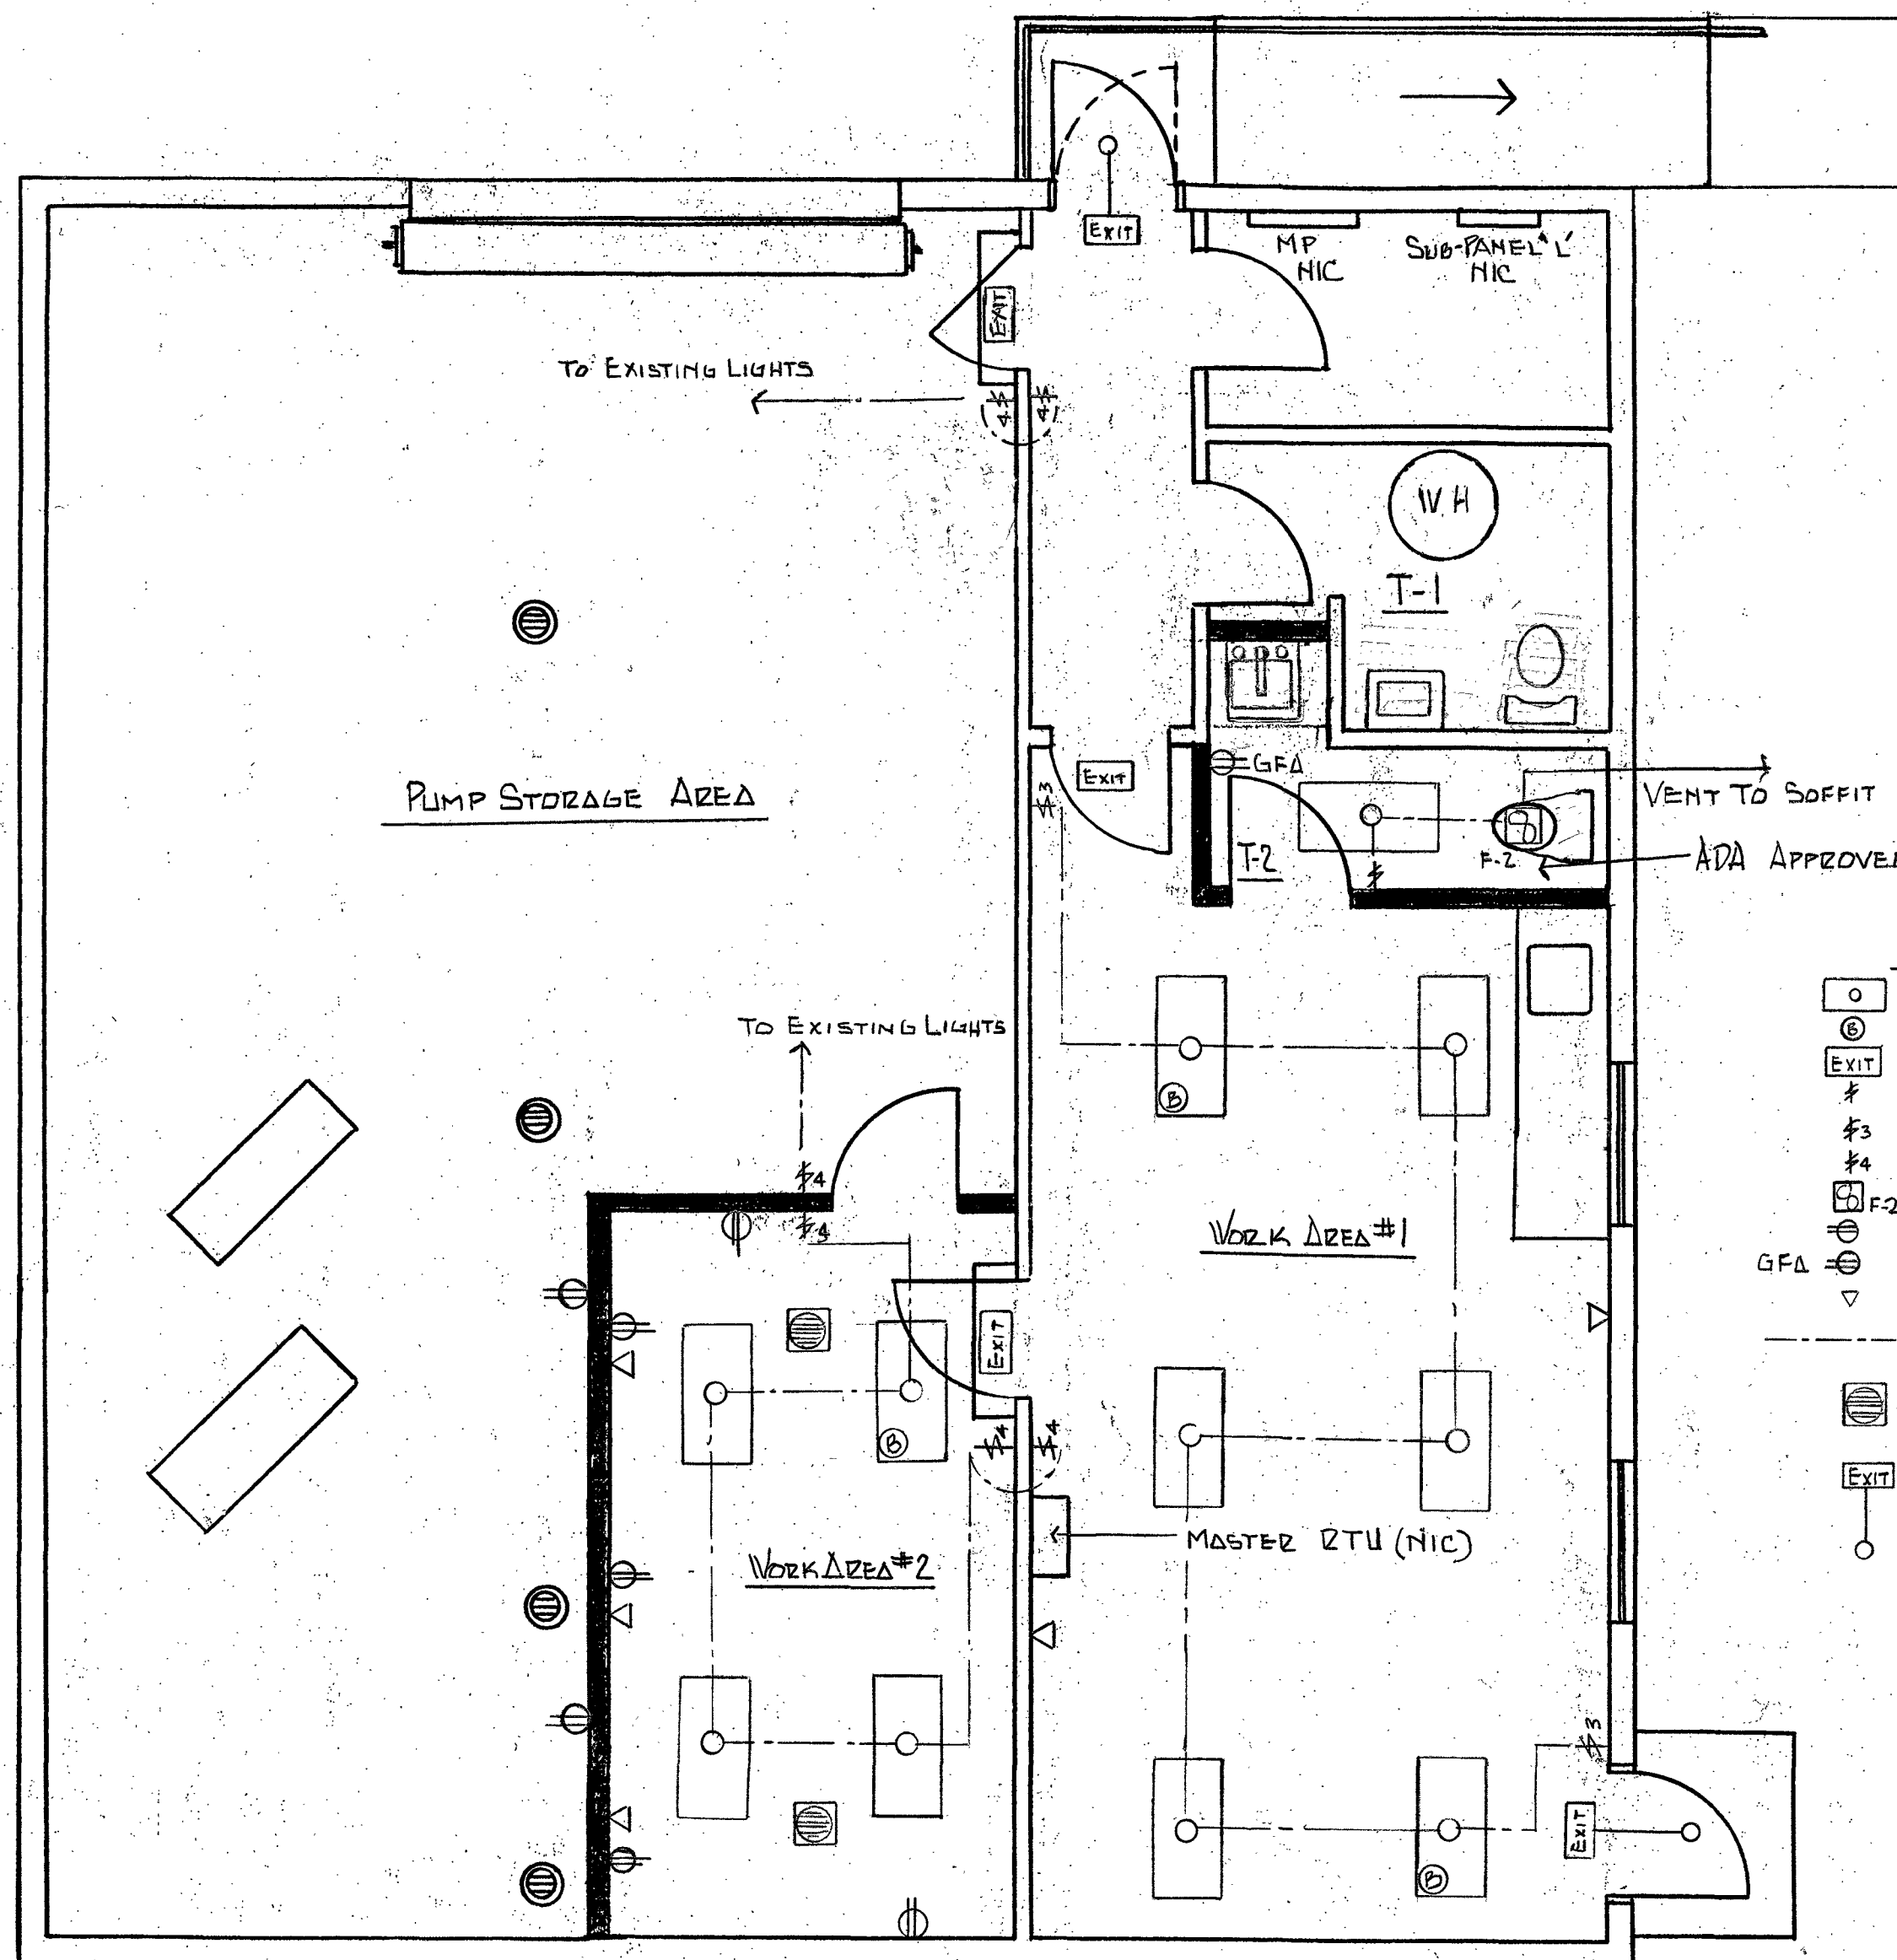

- ELECTRICAL SYMBOLS**
- CEILING OUTLET WITH FLUORESCENT FIXTURE
 - ⊙ EMERGENCY BATTERY PACK
 - EXIT EXIT/EMERGENCY LIGHT WITH BATTERY BACKUP
 - # LIGHT SWITCH
 - #3 3-WAY LIGHT SWITCH
 - #4 4-WAY LIGHT SWITCH
 - F-2 SD CFM BATH FAN
 - ⊕ DUPLEX OUTLET 125V, 20A, 1Ø, 3W
 - GFA ⊕ DUPLEX GROUND FAULT OUTLET 125V, 20A, 1Ø, 3W
 - ▽ DATA/VOICE DROP, WALL BOX WITH 1" CONDUIT TO ACCESSIBLE CEILING
 - LIGHTING/FAN CONTROL WIRE
 - ⊕ 6" HVAC CEILING DIFFUSER TO EXISTING DUCTWORK
 - EXIT EXIT/EMERGENCY LIGHT WITH BATTERY BACKUP AND REMOTE HEAD FOR EXTERIOR LIGHT

RENOVATION OF GREENFIELD
CHLORINATION FACILITY
VVVA-REN-2015-CF SCALE: 1/4" = 1'-0"
DATE: MAY 1, 2015 REVISED: JULY 30, 2015

PROJECT: BOTETOURT OPERATIONS CENTER RENOVATION

ELECTRICAL PLAN
SC: 1/4" = 1'-0"