



*Note B : Universal Flow Monitor Model SN-FSE8GV-4-32VI.0
-1NR-5U Flow Switch.*




* ITEMS SHALL BE FURNISHED
BY THE CITY




NOTES:

1. THE CONTRACTOR SHALL EXAMINE THE SITE TO BECOME FAMILIARIZED WITH THE PREMISES AND CONDITIONS UNDER WHICH HE WILL BE SUBJECT TO THE PROJECT. HAVE THE
2. STUP UP LOCATION OF CONDUITS TO BE VERIFIED IN THE FIELD.
3. PROVIDE OVERSIZE MTR. TERMINAL BOX TO ACCOMMODATE CABLES.
4. ROUTE CMDS. UNDER EEL TEST.C

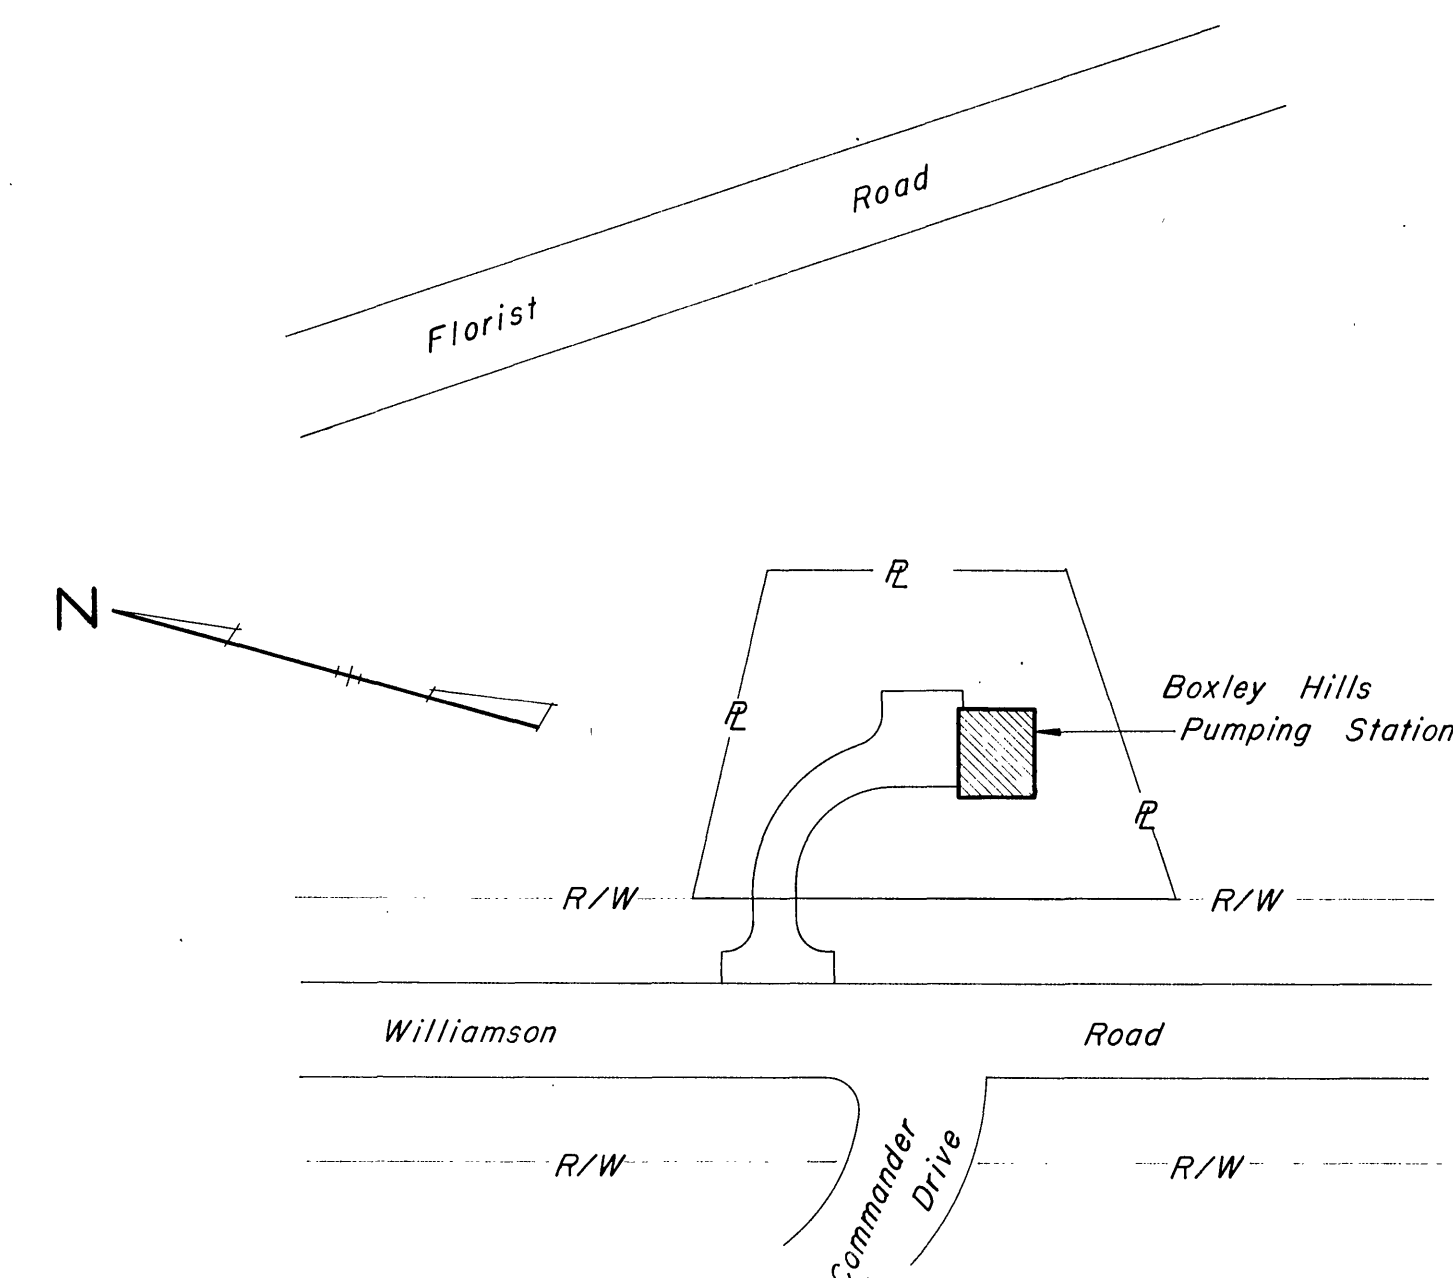

LOCATION PLAN
SCALE: 1" = 60'

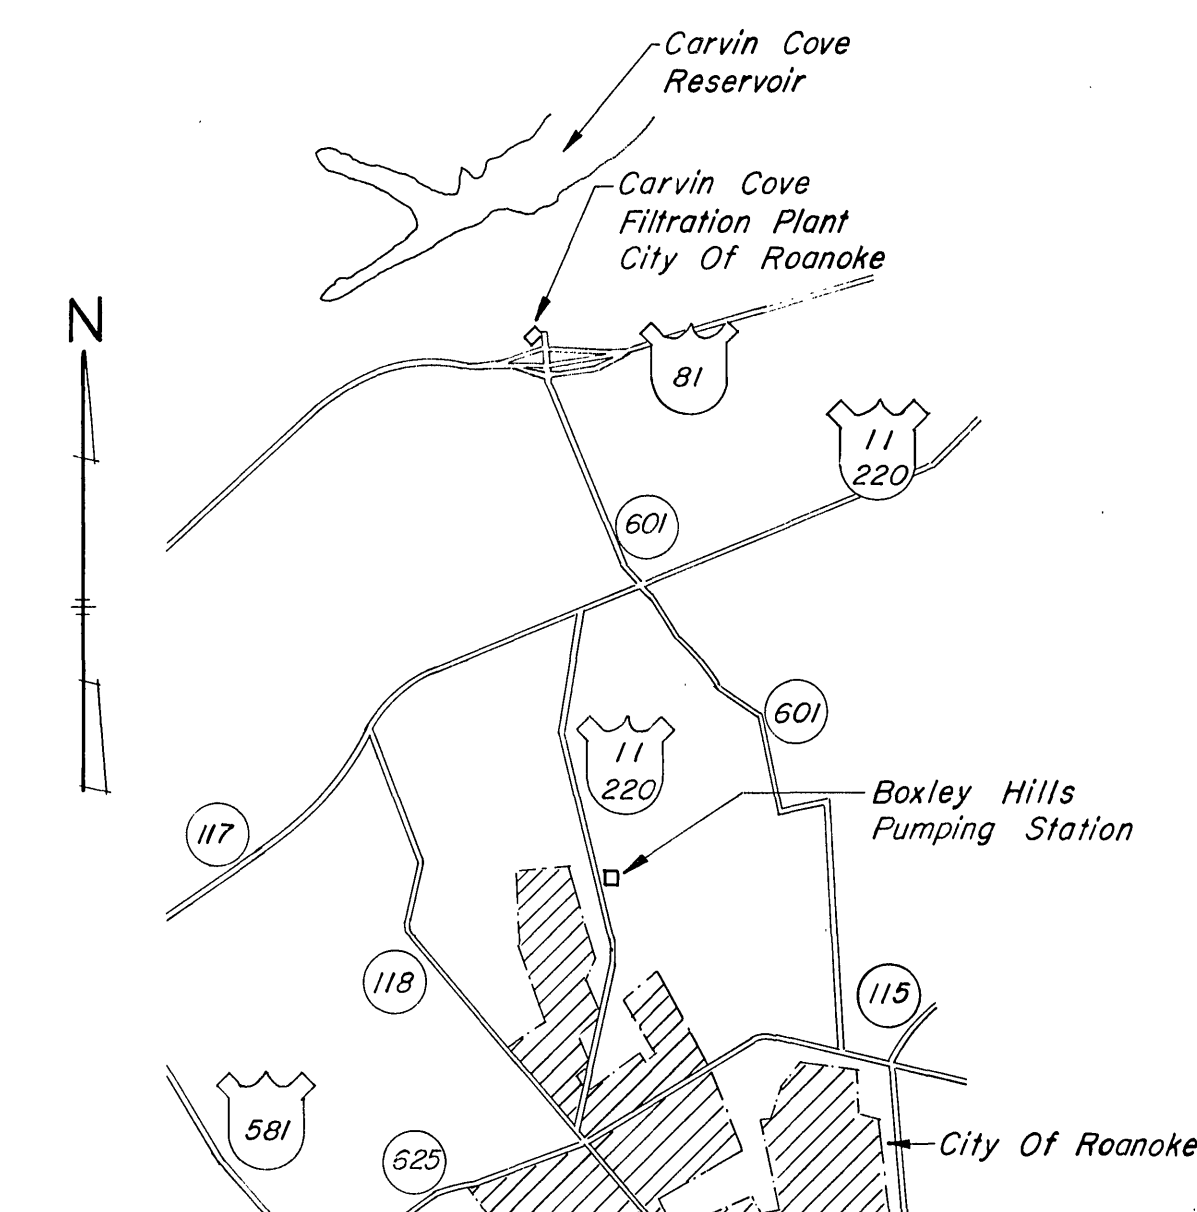

SITE PLAN
SCALE: 1/4"=1000'

ALVORD, BURDICK & HOWSON
ENGINEERS
1984
CHICAGO