



PIPING INDICATIONS


TYPICAL PIPING	TEE OR ELBOW FROM TOP OF MAIN	
	TOP OF MAIN	
	BOTTOM OF MAIN	
	SIDE OF MAIN	
	IN PLAN	

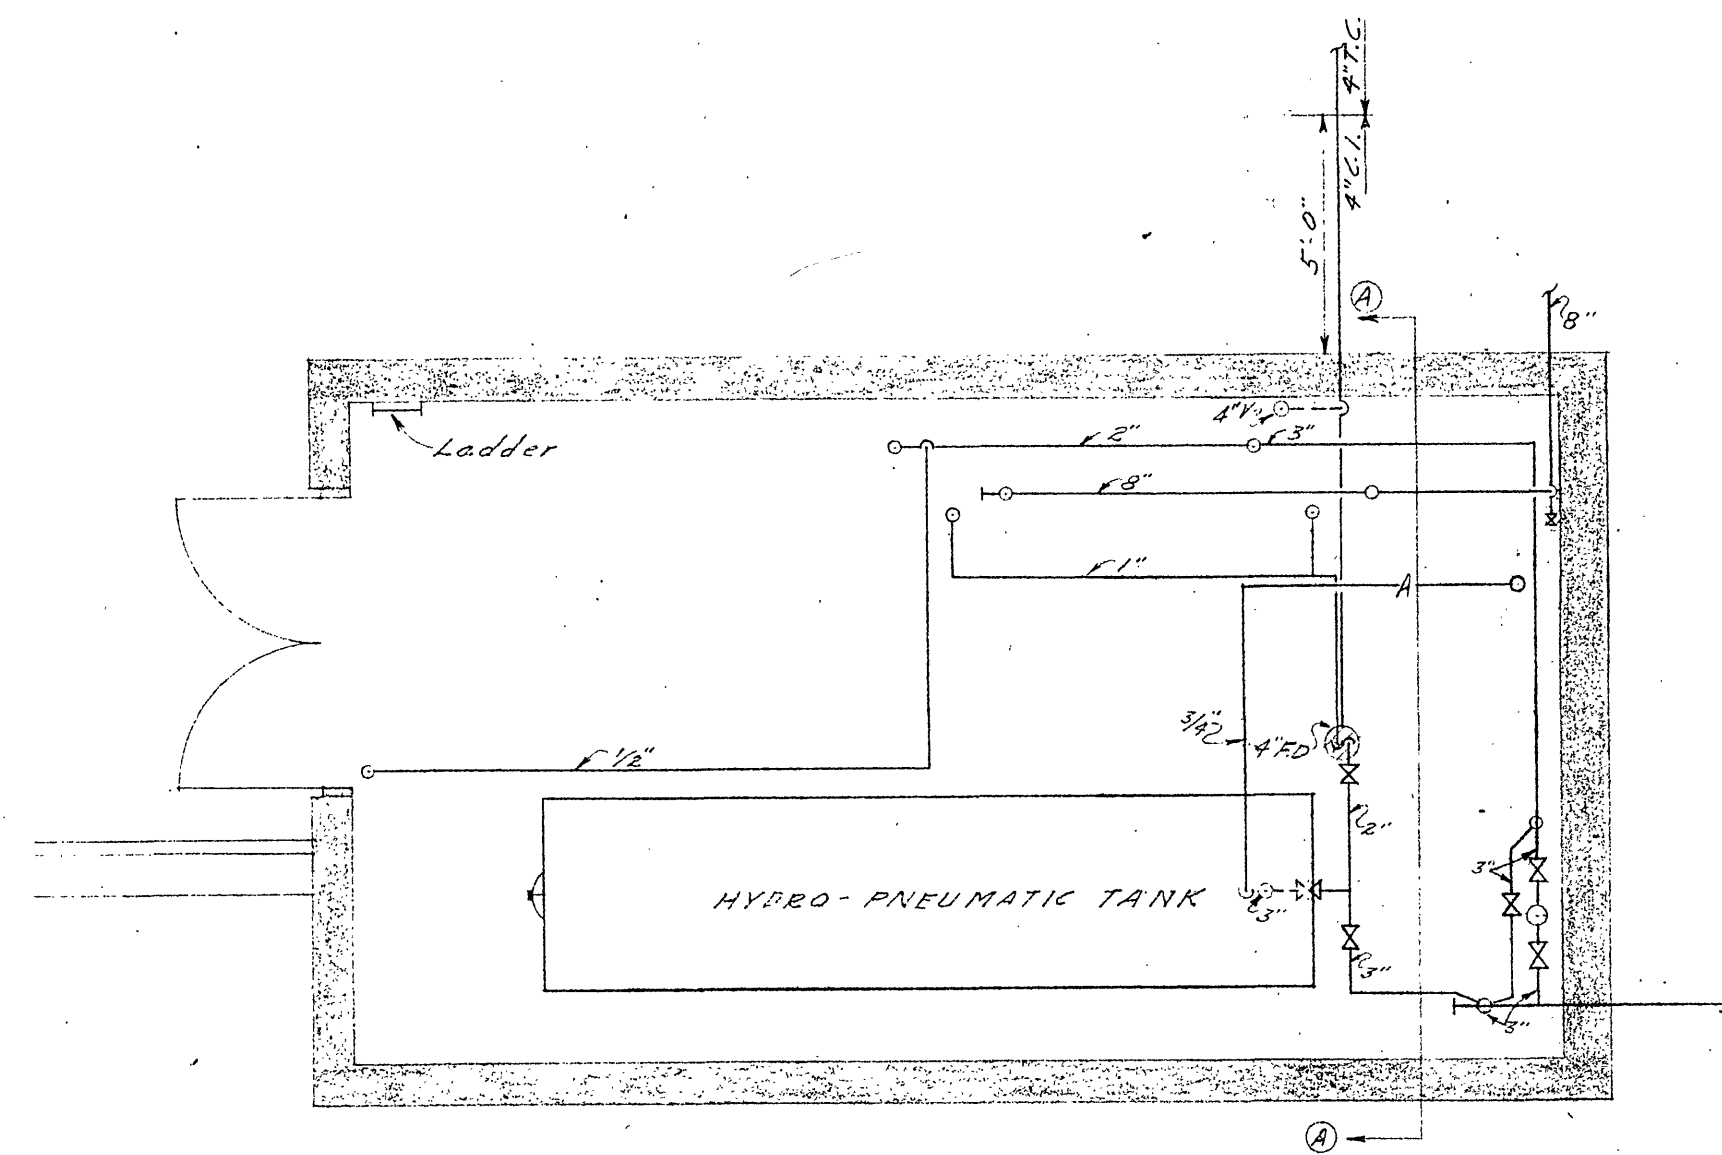


PLAN OF TANK ROOM
SCALE: 1/4" = 1'-0"

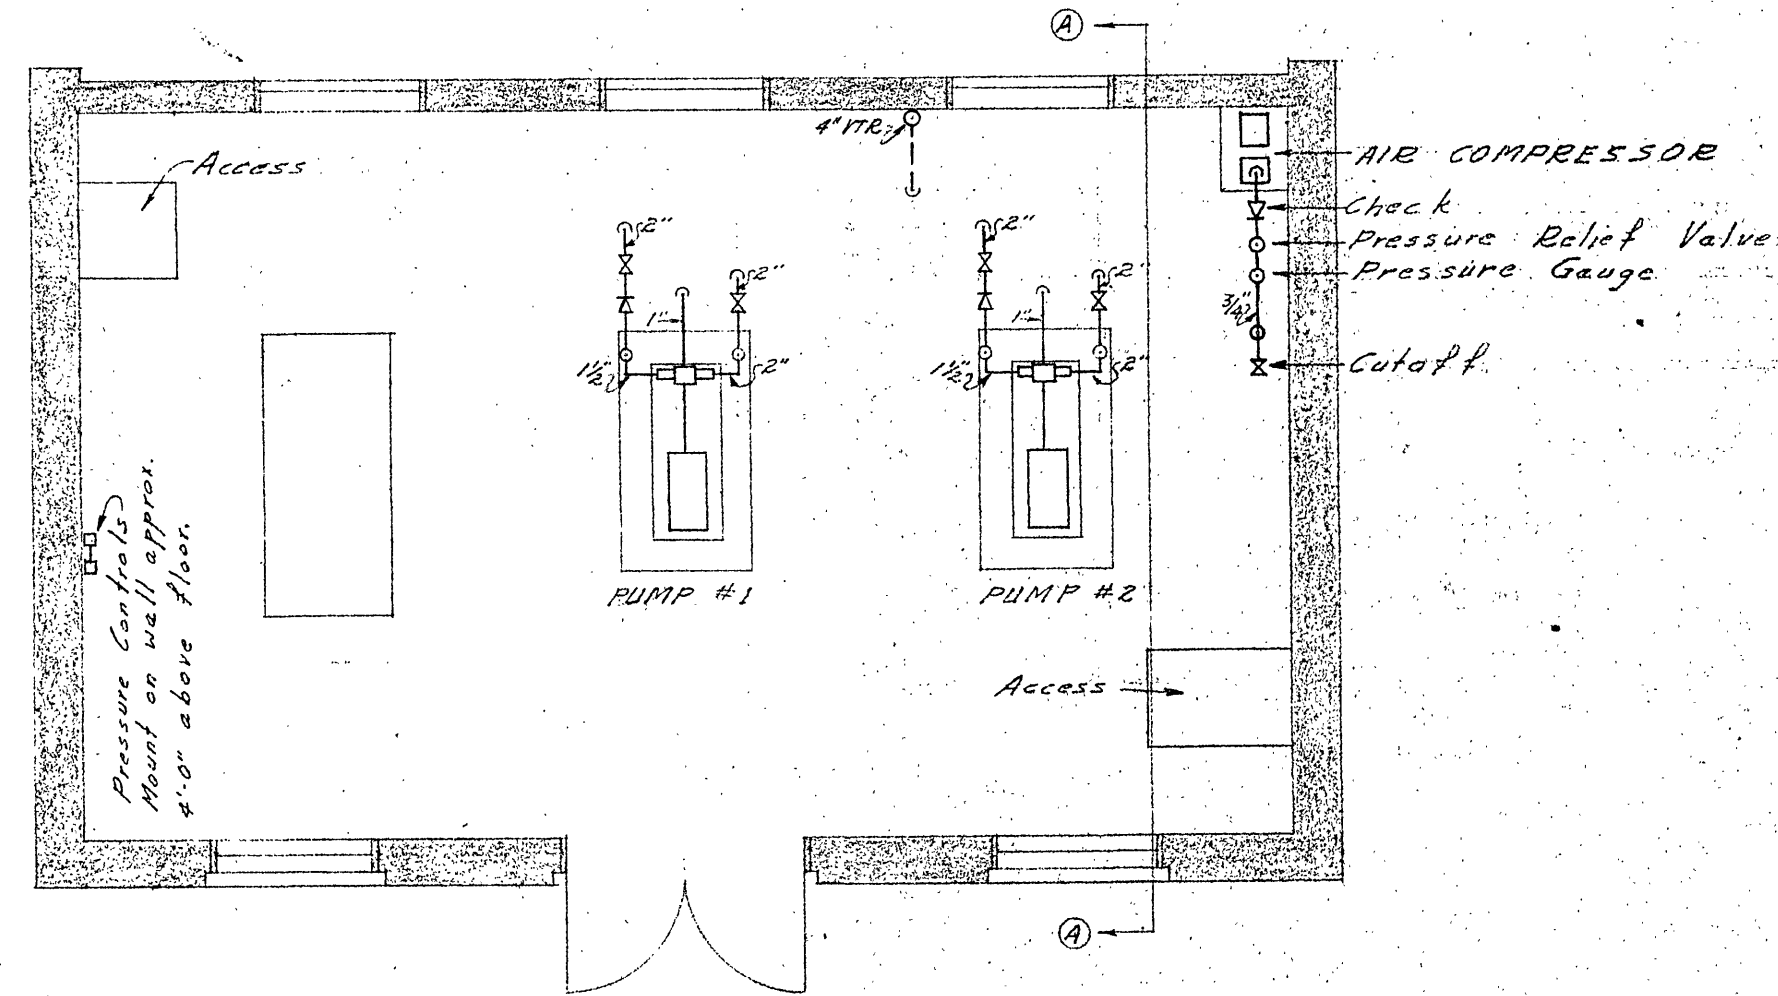

PLAN OF PUMP ROOM
SCALE: 1/4" = 1'-0"



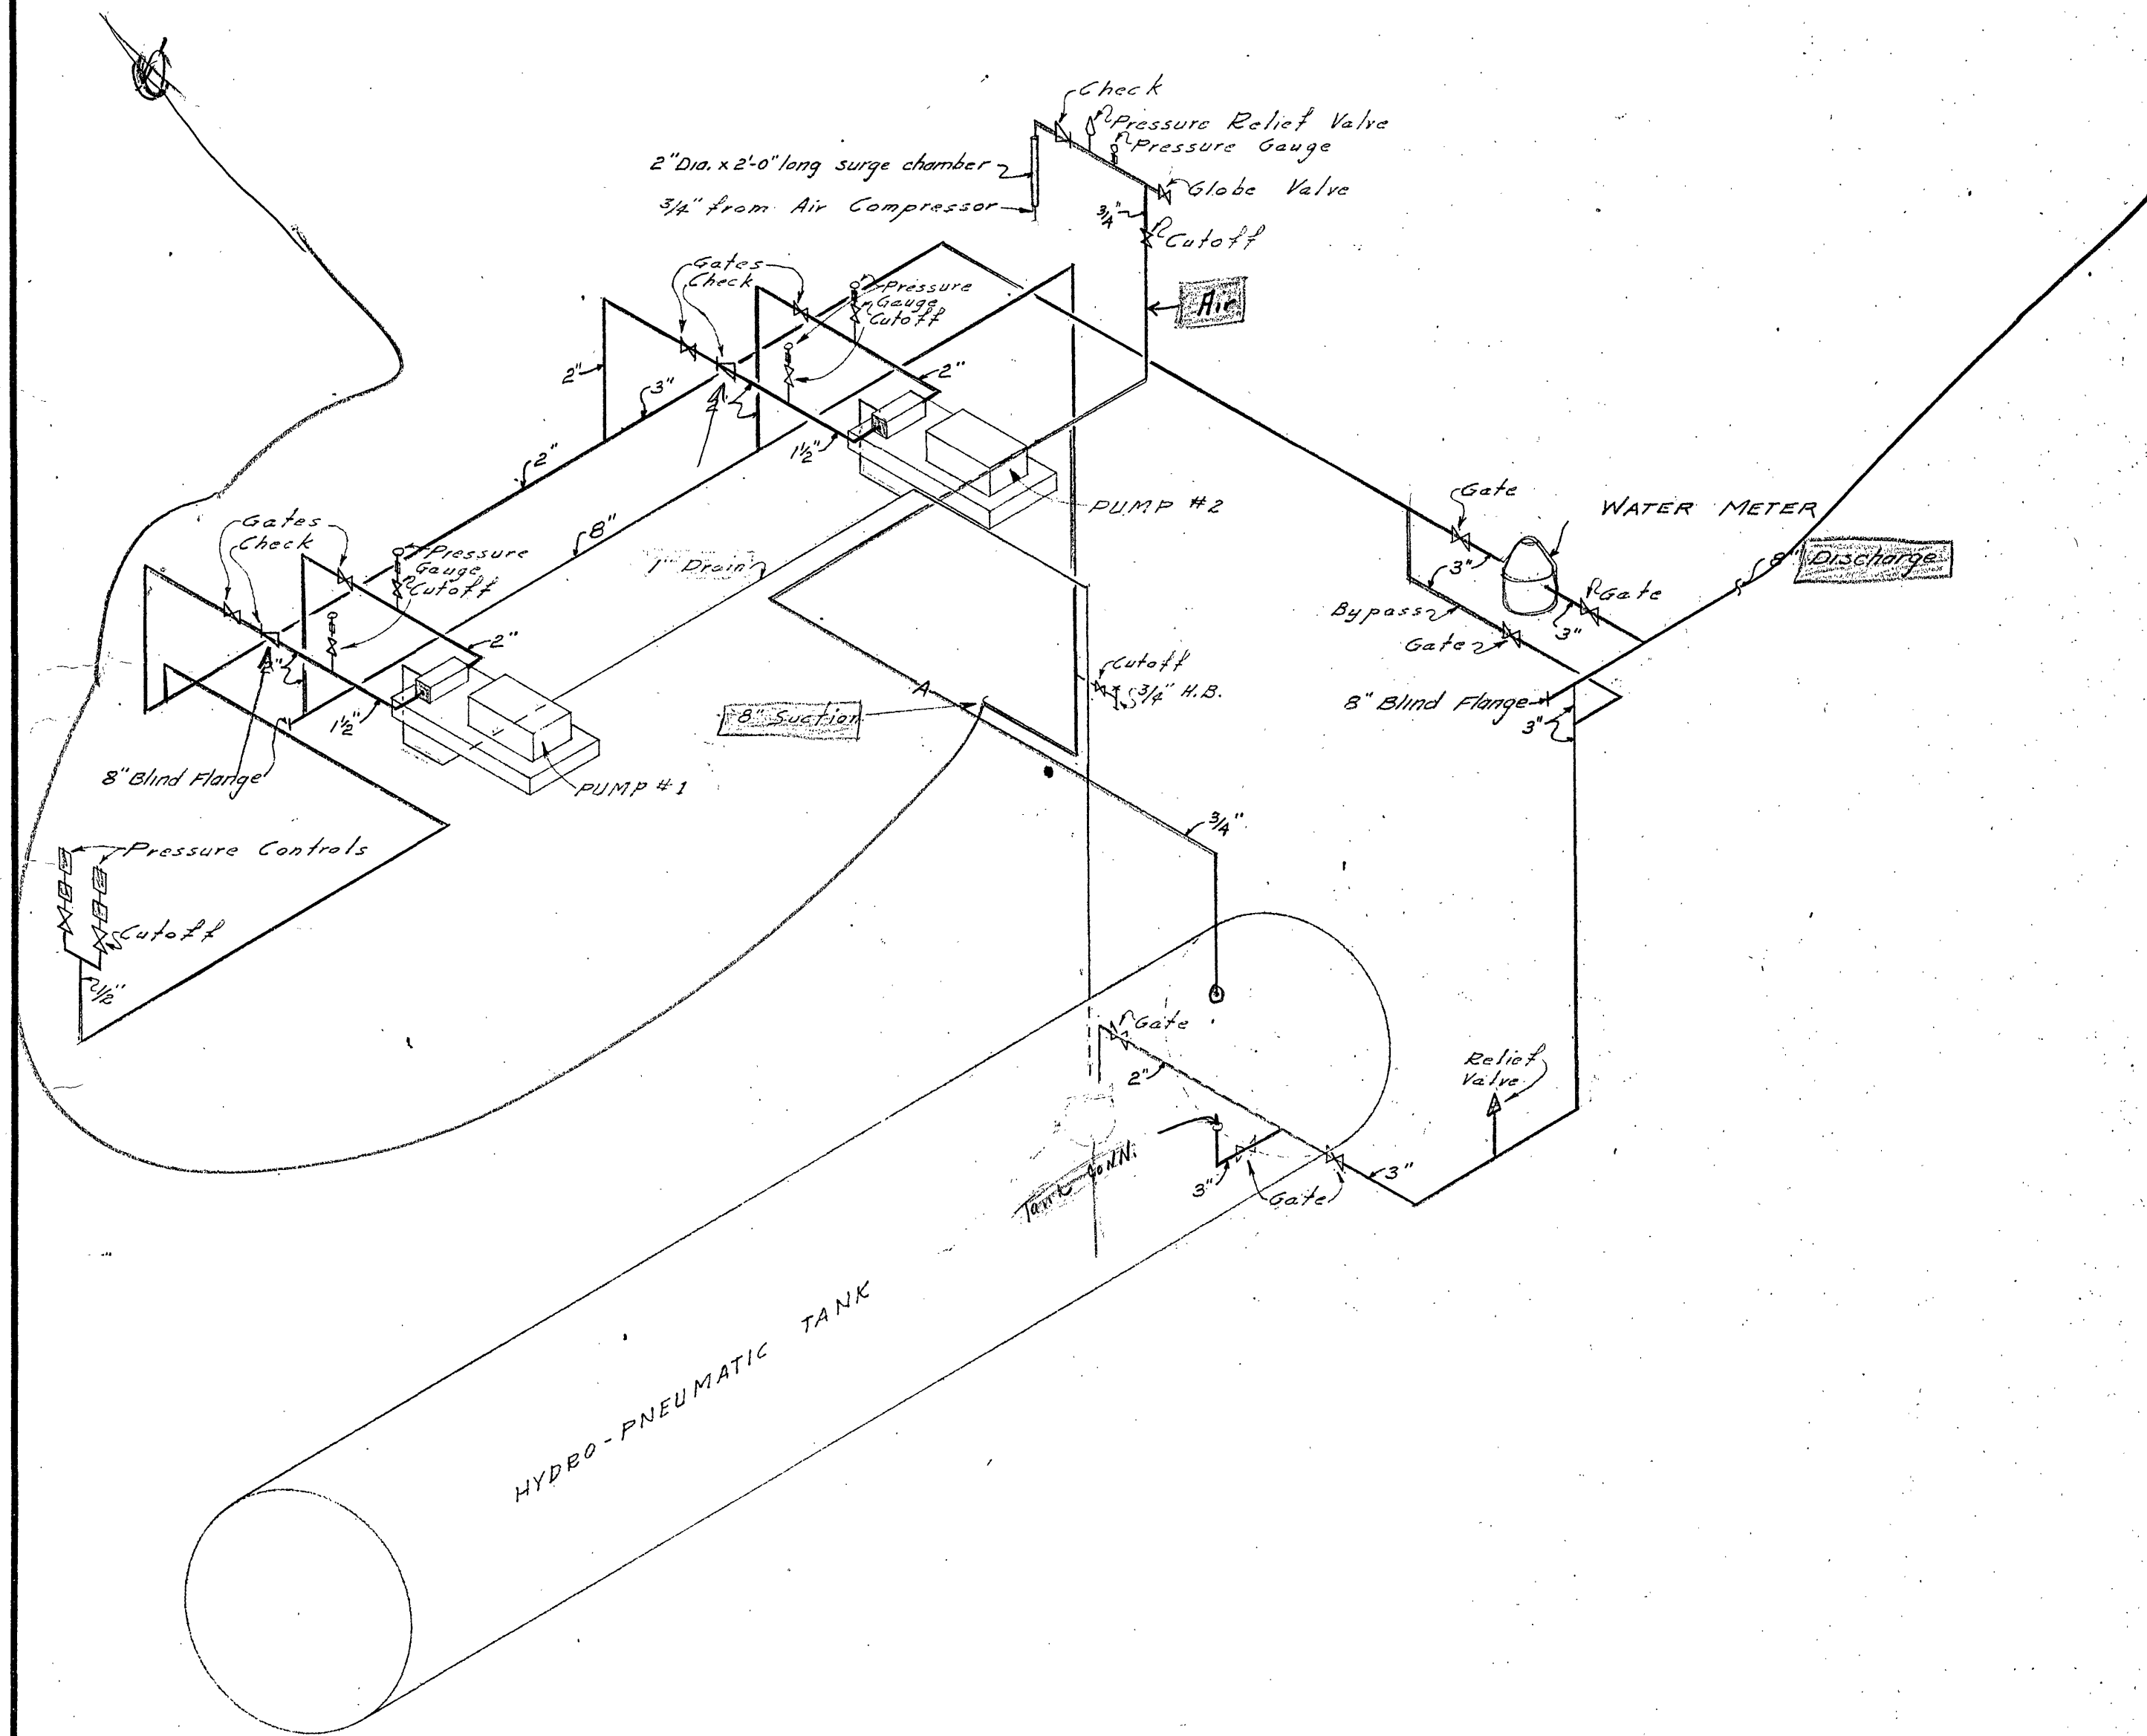


ISOMETRIC DETAIL OF PIPING
NO SCALE

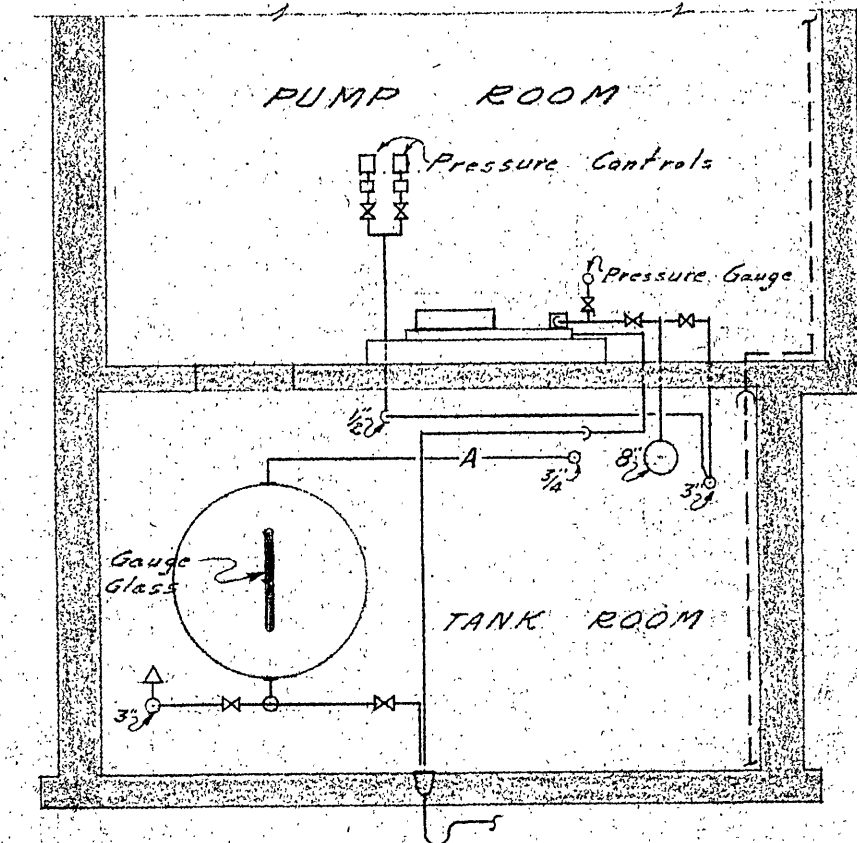

SECTION AA
SCALE: 1/4" = 1'-0"

PLUMBING NOTE
See Plot Plan for outside plumbing work.

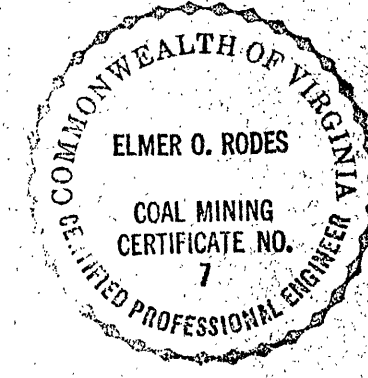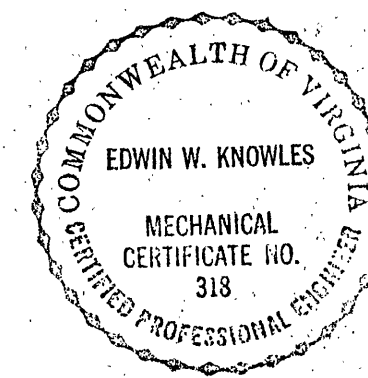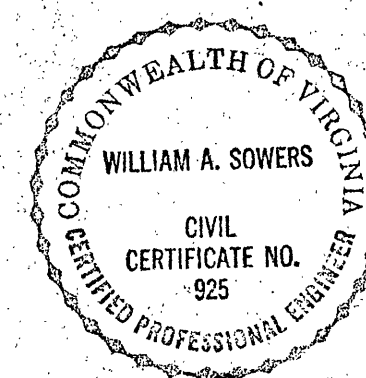

BARKSDALE, CARTER AND ASSOCIATES ARCHITECTS ENGINEERS	
PATRICK HENRY HOTEL BUILDING - ROANOKE, VIRGINIA - DIAL 2-5556	
COMM. No. 1218	PUMPING STATION
DATE 1 AUG. 1964	CHAPEL FOREST - ROANOKE, VIRGINIA
SCALE AS NOTED	PLUMBING PLANS
SHEET 3 OF 4	

ENGINEERS FOR
PLUMBING AND
ELECTRICAL WORK
SOWERS, KNOWLES & RODES
ENGINEERS
ROANOKE, VIRGINIA