




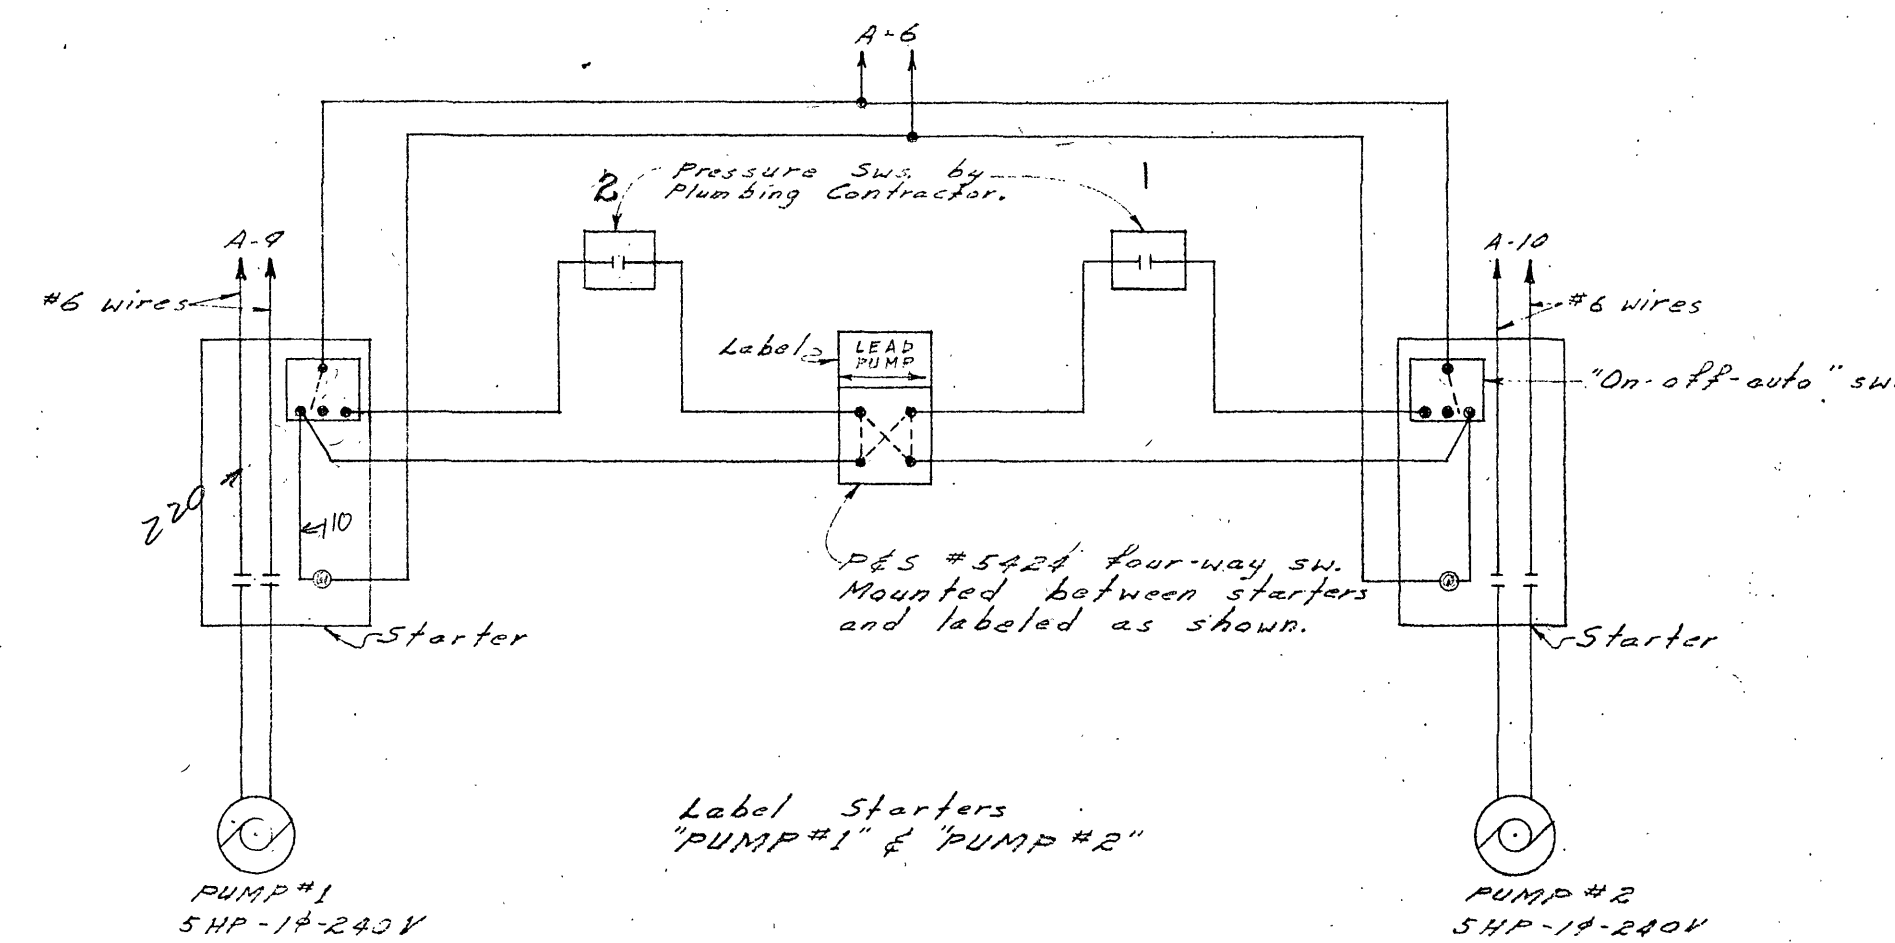


SCHEMATIC DIAGRAM OF PUMP #1 & #2 WIRING
NO SCALE

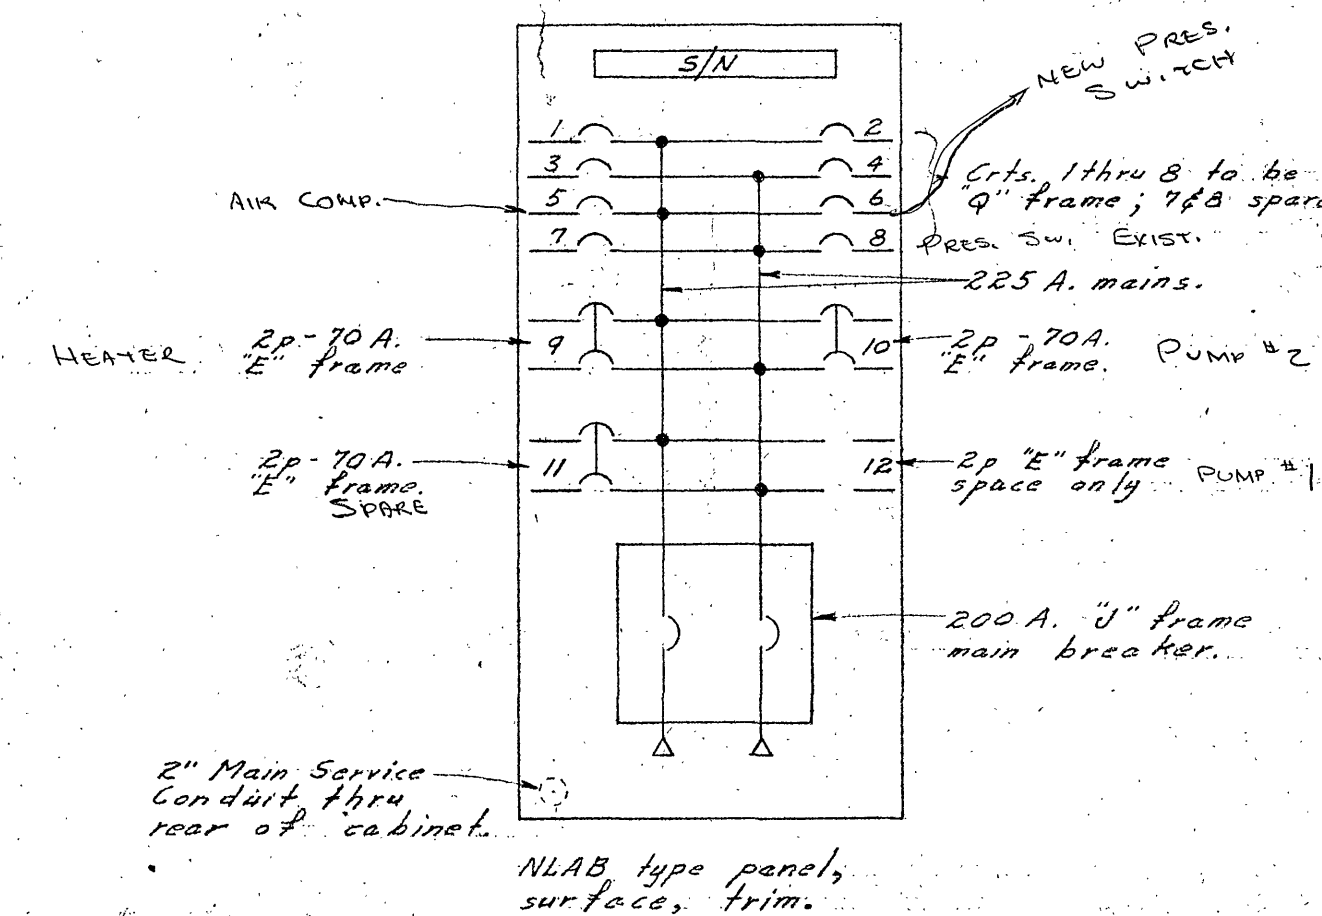


DETAIL OF PANEL-A
NO SCALE

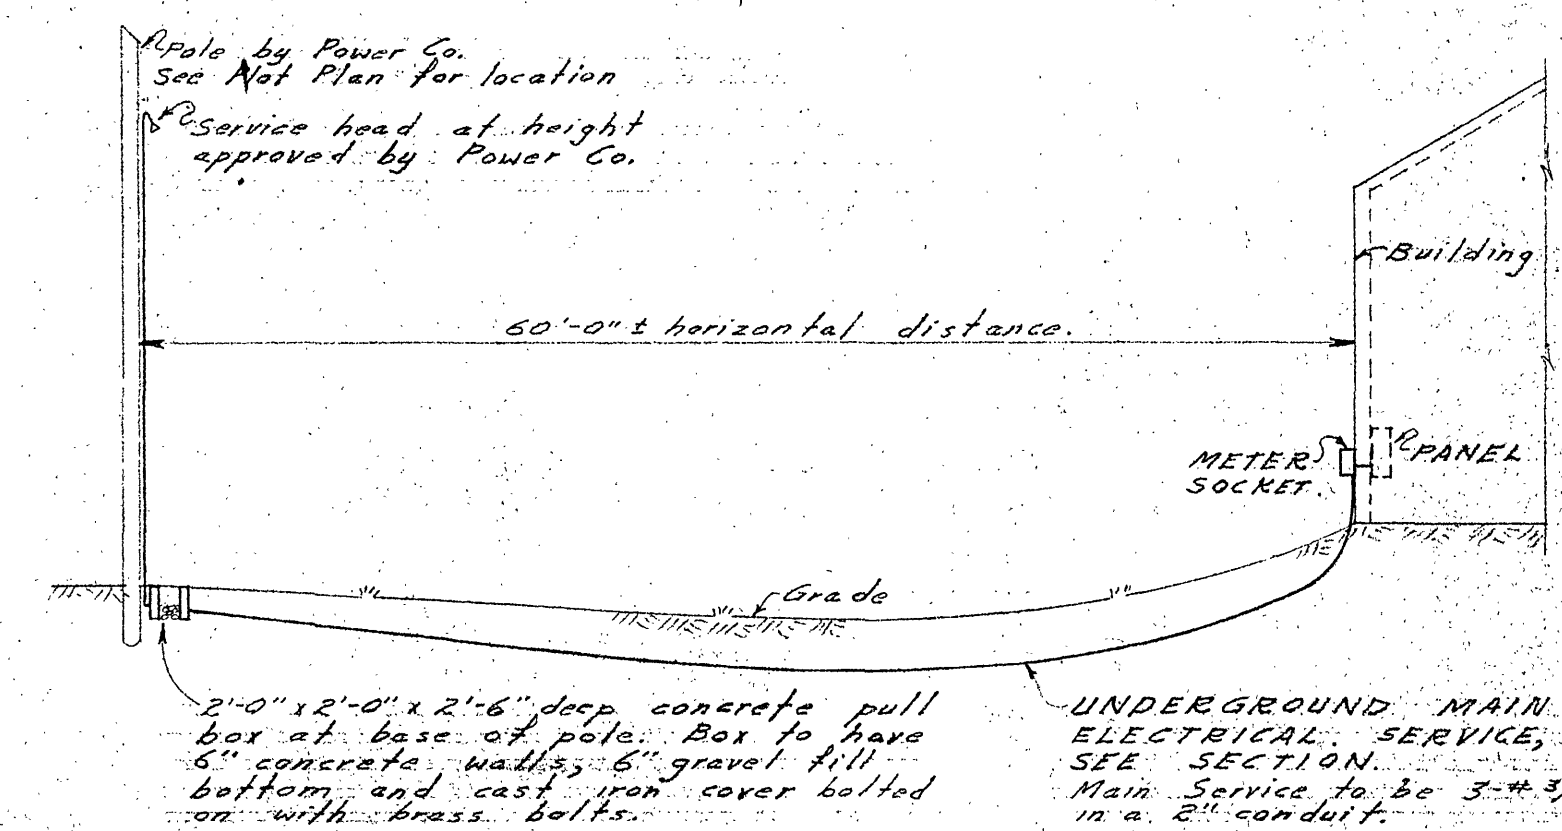

DETAIL OF MAIN SERVICE
NO SCALE

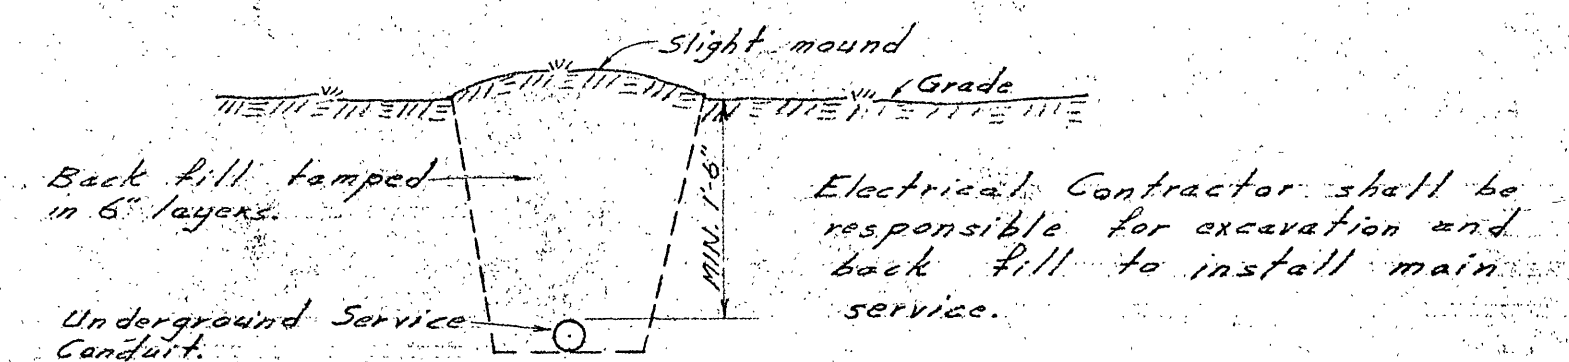

SECTION THROUGH UNDERGROUND SERVICE
NO SCALE

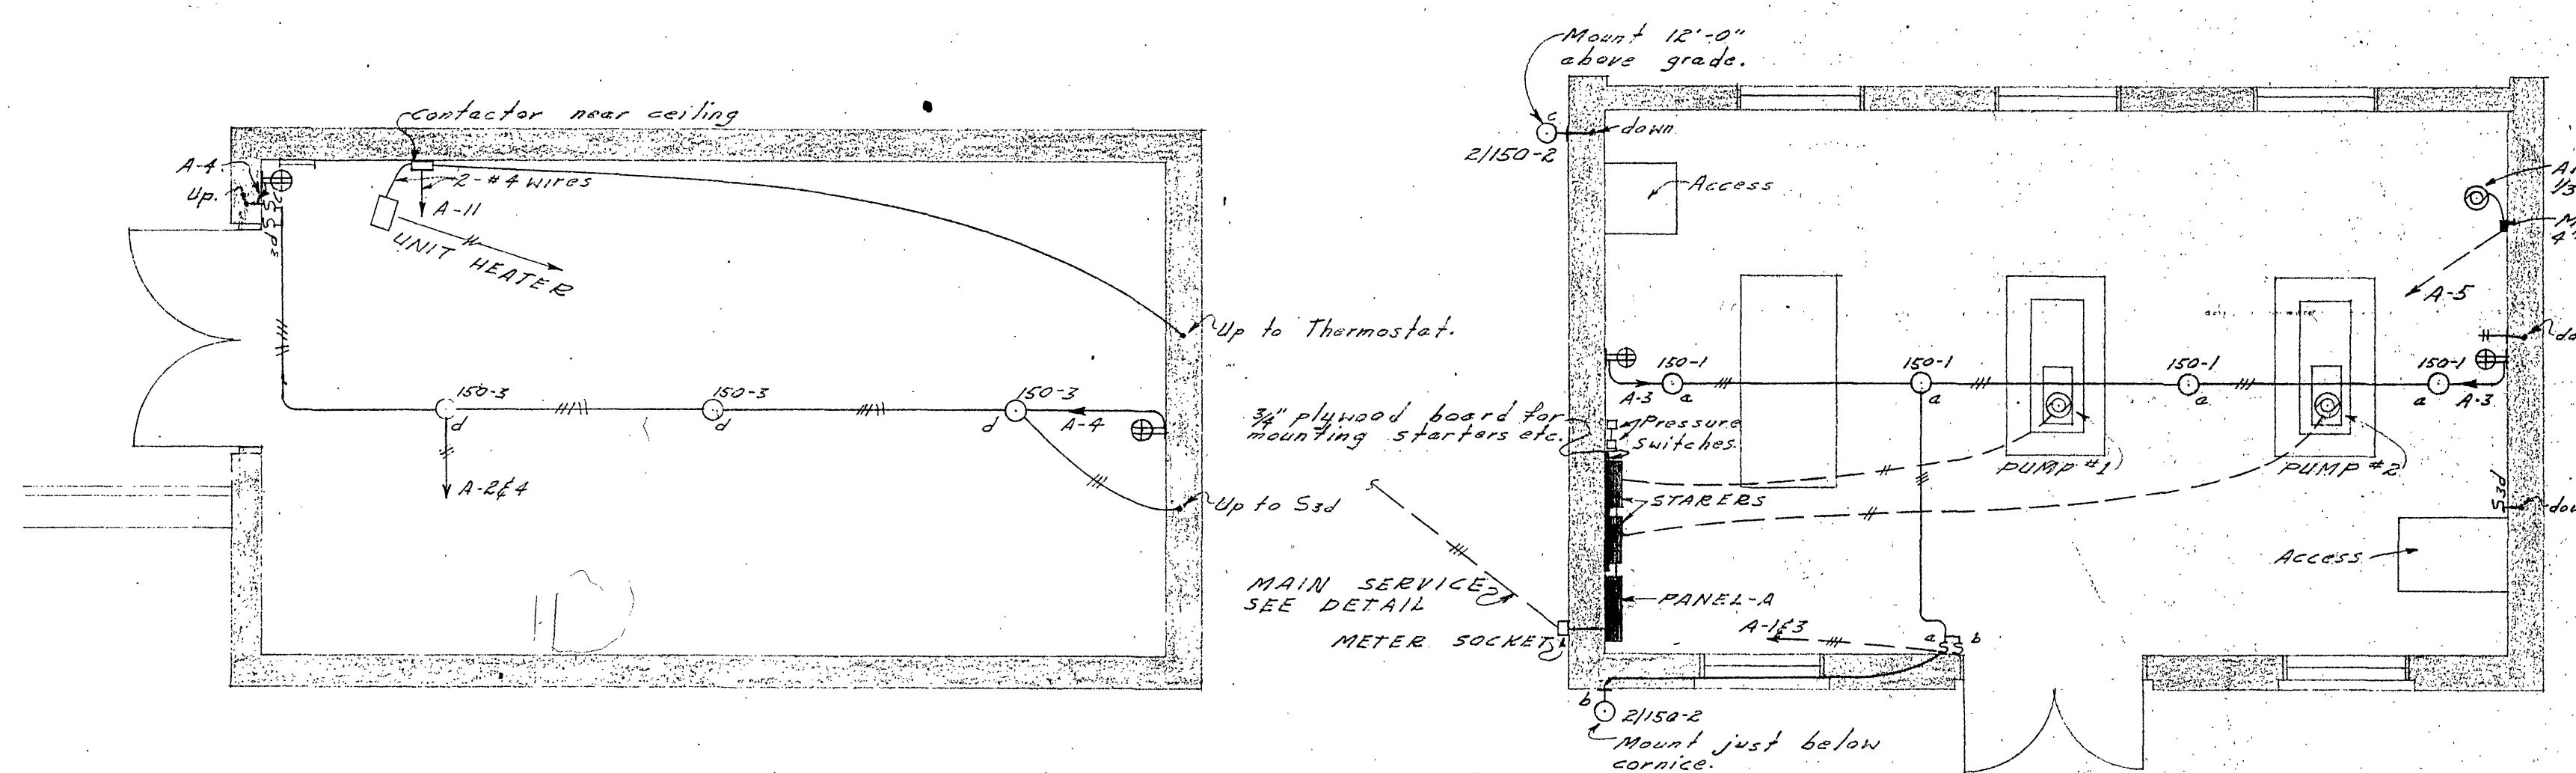

PLAN OF TANK ROOM
SCALE: 1/4" = 1'-0"

PLAN OF PUMP ROOM
SCALE: 1/4" = 1'-0"

ENGINEERS FOR
PLUMBING AND
ELECTRICAL WORK
SOWERS, KNOWLES & RODES
ENGINEERS
ROANOKE, VIRGINIA

BARKSDALE, CARTER AND ASSOCIATES ARCHITECTS ENGINEERS
PATRICK HENRY HOTEL BUILDING - ROANOKE, VIRGINIA - DIAL 2-5556

COMM. No. 1218
DATE 1 AUG 1956
SCALE AS NOTED
SHEET 4 OF 4

PUMPING STATION
CHAPEL FOREST - ROANOKE, VIRGINIA

ELECTRICAL PLANS

COMMONWEALTH OF VIRGINIA
WILLIAM A. SOWERS
CIVIL ENGINEER
CERTIFICATE NO. 925
REGISTERED PROFESSIONAL ENGINEER

COMMONWEALTH OF VIRGINIA
EDWIN W. KNOWLES
MECHANICAL ENGINEER
CERTIFICATE NO. 318
REGISTERED PROFESSIONAL ENGINEER

COMMONWEALTH OF VIRGINIA
ELMER O. RODES
COAL MINING ENGINEER
CERTIFICATE NO. 7
REGISTERED PROFESSIONAL ENGINEER