



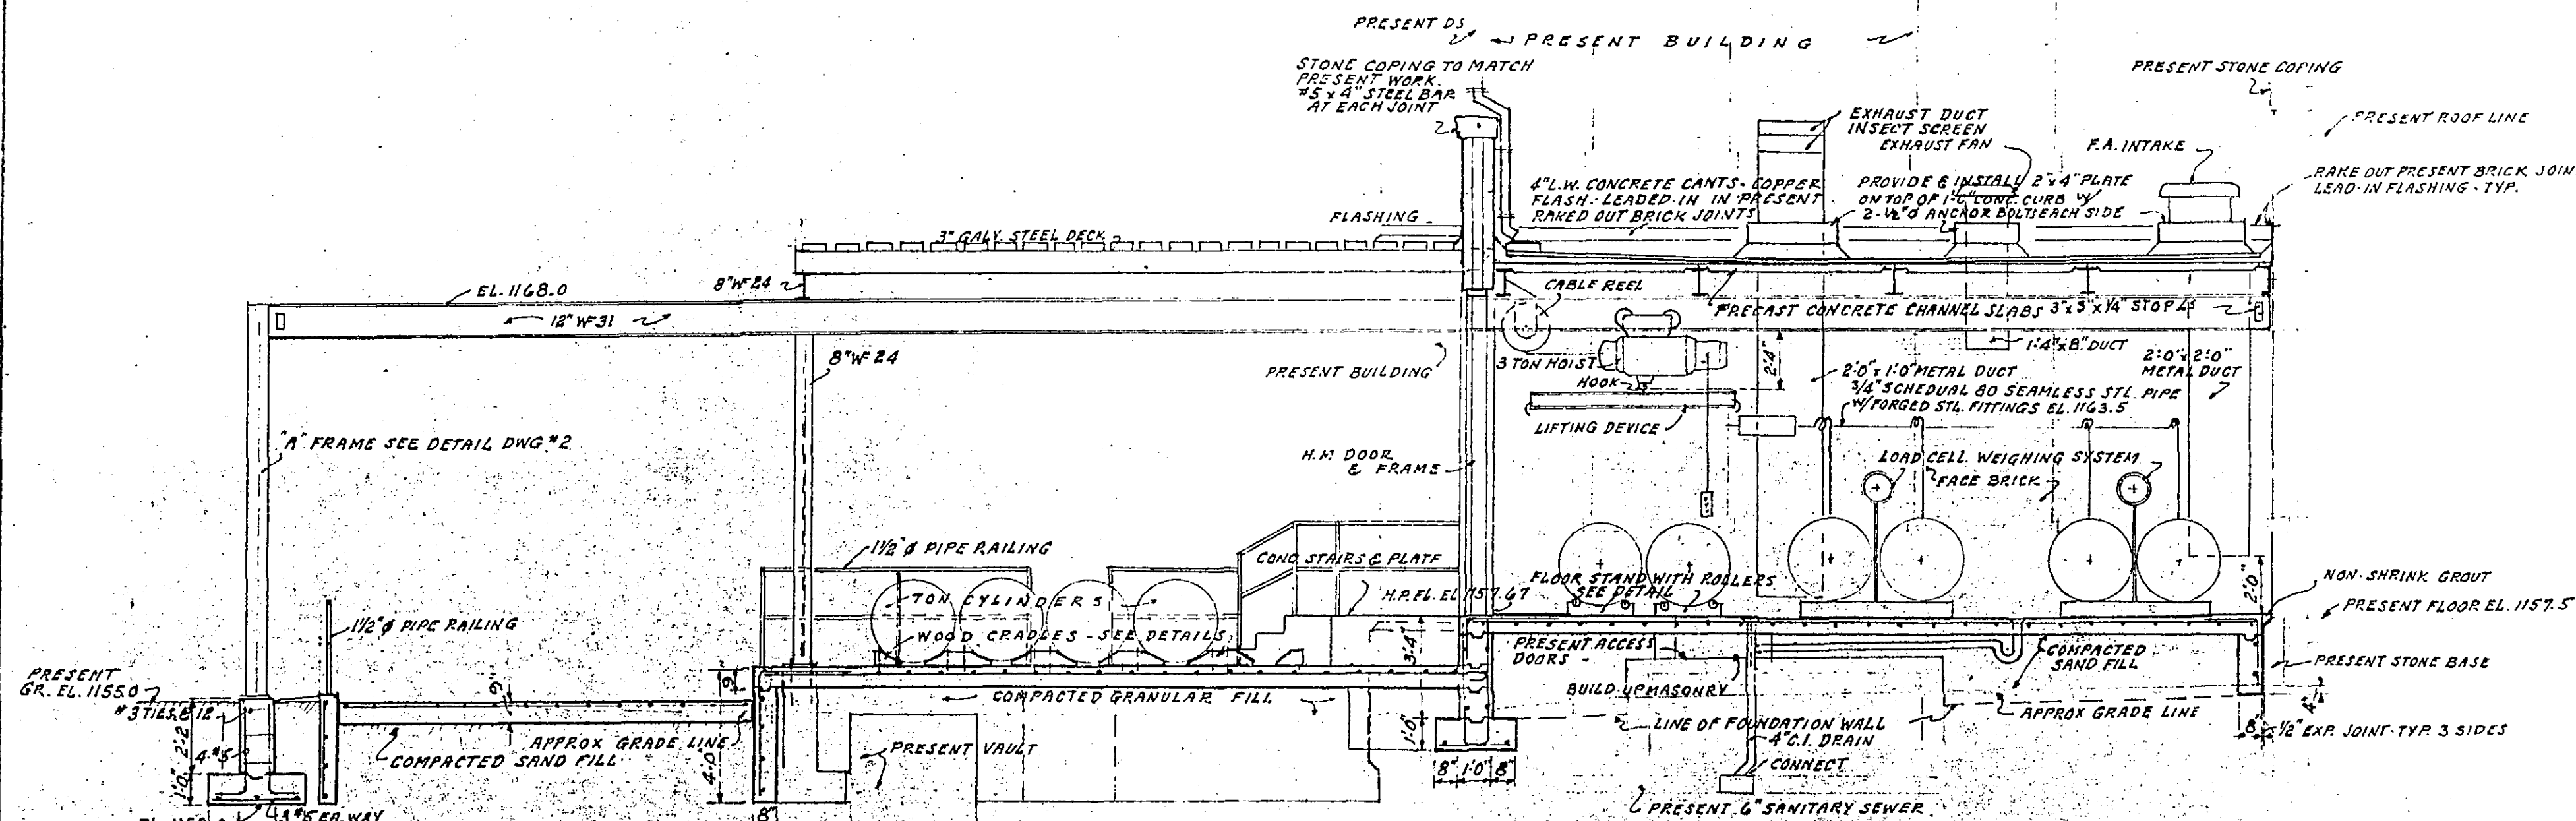

SECTION A-A


SCALE 1/4" = 1'-0"

NOTE: ALL REINFORCING STEEL #5 @ 12 AS SHOWN EXCEPT AS NOTED OTHERWISE.

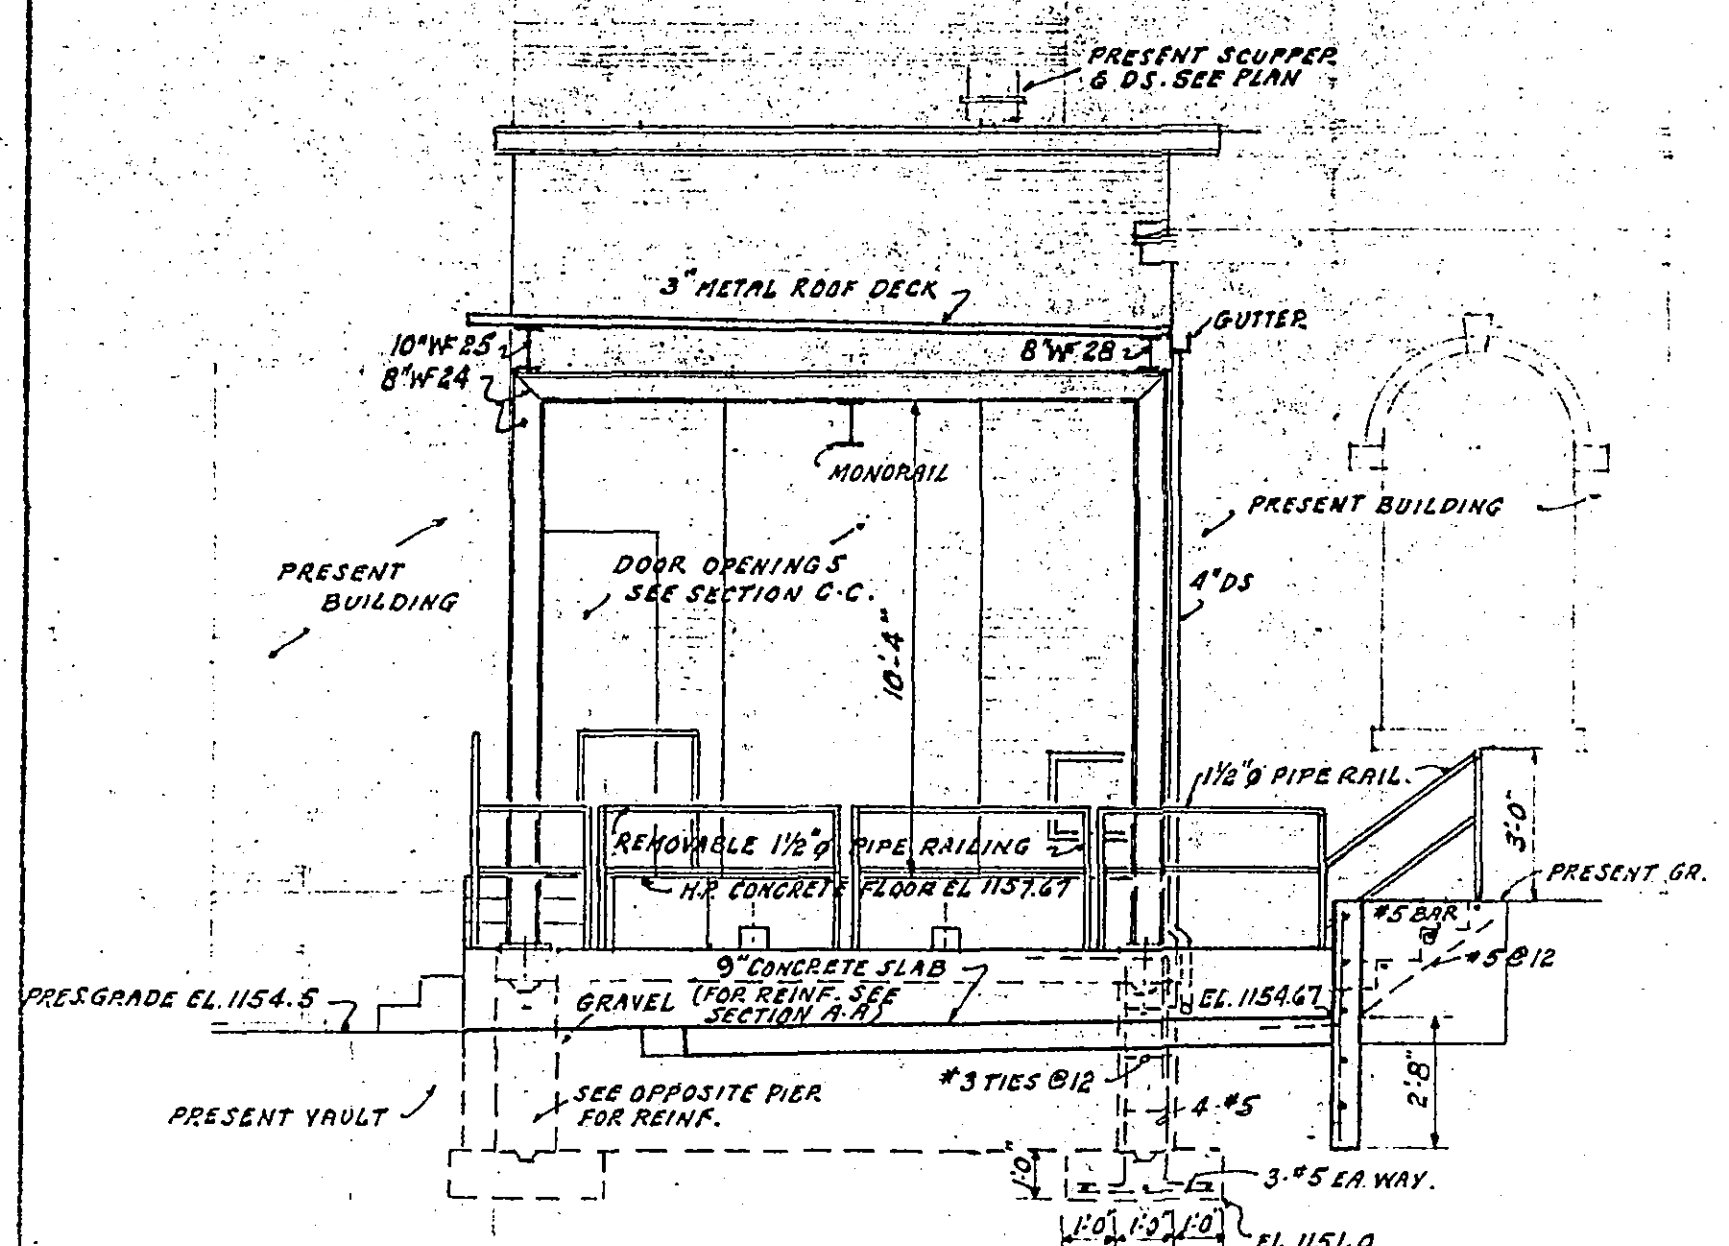


SECTION B-B

SCALE 1/4" = 1'-0"

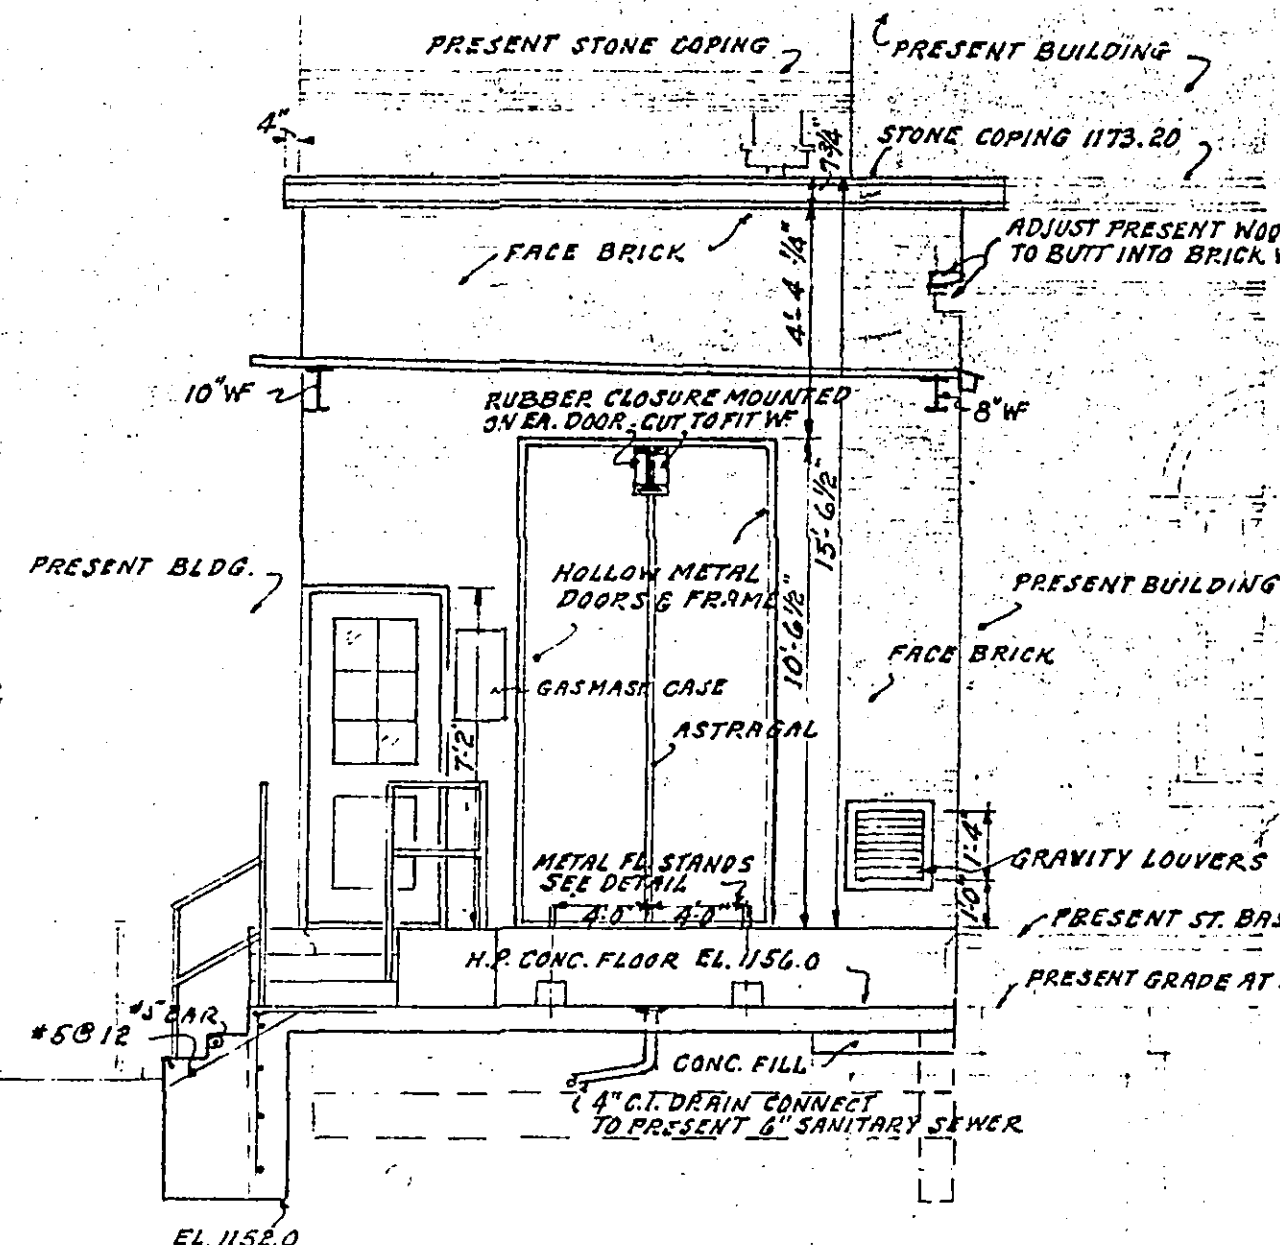


SECTION C-C

SCALE 1/4" = 1'-0"

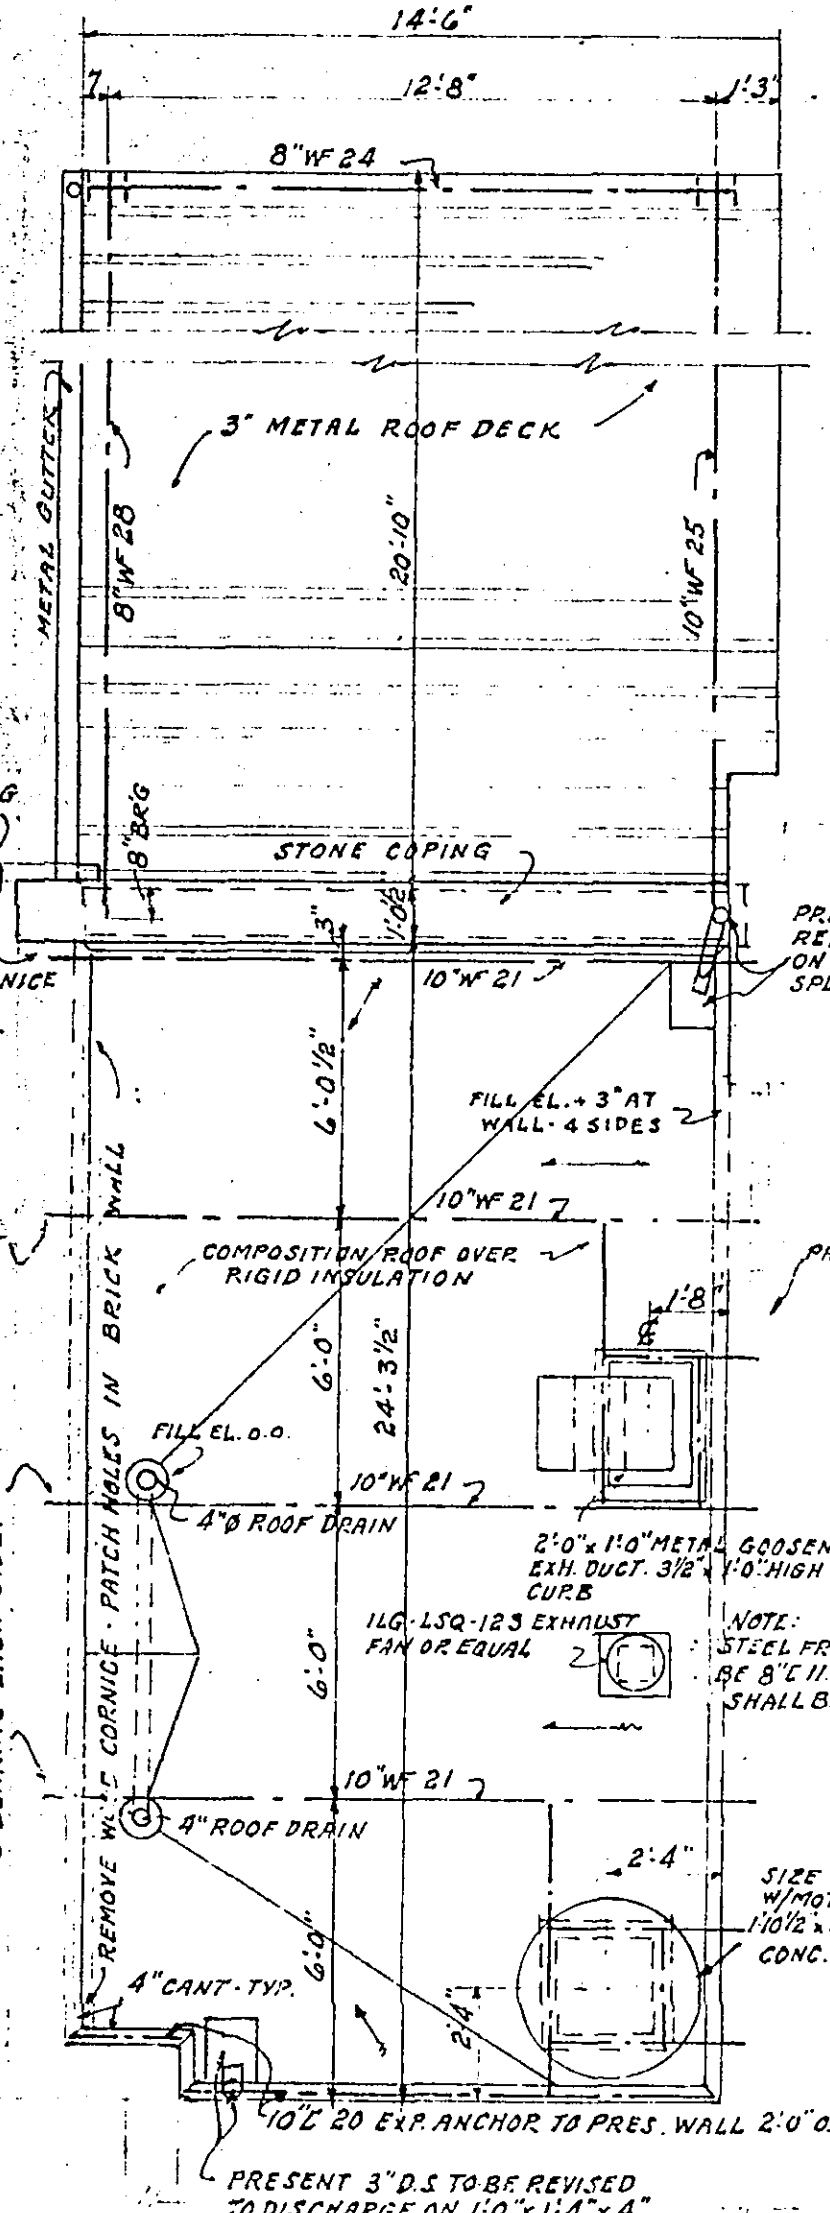


ROOF & ROOF FRAMING PLAN

SCALE 1/4" = 1'-0"

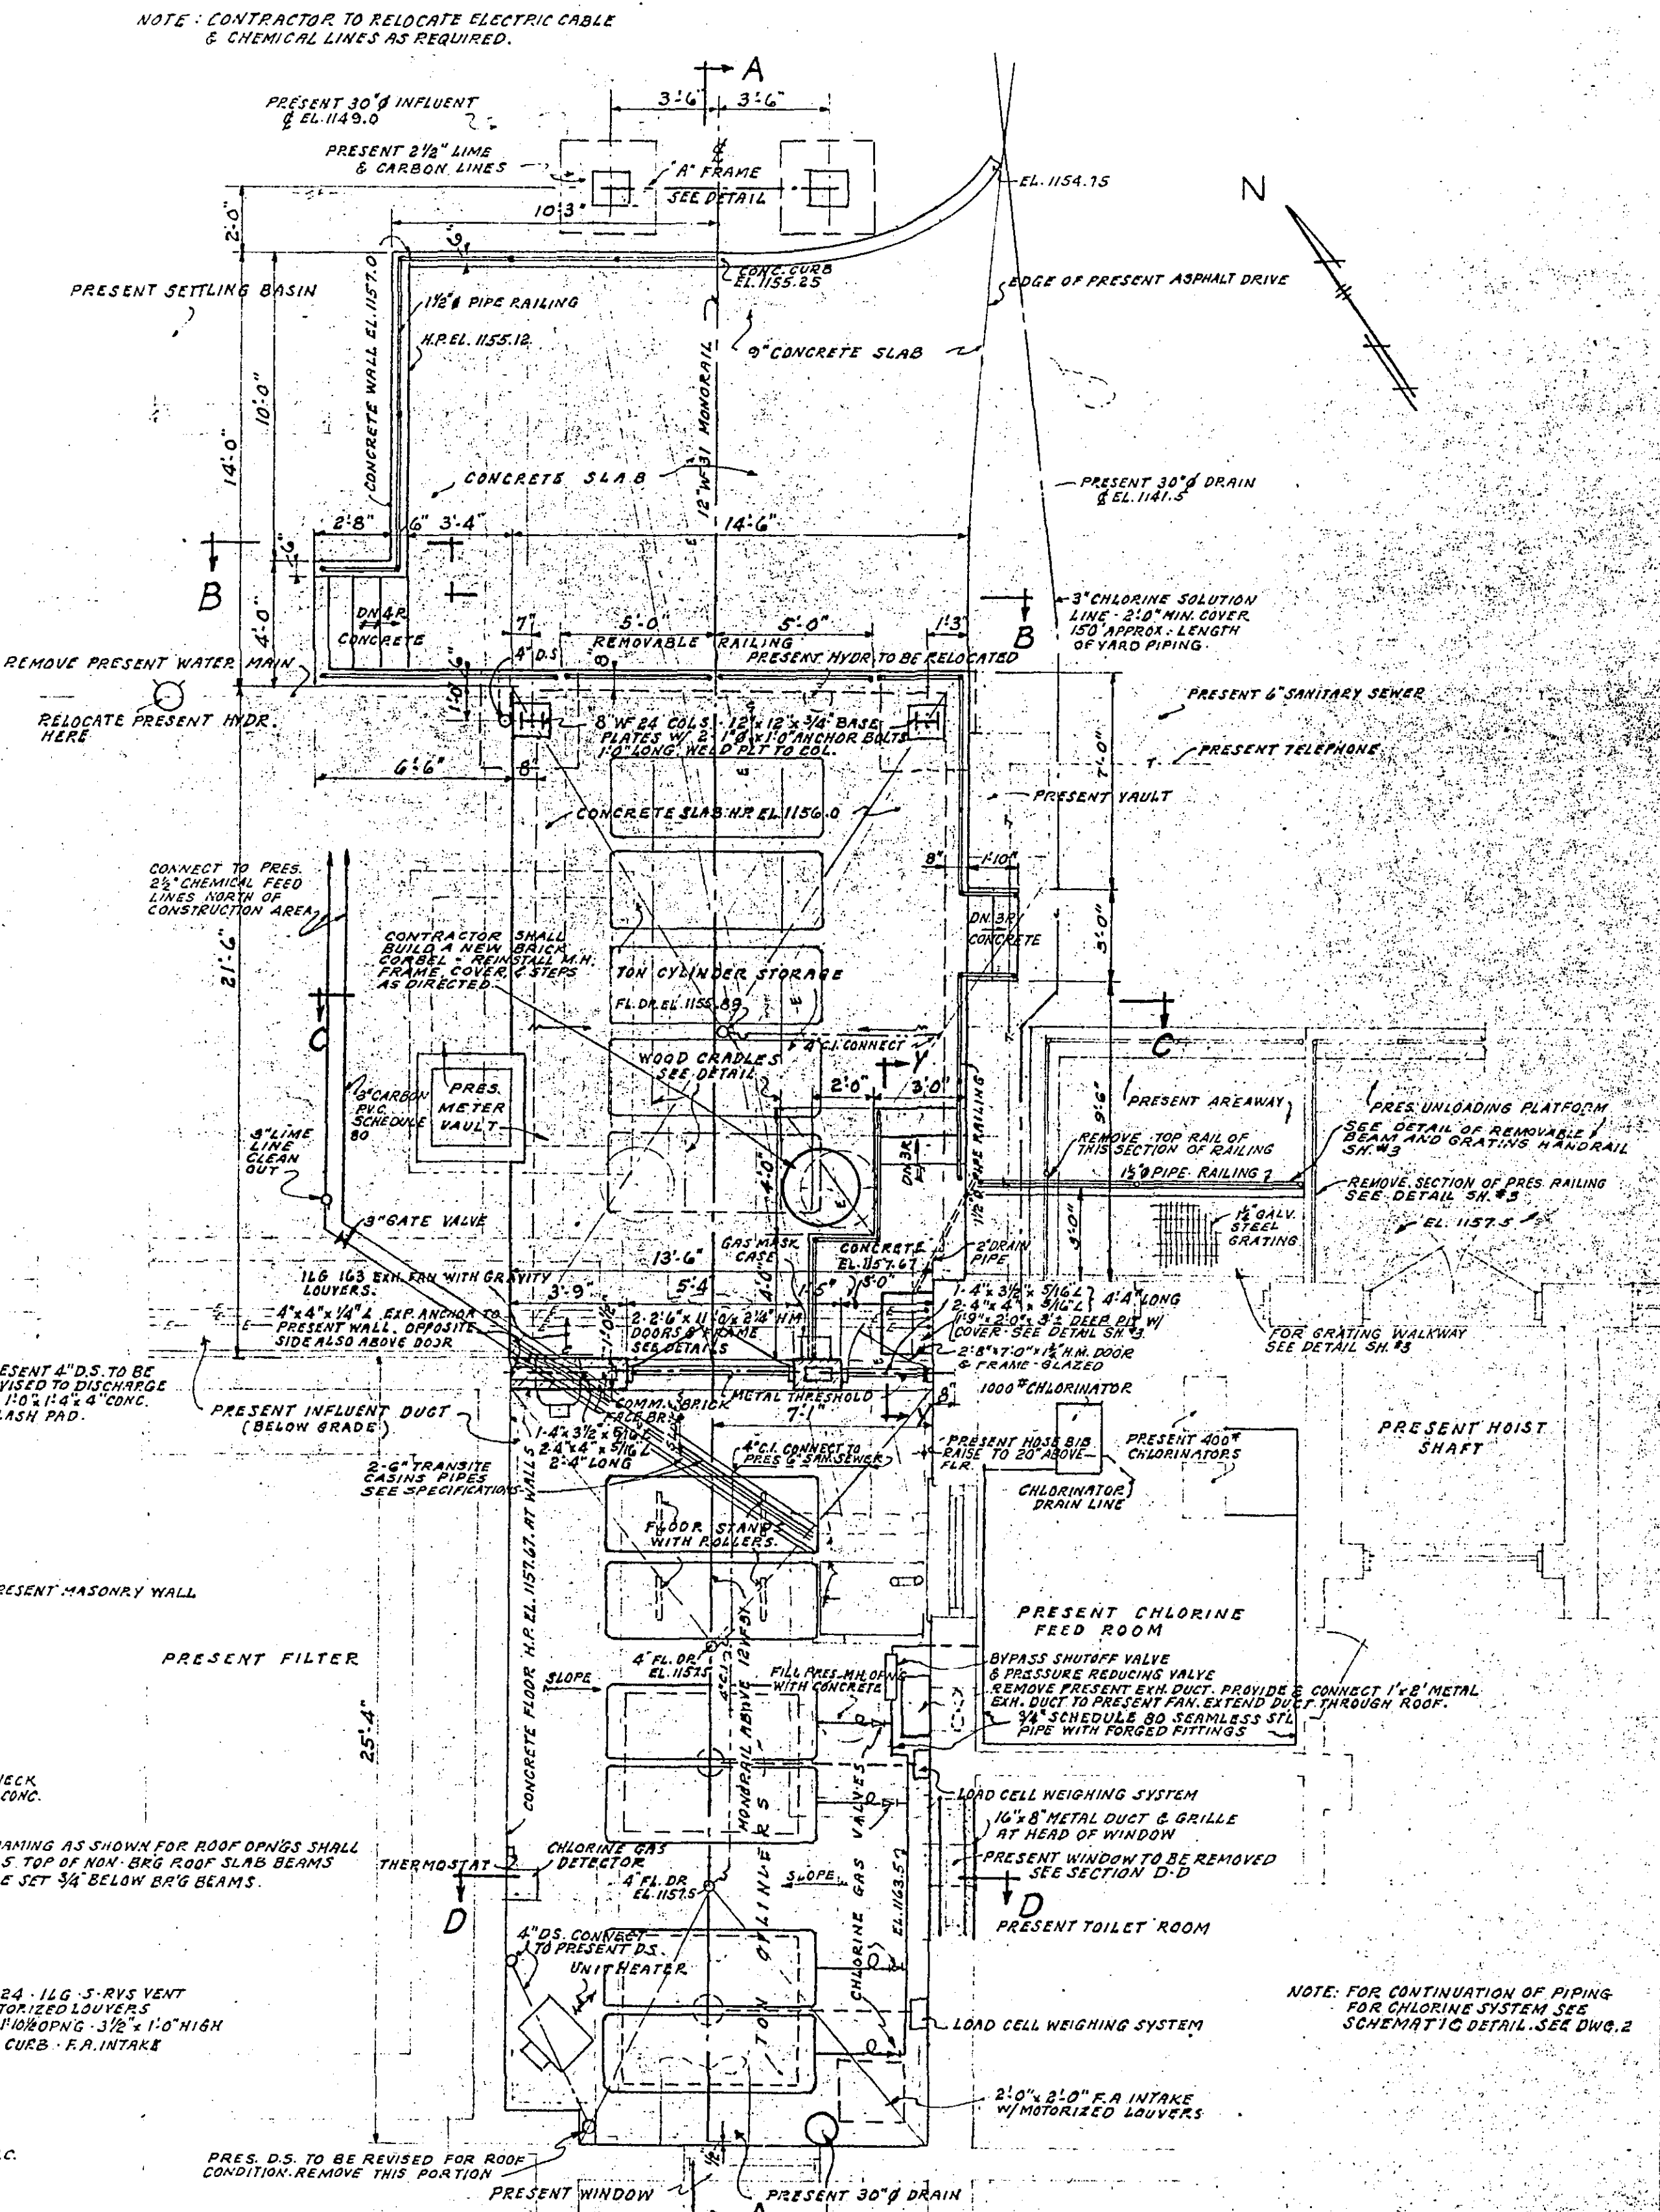


FLOOR PLAN

SCALE 1/4" = 1'-0"

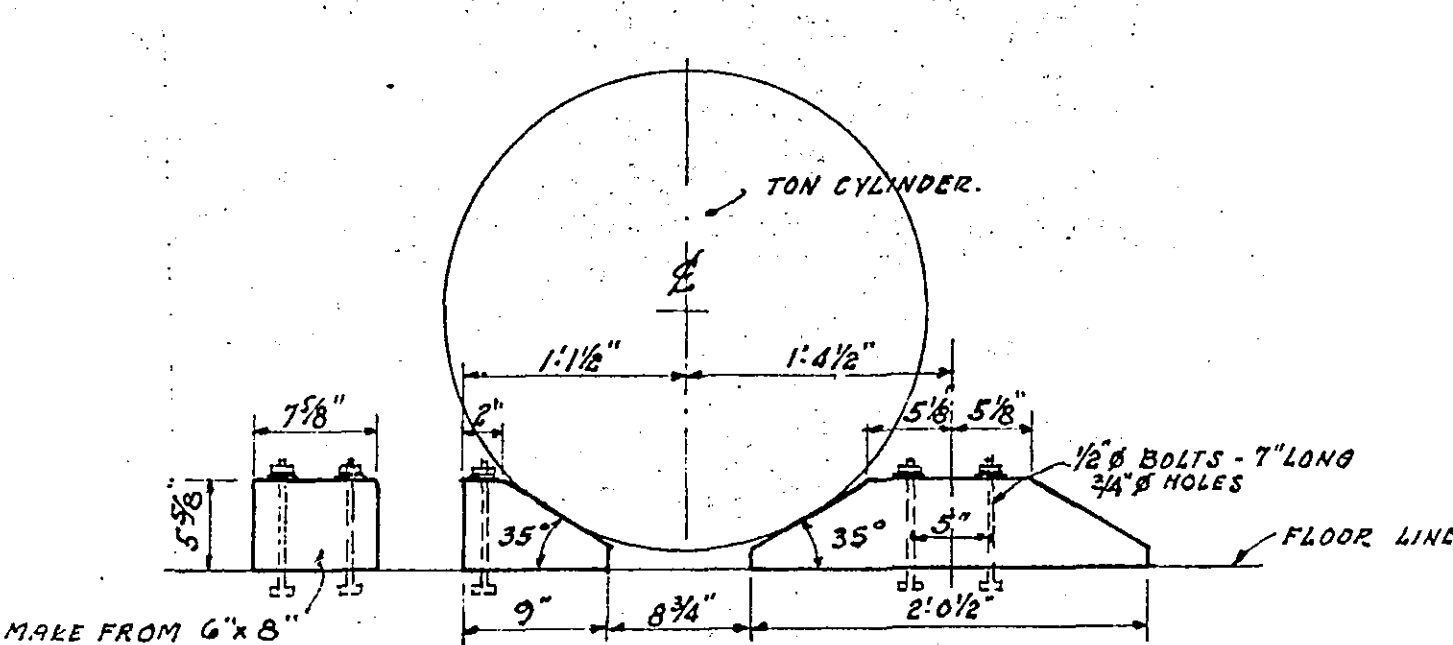


WOOD CRADLES DETAIL

SCALE 1" = 1'-0"

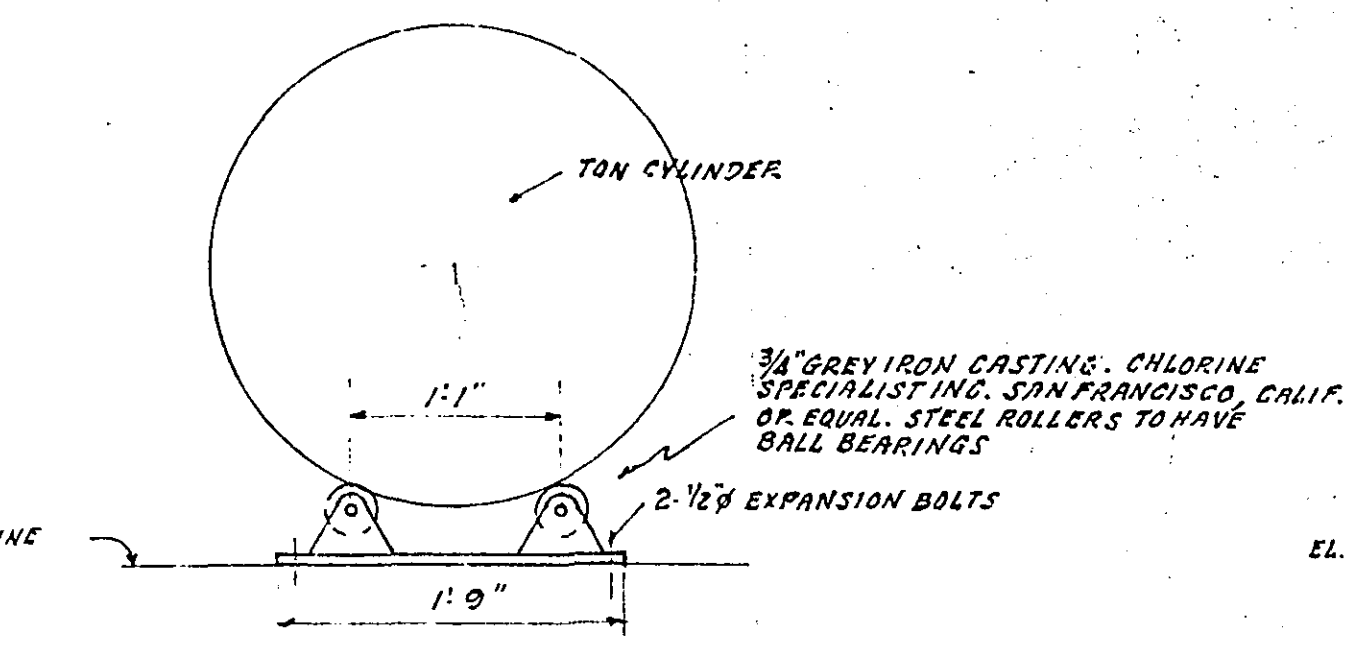

ROLLER CYLINDER CRADLE

SCALE 1 1/2" = 1'-0"

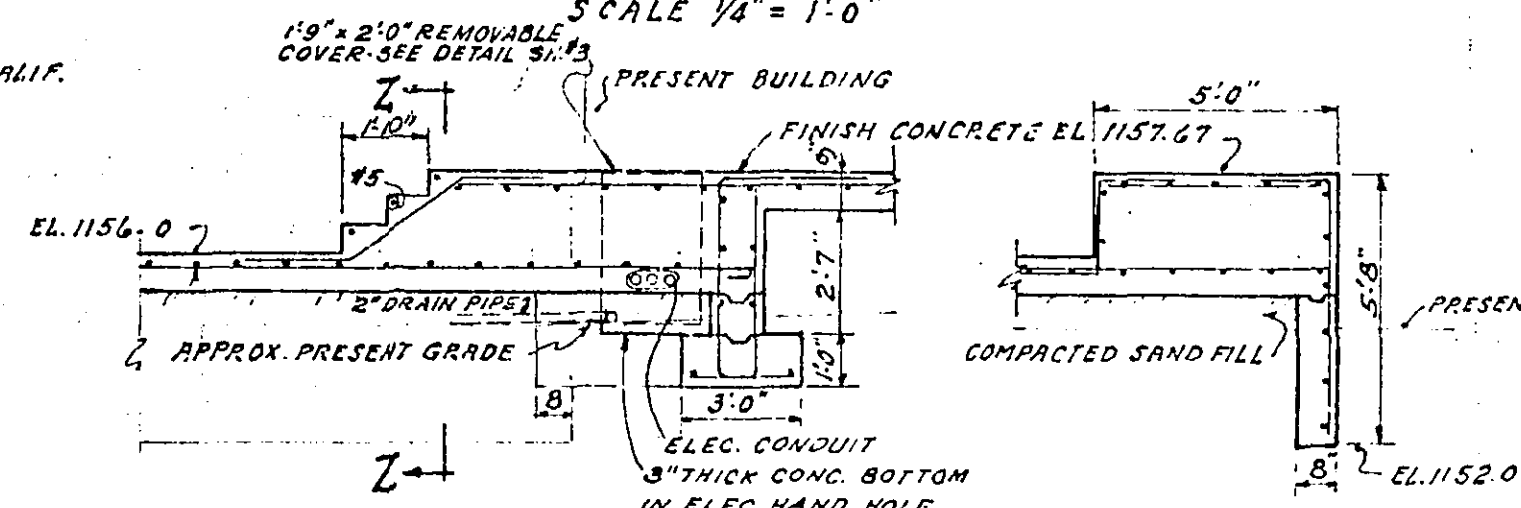

SECTION Y-Y

SCALE 1/4" = 1'-0"

SECTION Z-Z

SCALE 1/4" = 1'-0"

NOTE: CONTRACTOR TO RELOCATE ELECTRIC CABLE & CHEMICAL LINES AS REQUIRED.

NOTE: CONTRACTOR SHALL VERIFY ALL DIMENSIONS & CONDITIONS AT BUILDING SITE & SHALL MAKE PROPER ADJUSTMENTS TO SUIT FIELD CONDITIONS.

SHEET 1 OF 3

CONTRACT "P"
CHLORINATION FACILITIES
PLANS & DETAILS
CITY OF ROANOKE, WATER DEPT.
ROANOKE, VIRGINIA
ALVORD, BURDICK & HOWSON
ENGINEERS
CHICAGO
1973

