

HUGHES ASSOCIATES ARCHITECTS

Architecture • Planning • Consulting

656 ELM AVENUE, S.W.
P.O. BOX 1034
ROANOKE, VIRGINIA 24005-1034

TEL (540) 342-4002
FAX (540) 342-2060
www.HughesArchitects.com

ALTERATIONS TO
 WESTERN VIRGINIA
 WATER AUTHORITY
 COULTER BUILDING
 601 South Jefferson Street Roanoke, Virginia

FIRST
 FLOOR
 PLAN
 (TELEPHONE,
 DATA,
 POWER &
 ELECTRICAL)

PHASE I

COMMISSION No.

04102

SHEET

E1-2

No. 1 of 13


COPYRIGHT 2005

HUGHES ASSOCIATES ARCHITECTS

A PROFESSIONAL CORPORATION

FRANKLIN ROAD

E1-4.1
E1-2
PHASE 1

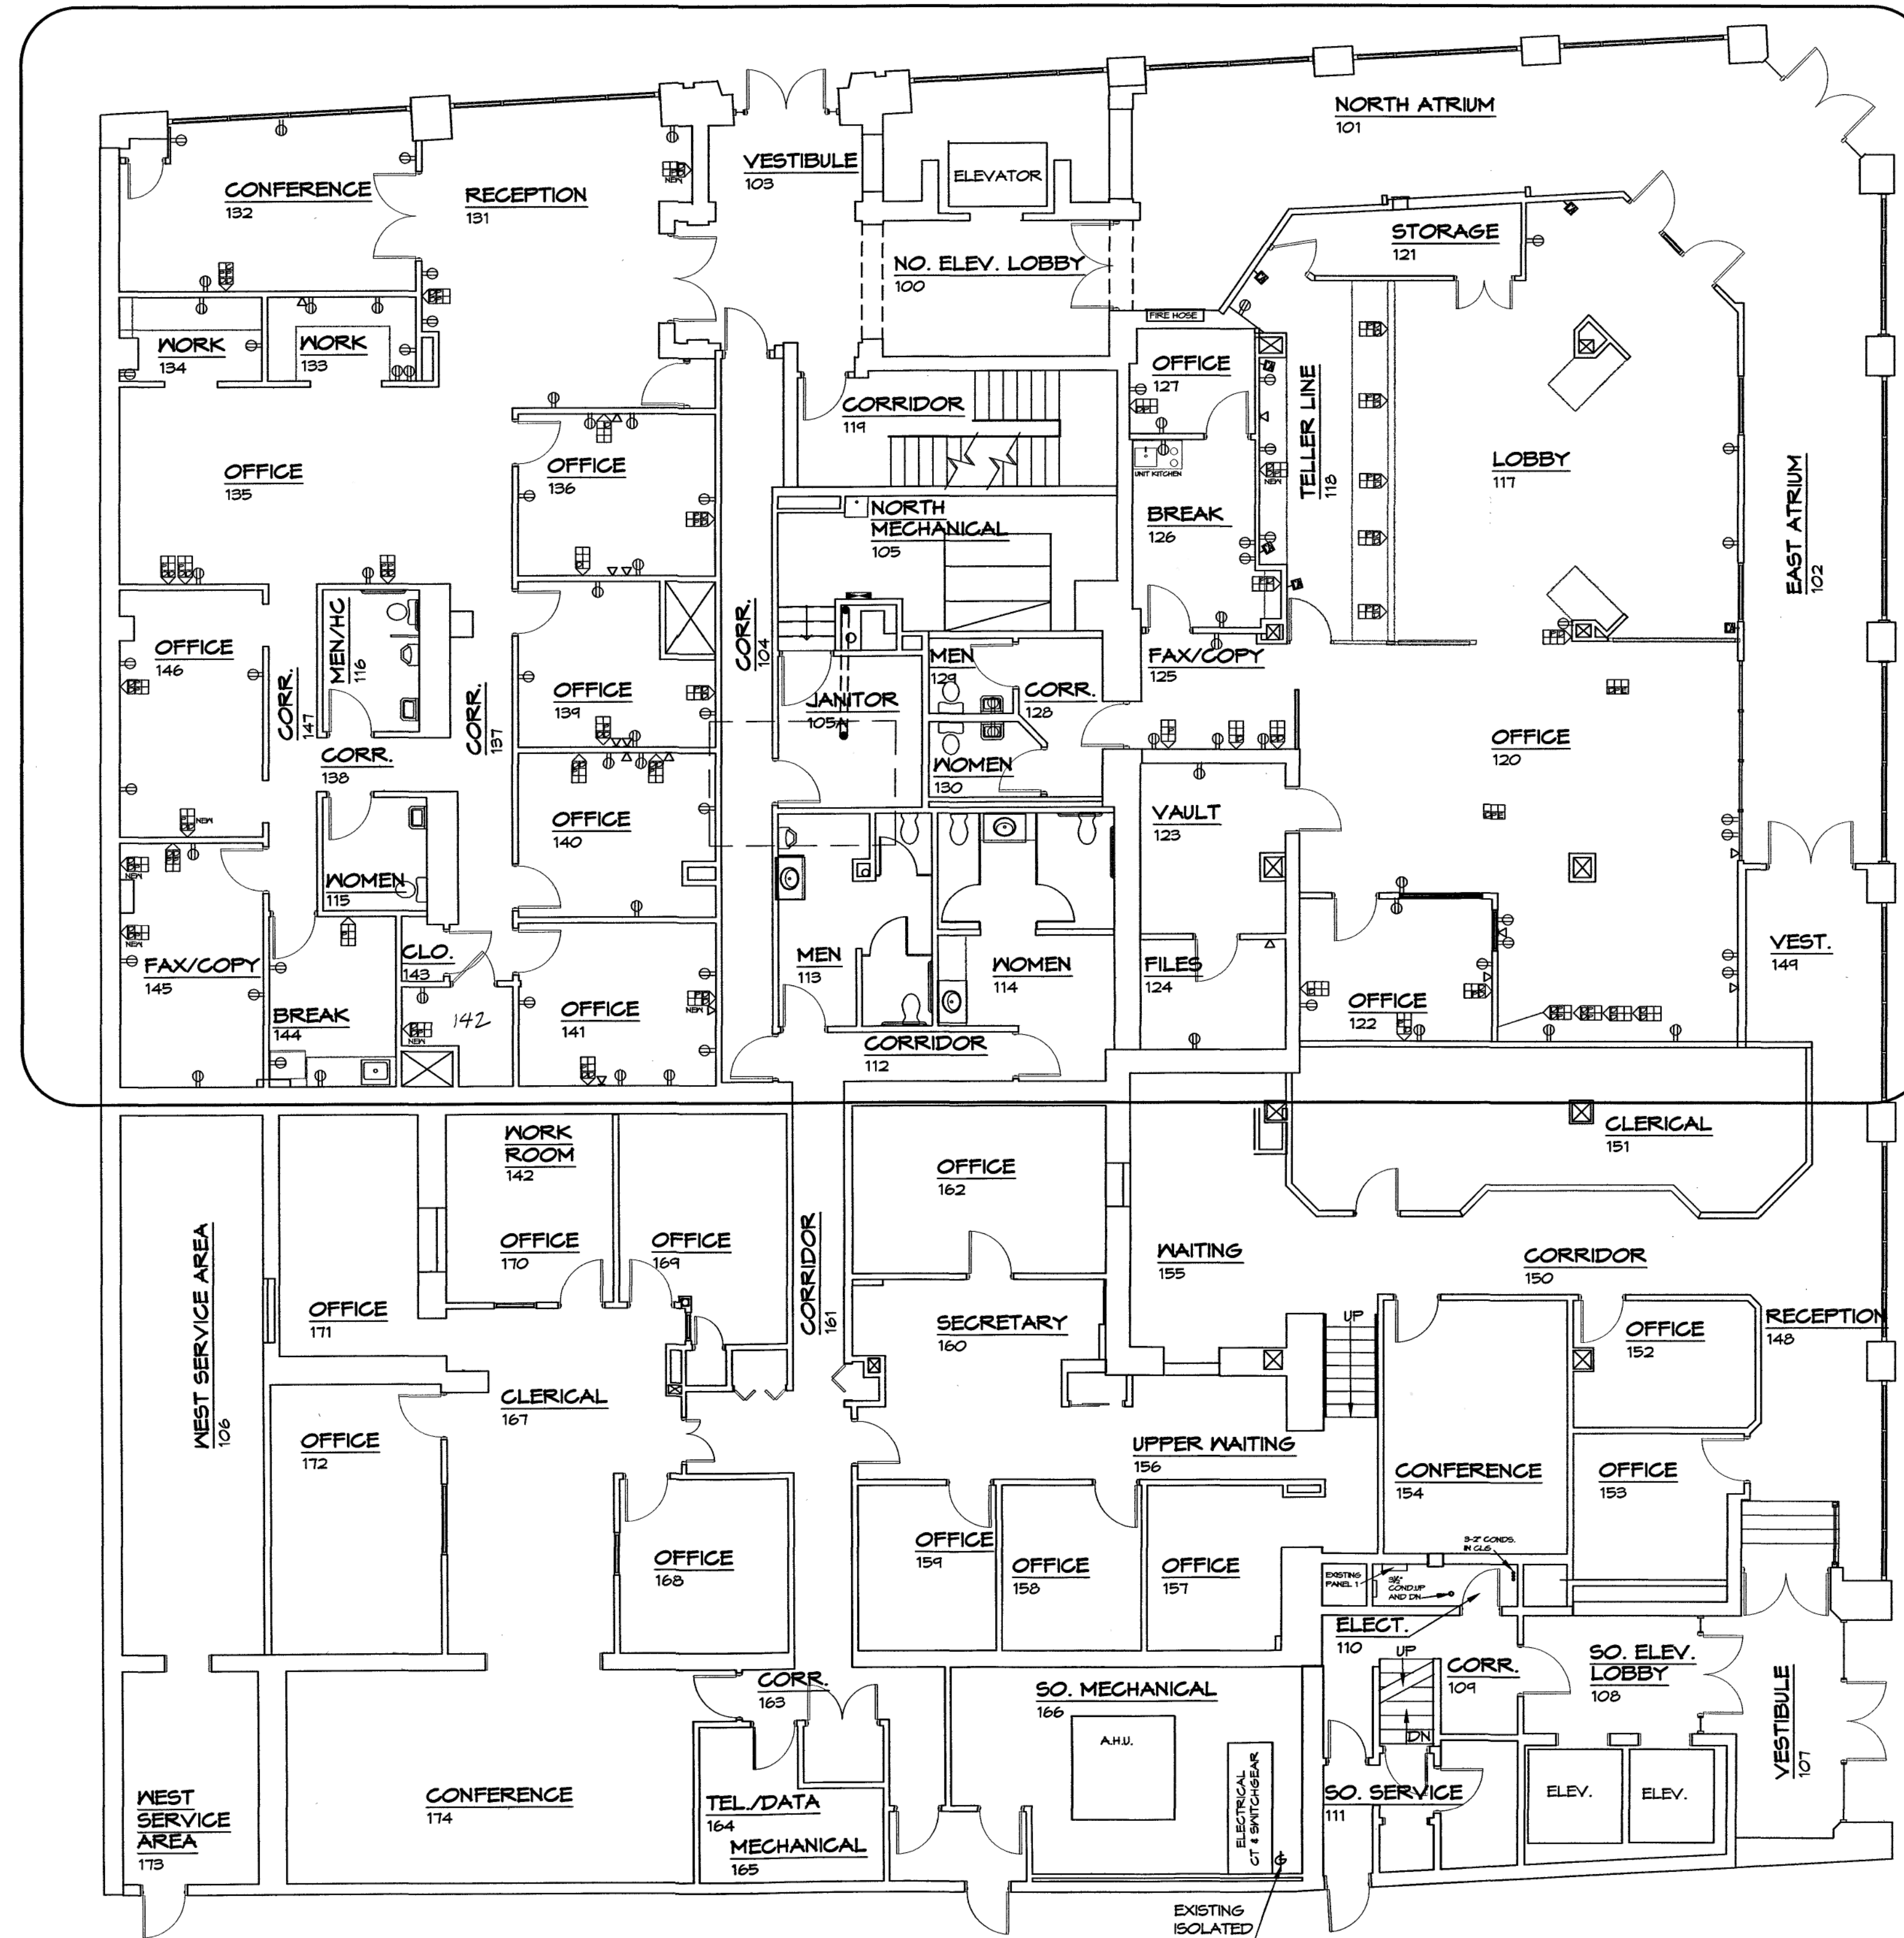

JEFFERSON STREET

FIRST FLOOR PLAN

SCALE: 1/8" = 1'-0"

WIRING LEGEND

- DATA TELEPHONE COAXIAL CABLE
- WALL DATA TELEPHONE ELECTRICAL REC.
- NEW RECEPTACLE ON NEW 40A CIRCUIT WITH ISOLATION GROUND
- NEW 2" - 2" CONDUITS
- EXISTING RECEPTACLE TO REMAIN
- EXISTING PHONE JACK
- EXISTING DATA PORT
- EXISTING TOKEN RING PORT