

BASEMENT FLOOR PLAN
SCALE: 1/8" = 1'-0"

DESIGN BY:
Star City Fire Protections Inc.




LEDGEND

- FACP Fire Alarm Control Panel
- F MANUAL PULL STATION
- TS SPRINKLER TAMPER SWITCH
- FS SPRINKLER WATERFLOW SWITCH
- AV HORN/STROBE
- V STROBE
- S SYSTEM SMOKE DETECTOR
- FAAN FIRE ALARM ANNUNCIATOR
- DD DUCT DETECTOR
- H HEAT DETECTOR
- SR SYSTEM SMOKE DETECTOR WITH RELAY
- FABP FIRE ALARM BOOSTER PANEL
- Z Monitor Module

REVISION	DATE	DESCRIPTION
DESIGNED BY:	COULTER BUILDING BASEMENT WESTERN VIRGINIA WATER AUTHORITY 801 S. JEFFERSON STREET ROANOKE VA. 24011	
DRAWN BY:		
CHECKED BY:		
SCALE:		
DATE:		
SHEET		FA-1

DESIGN BY:
Star City Fire Protections Inc.

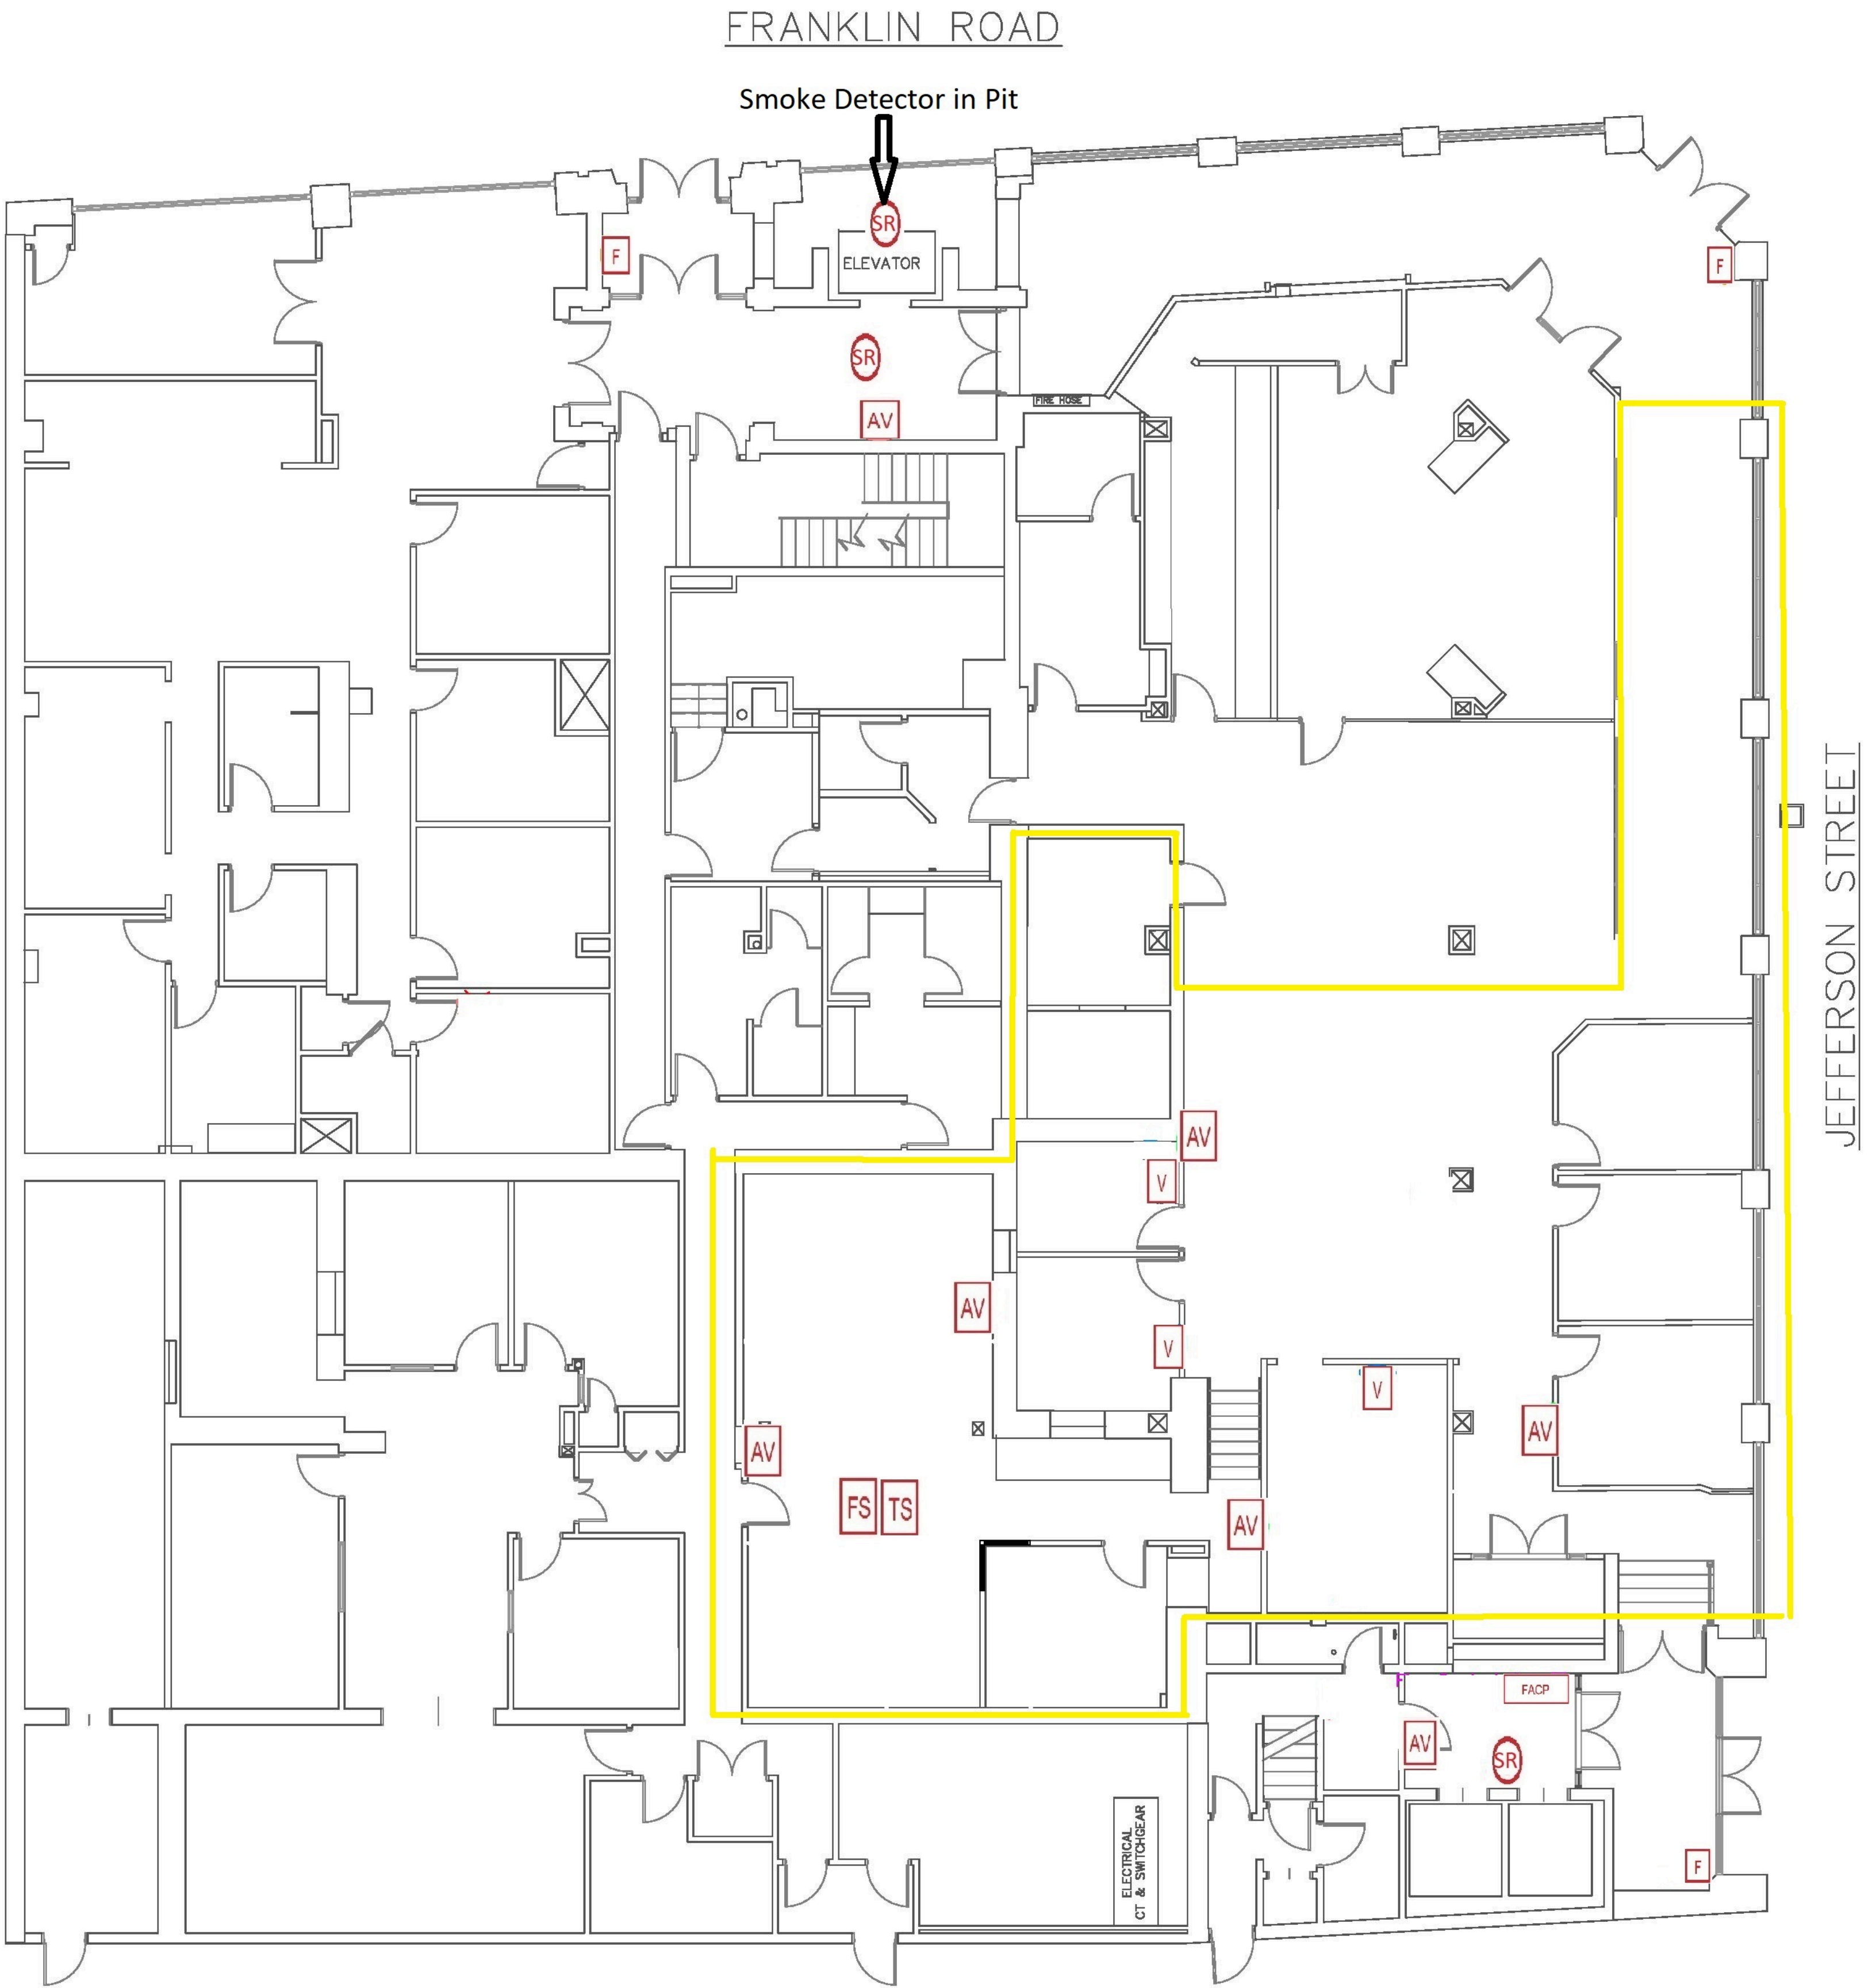

NOTE:
Renovated section in
yellow line.


LEDGEND

- FACP Fire Alarm Control Panel
- F MANUAL PULL STATION
- TS SPRINKLER TAMPER SWITCH
- FS SPRINKLER WATERFLOW SWITCH
- AV HORN/STROBE
- V STROBE
- S SYSTEM SMOKE DETECTOR
- FAAN FIRE ALARM ANNUNCIATOR
- DD DUCT DETECTOR
- H HEAT DETECTOR
- SR SYSTEM SMOKE DETECTOR WITH RELAY
- FABP FIRE ALARM BOOSTER PANEL
- Z Monitor Module

FIRST FLOOR PLAN
SCALE: 1/8" = 1'-0"

REVISION	DATE	DESCRIPTION
DESIGNED BY:	COULTER BUILDING BASEMENT WESTERN VIRGINIA WATER AUTHORITY 801 S. JEFFERSON STREET ROANOKE VA. 24011	
DRAWN BY:		
CHECKED BY:		
SCALE:		
DATE:		
SHEET		FA-2

FRANKLIN ROAD

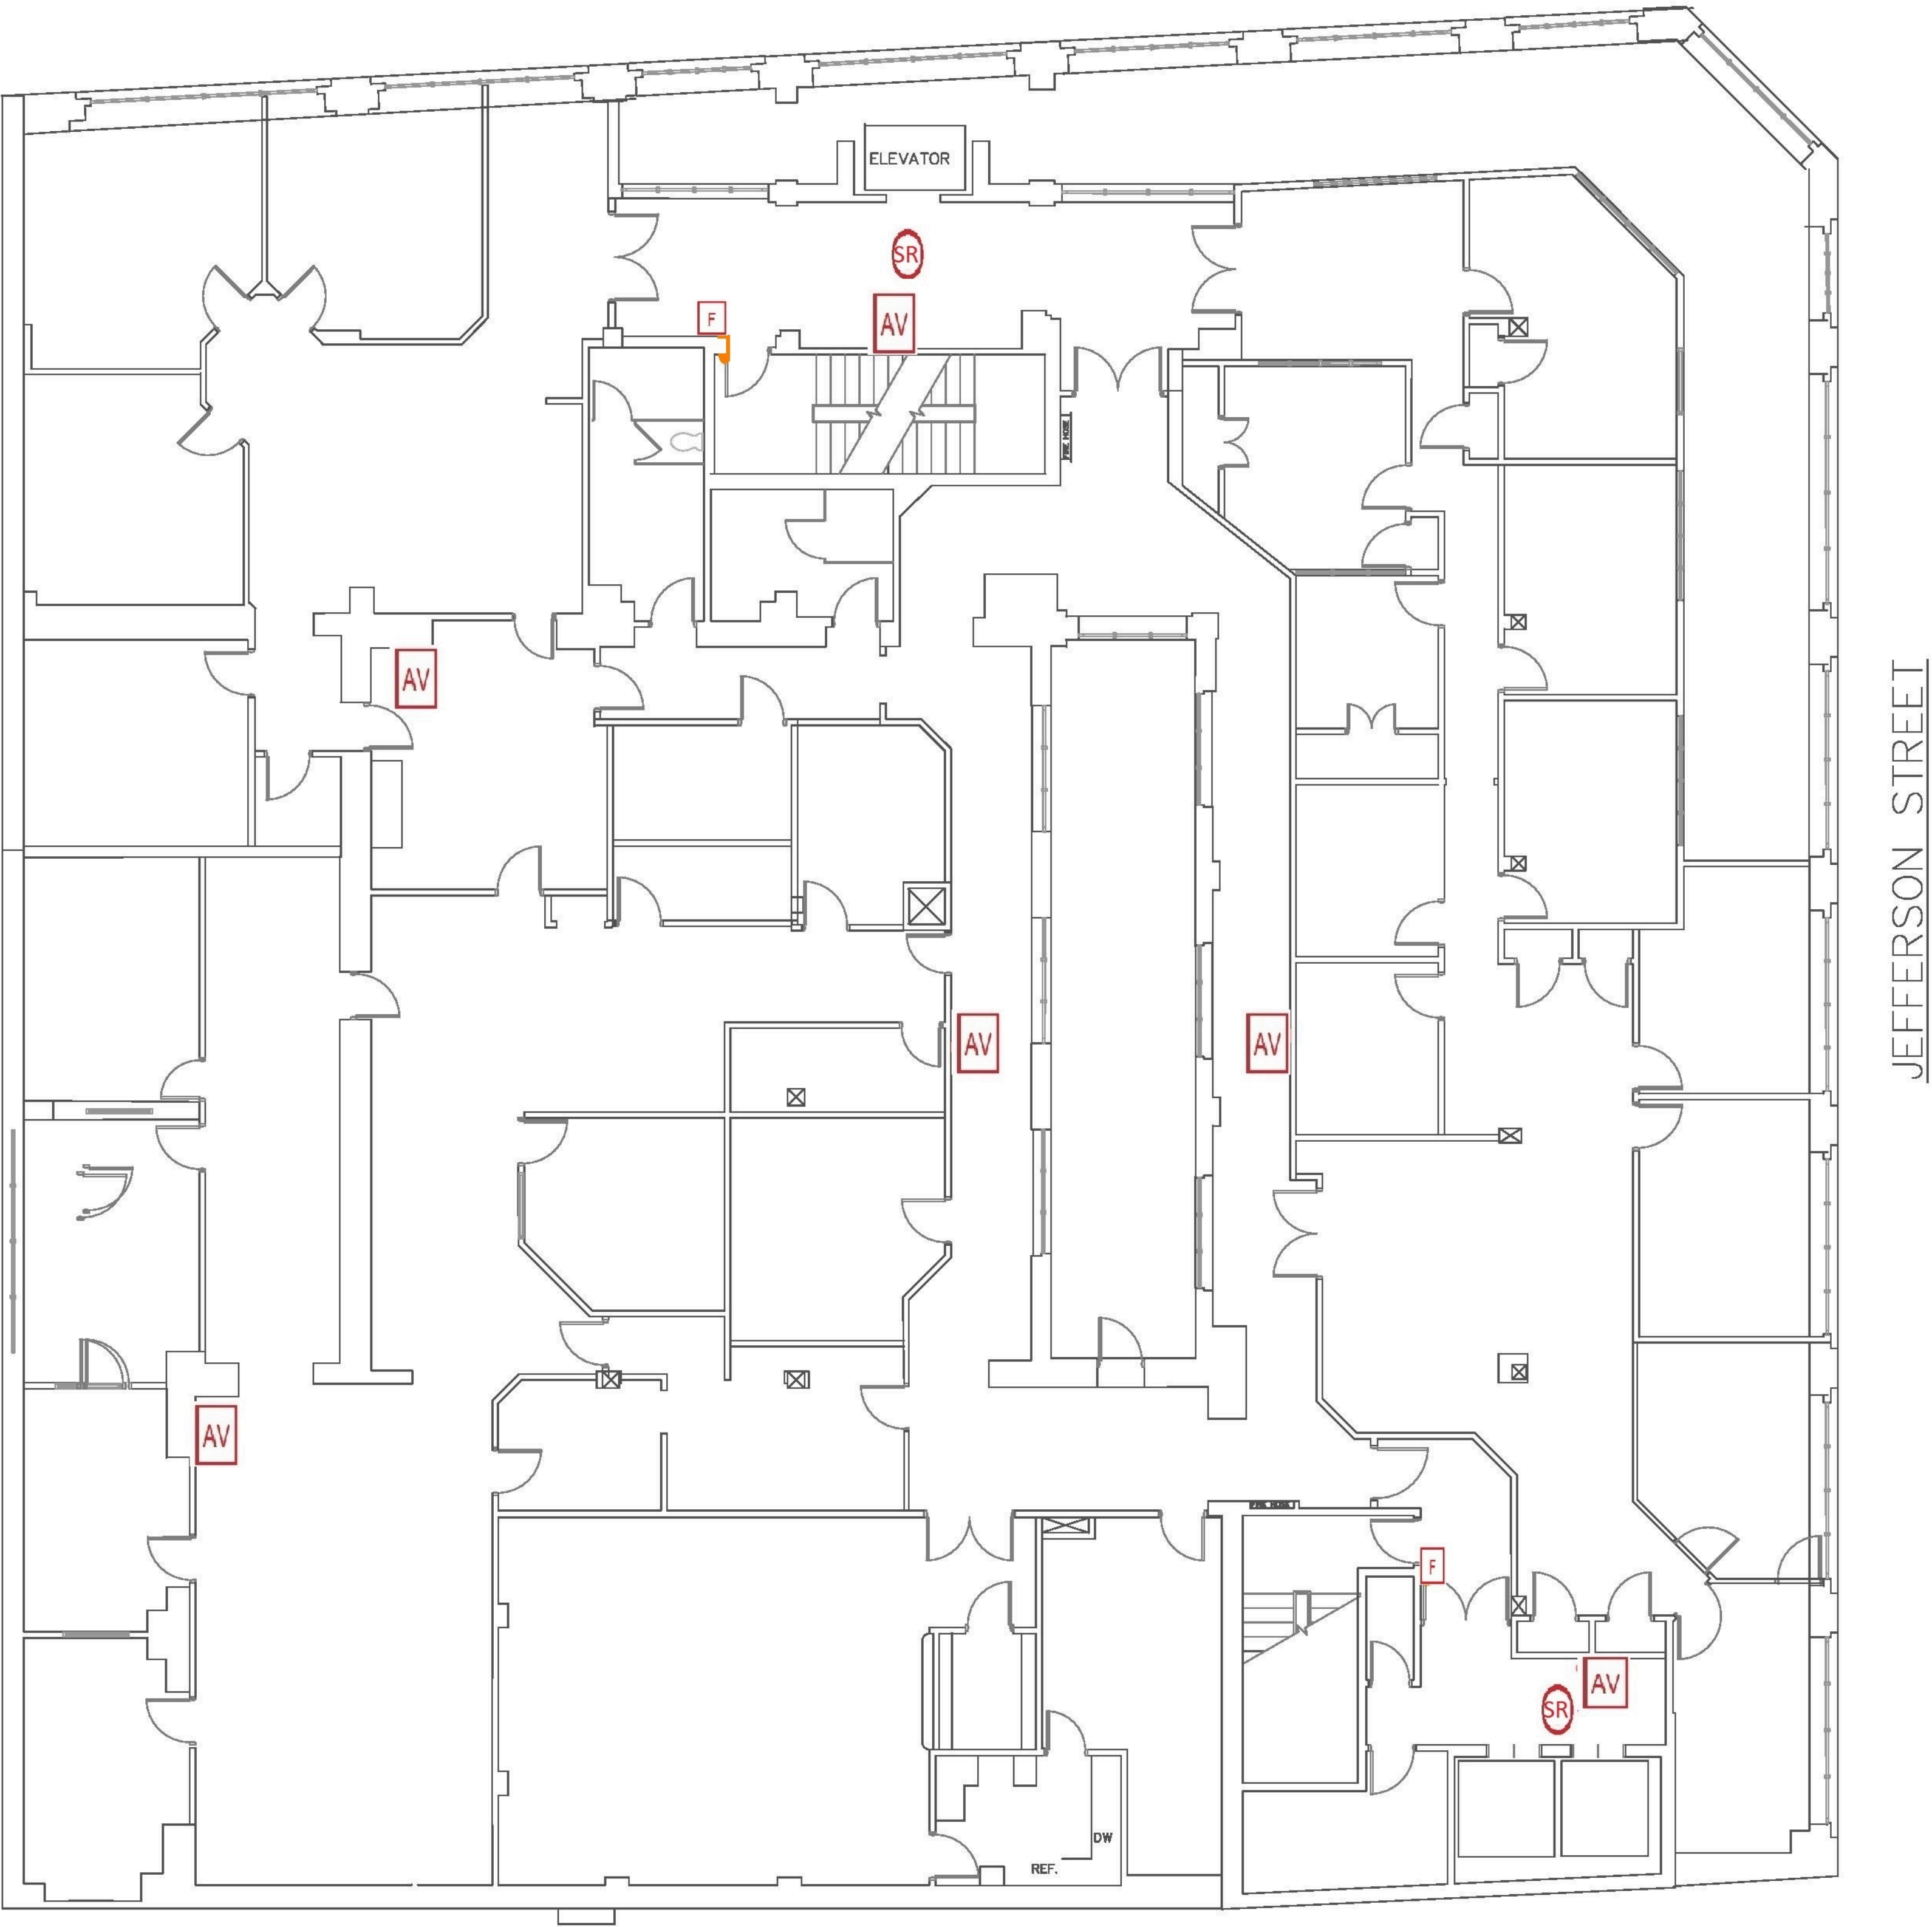

SECOND FLOOR PLAN
SCALE: 1/8" = 1'-0"


DESIGN BY:
Star City Fire Protections Inc.



LEDGEND

- FACP Fire Alarm Control Panel
- F MANUAL PULL STATION
- TS SPRINKLER TAMPER SWITCH
- FS SPRINKLER WATERFLOW SWITCH
- AV HORN/STROBE
- V STROBE
- S SYSTEM SMOKE DETECTOR
- FAAN FIRE ALARM ANNUNCIATOR
- DD DUCT DETECTOR
- H HEAT DETECTOR
- SR SYSTEM SMOKE DETECTOR WITH RELAY
- FABP FIRE ALARM BOOSTER PANEL
- Z Monitor Module

REVISION	DATE	DESCRIPTION
DESIGNED BY:	COULTER BUILDING BASEMENT WESTERN VIRGINIA WATER AUTHORITY 801 S. JEFFERSON STREET ROANOKE VA. 24011	
DRAWN BY:		
CHECKED BY:		
SCALE:		
DATE:		

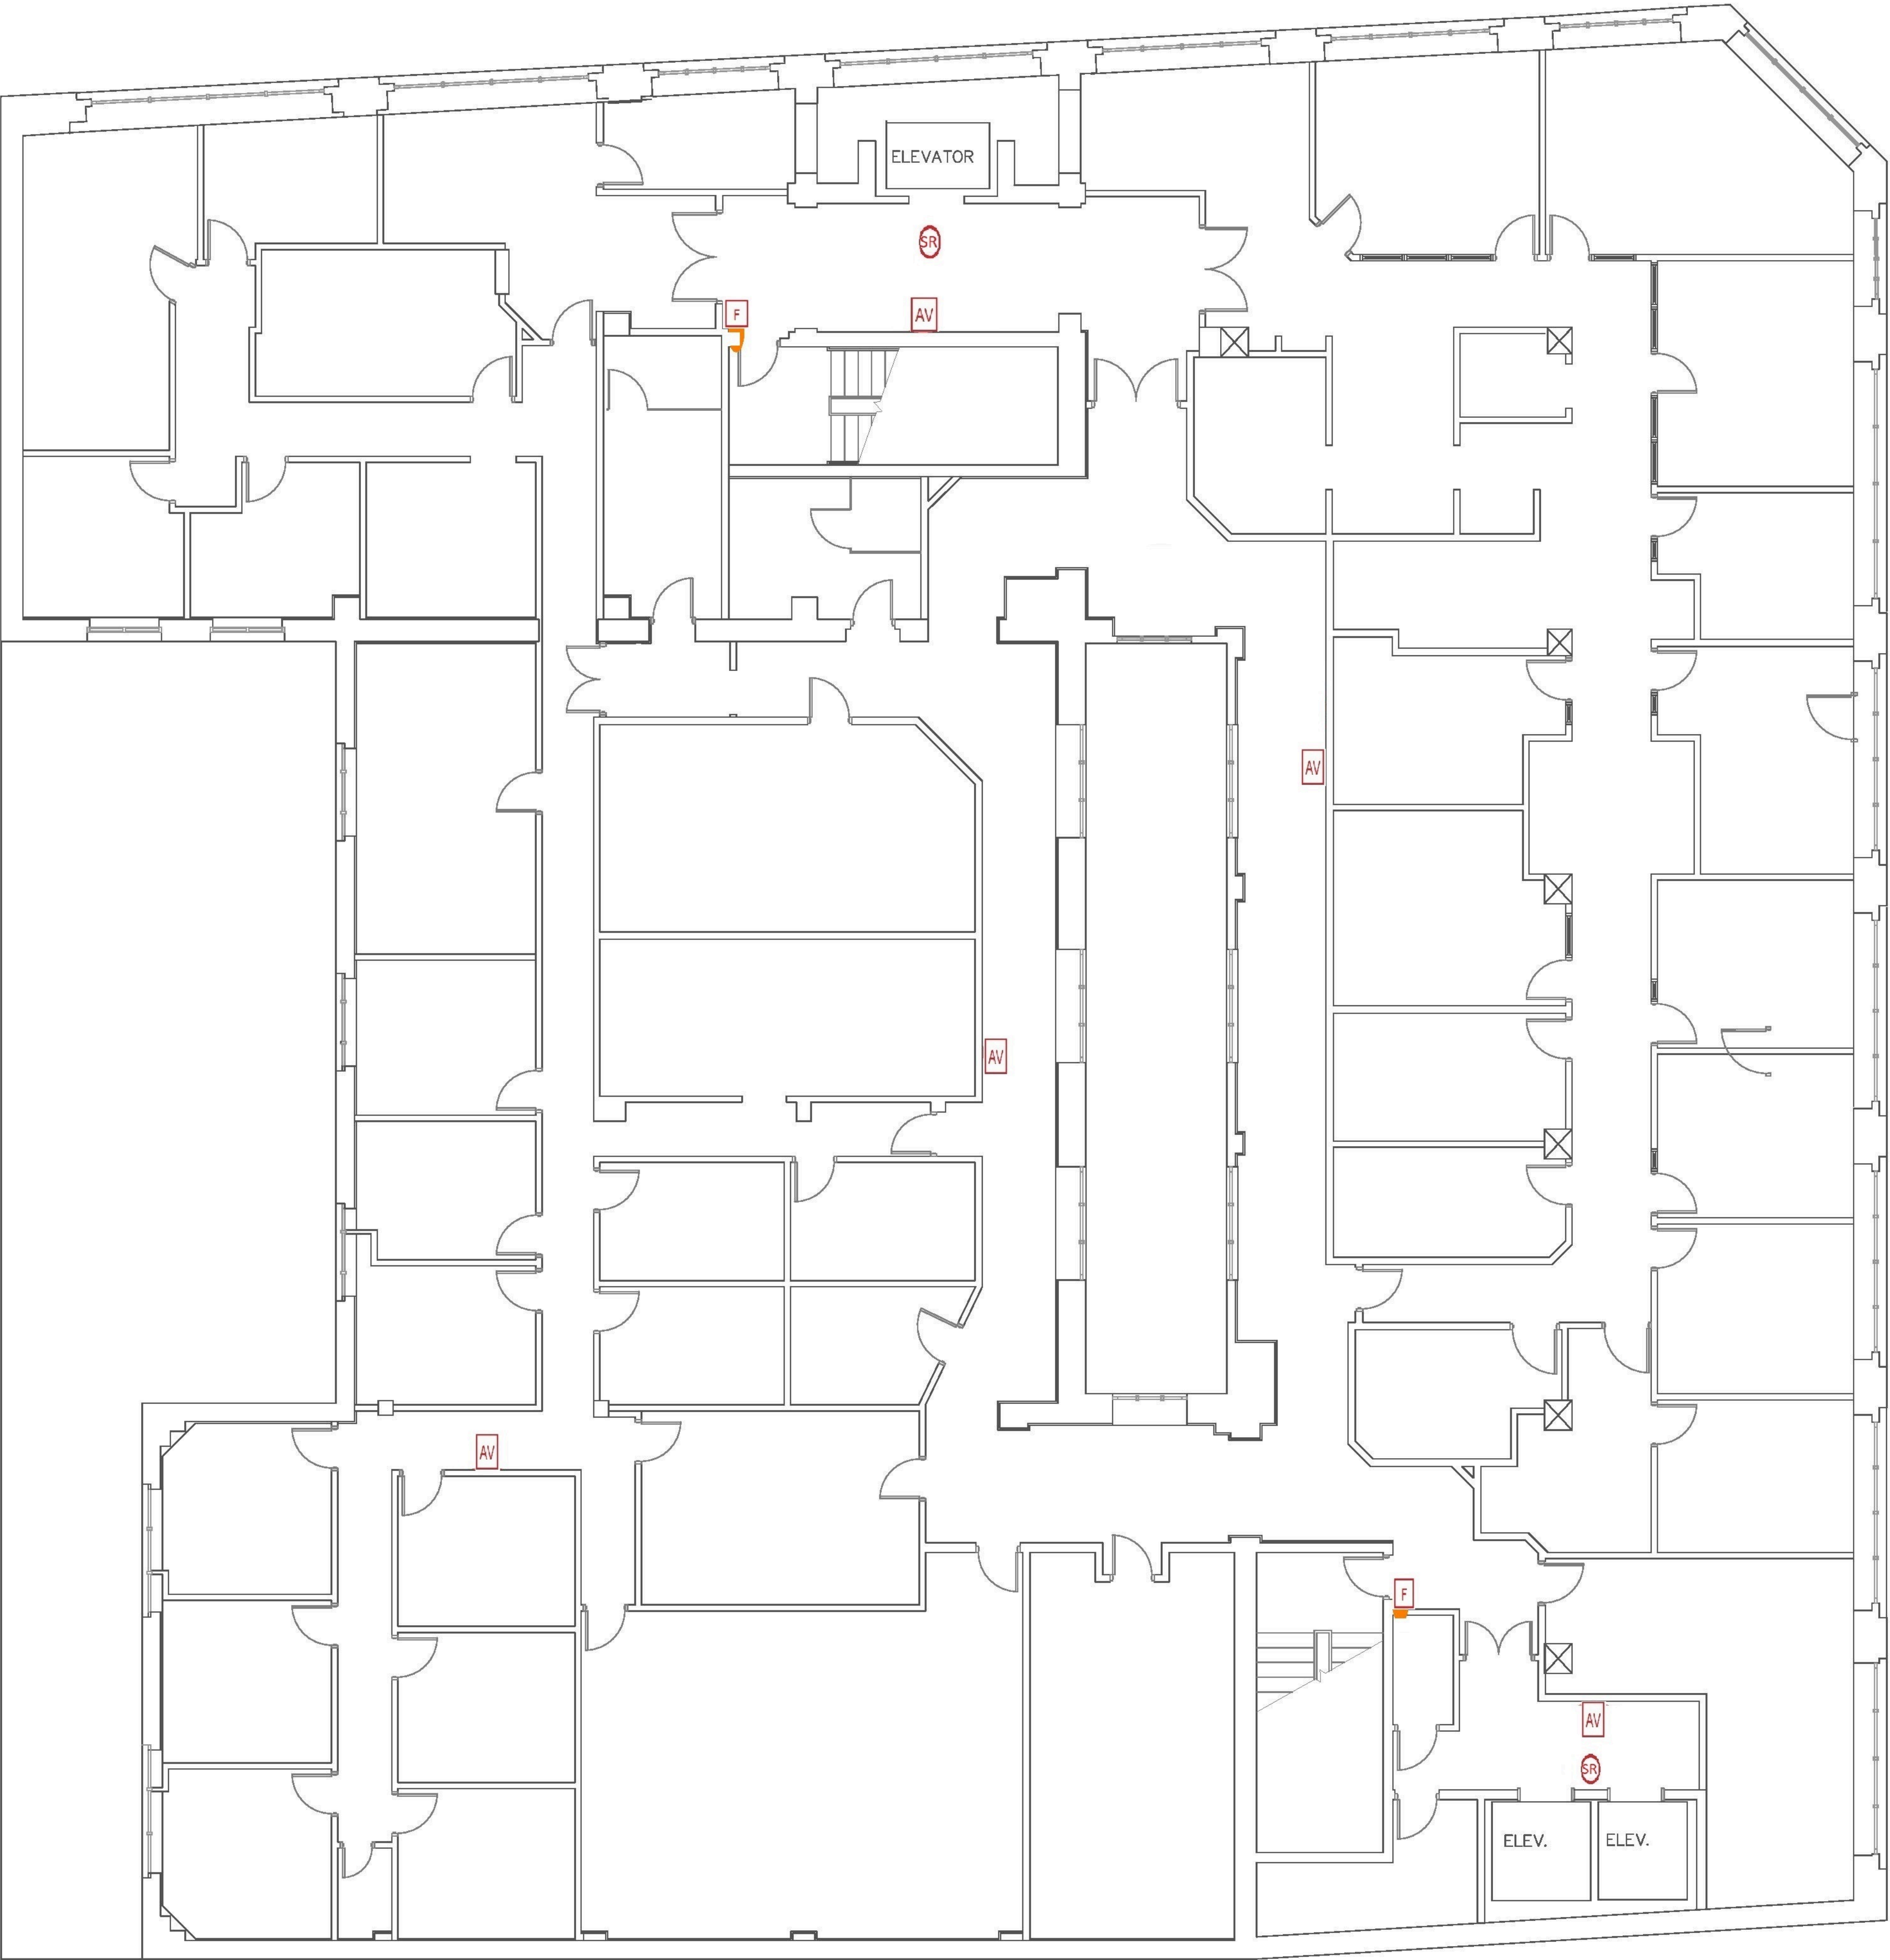

THIRD FLOOR PLAN

JEFFERSON STREET


DESIGN BY:
Star City Fire Protections Inc.



LEDGEND


- FACP Fire Alarm Control Panel
- F MANUAL PULL STATION
- TS SPRINKLER TAMPER SWITCH
- FS SPRINKLER WATERFLOW SWITCH
- AV HORN/STROBE
- V STROBE
- S SYSTEM SMOKE DETECTOR
- FAAN FIRE ALARM ANNUNCIATOR
- DD DUCT DETECTOR
- H HEAT DETECTOR
- SR SYSTEM SMOKE DETECTOR WITH RELAY
- FABP FIRE ALARM BOOSTER PANEL
- Z Monitor Module

REVISION	DATE	DESCRIPTION
DESIGNED BY:	<div>COULTER BUILDING BASEMENT</div> <div>WESTERN VIRGINIA WATER AUTHORITY 801 S. JEFFERSON STREET ROANOKE VA. 24011</div>	
DRAWN BY:		
CHECKED BY:		
SCALE:		
DATE:		

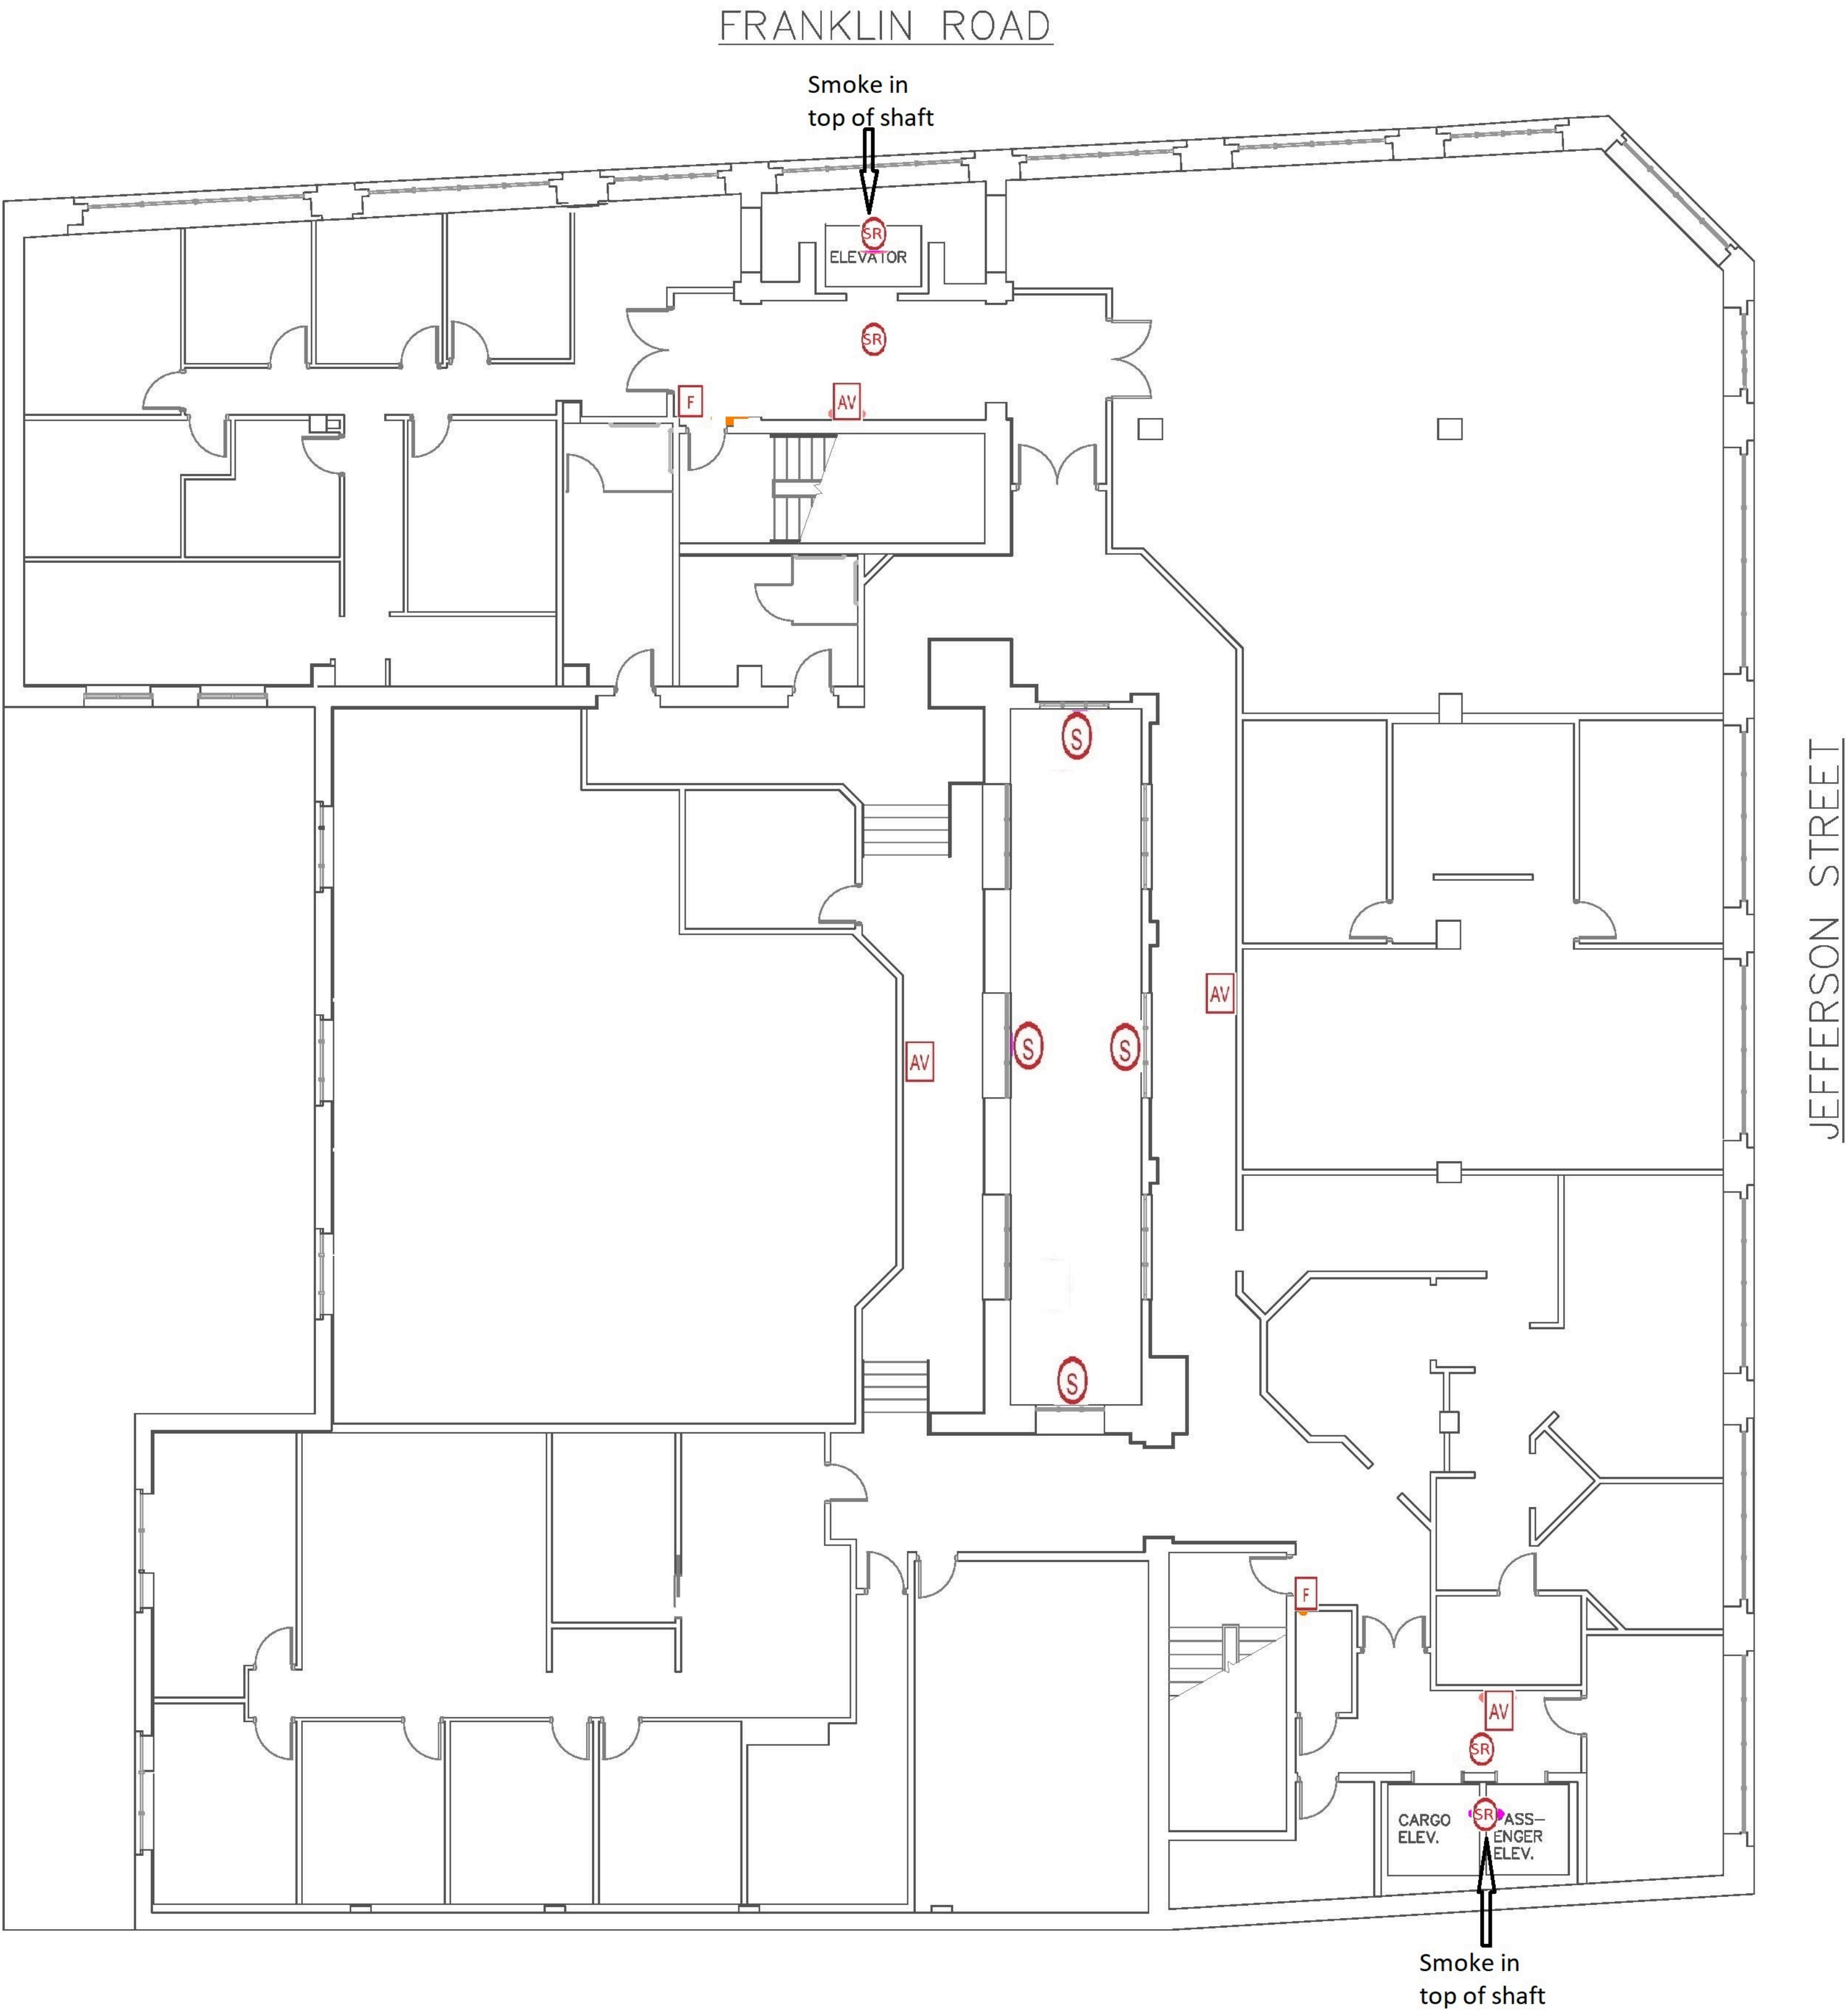

FOURTH FLOOR PLAN
SCALE: 1/8" = 1'-0"

DESIGN BY:
Star City Fire Protections Inc.

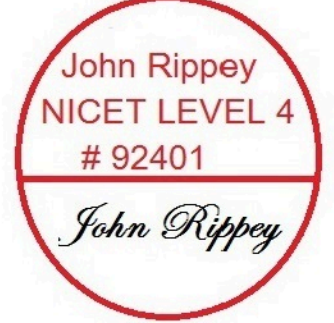

LEDGEND

- FACP Fire Alarm Control Panel
- F MANUAL PULL STATION
- TS SPRINKLER TAMPER SWITCH
- FS SPRINKLER WATERFLOW SWITCH
- AV HORN/STROBE
- V STROBE
- S SYSTEM SMOKE DETECTOR
- FAAN FIRE ALARM ANNUNCIATOR
- DD DUCT DETECTOR
- H HEAT DETECTOR
- SR SYSTEM SMOKE DETECTOR WITH RELAY
- FABP FIRE ALARM BOOSTER PANEL
- Z Monitor Module

REVISION	DATE	DESCRIPTION
DESIGNED BY:	<div>COULTER BUILDING BASEMENT</div> <div>WESTERN VIRGINIA WATER AUTHORITY 801 S. JEFFERSON STREET ROANOKE VA. 24011</div>	
DRAWN BY:		
CHECKED BY:		
SCALE:		
DATE:		